


AS-BUILT DRAWING NOTE:
AS-BUILT DRAWING FOR SANITARY SEWER AND WATERLINE IMPROVEMENTS ARE FOR AS-BUILT PURPOSES ONLY. NO IMPROVEMENTS OTHER THAN WATER AND SANITARY SEWER STRUCTURES WERE AS-BUILT OR INDICATED AS SUCH ON THE SUBJECT PLAN SET. UNDERGROUND PIPING WAS NOT LOCATED. LOCATION SHOWN IS APPROXIMATE BASED ON SURFACE FEATURES AND INFORMATION PROVIDED BY CONTRACTOR.

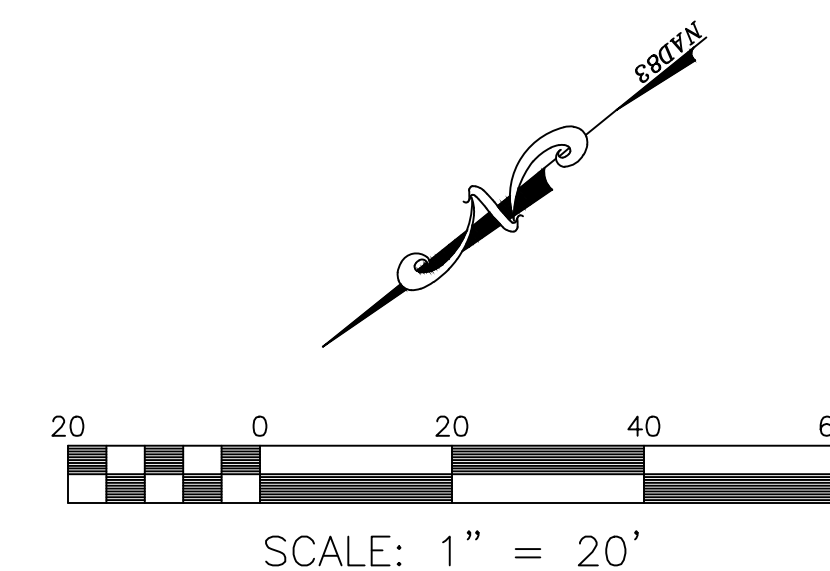


BALZER
& ASSOCIATES
PLANNERS / ARCHITECTS
ENGINEERS / SURVEYORS

Roanoke / Richmond
New River Valley / Staunton
Harrisonburg / Lynchburg

www.balzer.cc

1208 Corporate Circle
Roanoke, VA 24018
540.772.9580

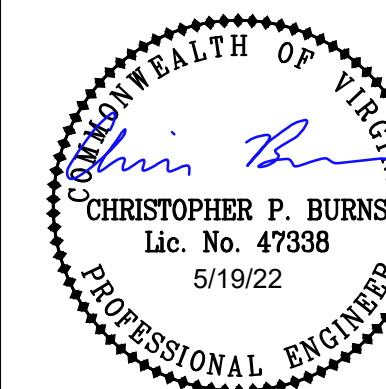

CARILION ROANOKE MEMORIAL HOSPITAL

CARILION KUANUKE MEMORIAL HOSPITAL
CRYSTAL SPRING TOWER ADDITIONS & RENOVATIONS - ENABLING PROJECT #1B

UTILITY PLAN (WWA AS-BUILT)

1906 BELLEVIEW AVENUE, SE
CITY OF ROANOKE, VIRGINIA

DRAWN BY	EJP
DESIGNED BY	SMH
CHECKED BY	CPB
DATE	5/19/2022
SCALE	1"=20'
REVISIONS	

C4T
PROJECT NO. 04190036.00