



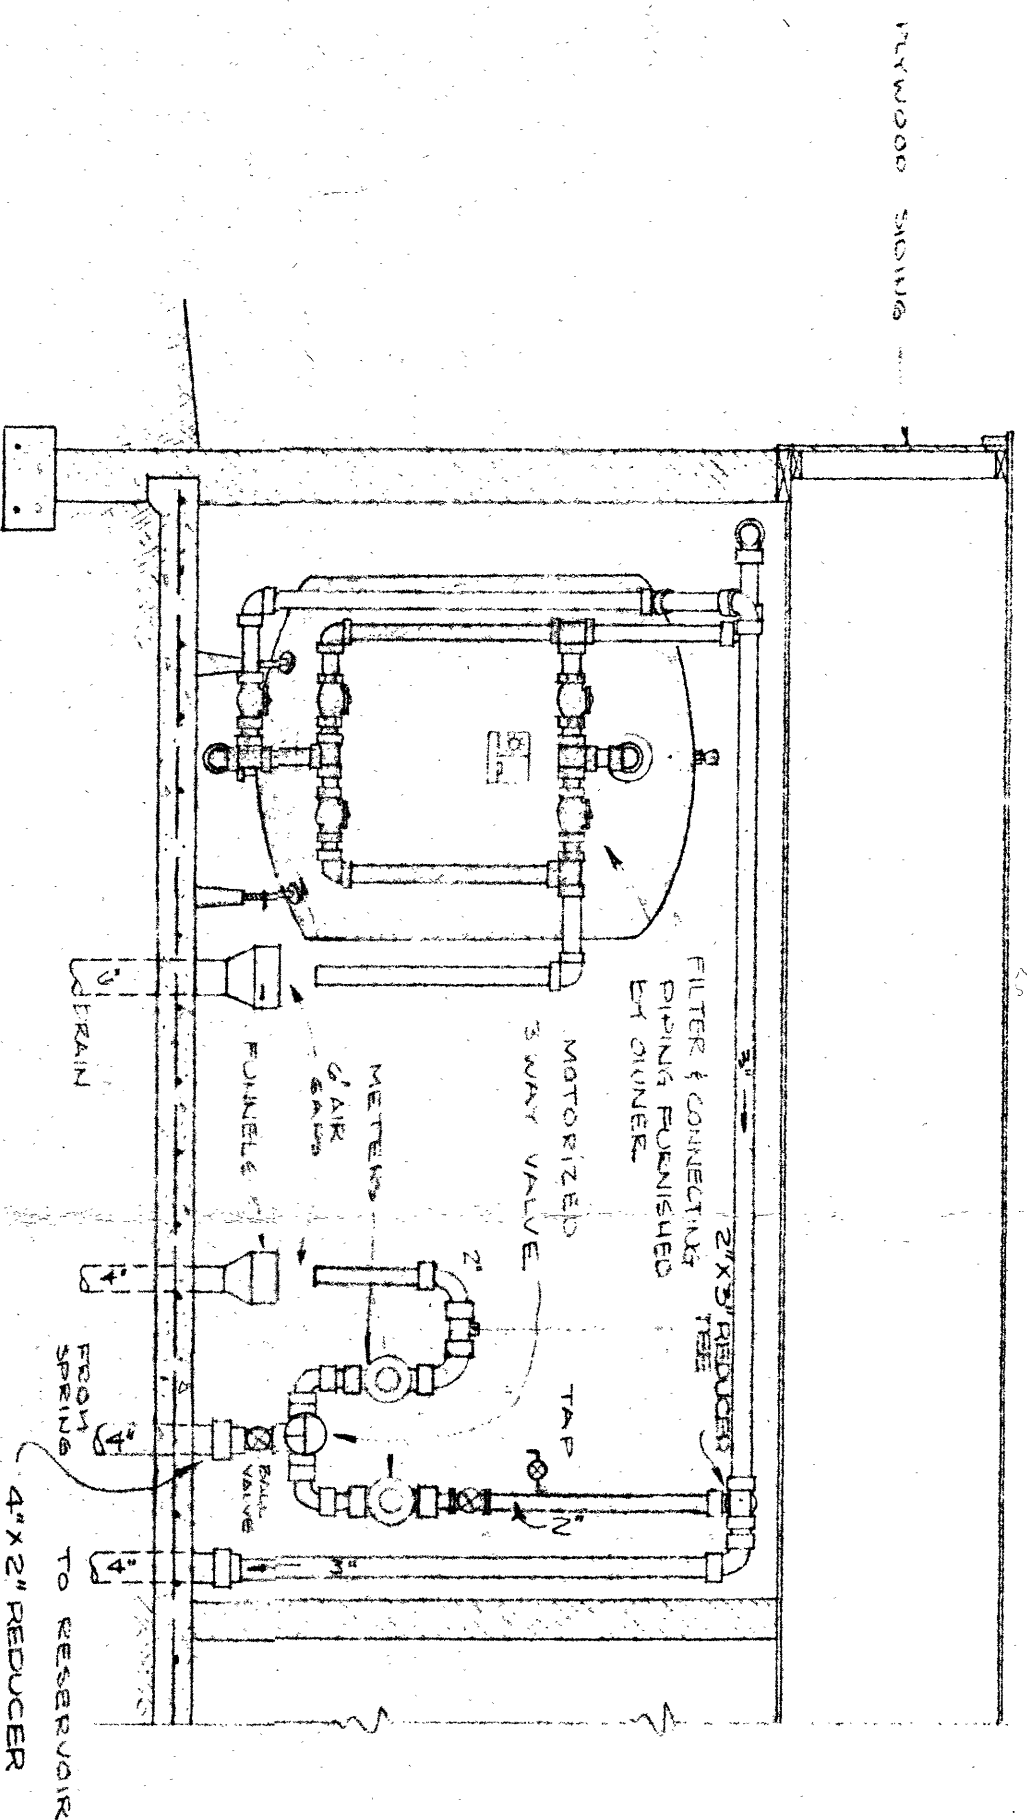


SECTION 'B-B'

3/8" = 1'-0"

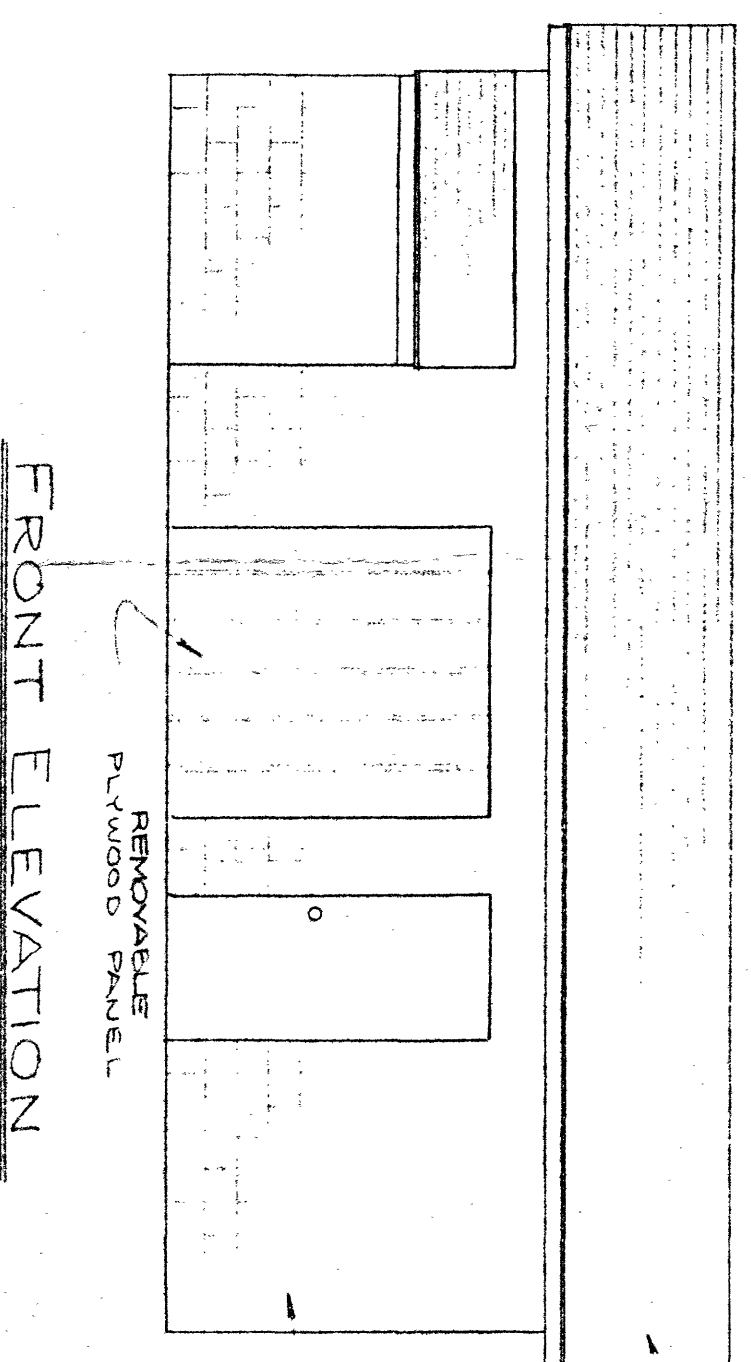


FRONT ELEVATION

1/4" = 1'-0"

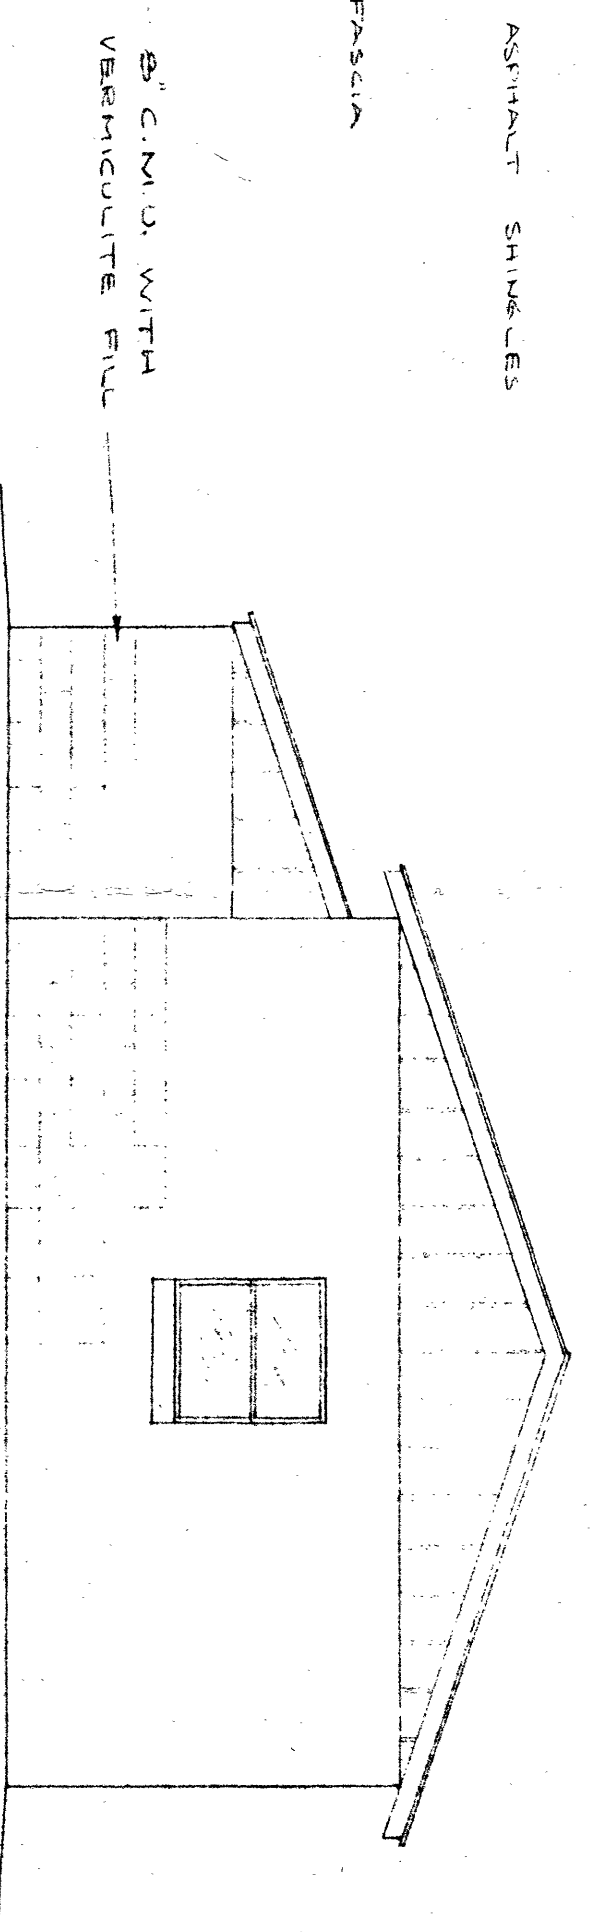


END ELEVATION

1/4" = 1'-0"

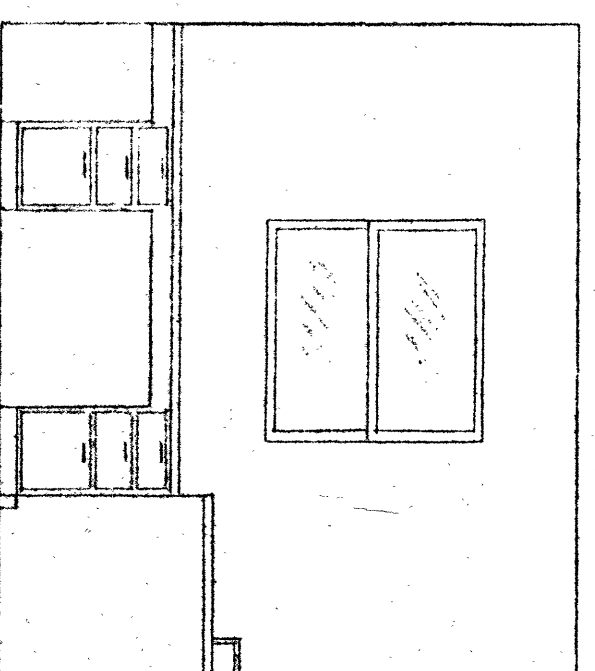


VIEW

3/8" = 1'-0"

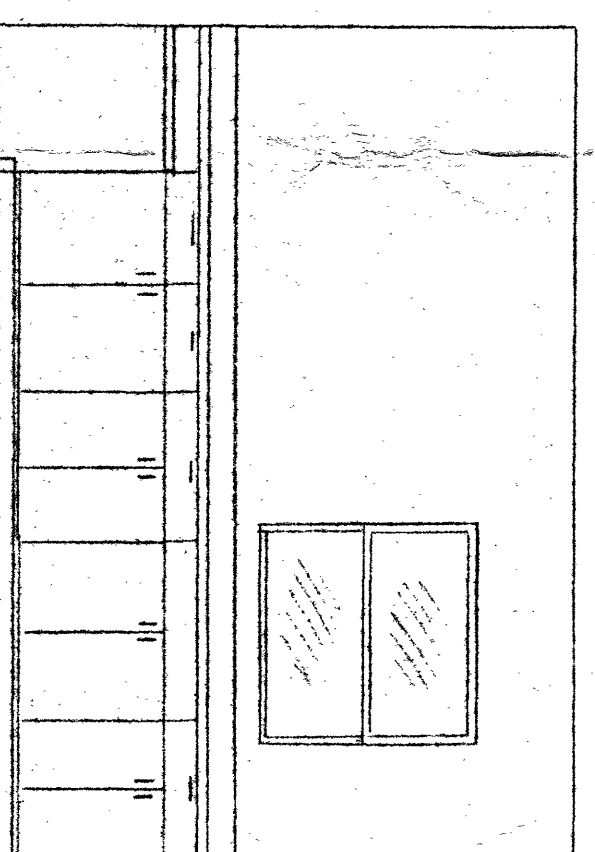


VIEW

3/8" = 1'-0"

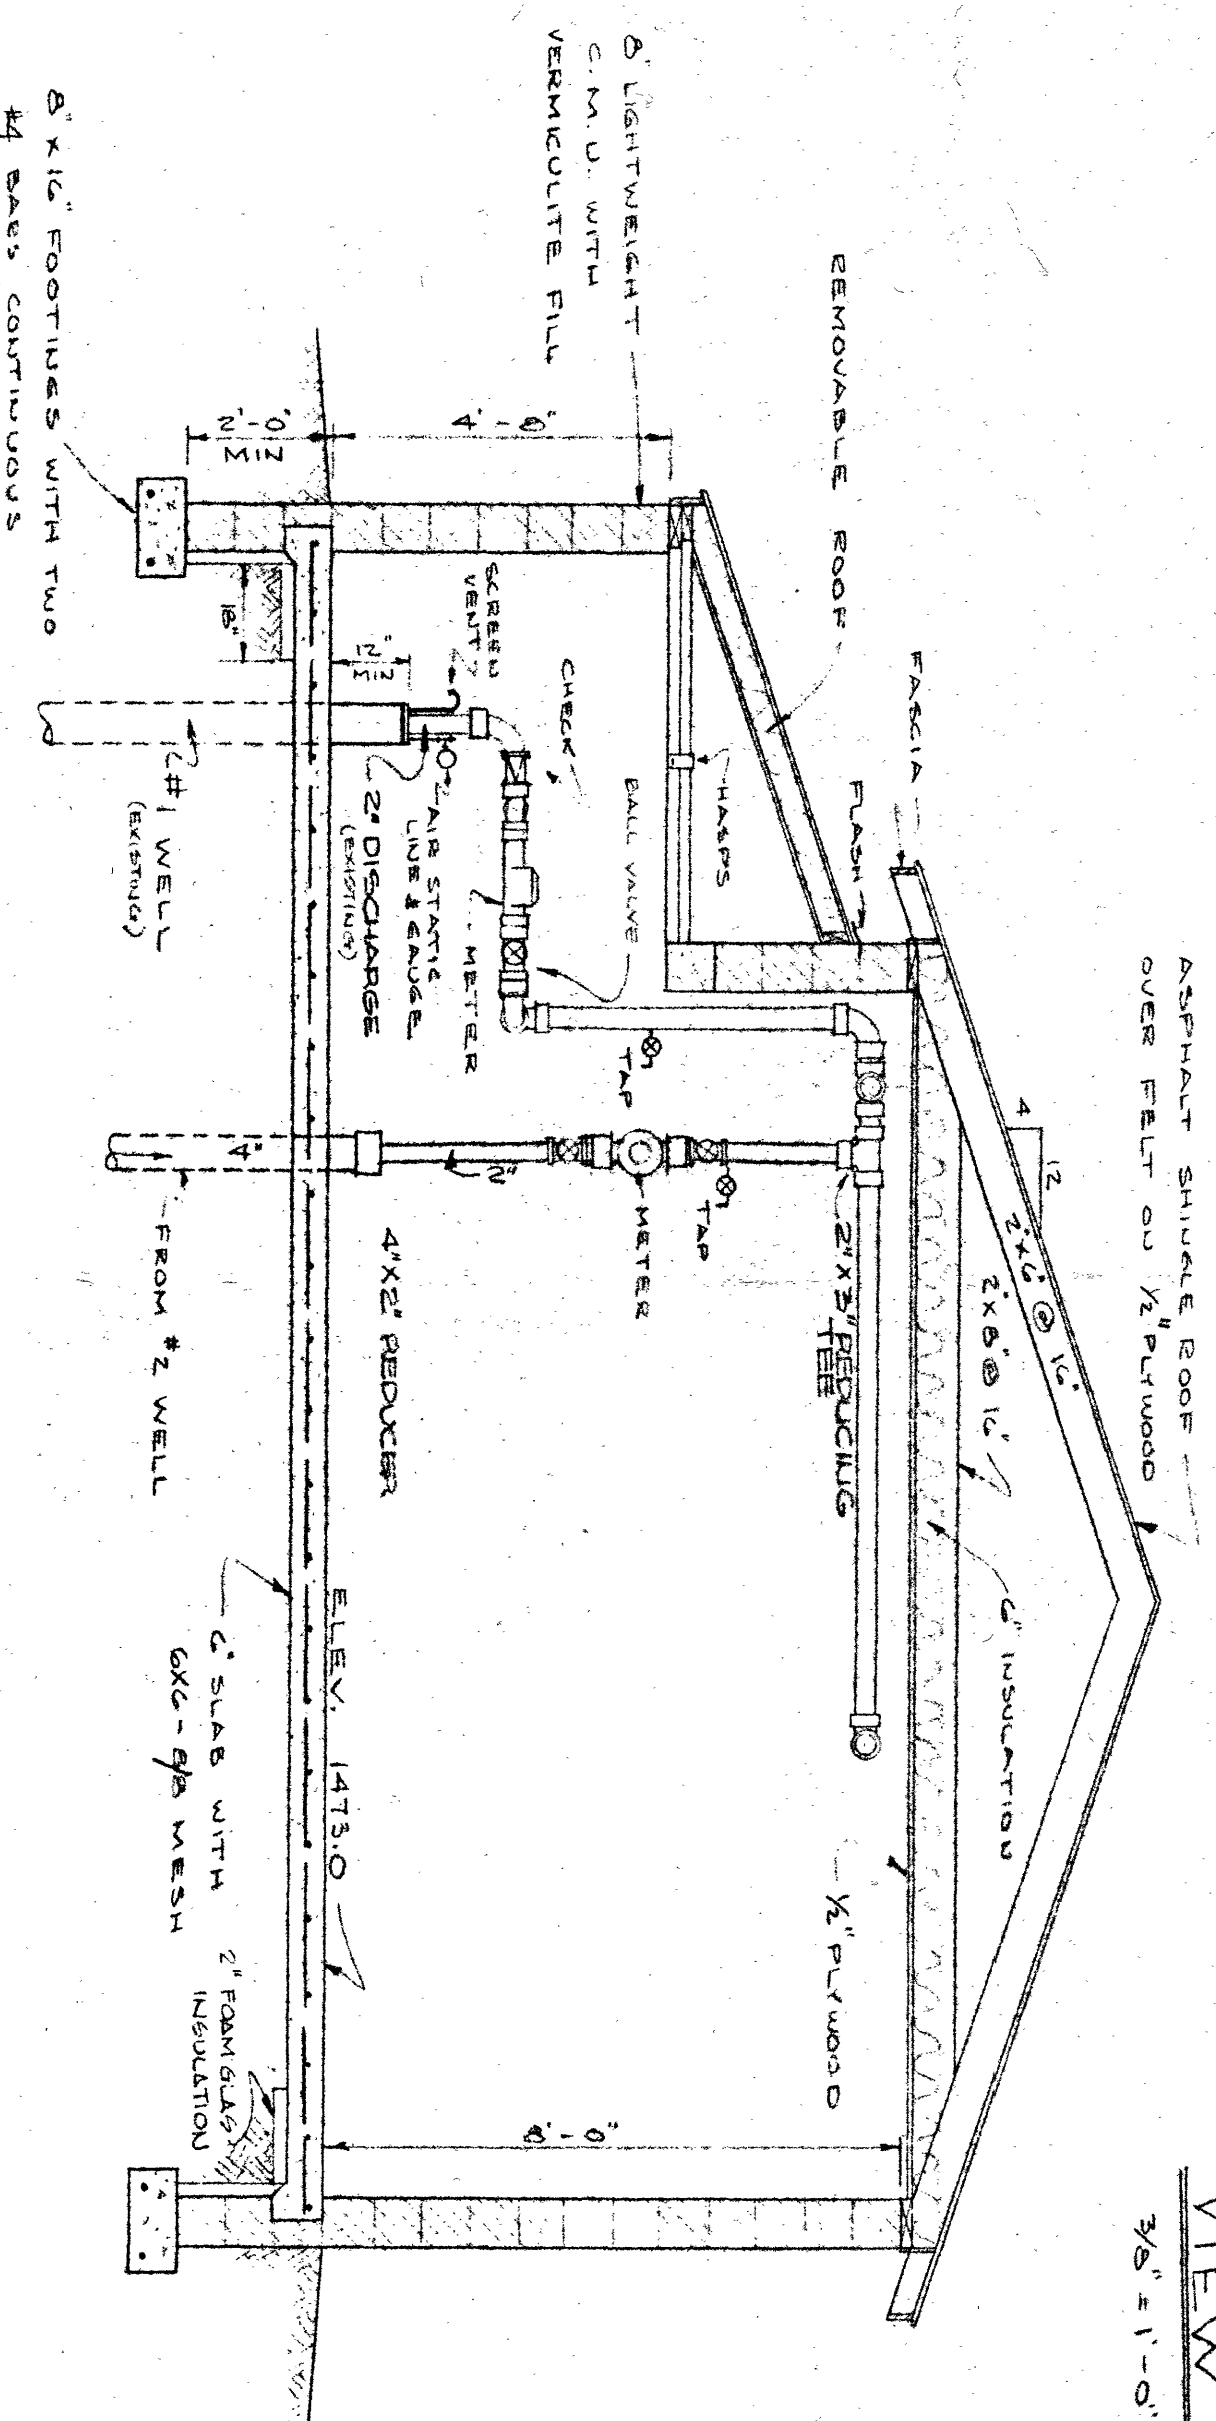

SECTION 'A-A'

3/8" = 1'-0"

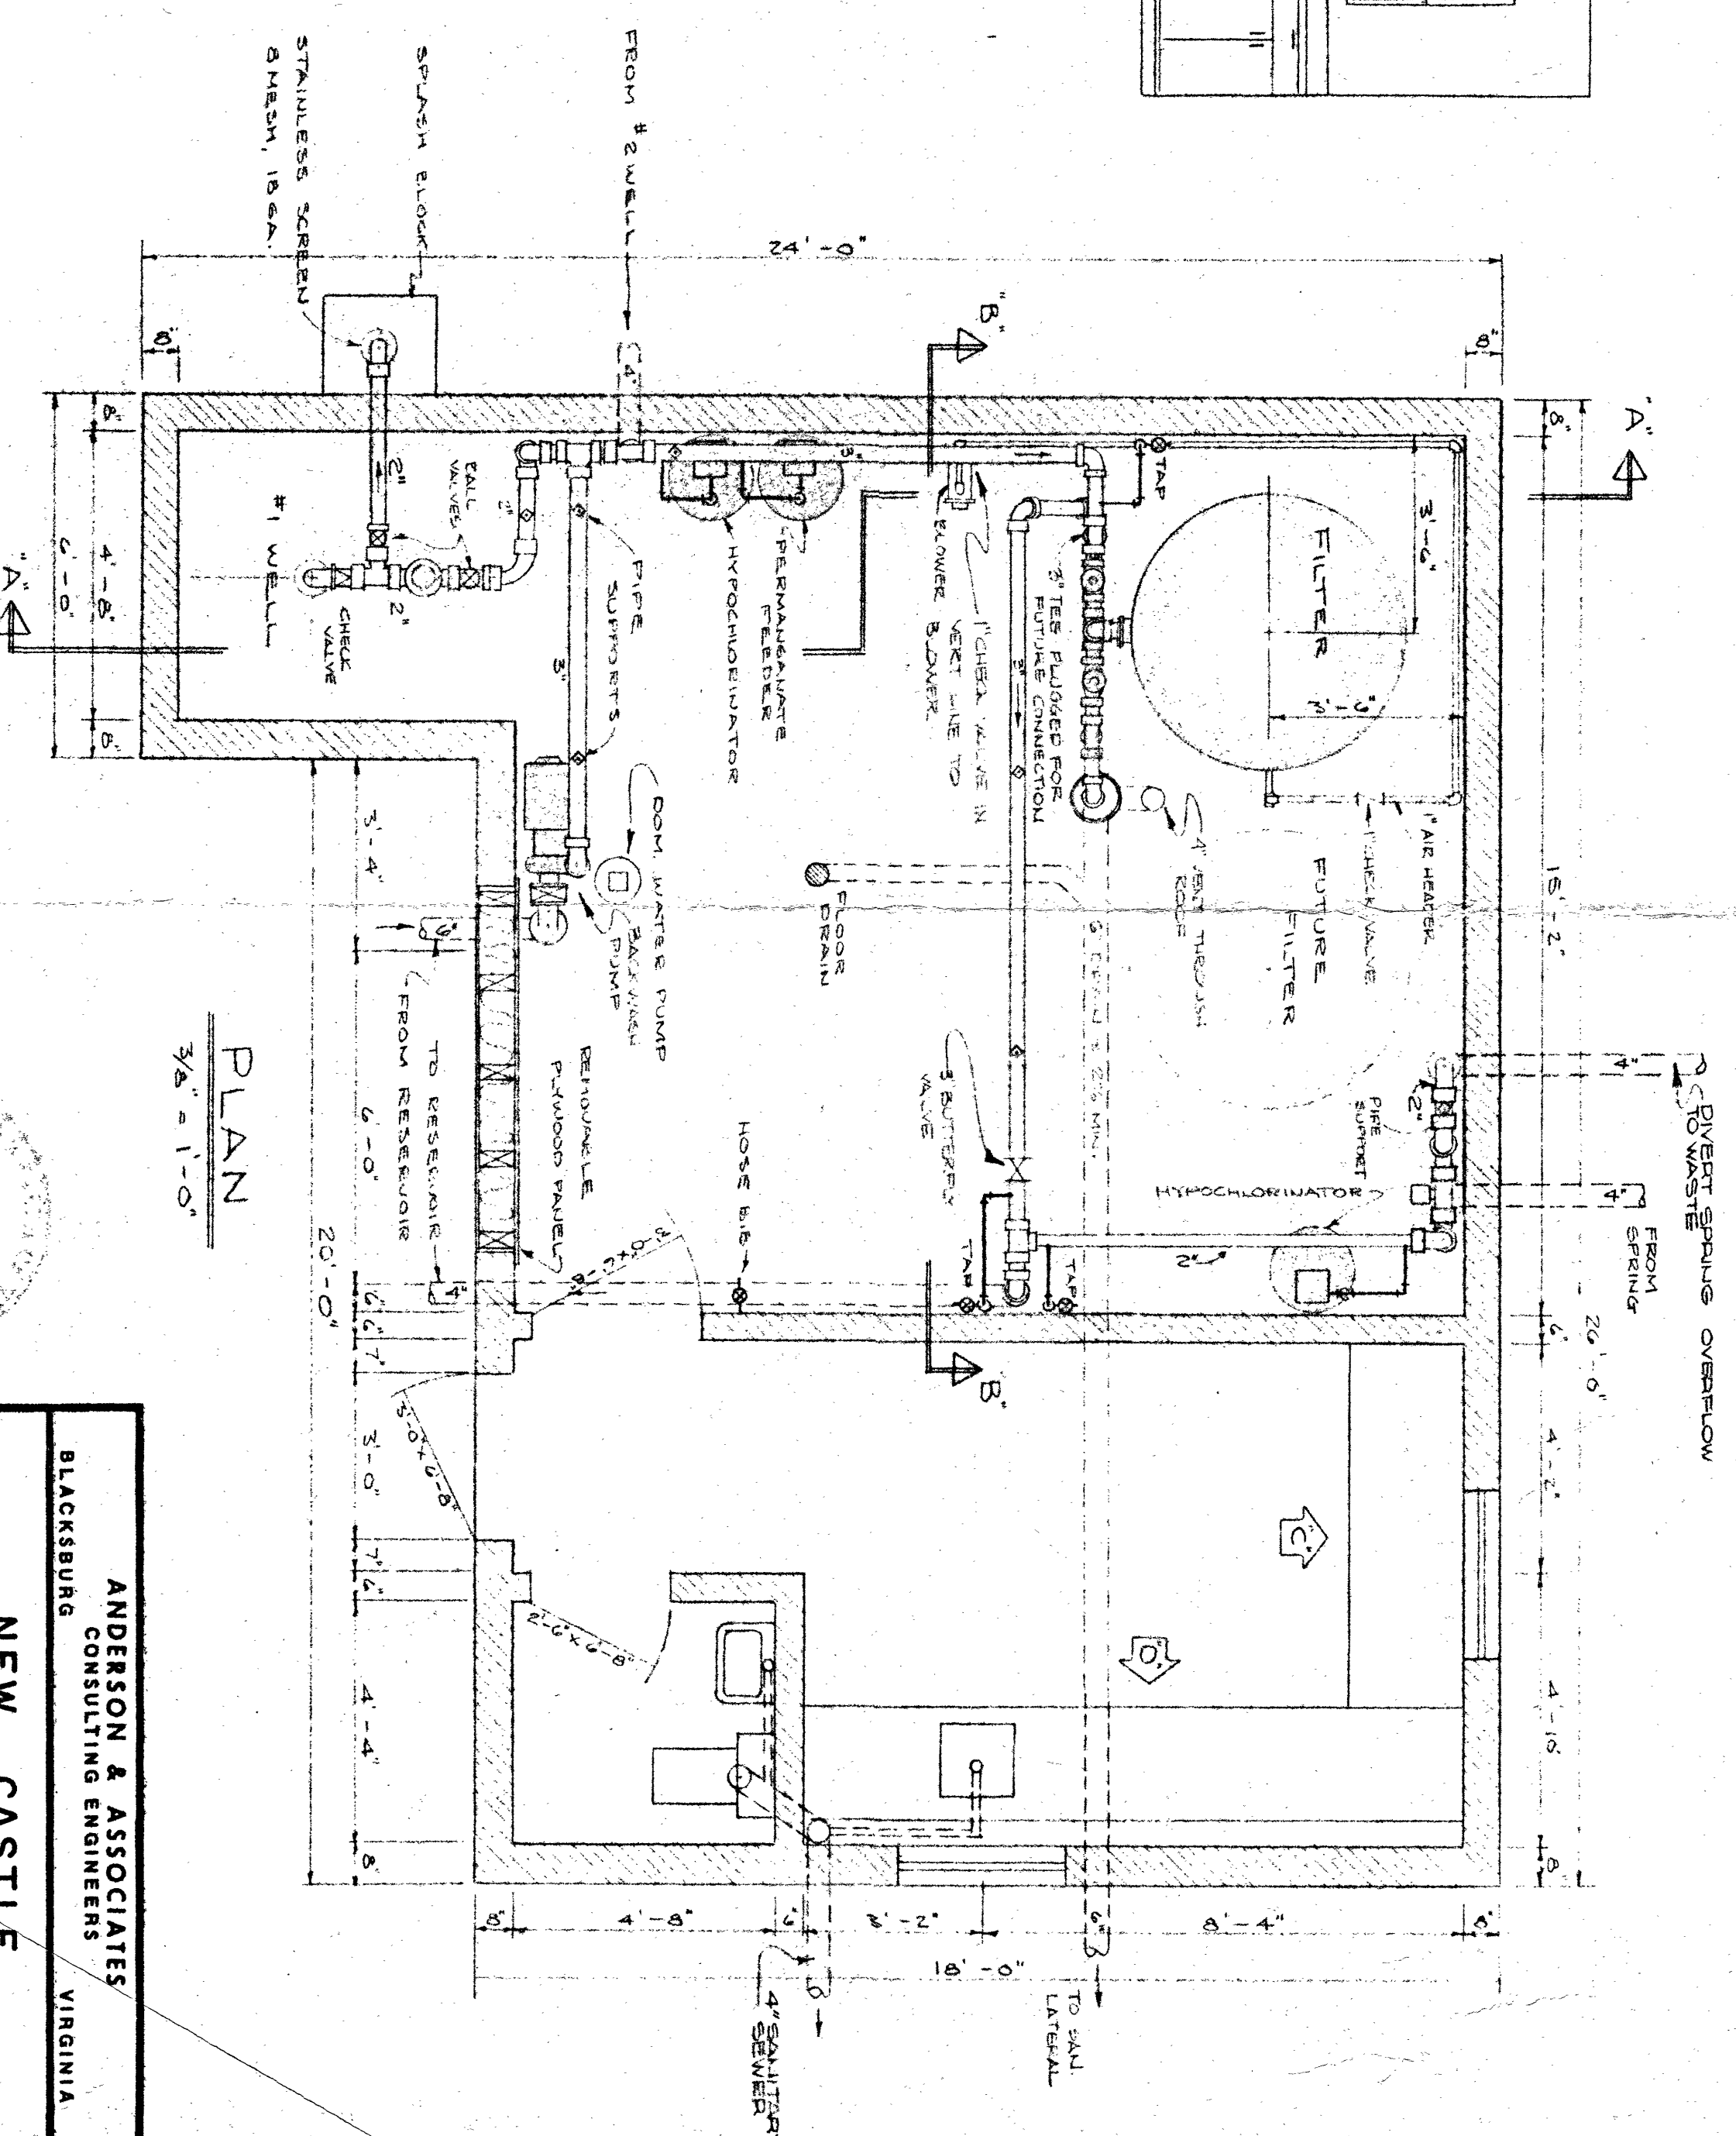

PLAN

3/8" = 1'-0"

ANDERSON & ASSOCIATES
BLACKSBURG
CONSULTING ENGINEERS VIRGINIA

NEW CASTLE
WATER SYSTEM IMPROVEMENTS

TREATMENT BUILDING

DATE: 21 MARCH 1980
SCALE: AS SHOWN
DESIGNER: CTR
DRAWN: CTR
CHECKED: GSB

REVISIONS
SHEET
5 OF 8

JN/147