




PROJECT I

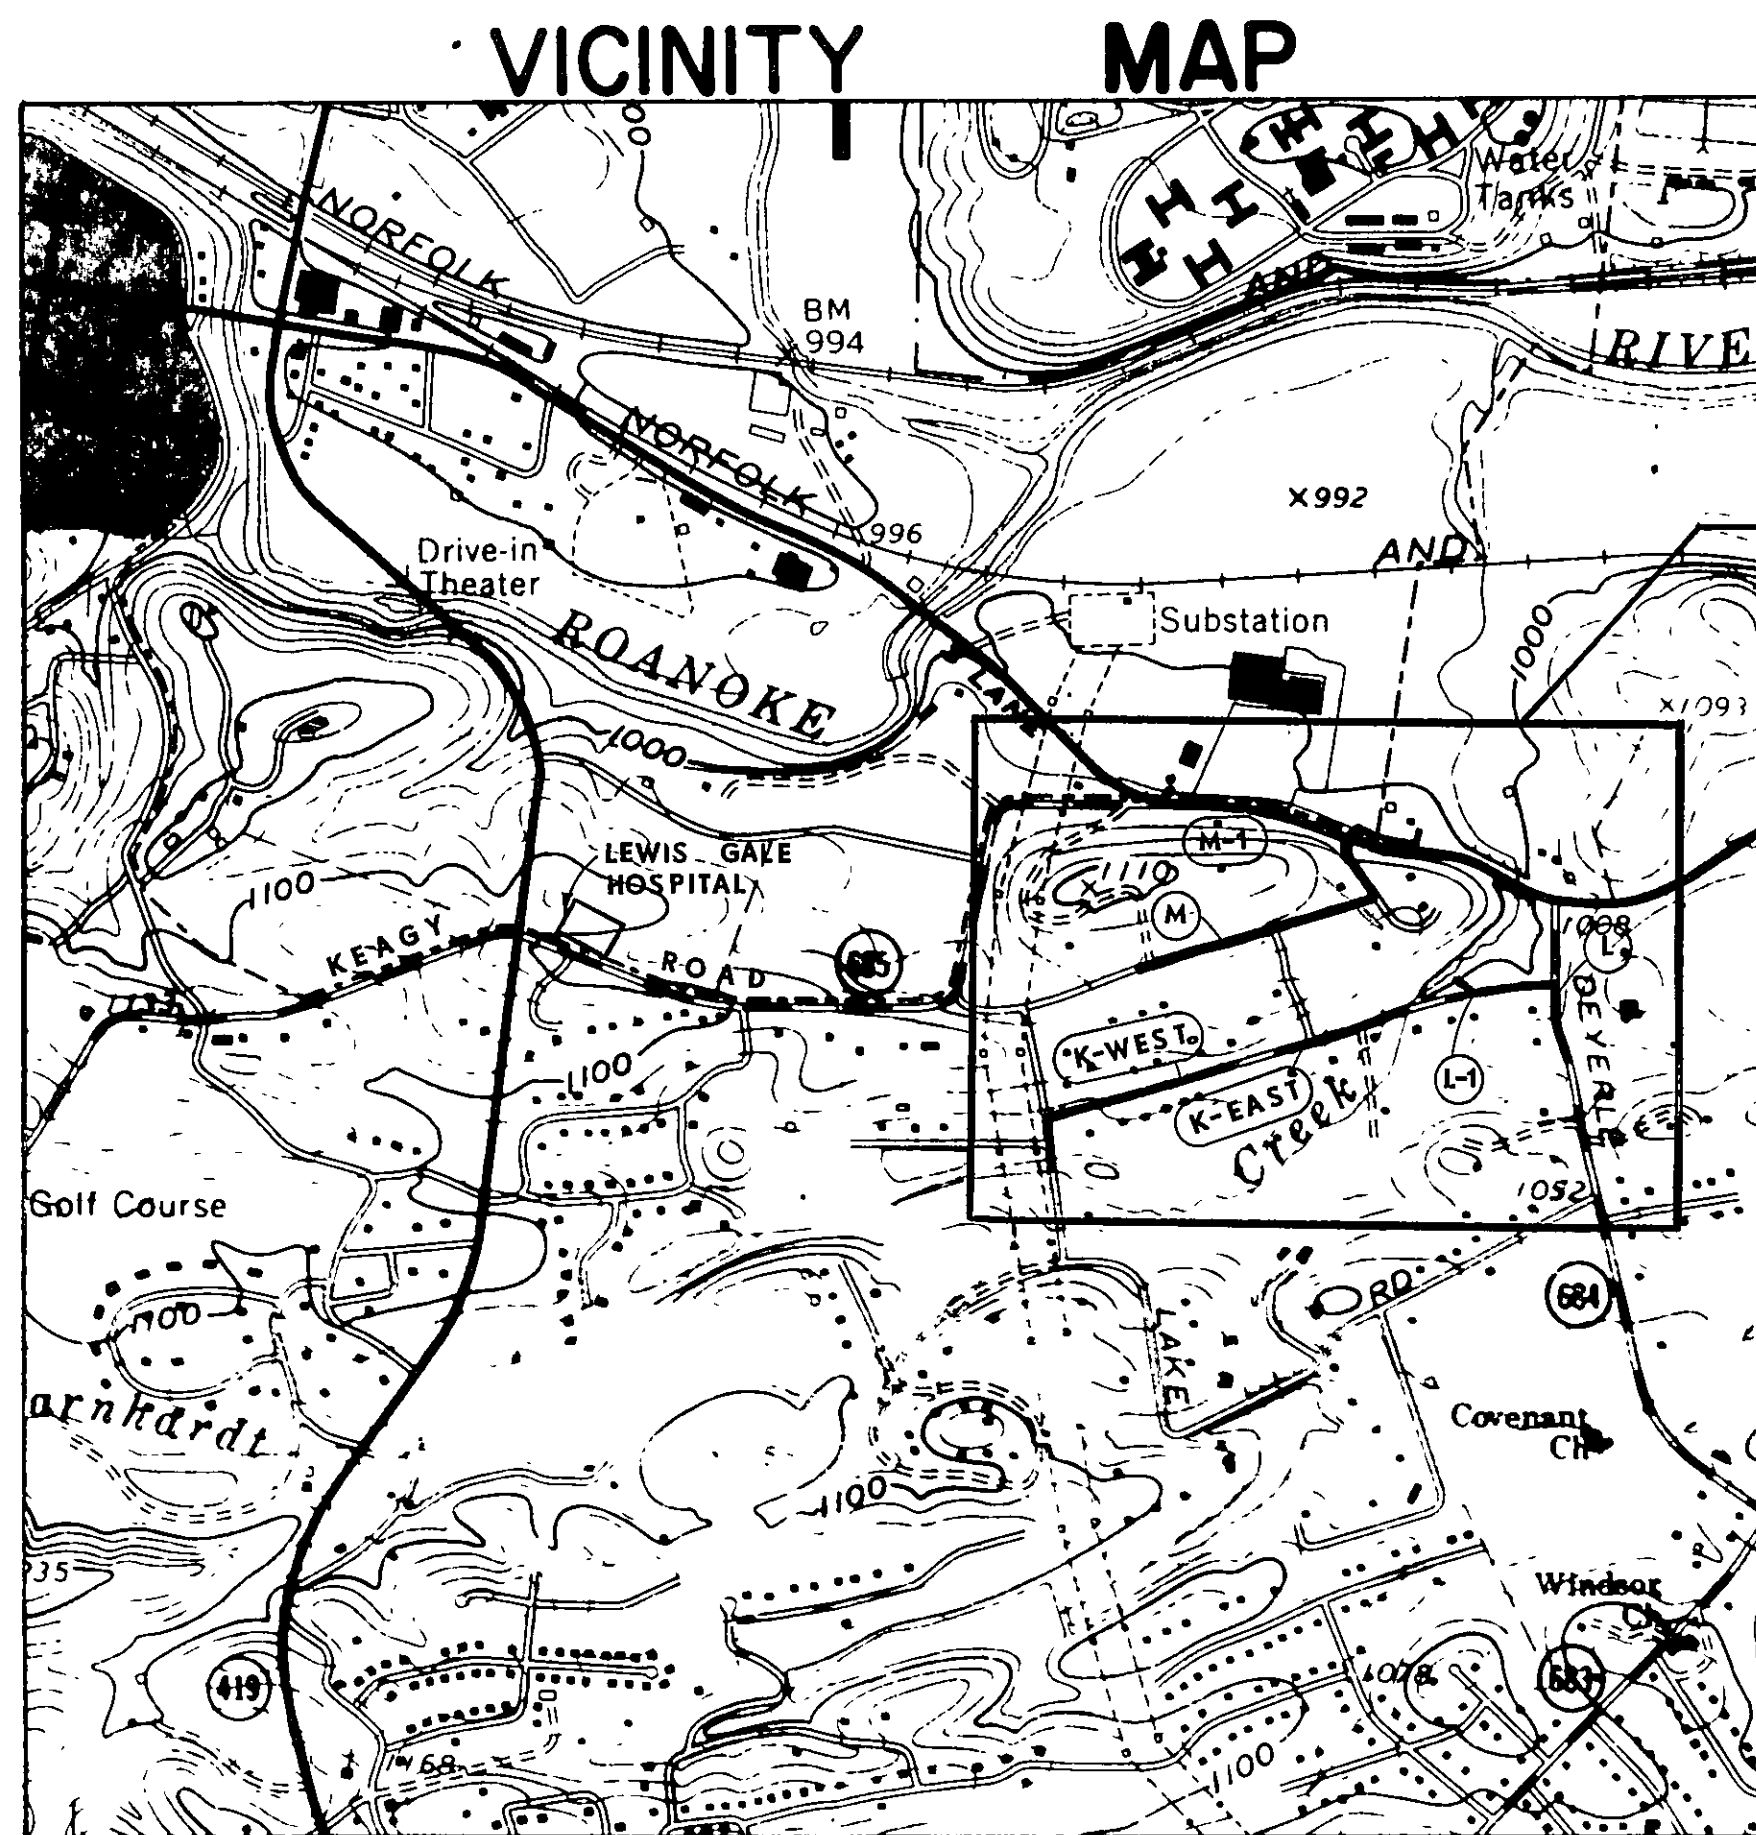

ROANOKE, VIRGINIA


OFFICE OF CITY ENGINEER CONSTRUCTION PLAN CRAVENS-BARNHART SEWAGE COLLECTION SYSTEM PROJECT I

PREPARED BY
BUFORD T. LUMSDEN & ASSOCIATES, P.C.
CERTIFIED LAND SURVEYORS
ROANOKE, VIRGINIA
DATE: 24 OCT. 1980

INDEX OF SHEETS

SHEET NO.	DESCRIPTION
1	TITLE
2	QUANTITIES AND DETAILS
3	PLAN AND PROFILE LINE K-WEST
4	PLAN AND PROFILE LINE K-EAST
5	PLAN AND PROFILE LINE L-L-1
6	PLAN AND PROFILE LINE M-1
7	PLAN AND PROFILE LINE M

AS BUILT

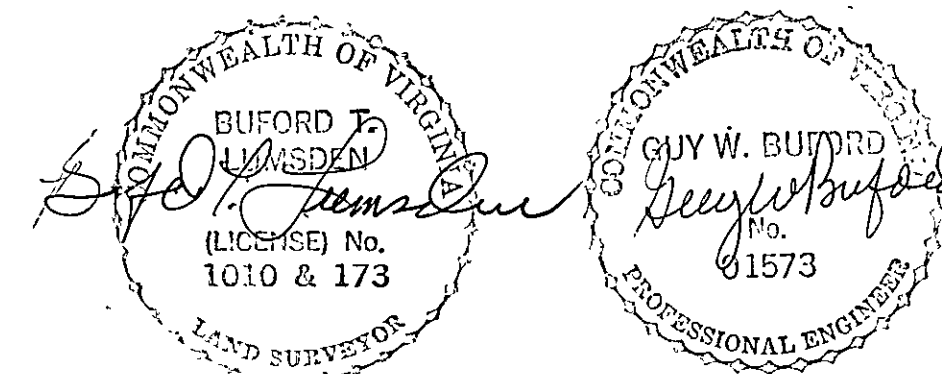

SHEET NO.	DATE	SHEET NO.	DATE
PLANS REVISED			

APPROVED FOR CONSTRUCTION	
24 Oct 80 DATE	<i>Richard B. Brown</i> CITY ENGINEER
10-24-80 DATE	<i>Sharon J. Brady</i> DIRECTOR OF PUBLIC WORKS
24 Oct. 80 DATE	<i>Jeff B. Li</i> DIRECTOR OF UTILITIES & OPERATIONS
DATE	
DATE	
DATE	

APPROVED
DATE
APPROVED
DATE

SHEET 1 OF 7
PLAN NO. 5699