




City of Roanoke
Office of City Engineer
215 South Avenue
Room 350
Roanoke, Virginia 24011
(540) 853-2731

NEW CONSTRUCTION
FIRE-EMS DEPT - TRAINING BUILDING
REGIONAL TRAINING CENTER ROANOKE COUNTY, VIRGINIA


Drawn By
TWK
Designed By
TWK
Checked By
LBC
Date
03/14/00
Scale
AS NOTED
Plan Number
OF
Sheet
C-1

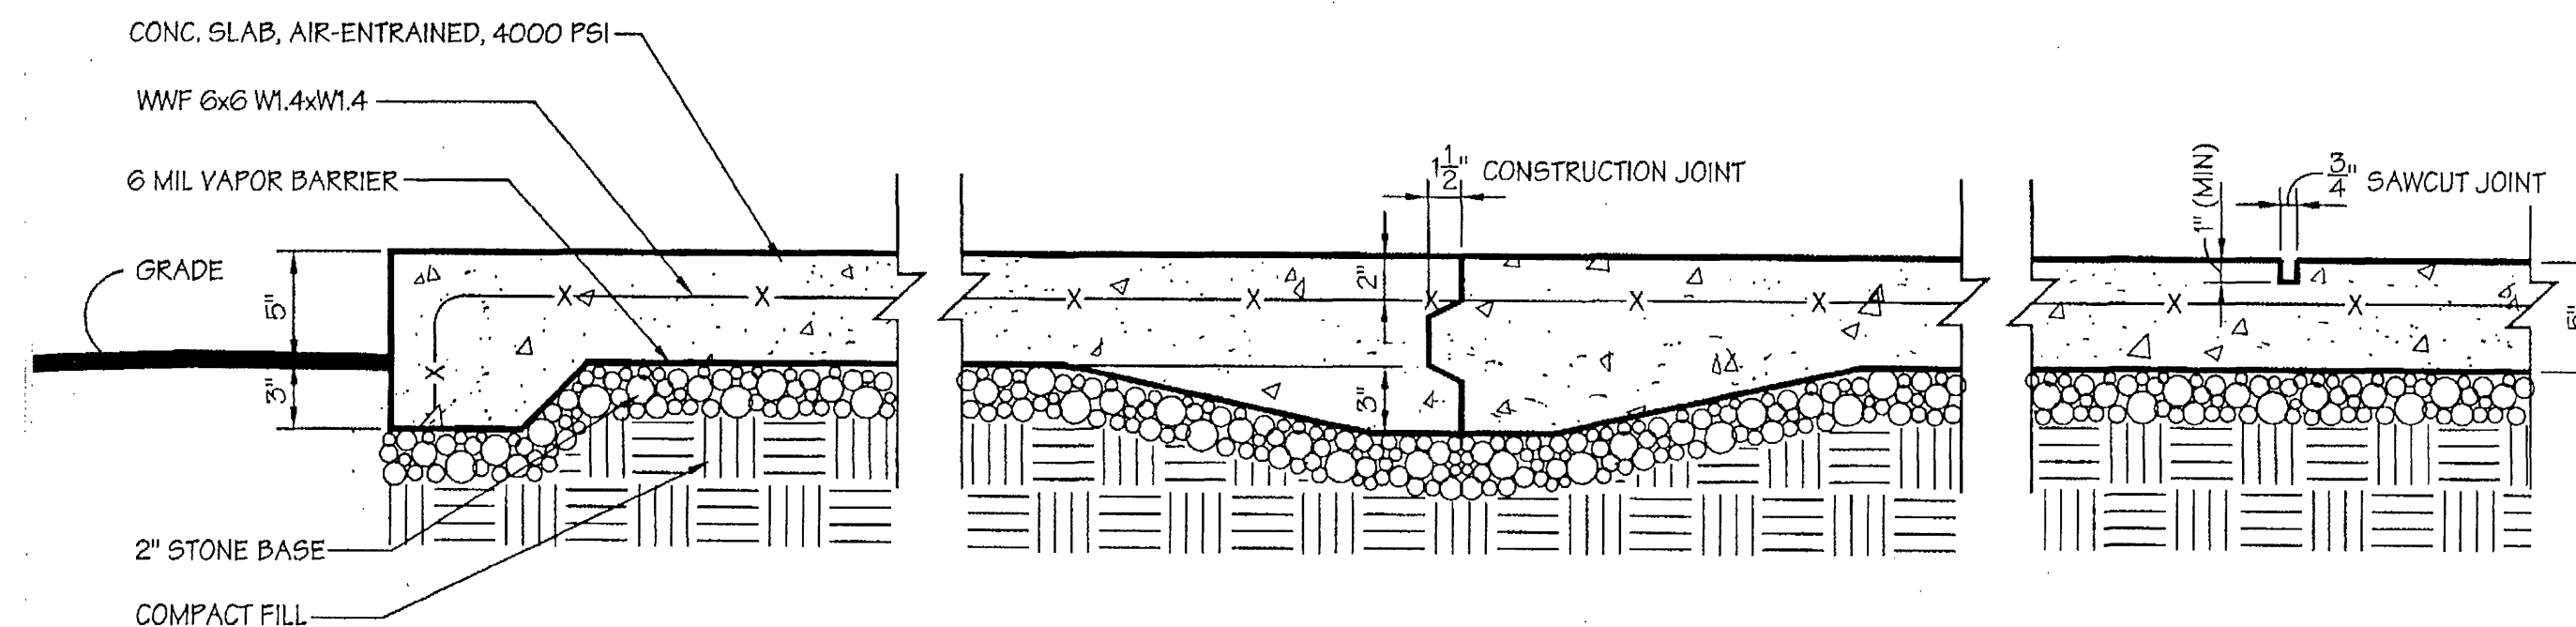

DETAIL-TURNED
DOWN SLAB
3A SCALE: 1 1/2" = 1'-0"

DETAIL-
CONSTRUCTION JOINT
3B SCALE: 1 1/2" = 1'-0"

DETAIL-
CONTROL JOINT
3C SCALE: 1 1/2" = 1'-0"

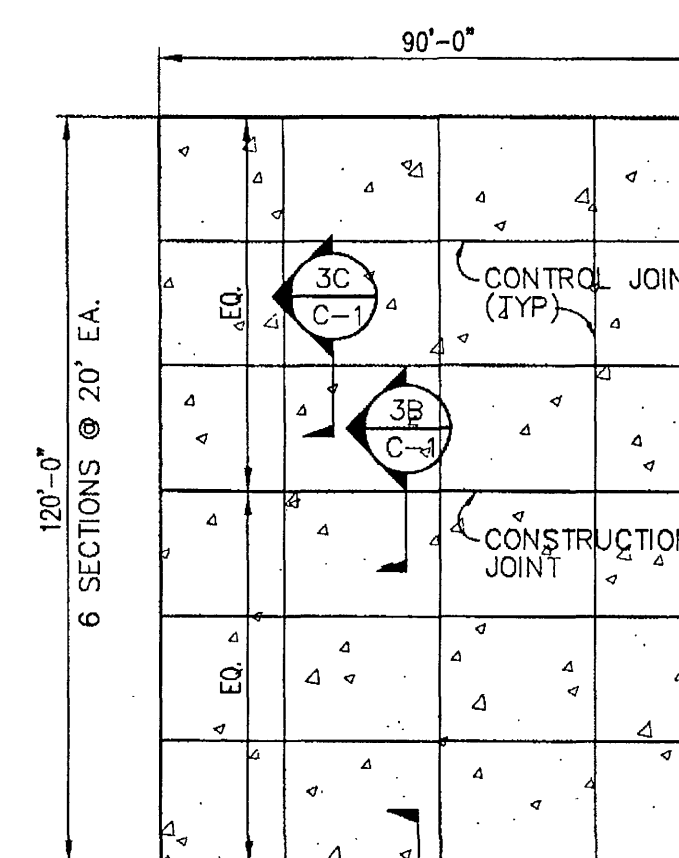

CONCRETE SLAB
PLAN
2 SCALE: 1" = 30'


NOTES:

1. ALL WATER AND SEWAGE FACILITIES SHALL COMPLY WITH ROANOKE COUNTY STANDARDS.
2. CONTRACTOR SHALL FIELD VERIFY LOCATION AND DEPTH OF ALL UNDERGROUND UTILITIES AND STRUCTURES PRIOR TO BEGINNING SITE WORK. NOTIFY CITY OF ROANOKE ENGINEERING DEPT. OF ALL DISCREPANCIES.
3. EXISTING SITE INFORMATION DEVELOPED BY DAY-WILLIAMS CONSULTING ENGINEERS, P.L.L.C. AND MARSHWITT ASSOCIATES, P.C.

LEGEND

- FINISHED GRADE
--- EXISTING GRADE

Charles M. Huffling CITY ENGINEER

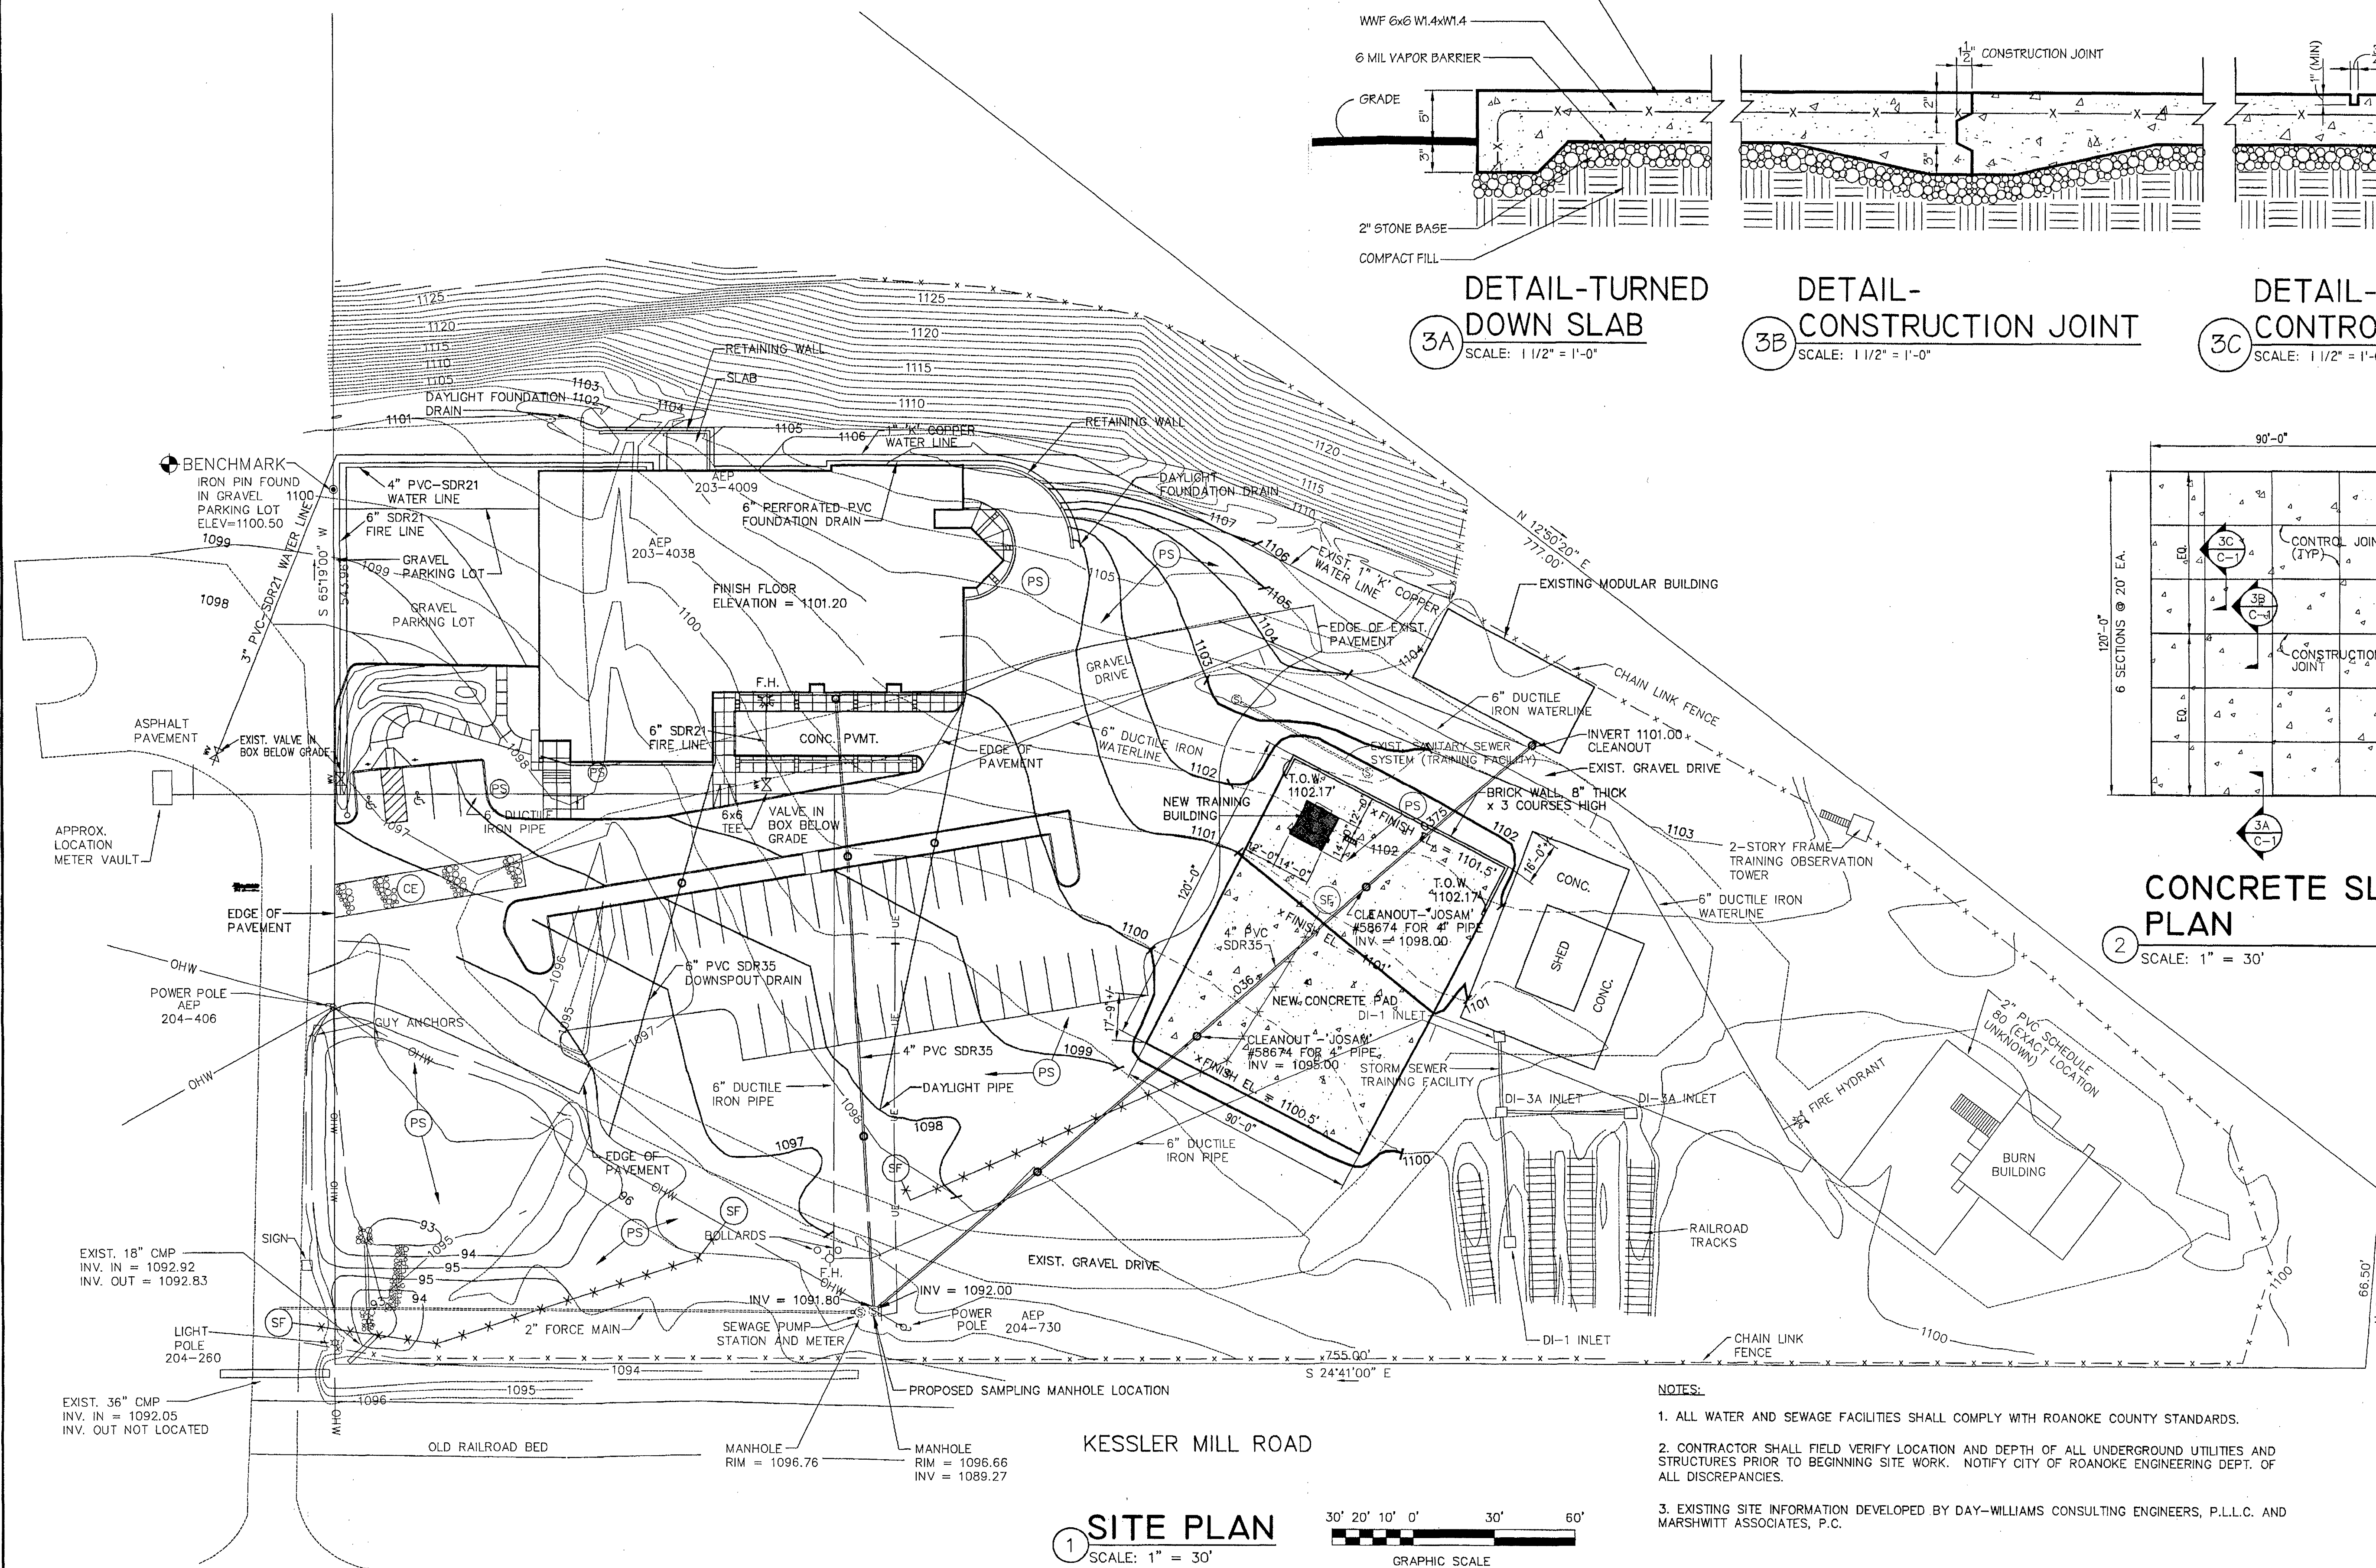

1 SITE PLAN
SCALE: 1" = 30'

