



S:\10284371\_Roanoke\_Firestone\DWG\Sheet\CD\4371-C4.1.dwg Plotted on 5/21/2020 11:13 AM by Jonathan Showalter

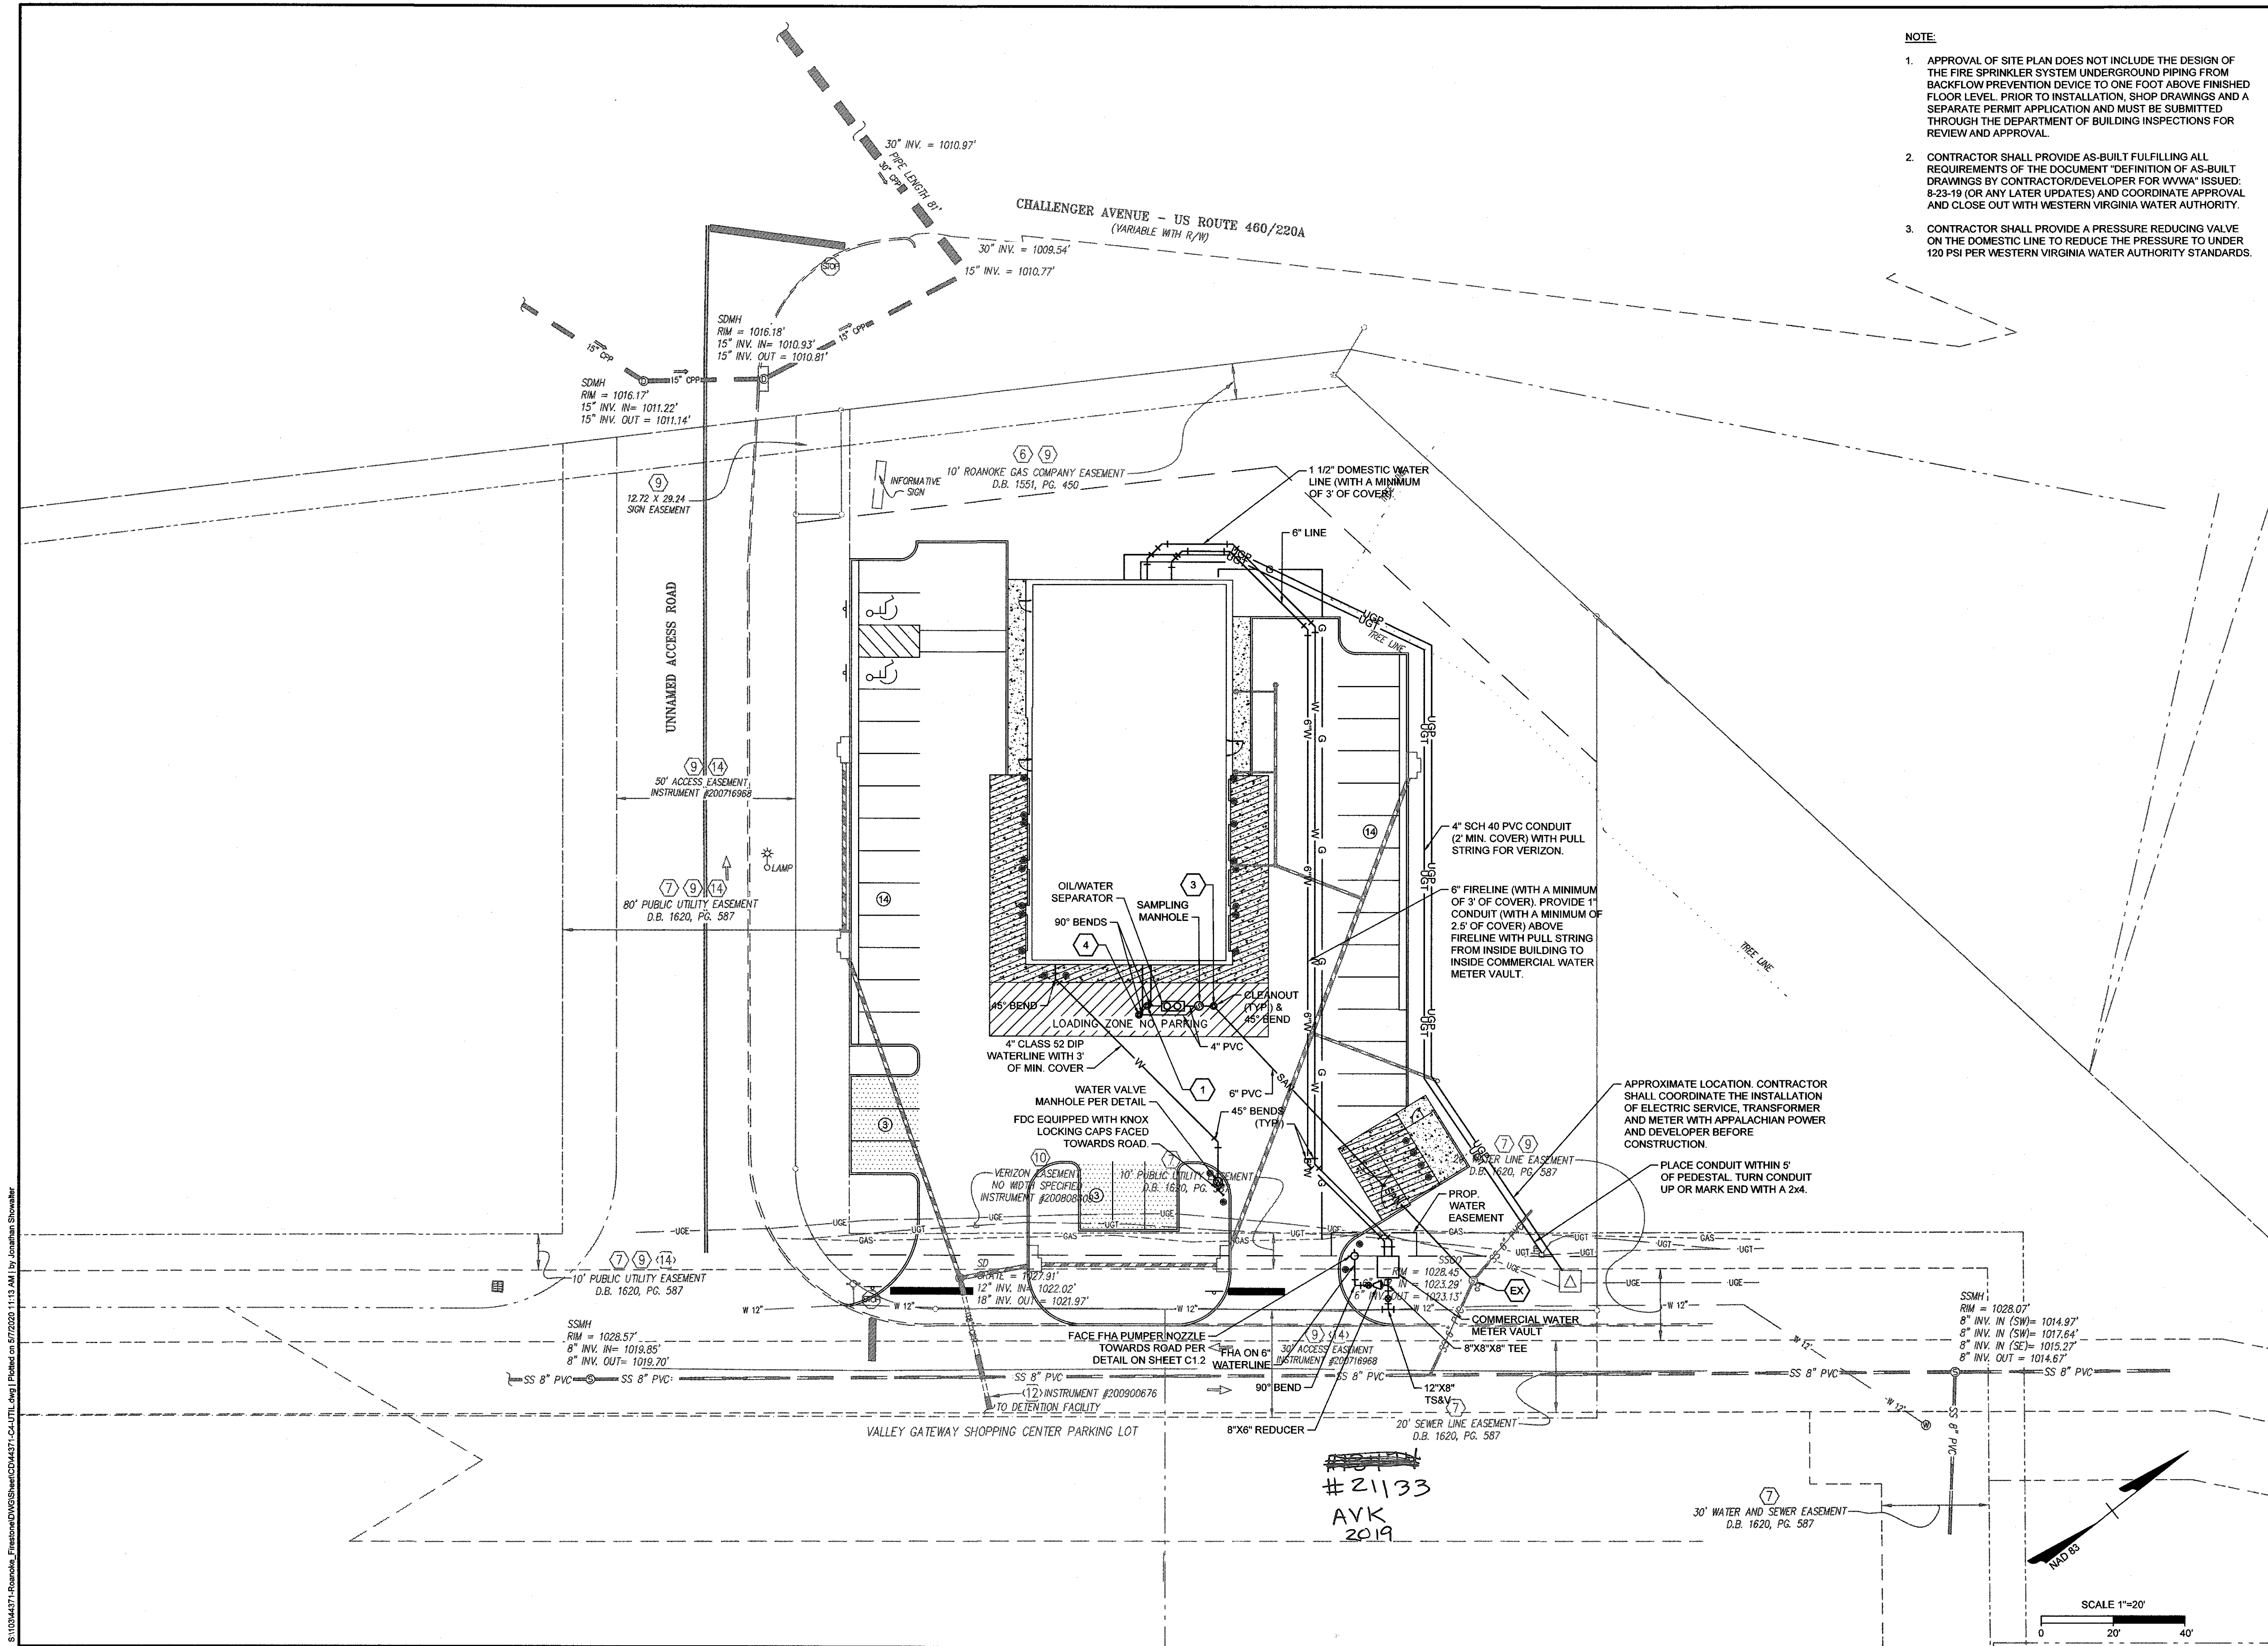

NOTE:

1. APPROVAL OF SITE PLAN DOES NOT INCLUDE THE DESIGN OF THE FIRE SPRINKLER SYSTEM UNDERGROUND PIPING FROM BACKFLOW PREVENTION DEVICE TO ONE FOOT ABOVE FINISHED FLOOR LEVEL. PRIOR TO INSTALLATION, SHOP DRAWINGS AND A SEPARATE PERMIT APPLICATION AND MUST BE SUBMITTED THROUGH THE DEPARTMENT OF BUILDING INSPECTIONS FOR REVIEW AND APPROVAL.
2. CONTRACTOR SHALL PROVIDE AS-BUILT FULFILLING ALL REQUIREMENTS OF THE DOCUMENT. DEFINITION OF AS-BUILT DRAWINGS BY CONTRACTOR/DEVELOPER FOR WVA\* ISSUED: 8-23-19 (OR ANY LATER UPDATES) AND COORDINATE APPROVAL AND CLOSE OUT WITH WESTERN VIRGINIA WATER AUTHORITY.
3. CONTRACTOR SHALL PROVIDE A PRESSURE REDUCING VALVE ON THE DOMESTIC LINE TO REDUCE THE PRESSURE TO UNDER 120 PSI PER WESTERN VIRGINIA WATER AUTHORITY STANDARDS.

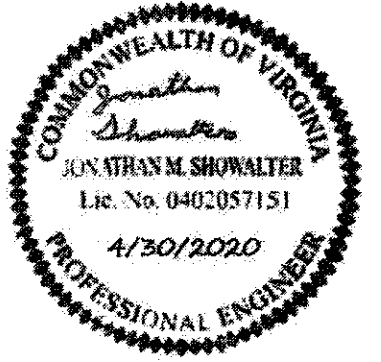

THIS DRAWING PREPARED AT THE  
**CHARLOTTEVILLE OFFICE**  
608 Preston Avenue, Suite 200, Charlottesville, VA 22903  
TEL: 434.295.3664 FAX: 434.295.6317 www.timmons.com

YOUR VISION ACHIEVED THROUGH OURS.

REVISION DESCRIPTION

REVISED PER COUNTY COMMENTS  
REVISED PER COUNTY COMMENTS

DATE  
3/25/20  
4/30/20

DATE  
02/10/2020

DRAWN BY  
Z.DAHL

DESIGNED BY  
J. SHOWALTER

CHECKED BY  
J. SHOWALTER

SCALE  
1" = 20'

**TIMMONS GROUP**

ROANOKE FIRESTONE

ROANOKE COUNTY, VIRGINIA

UTILITY PLAN

JOB NO.  
44371

SHEET NO.  
C4.1

This drawing and its contents are the property of TIMMONS GROUP and may not be reproduced, in whole or in part and shall not be used for any purpose whatsoever, inclusive, but not limited to construction, bidding, under construction solely without the express written consent of TIMMONS GROUP.

APPROVED, 5/21/2020