


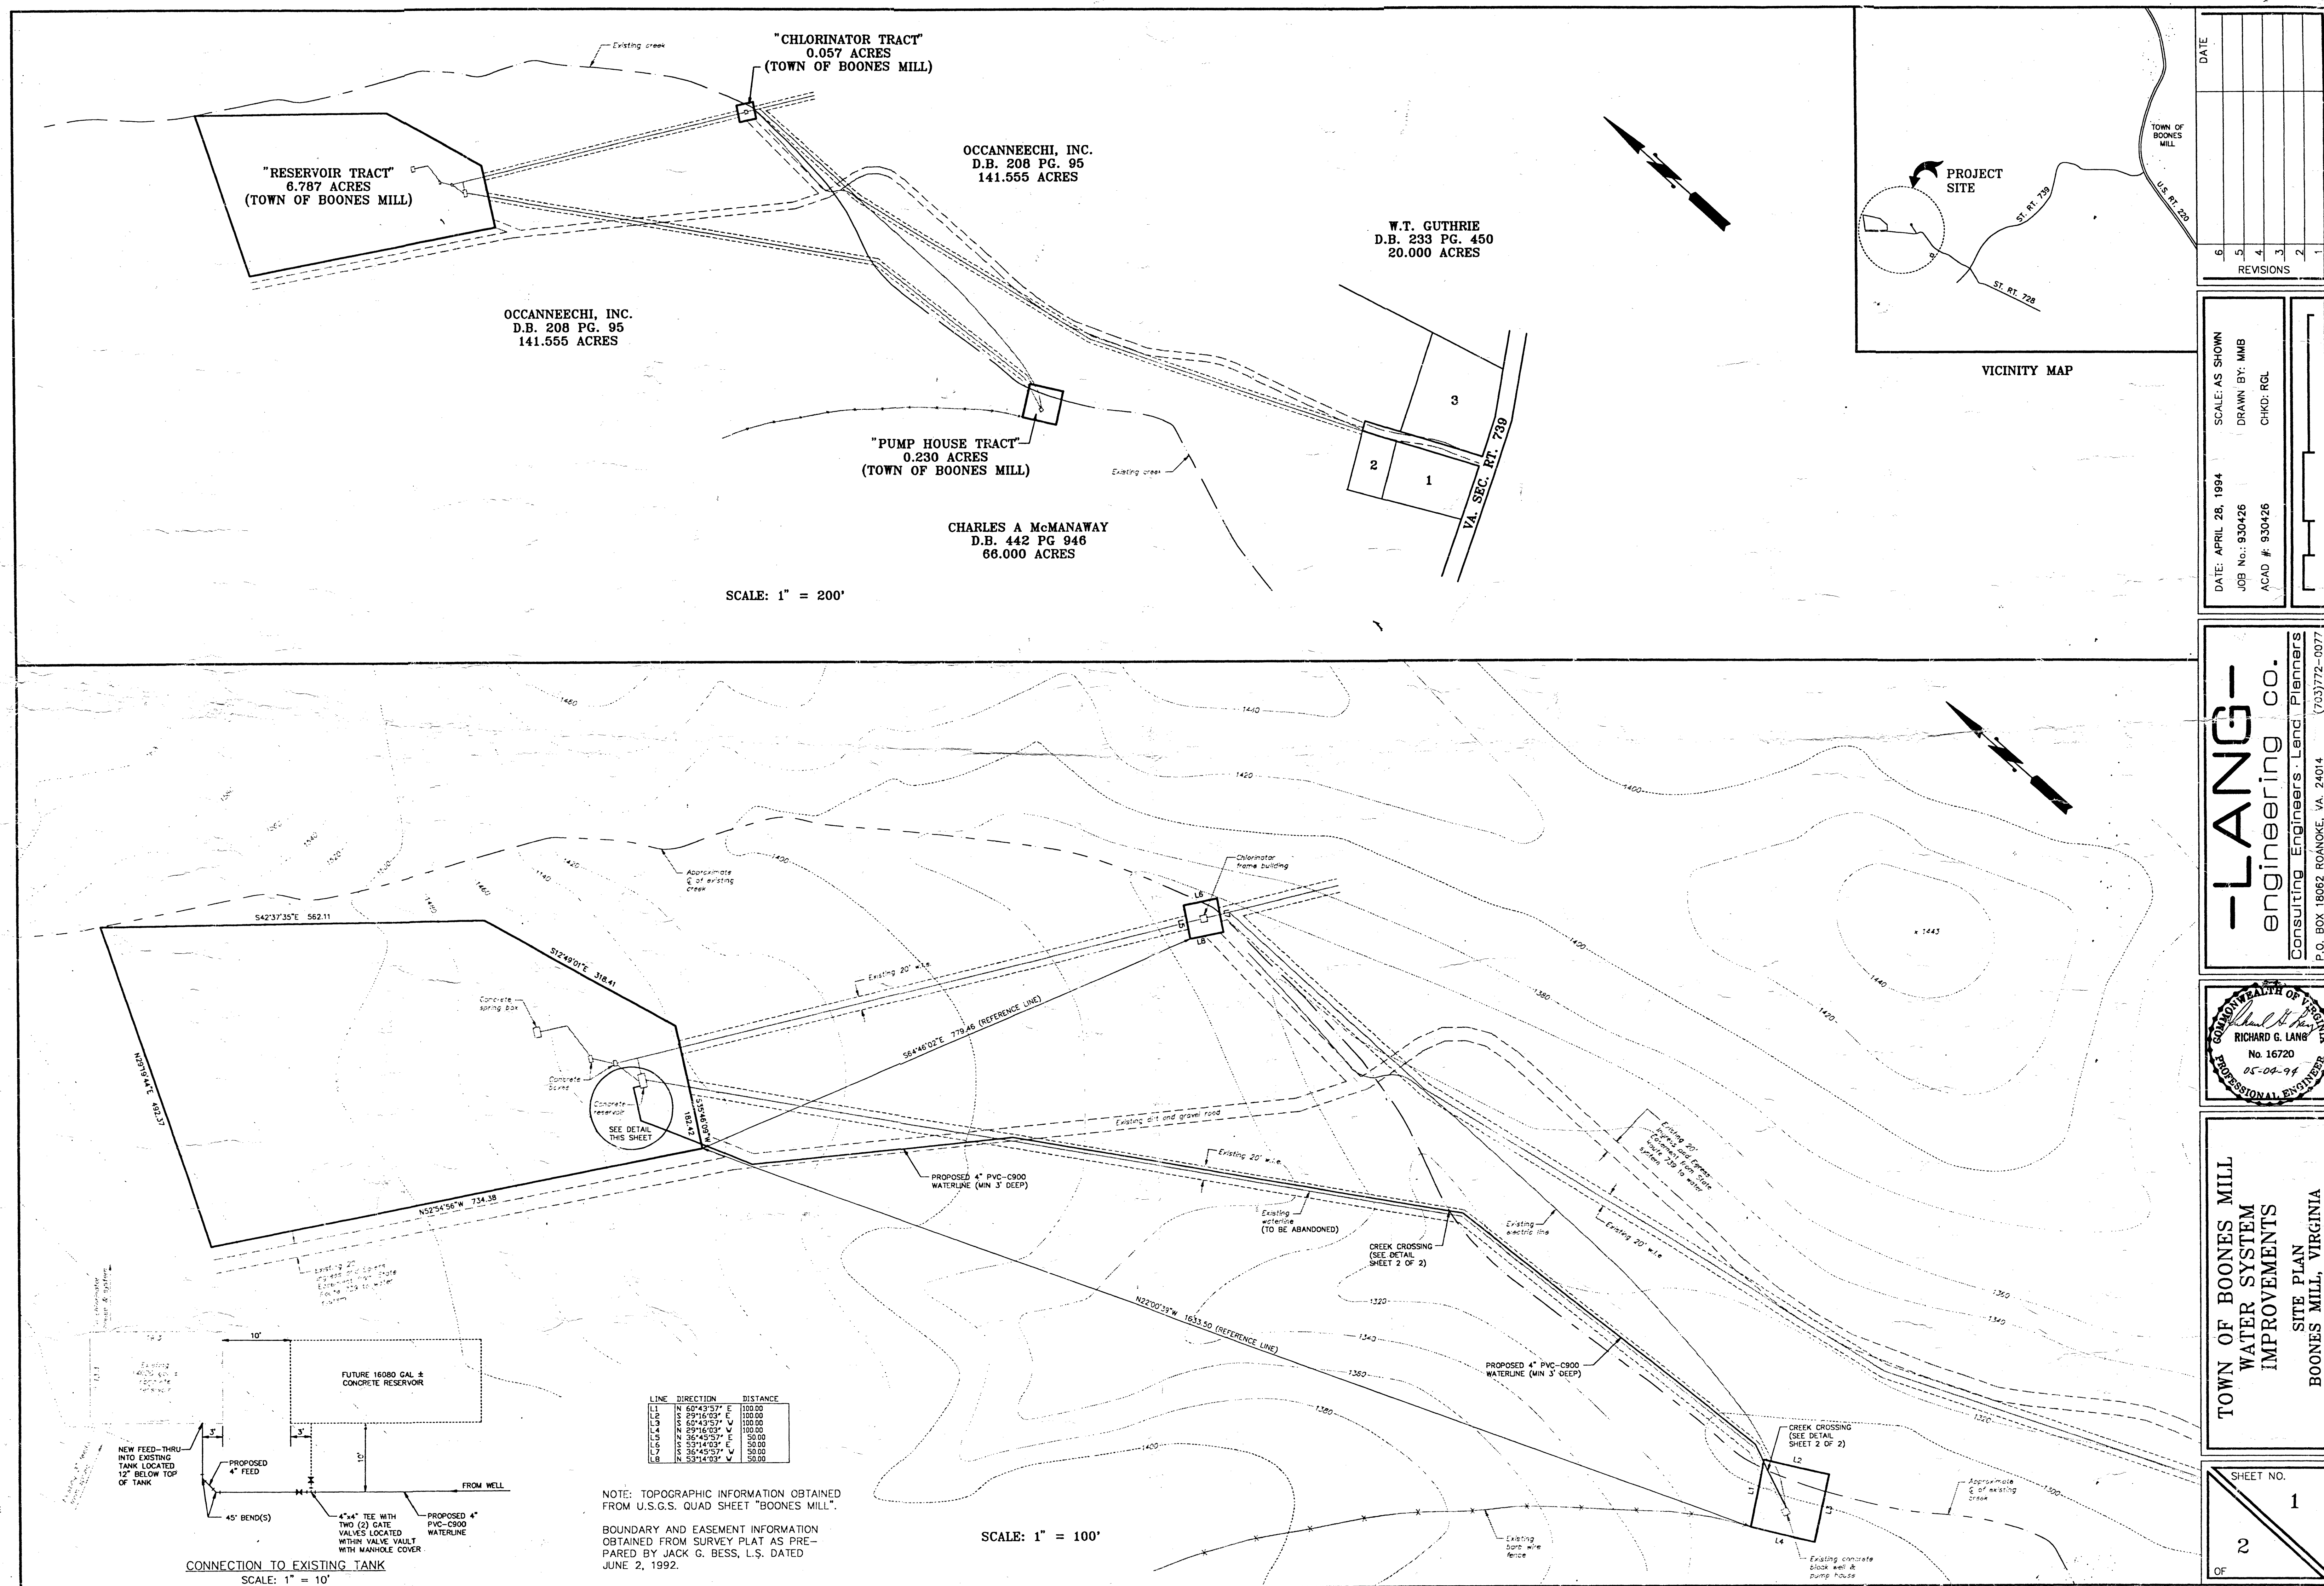

DATE	
REVISIONS	
6	
5	
4	
3	
2	
1	

DATE: APRIL 28, 1994	SCALE: AS SHOWN
JOB No.: 930426	DRAWN BY: MMB
ACAD #: 930426	CHKD: RGL

-LANG-
engineering co.
Consulting Engineers - Land Planners
P.O. BOX 18062 ROANOKE, VA 24014 (703)772-0077

SEAL OF THE COMMONWEALTH OF VIRGINIA
RICHARD G. LANG
No. 16720
05-04-99
PROFESSIONAL ENGINEER

TOWN OF BOONES MILL
WATER SYSTEM
IMPROVEMENTS
SITE PLAN
BOONES MILL, VIRGINIA

SHEET NO. 1
2
OF