


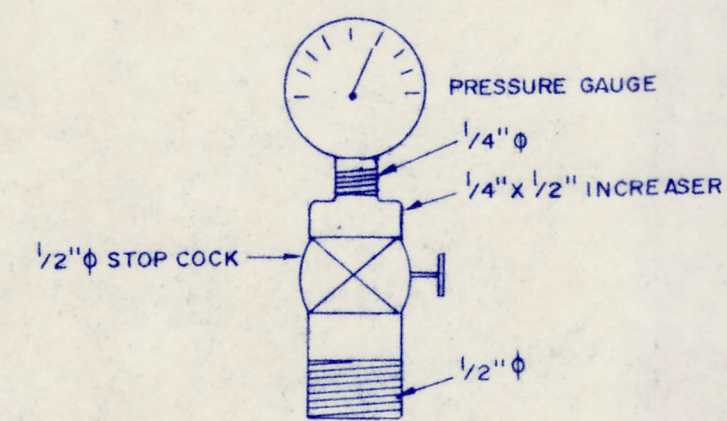


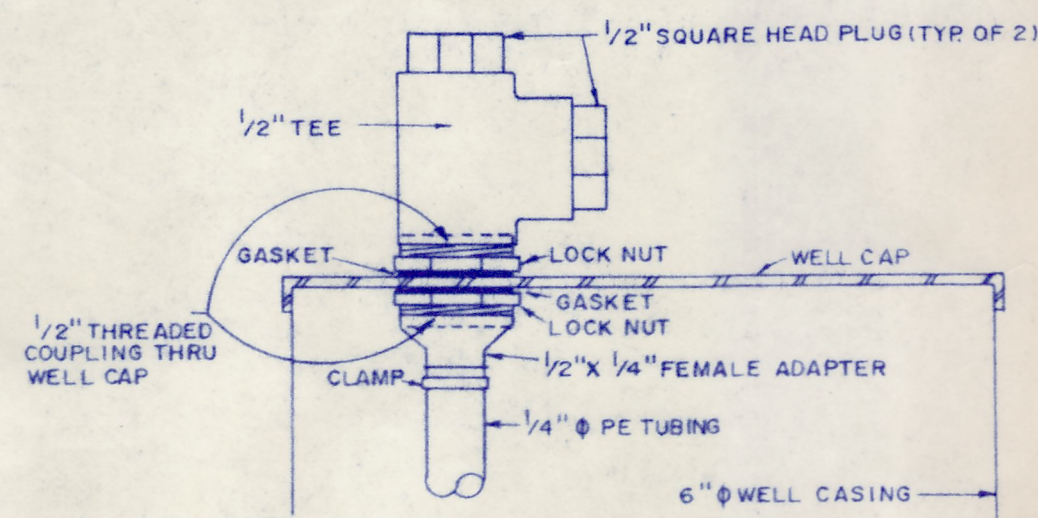

PORTABLE DRAWDOWN GAUGE ASSEMBLY - DETAIL  
N.T.S.

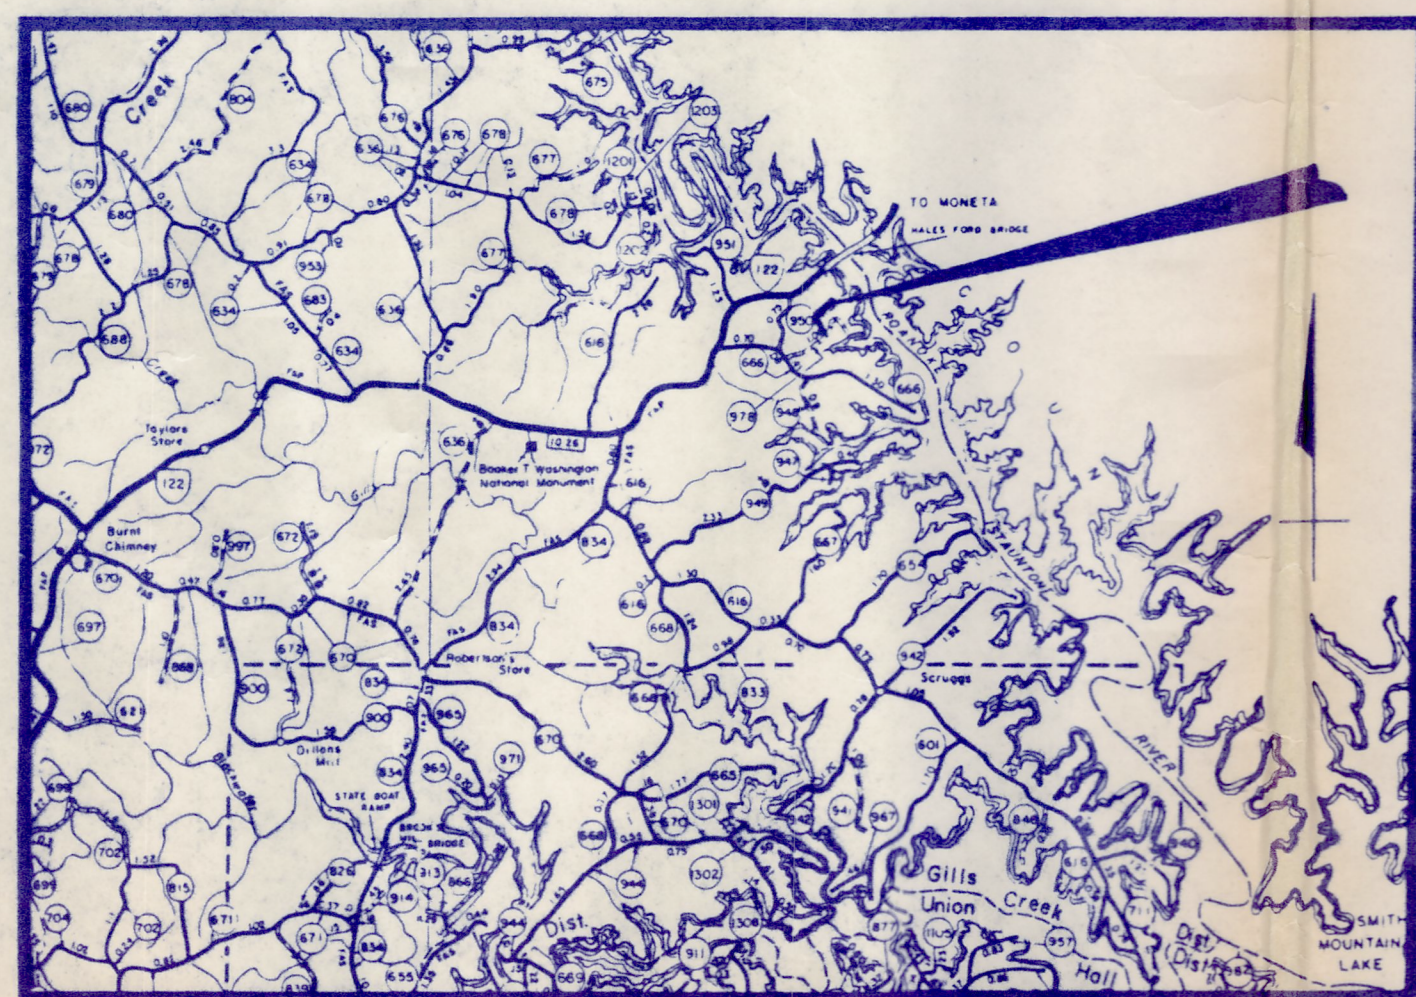


WELL CAP DETAIL  
N.T.S.

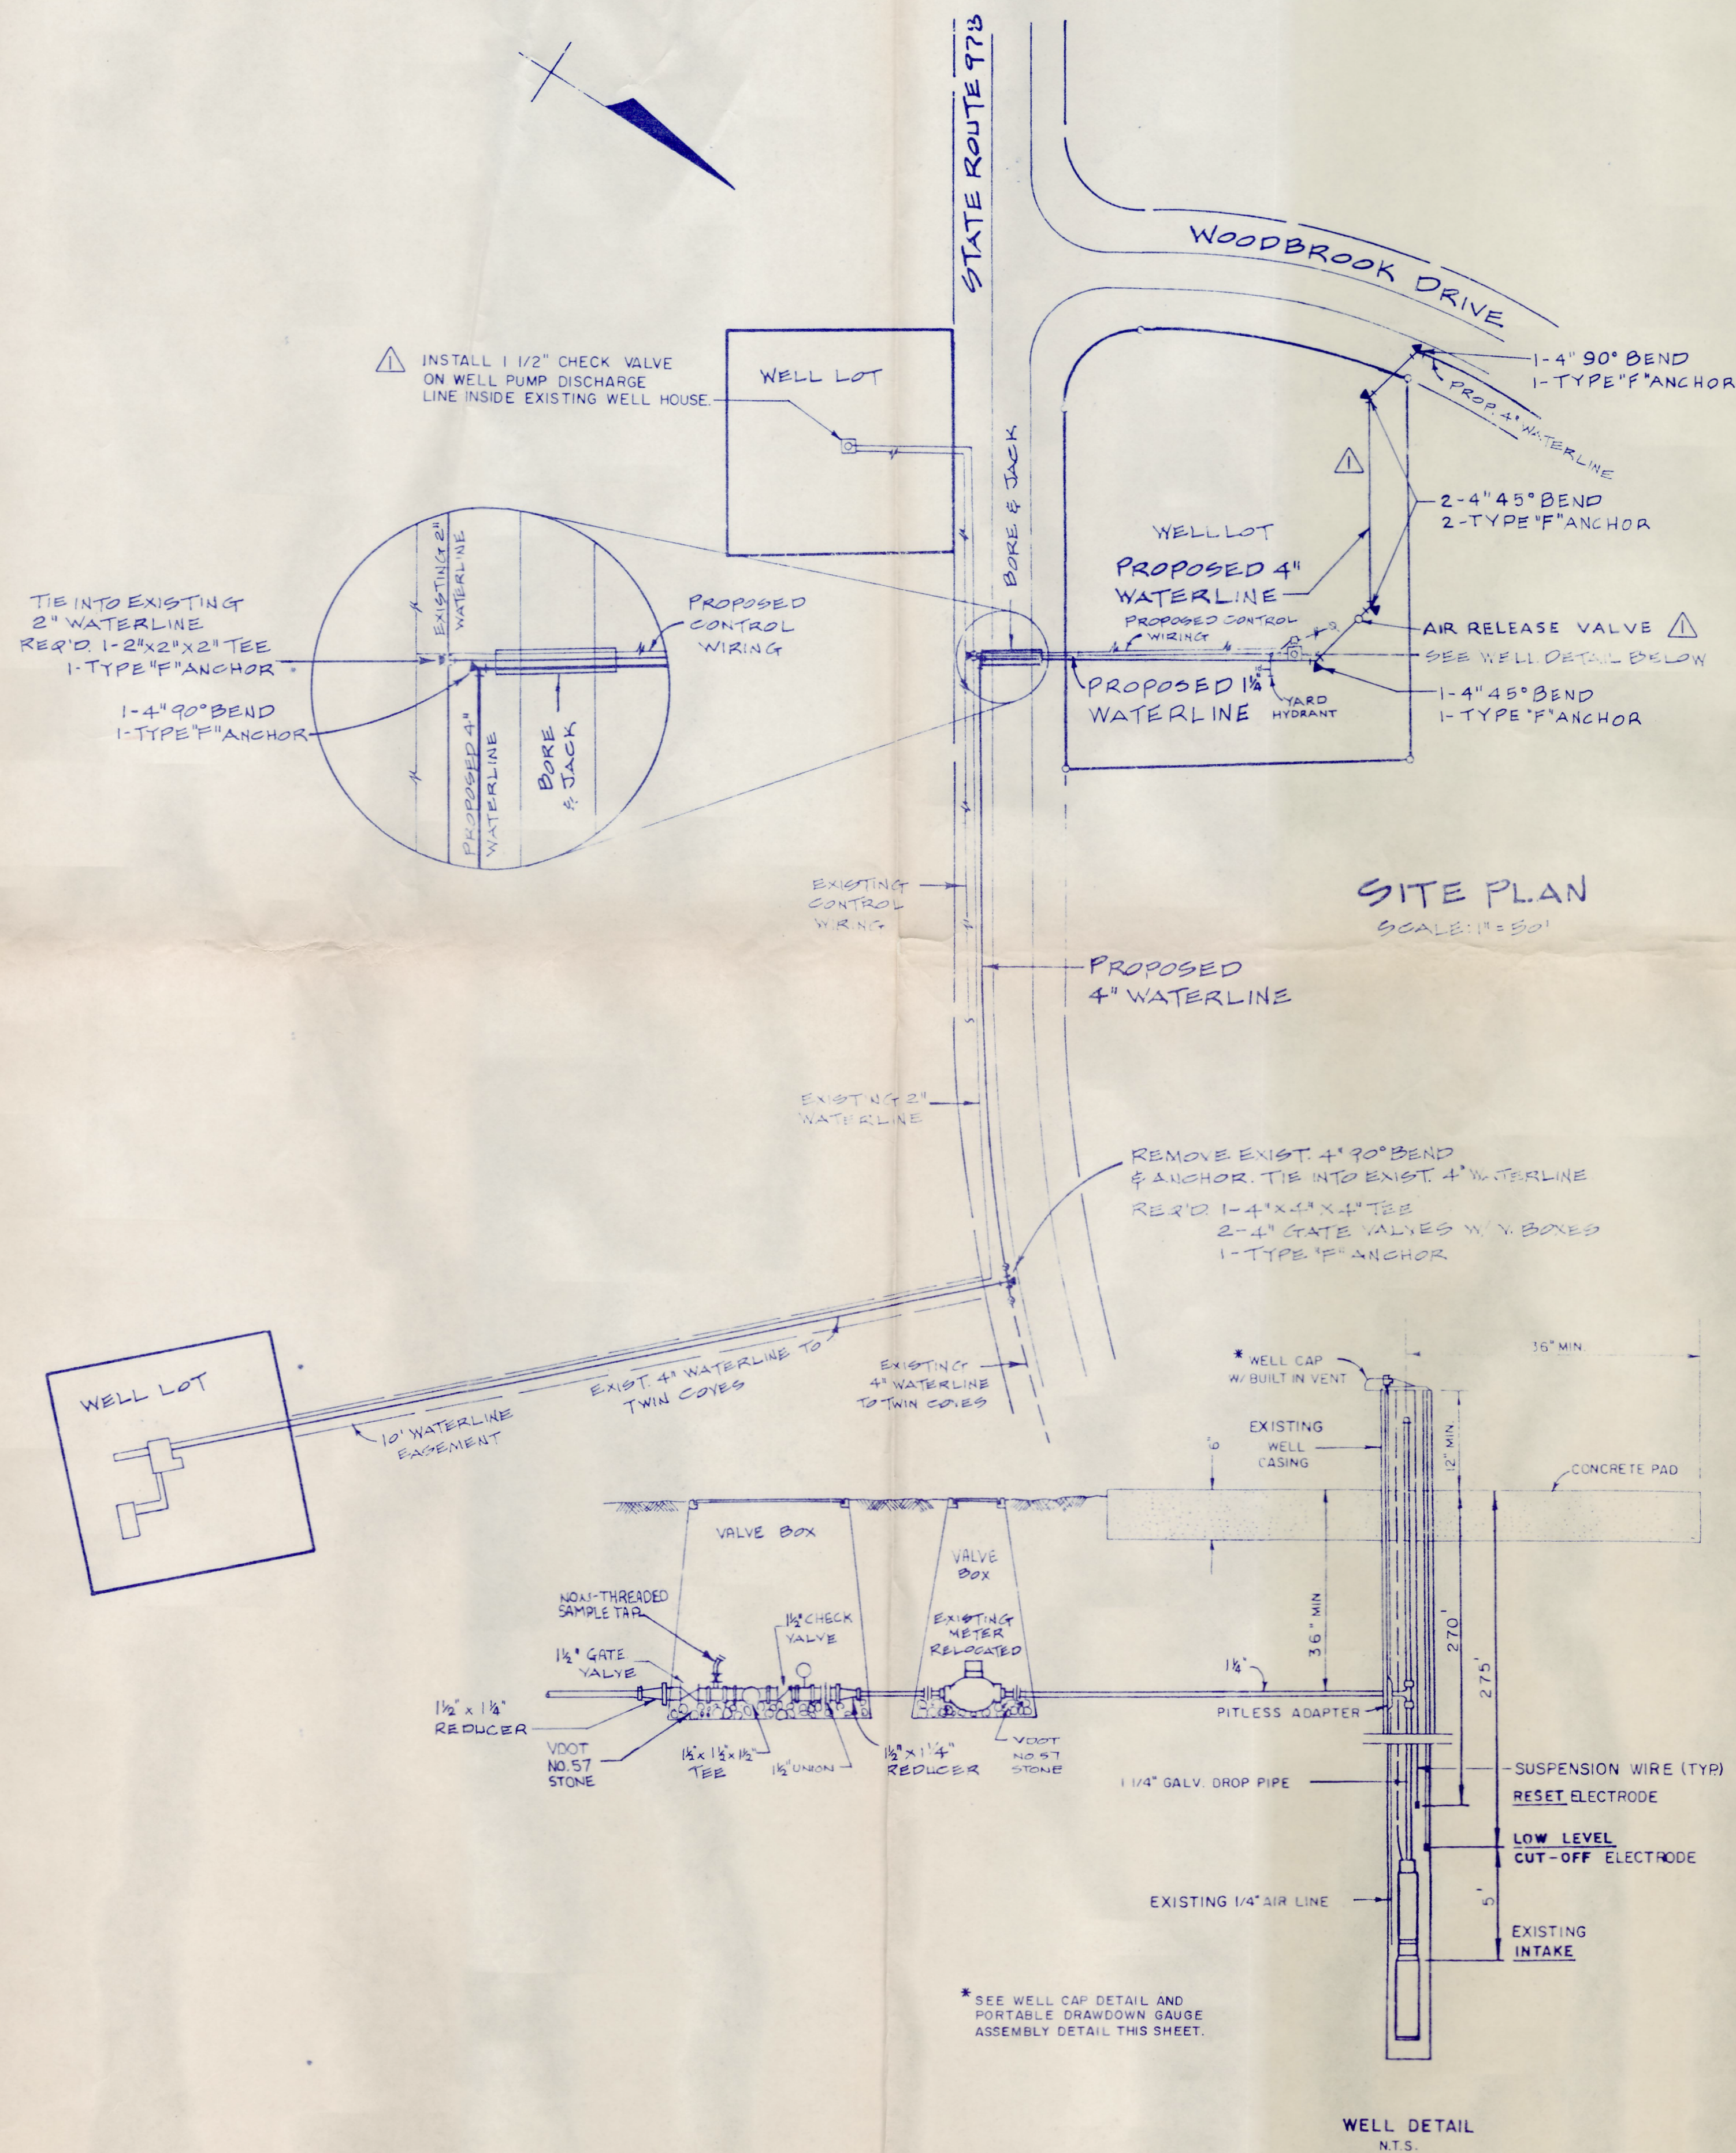

VICINITY MAP  
N.T.S.

Woodbrook Connection

BERKLEY HOWELL & ASSOC., P.C.  
ENGINEERS • SURVEYORS • PLANNERS  
LYND-BURG, VA SMITH MT. LAKE

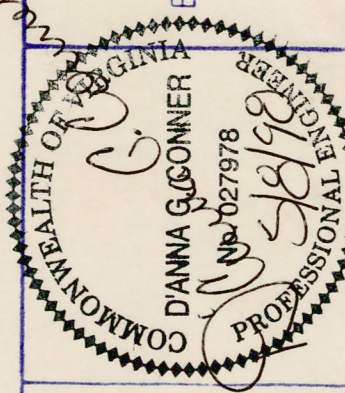

WOODBROOK / TWIN COVES  
WATER SYSTEM INTERFACE  
FRANKLIN COUNTY, VIRGINIA

SITE PLAN

DATE: 10-31-97  
TECHNICIAN:  
CHECKED BY: DGC

| REVISIONS |        |
|-----------|--------|
| NO.       | DATE   |
| 1         | 5-8-98 |

SCALES  
AS SHOWN

PROJ. NO. 97357 DIV. 1 OF 4

SHEET NO. 1 OF 4

DRAWING NO. C-1