



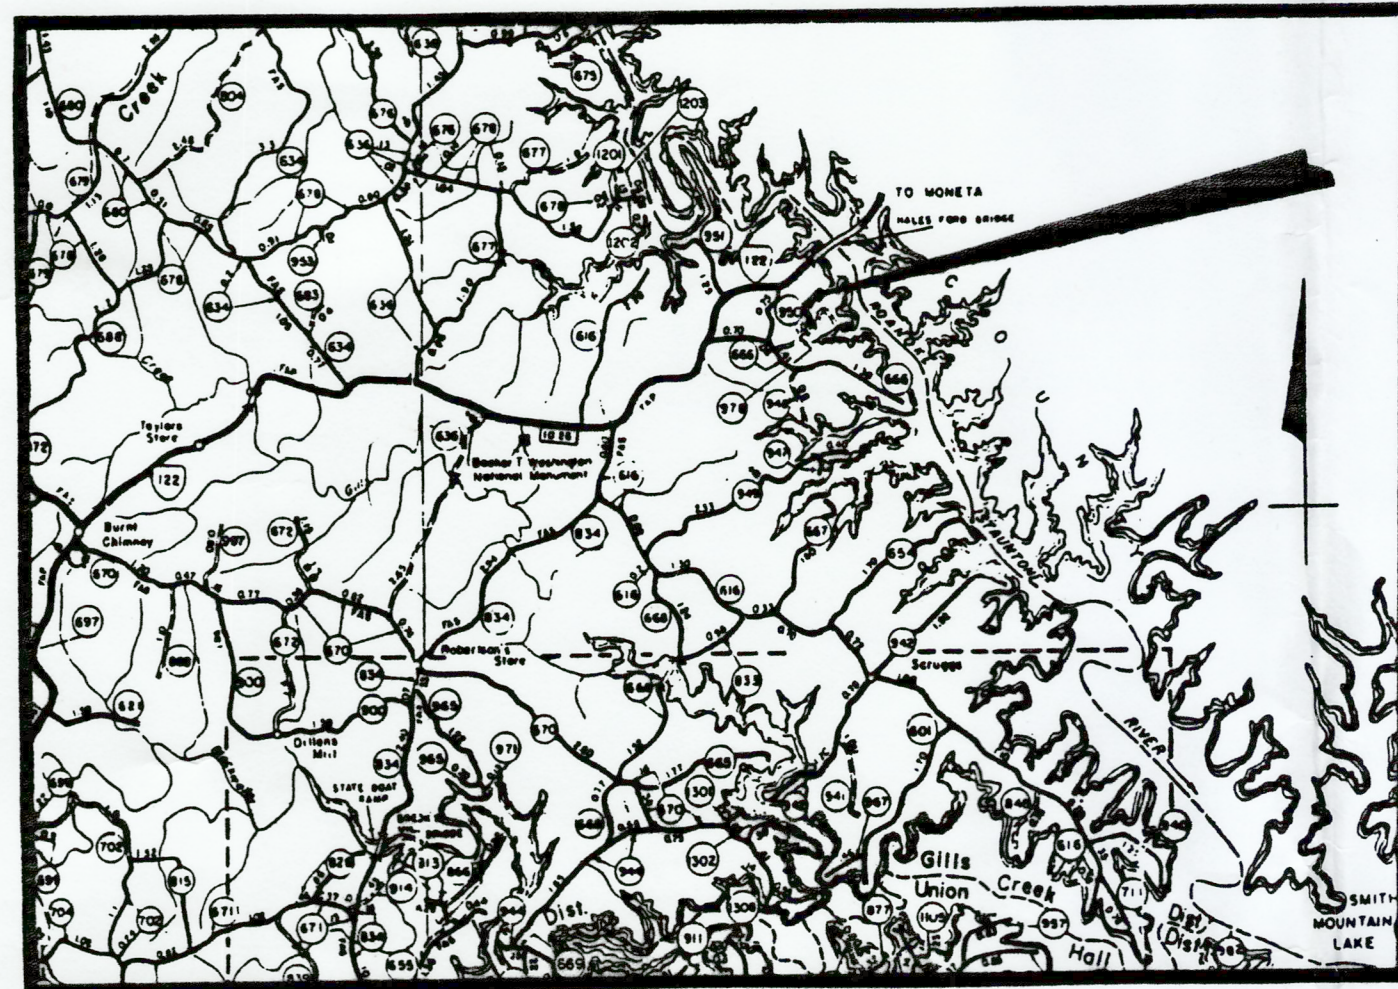

VICINITY MAP
N.T.S.

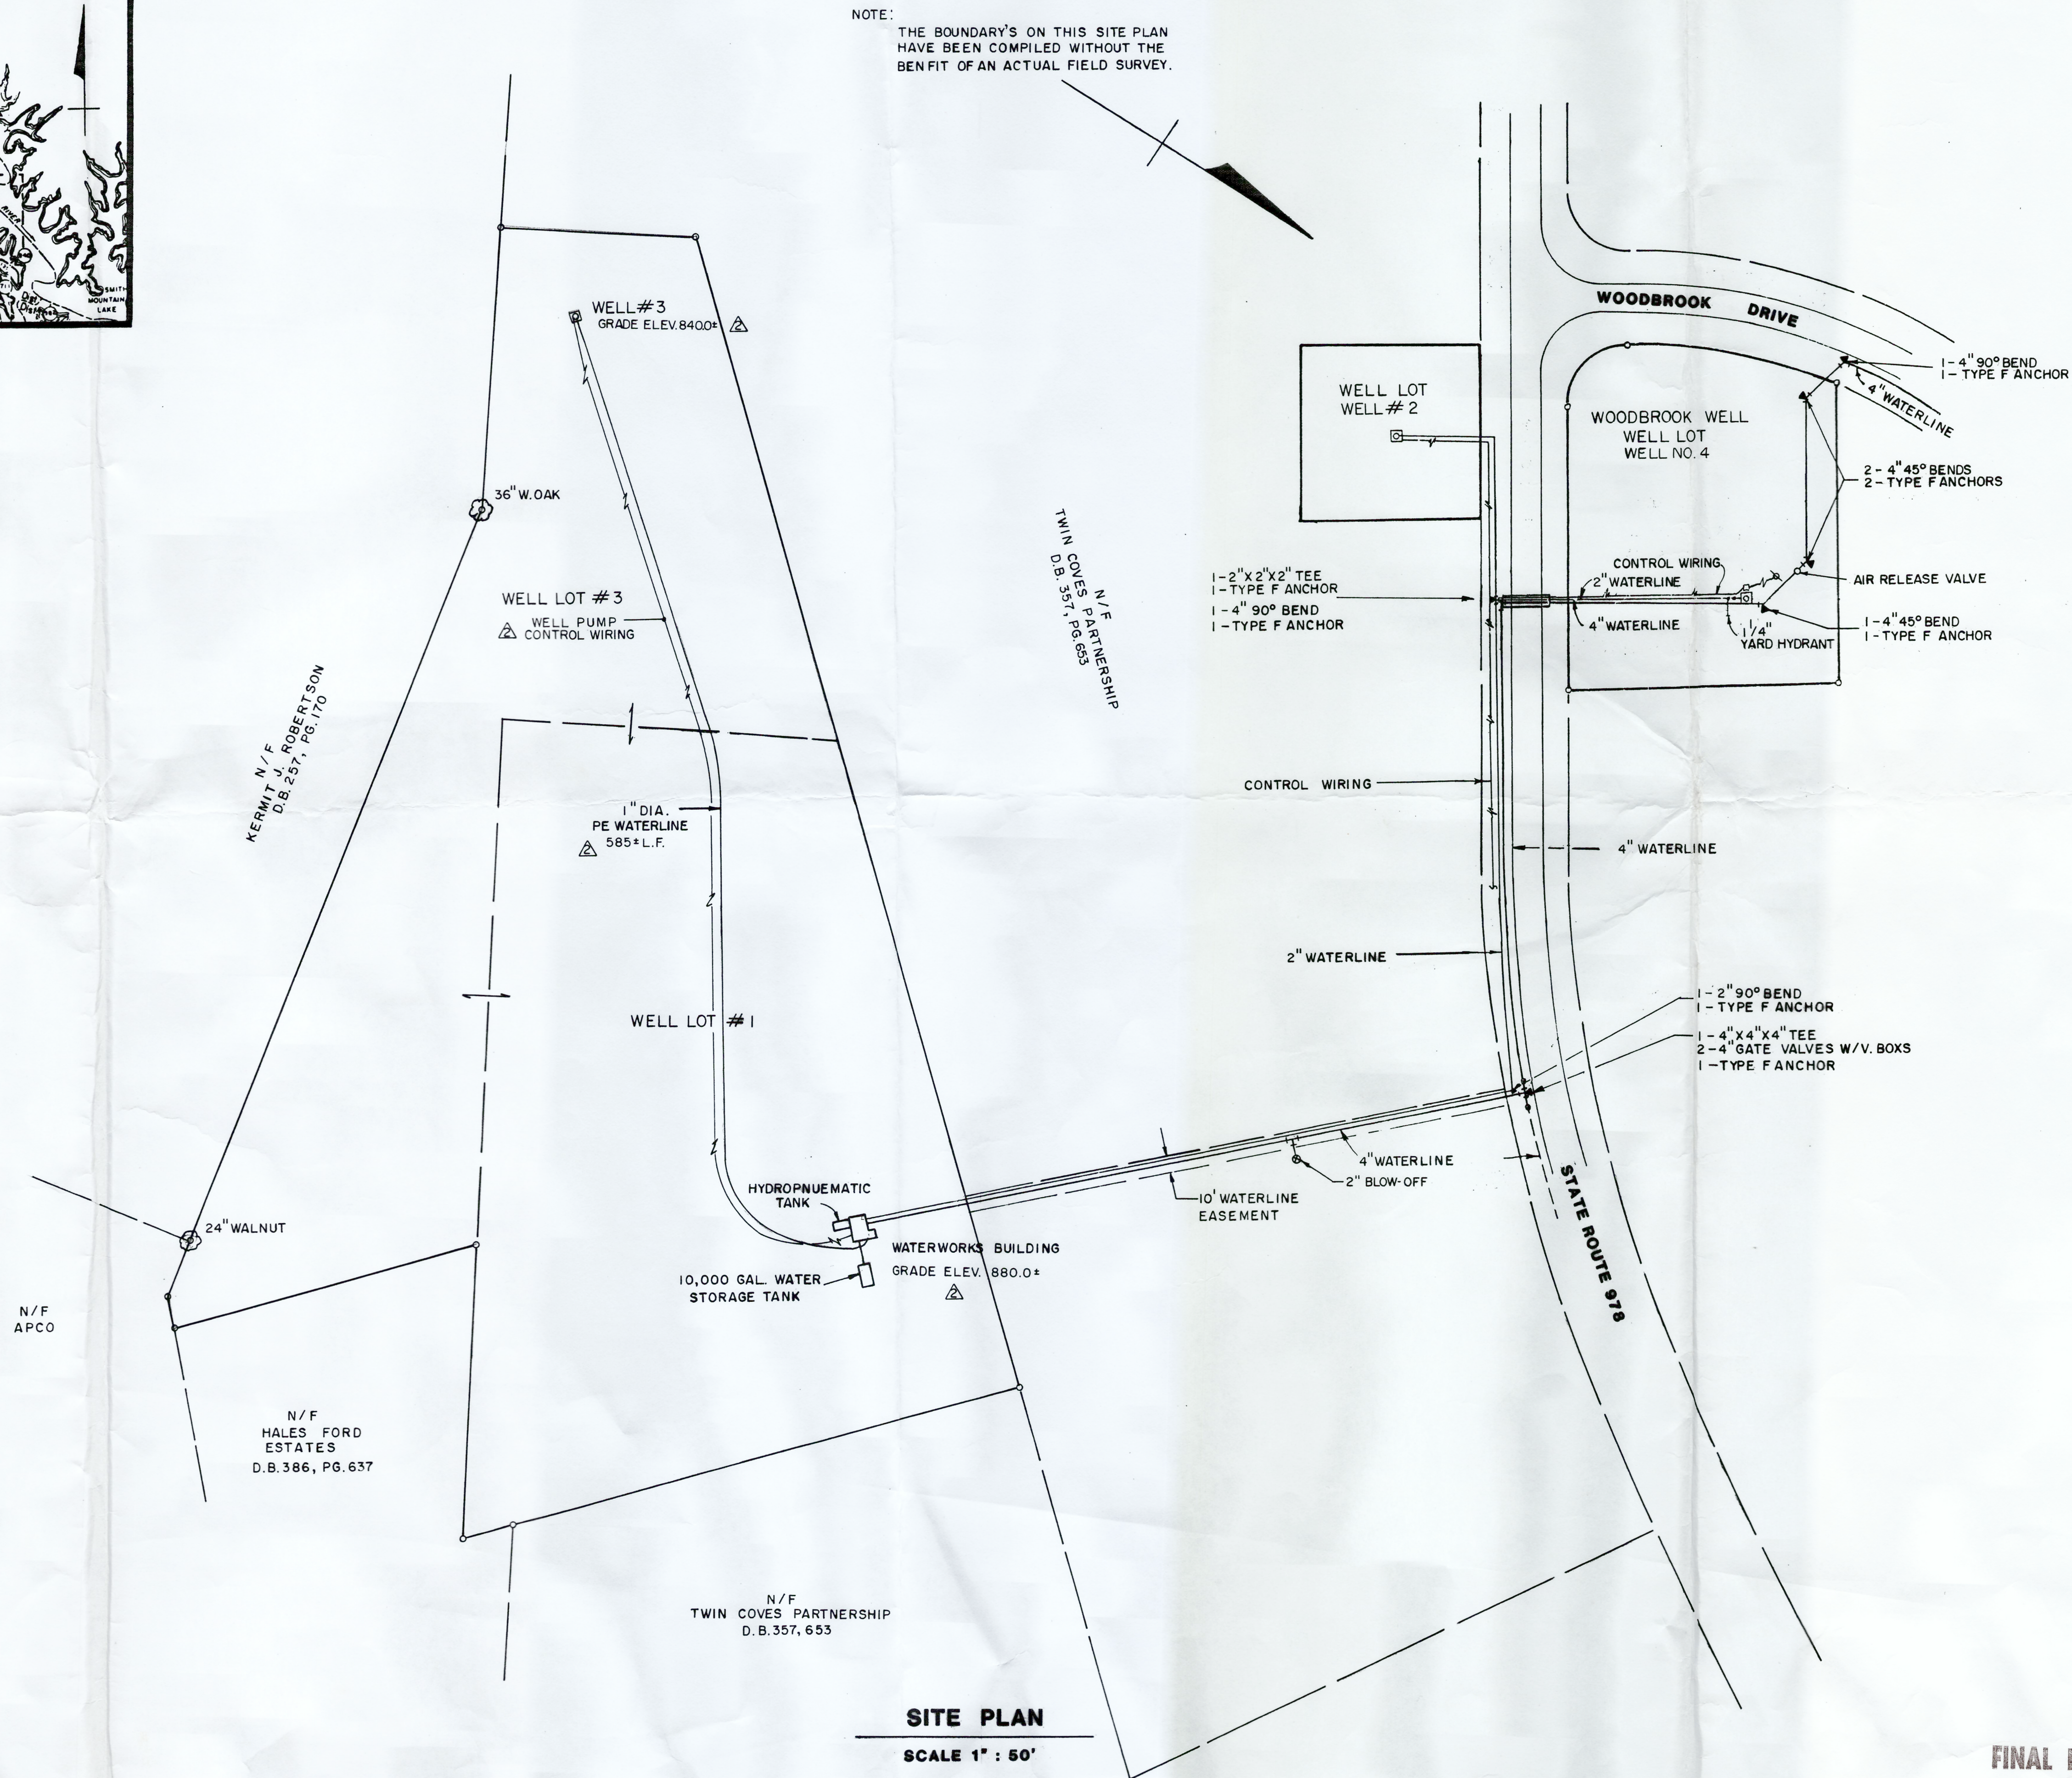

NOTE:
THE BOUNDARY'S ON THIS SITE PLAN
HAVE BEEN COMPILED WITHOUT THE
BENFIT OF AN ACTUAL FIELD SURVEY.

SITE PLAN

SCALE 1" : 50'

FINAL DRAFT

WATERWORKS IMPROVEMENTS

TWIN COVES
WATER SYSTEM

BERKLEY HOVELL & ASSOC., P.C.
ENGINEERS • SURVEYORS • PLANNERS
1032 CLAYMONT DRIVE
LYNCHBURG, VA. 24502
PH: (804) 385-7548 FAX: (804) 385-6178

BILLS CREEK DISTRICT-FRANKLIN COUNTY, VIRGINIA

DATE: 1-05-01

TECHNICIAN: TWM

CHECKED BY: BCP

REVISIONS

NO.	DATE
1	2-21-02

SCALES
AS SHOWN

PROJ. NO.
99363

SHEET NO.
1 OF 3

DRAWING NO.
WATER

MANUSCRIPT DRAWING NUMBER:

VIEWS TO CREATE THIS DRAWING:

FIELDBOOK IDENTIFICATION:

SURVEY DATUM USED: