
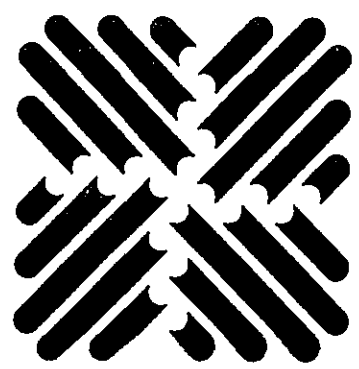


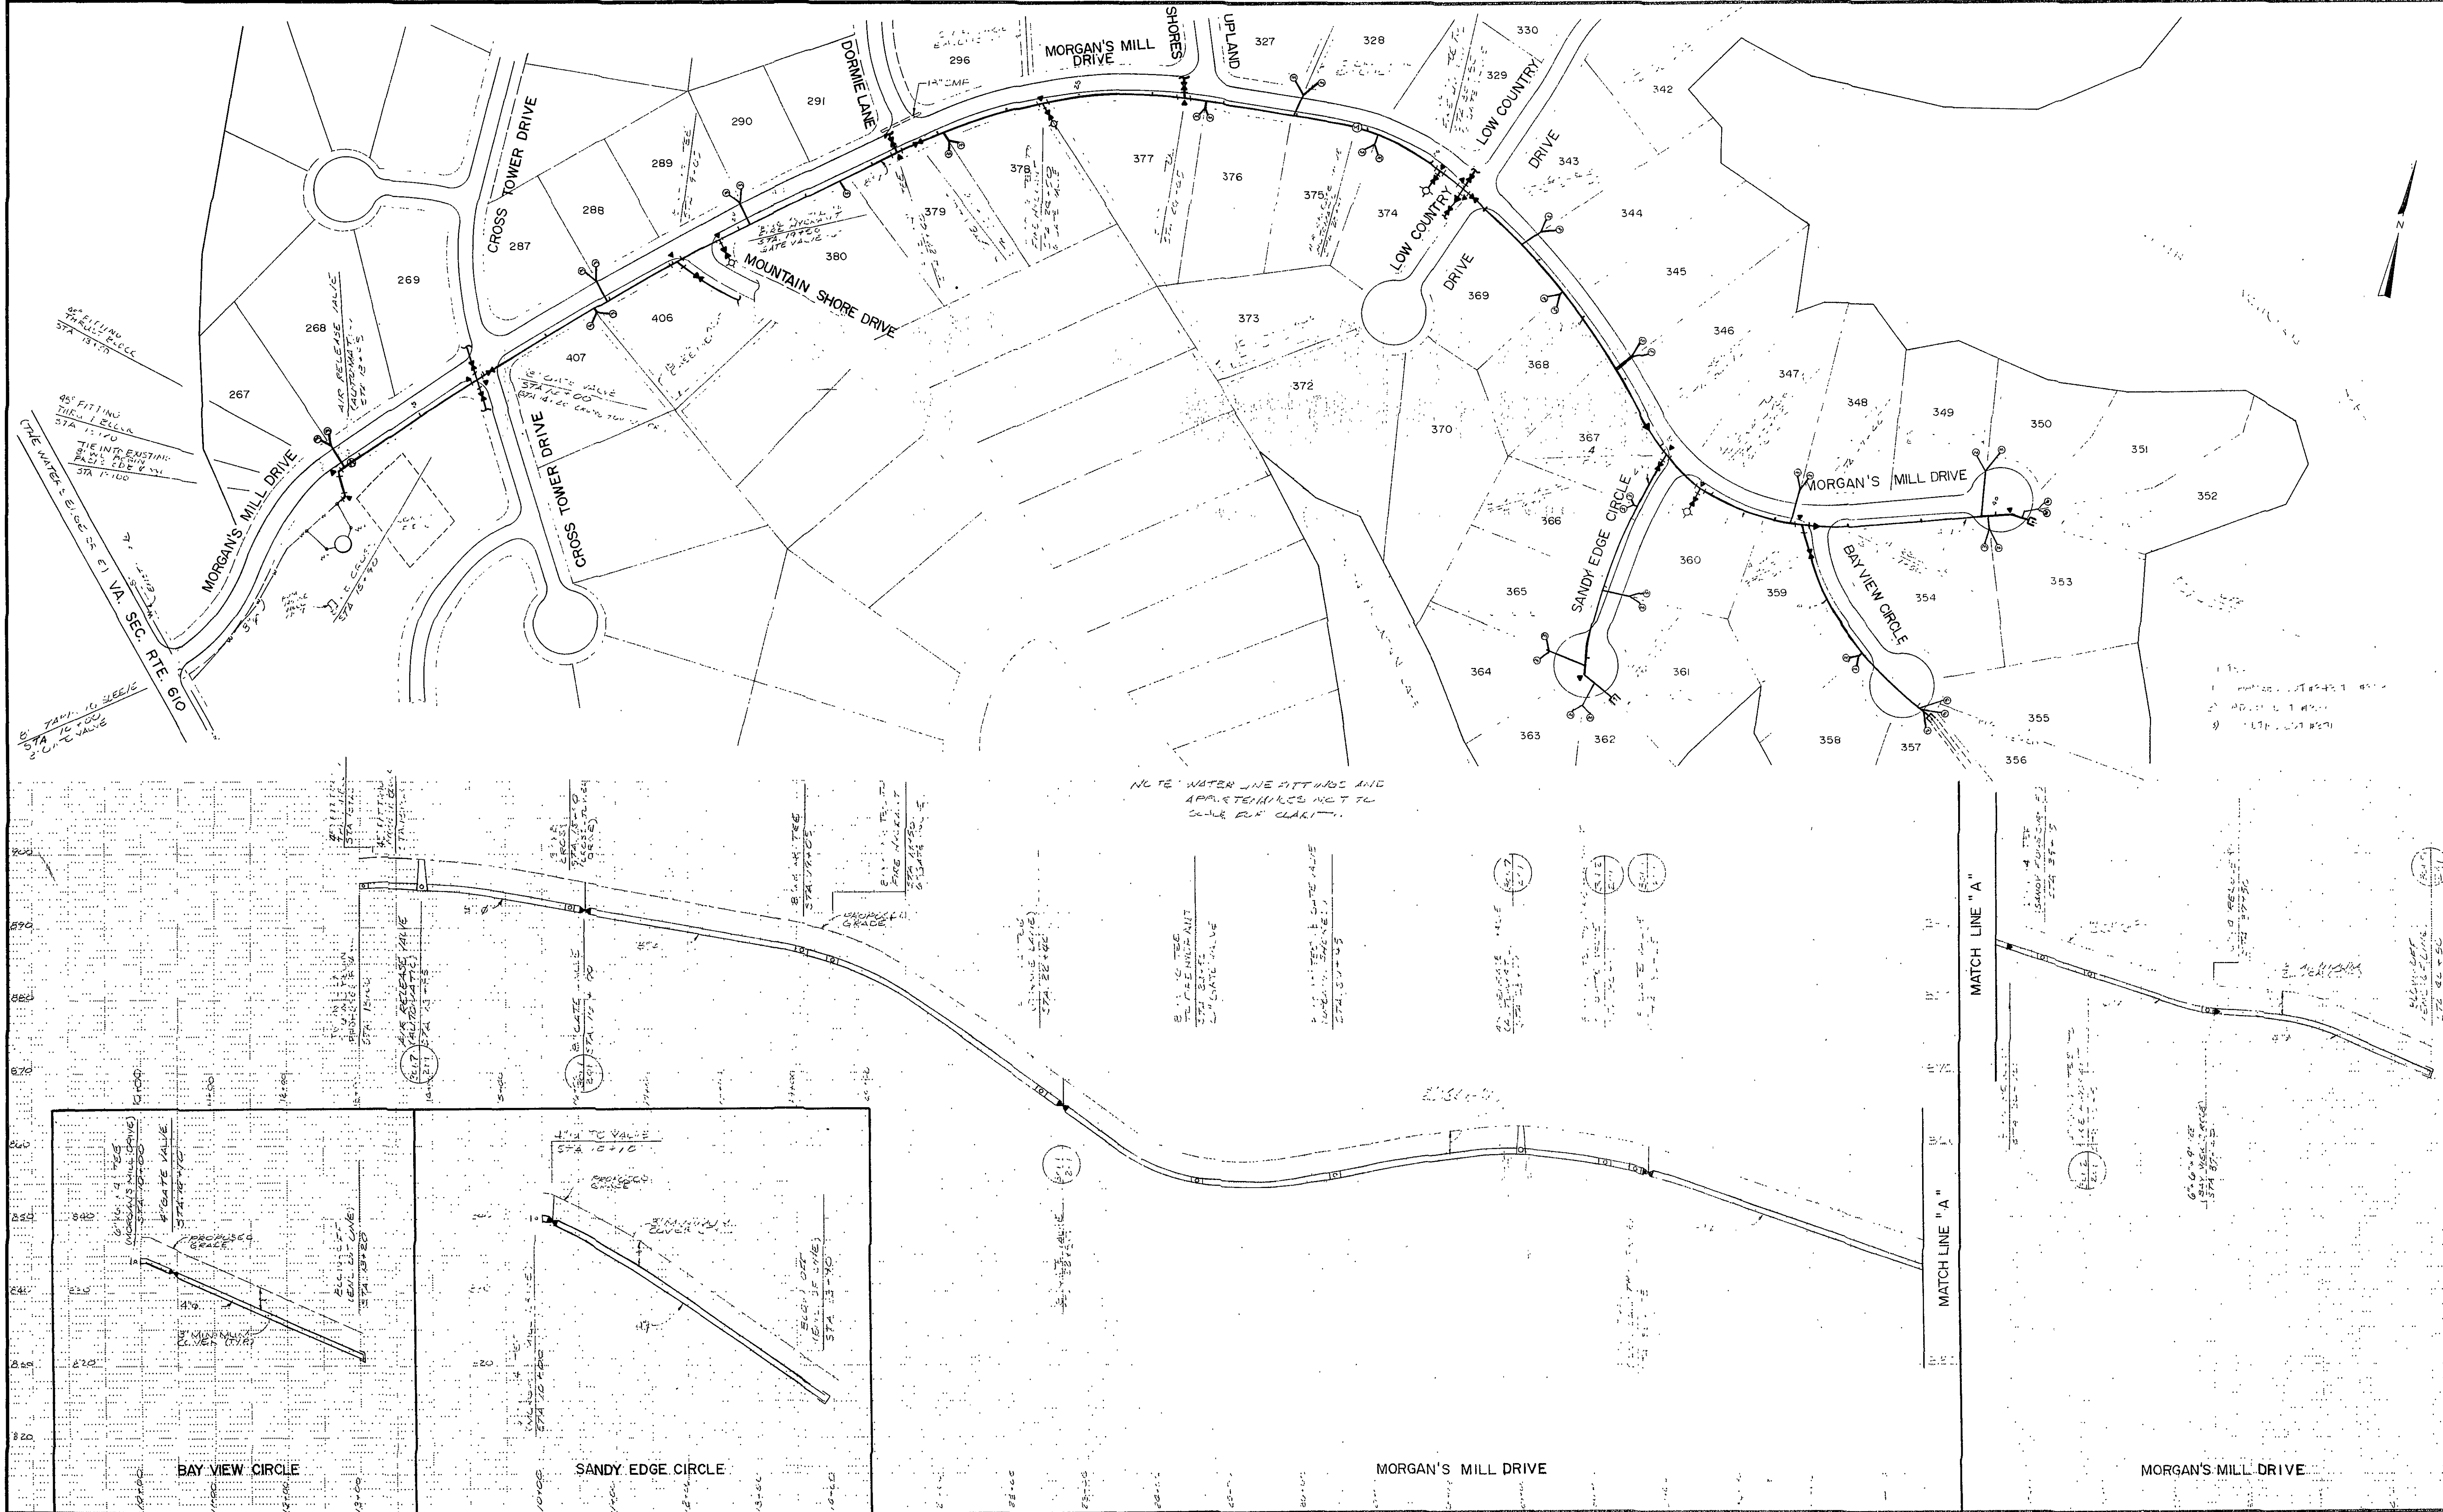

OLIVER INCORPORATED
Consulting Engineers • Environmental Laboratories
1116 SOUTH MAIN STREET
BLACKSBURG, VIRGINIA 24060
(703) 552-5548

Designed PBH
Drawn CWC/OPM
Checked KEM

1" = 10'-0" VERT.
Scale 1" = 100'-0" HORIZ.
Job No. 10980
Date SEPT. 20, 1988

**THE WATER'S EDGE
WATER DISTRIBUTION SYSTEM**

PLAN AND PROFILE

Rev.	Description	Date	By
2	REVISED - LOT REVISIONS	7/07/89	PBH
1	DESIGN ISSUE - SECTION VI	11/15/88	RMR
0	DESIGN ISSUE - SECTION VI	9/20/88	KEM

Sheet No.
201
File No.