



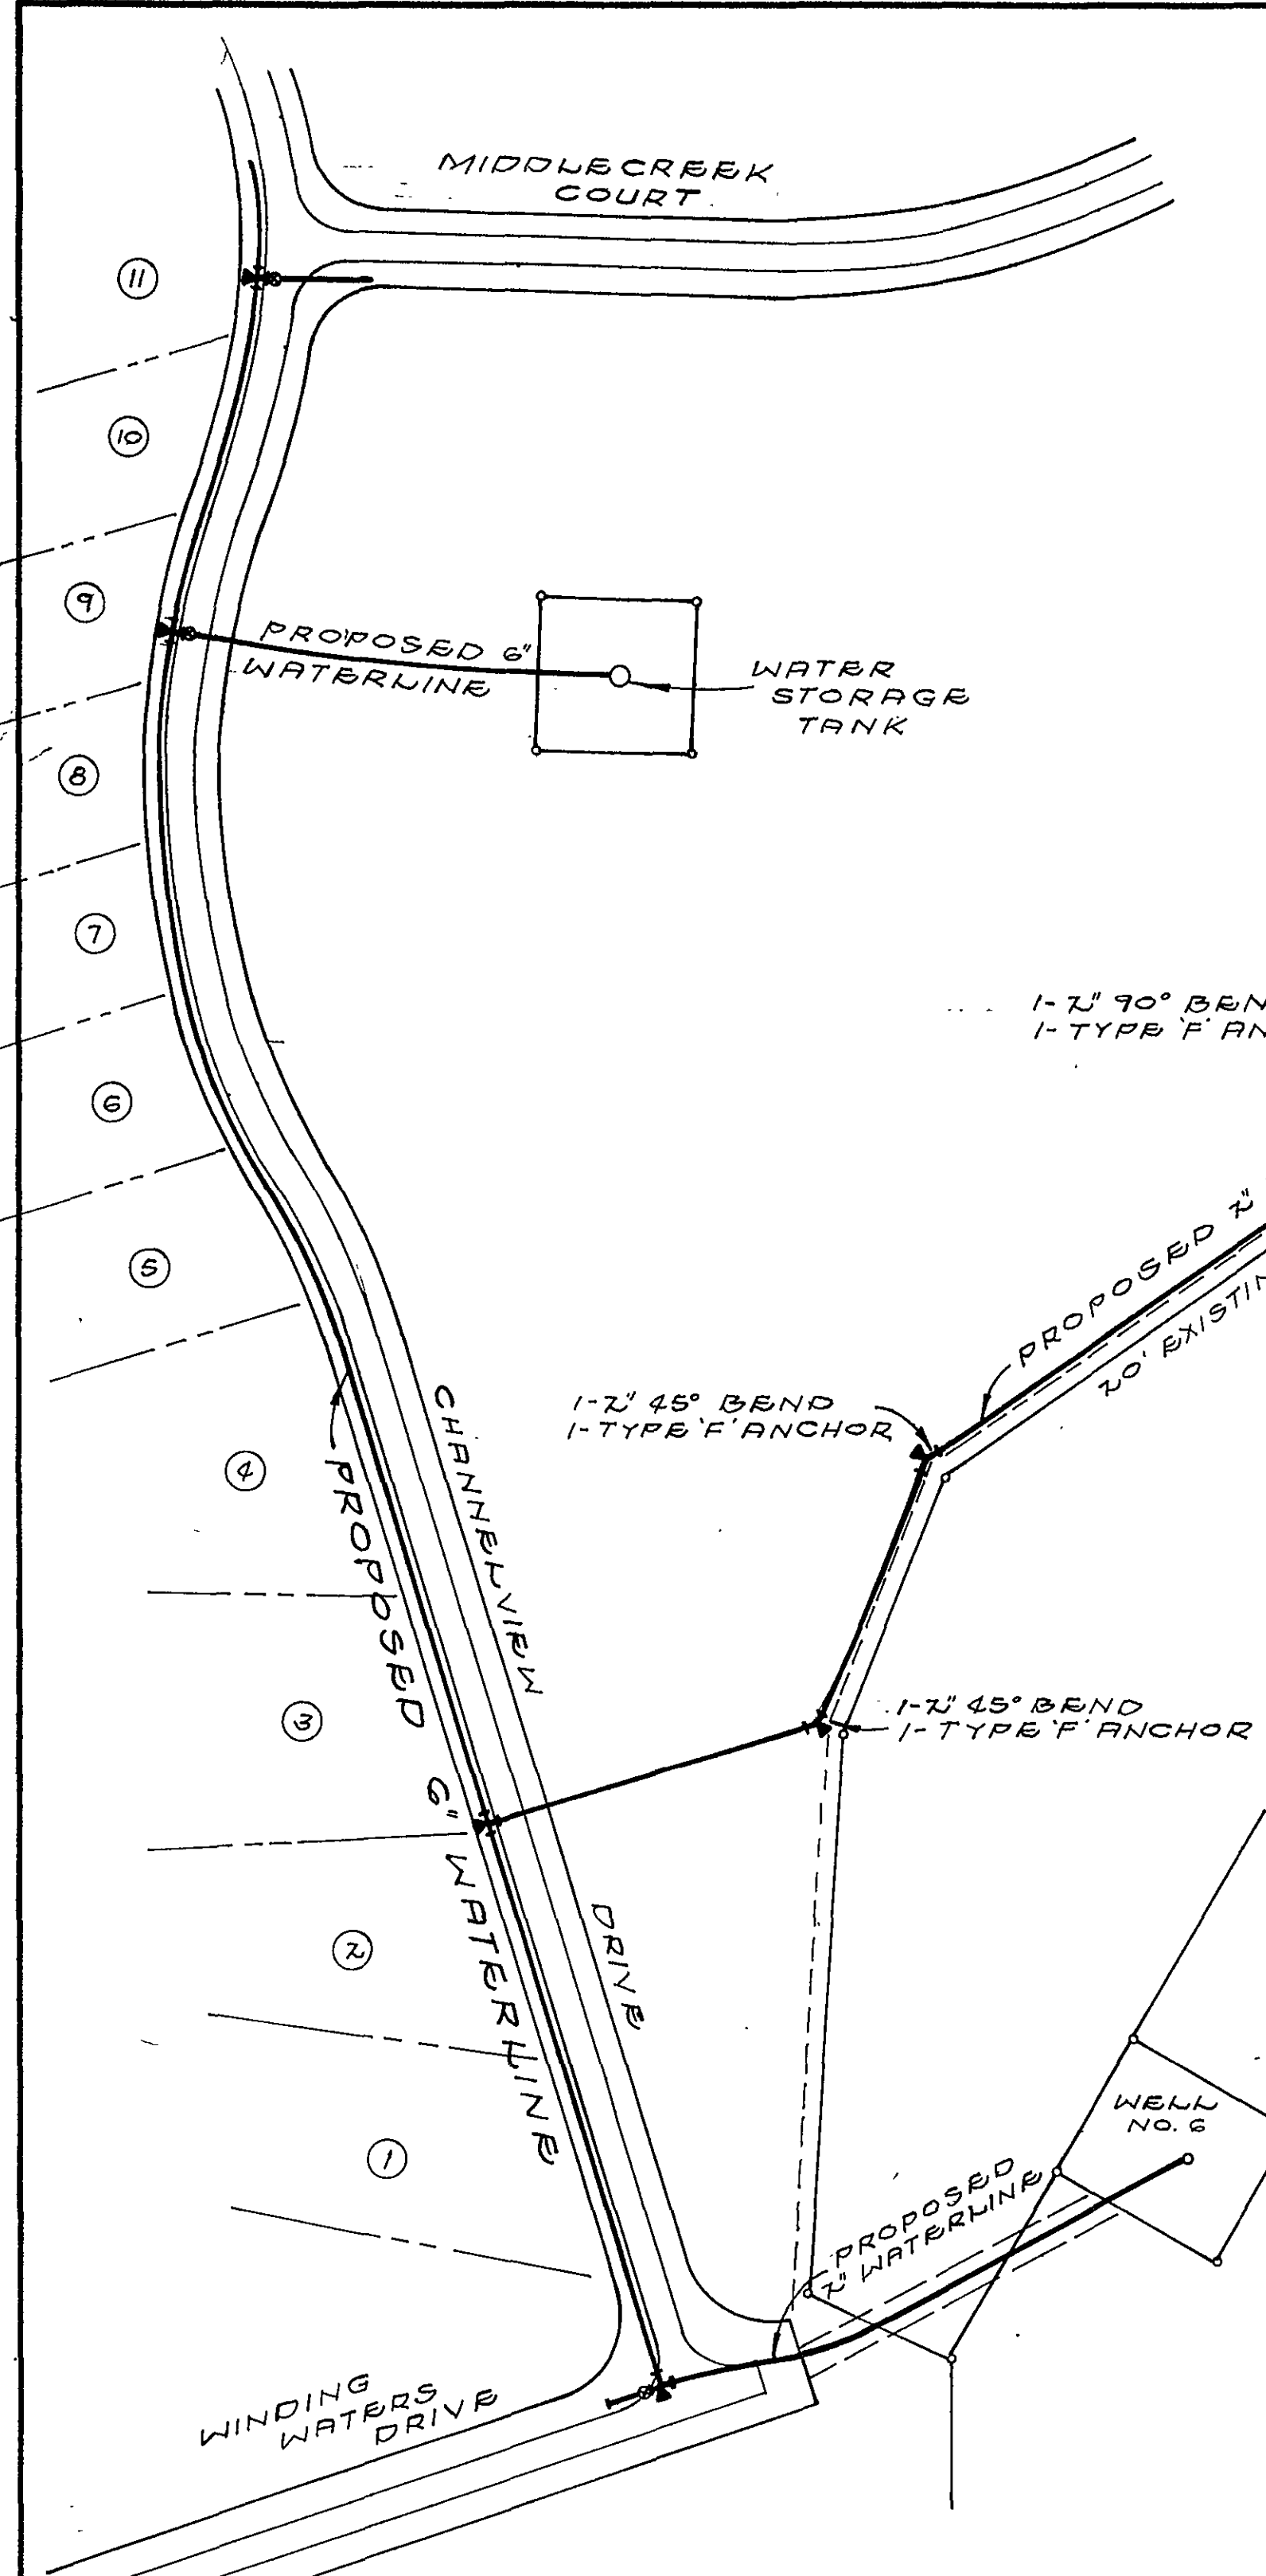


SITE PLAN
SCALE: 1"=100'

NOTES:


1. ALL PIPING BELOW GRADE AND UNDER CONCRETE SLAB SHALL BE GALVANIZED STEEL OR DUCTILE IRON.
2. ALL EXPOSED PIPING SHALL BE INSULATED TO PREVENT FREEZING TO A DEPTH 3' BELOW GRADE W/ CERTAINTIED® WRAP OR APPROVED EQUAL.
3. CUT OR FILE ALL THREADS FROM DISCHARGE OF SAMPLE TAPS.
4. GALVANIZED STEEL OR DUCTILE IRON PIPE SHALL BE USED FOR ALL ABOVE-GRADE PIPING AT THE WELL AND AT THE STANDPIPE STORAGE TANK.

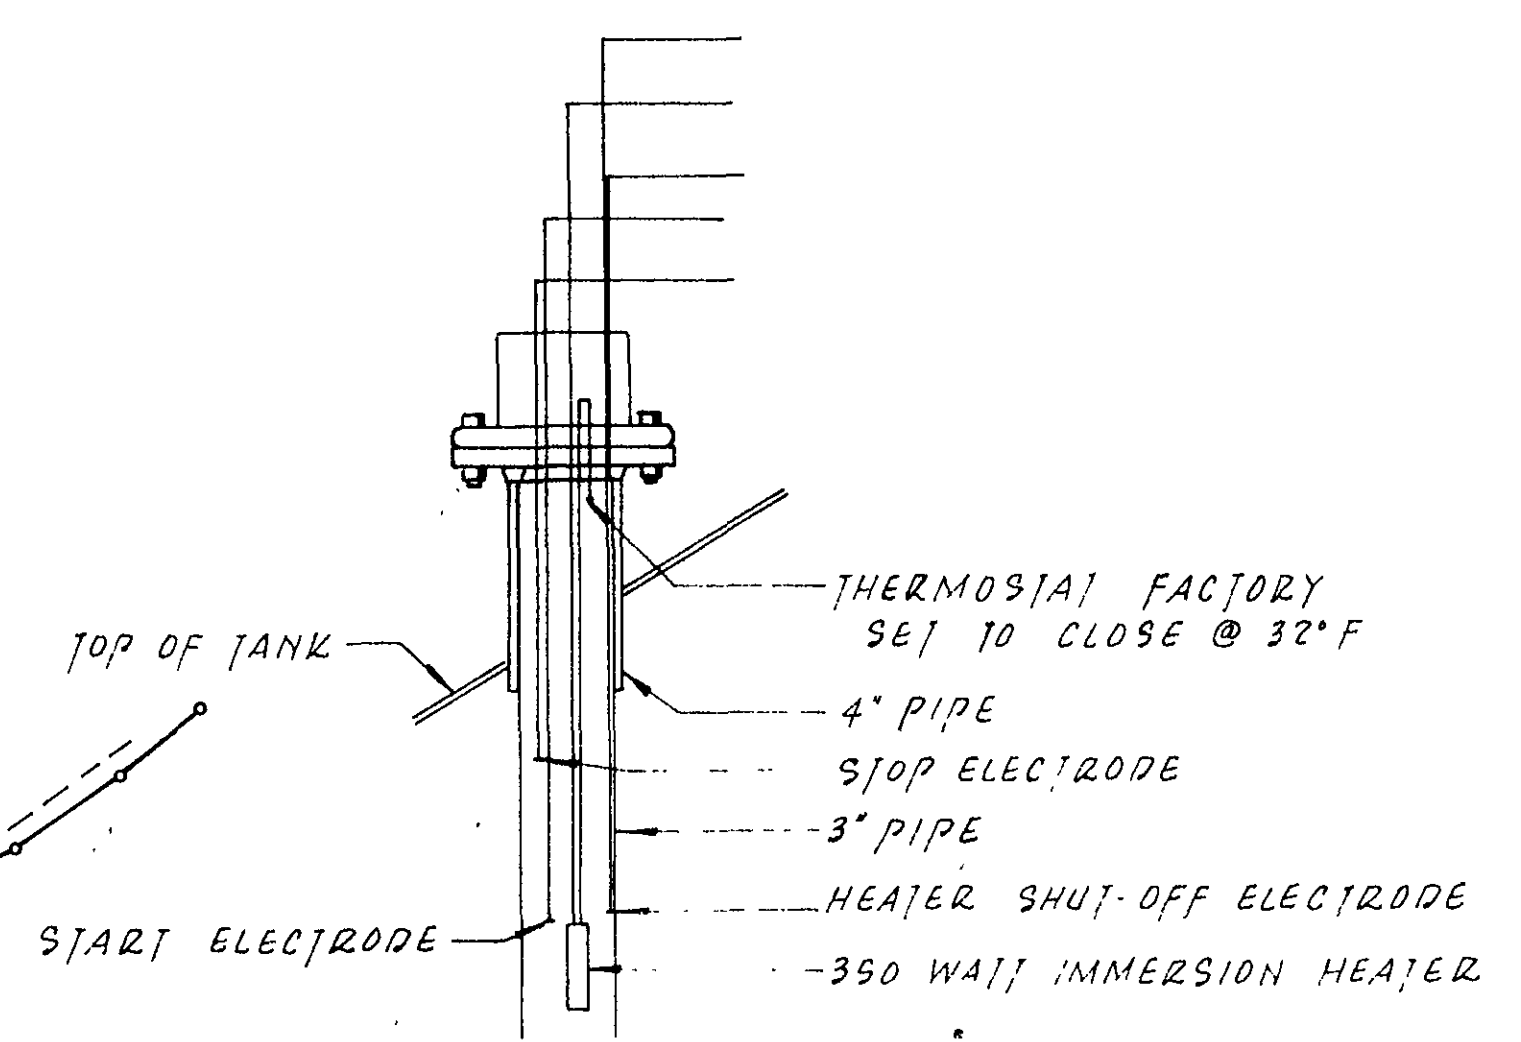


**ELECTRODE HOLDER @
WATER STORAGE TANK**

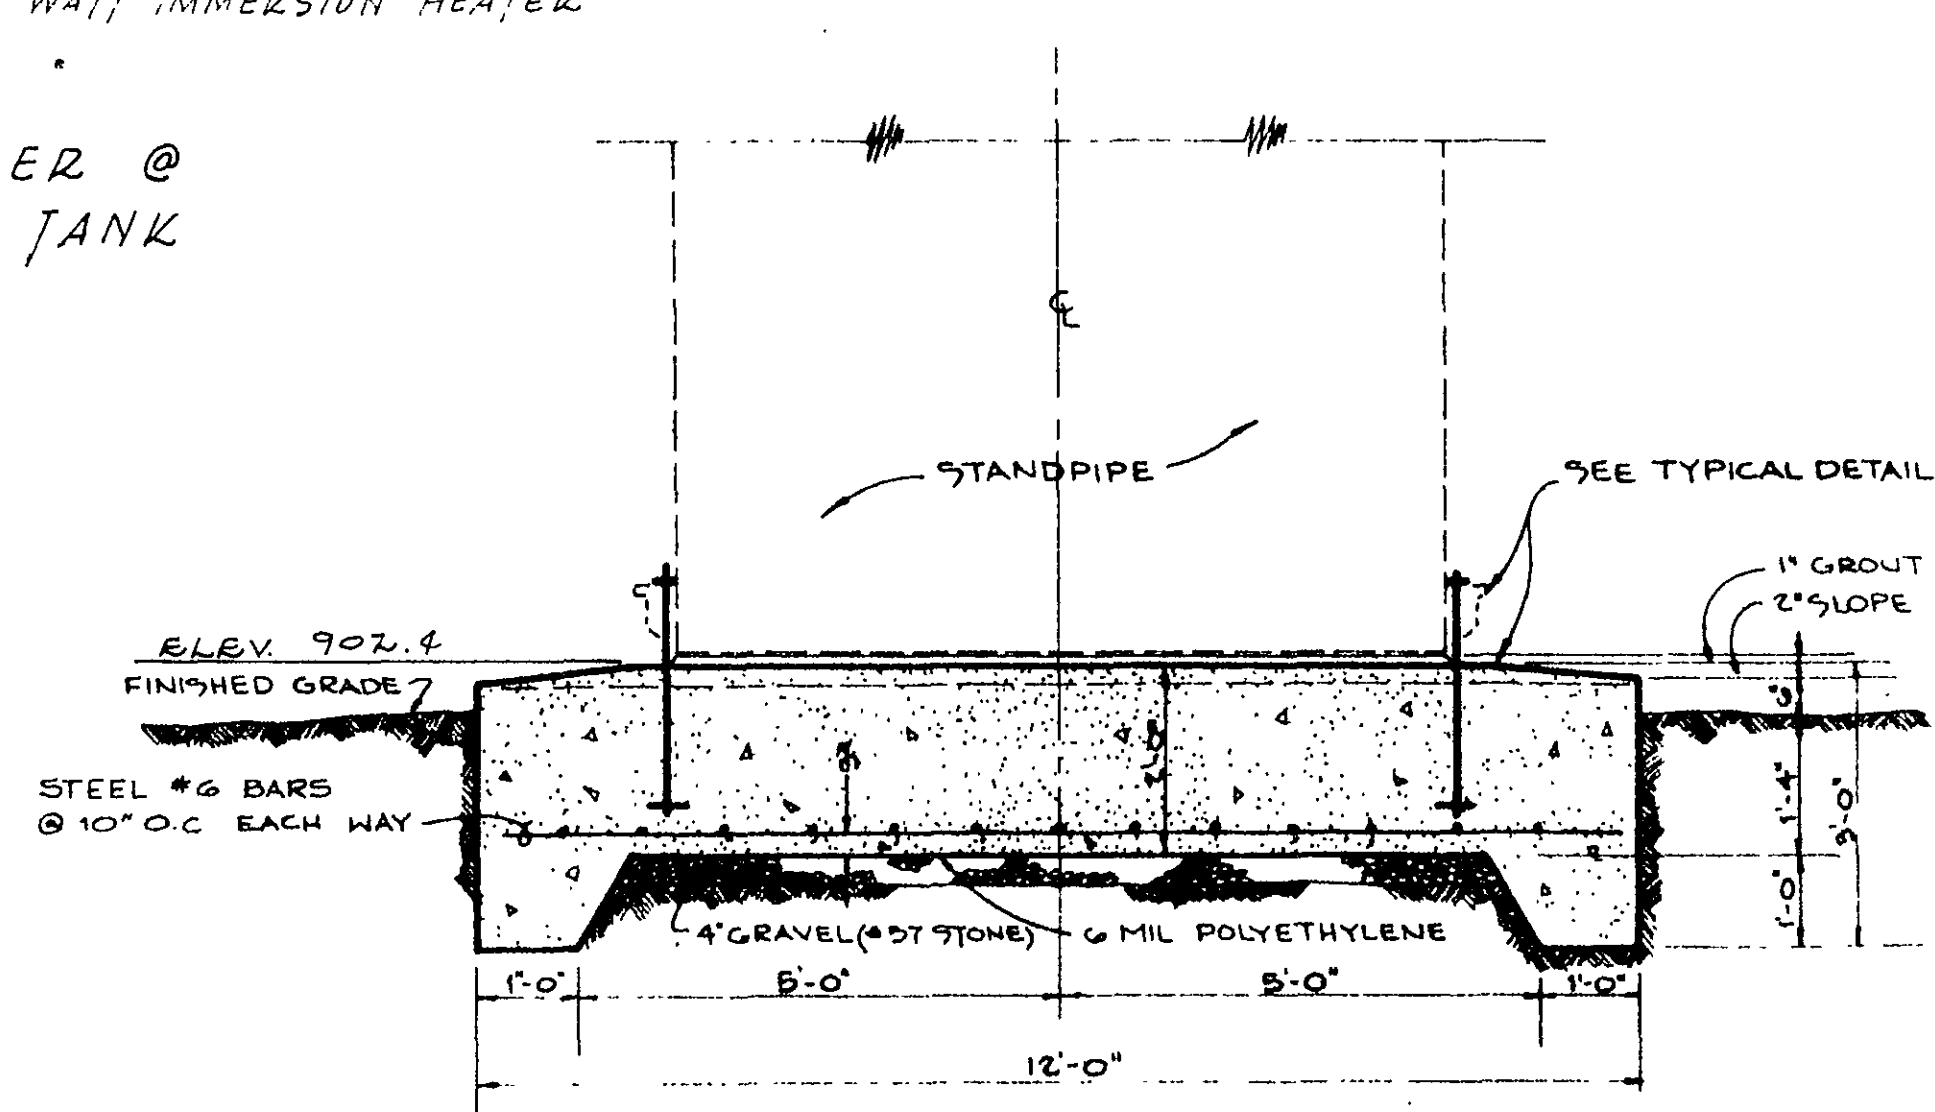


**SECTION
NO SCALE**

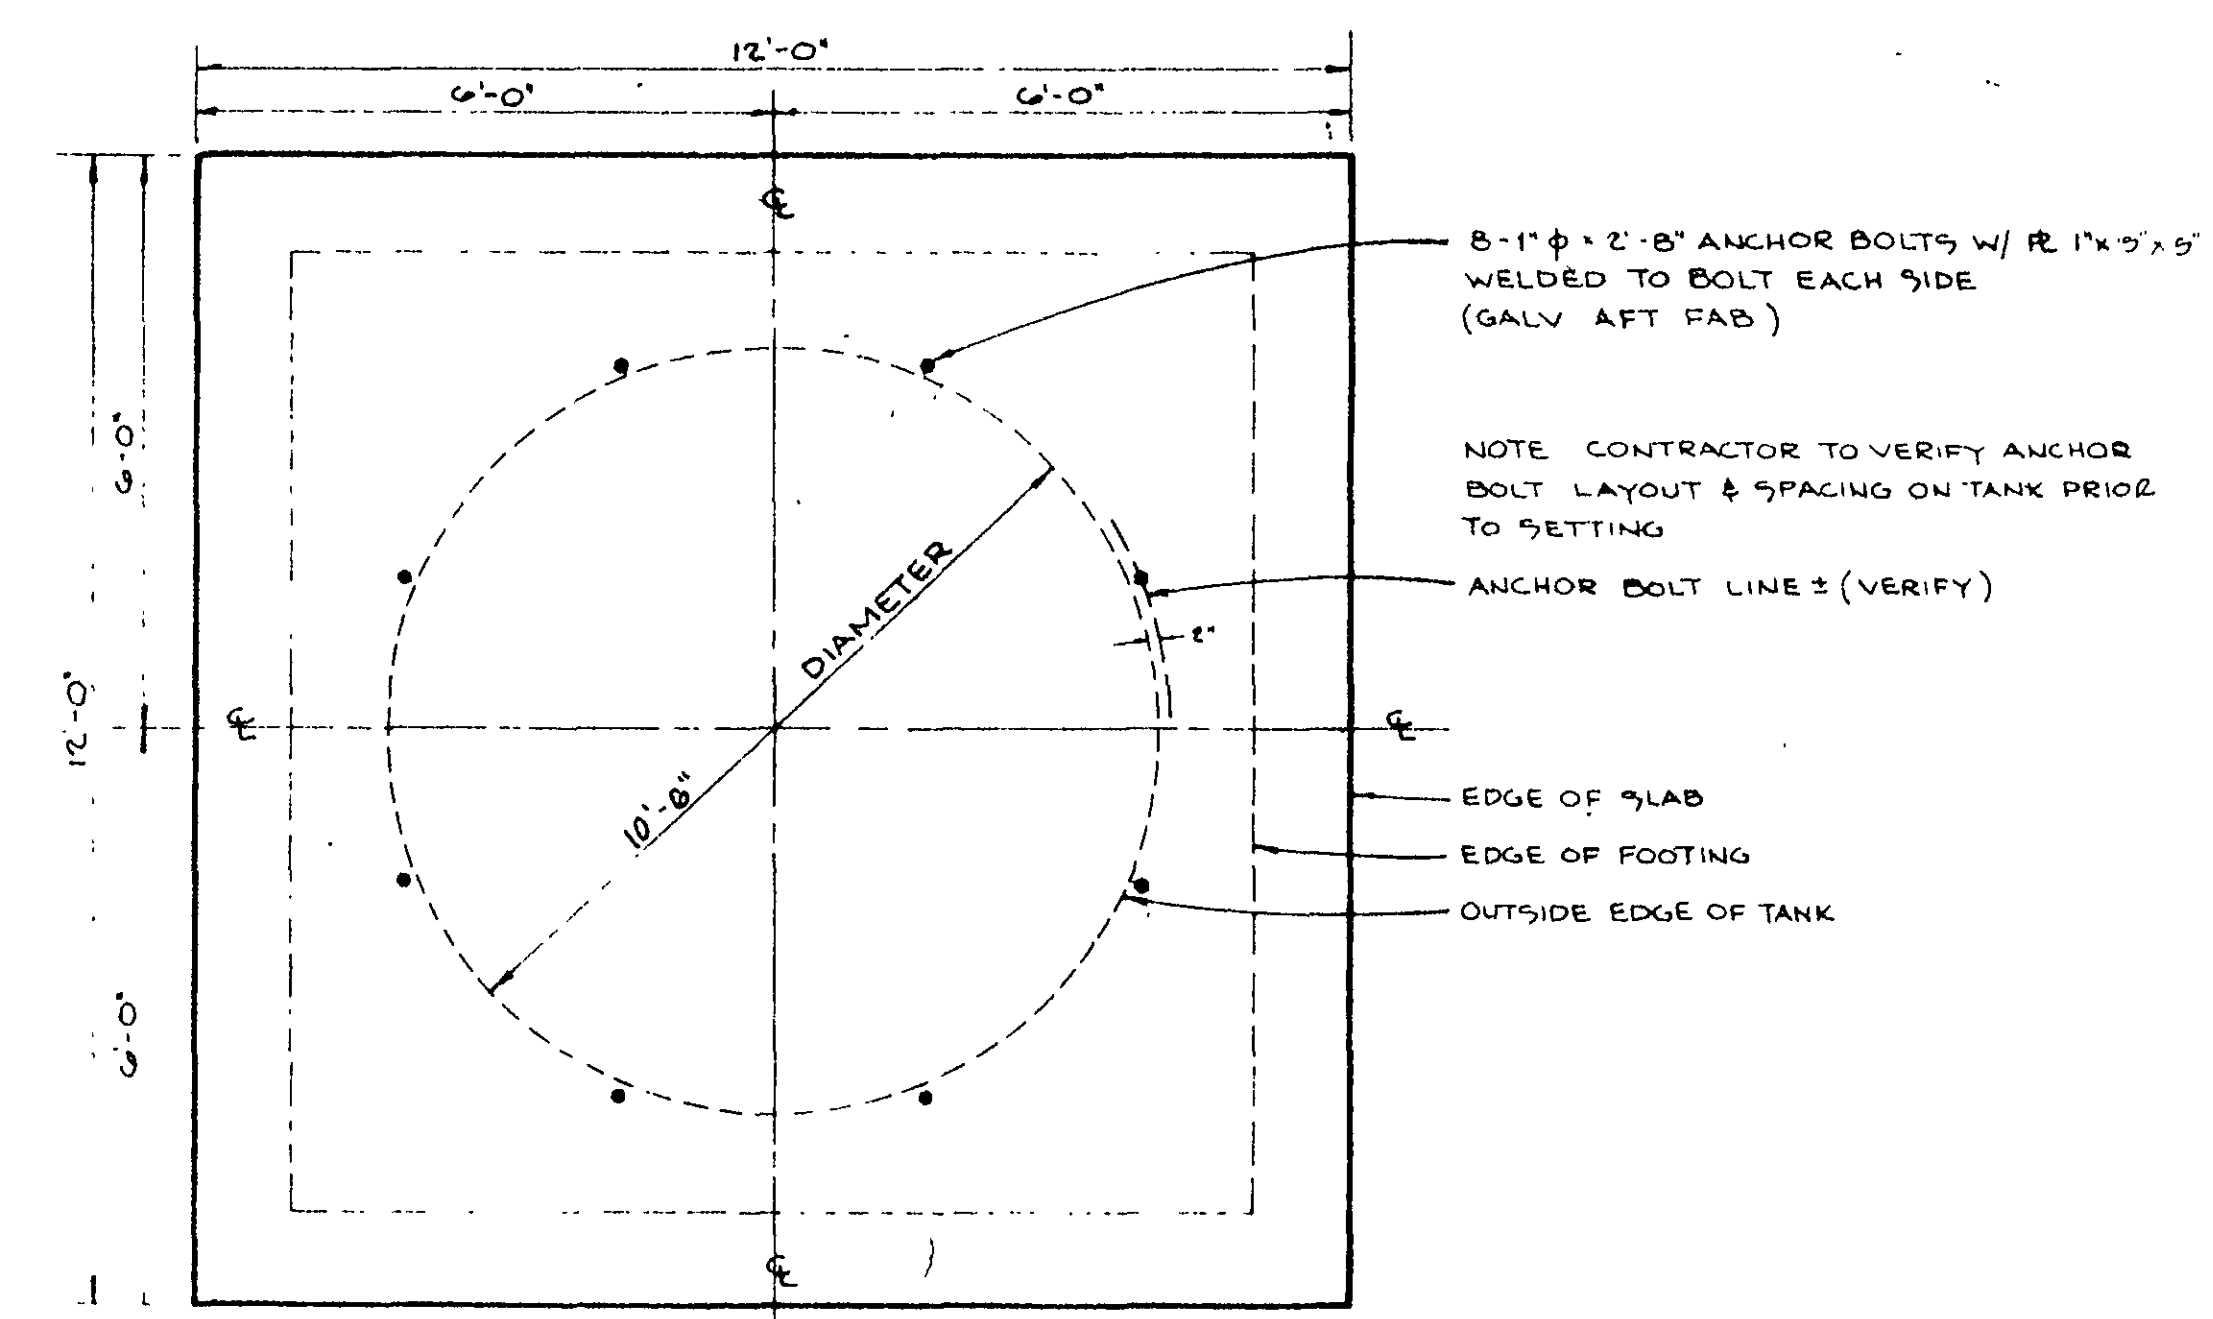


**FOUNDATION PLAN
NO SCALE**

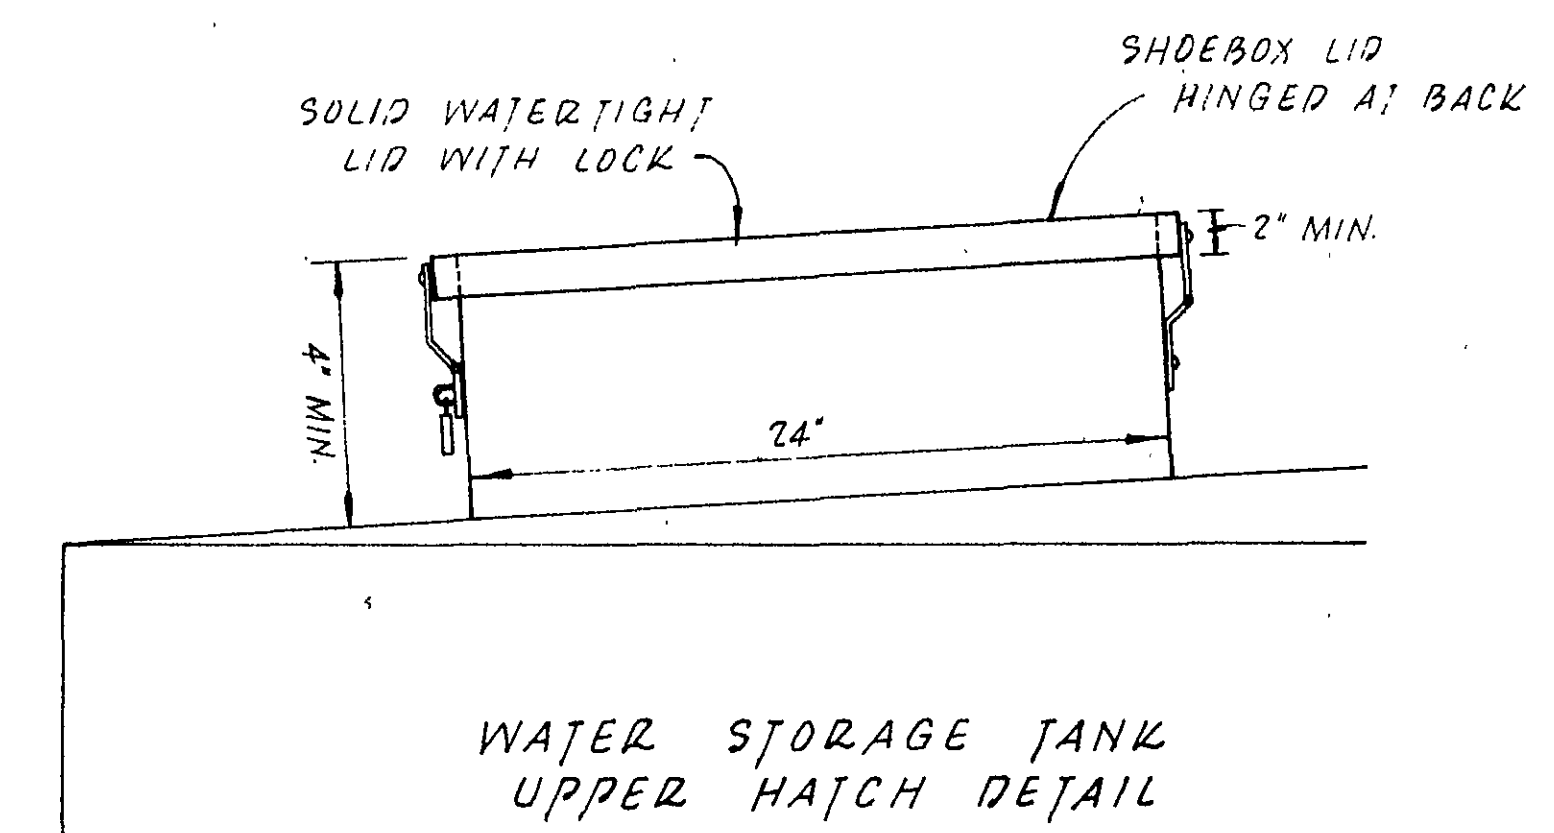


**WATER STORAGE TANK
UPPER HATCH DETAIL**

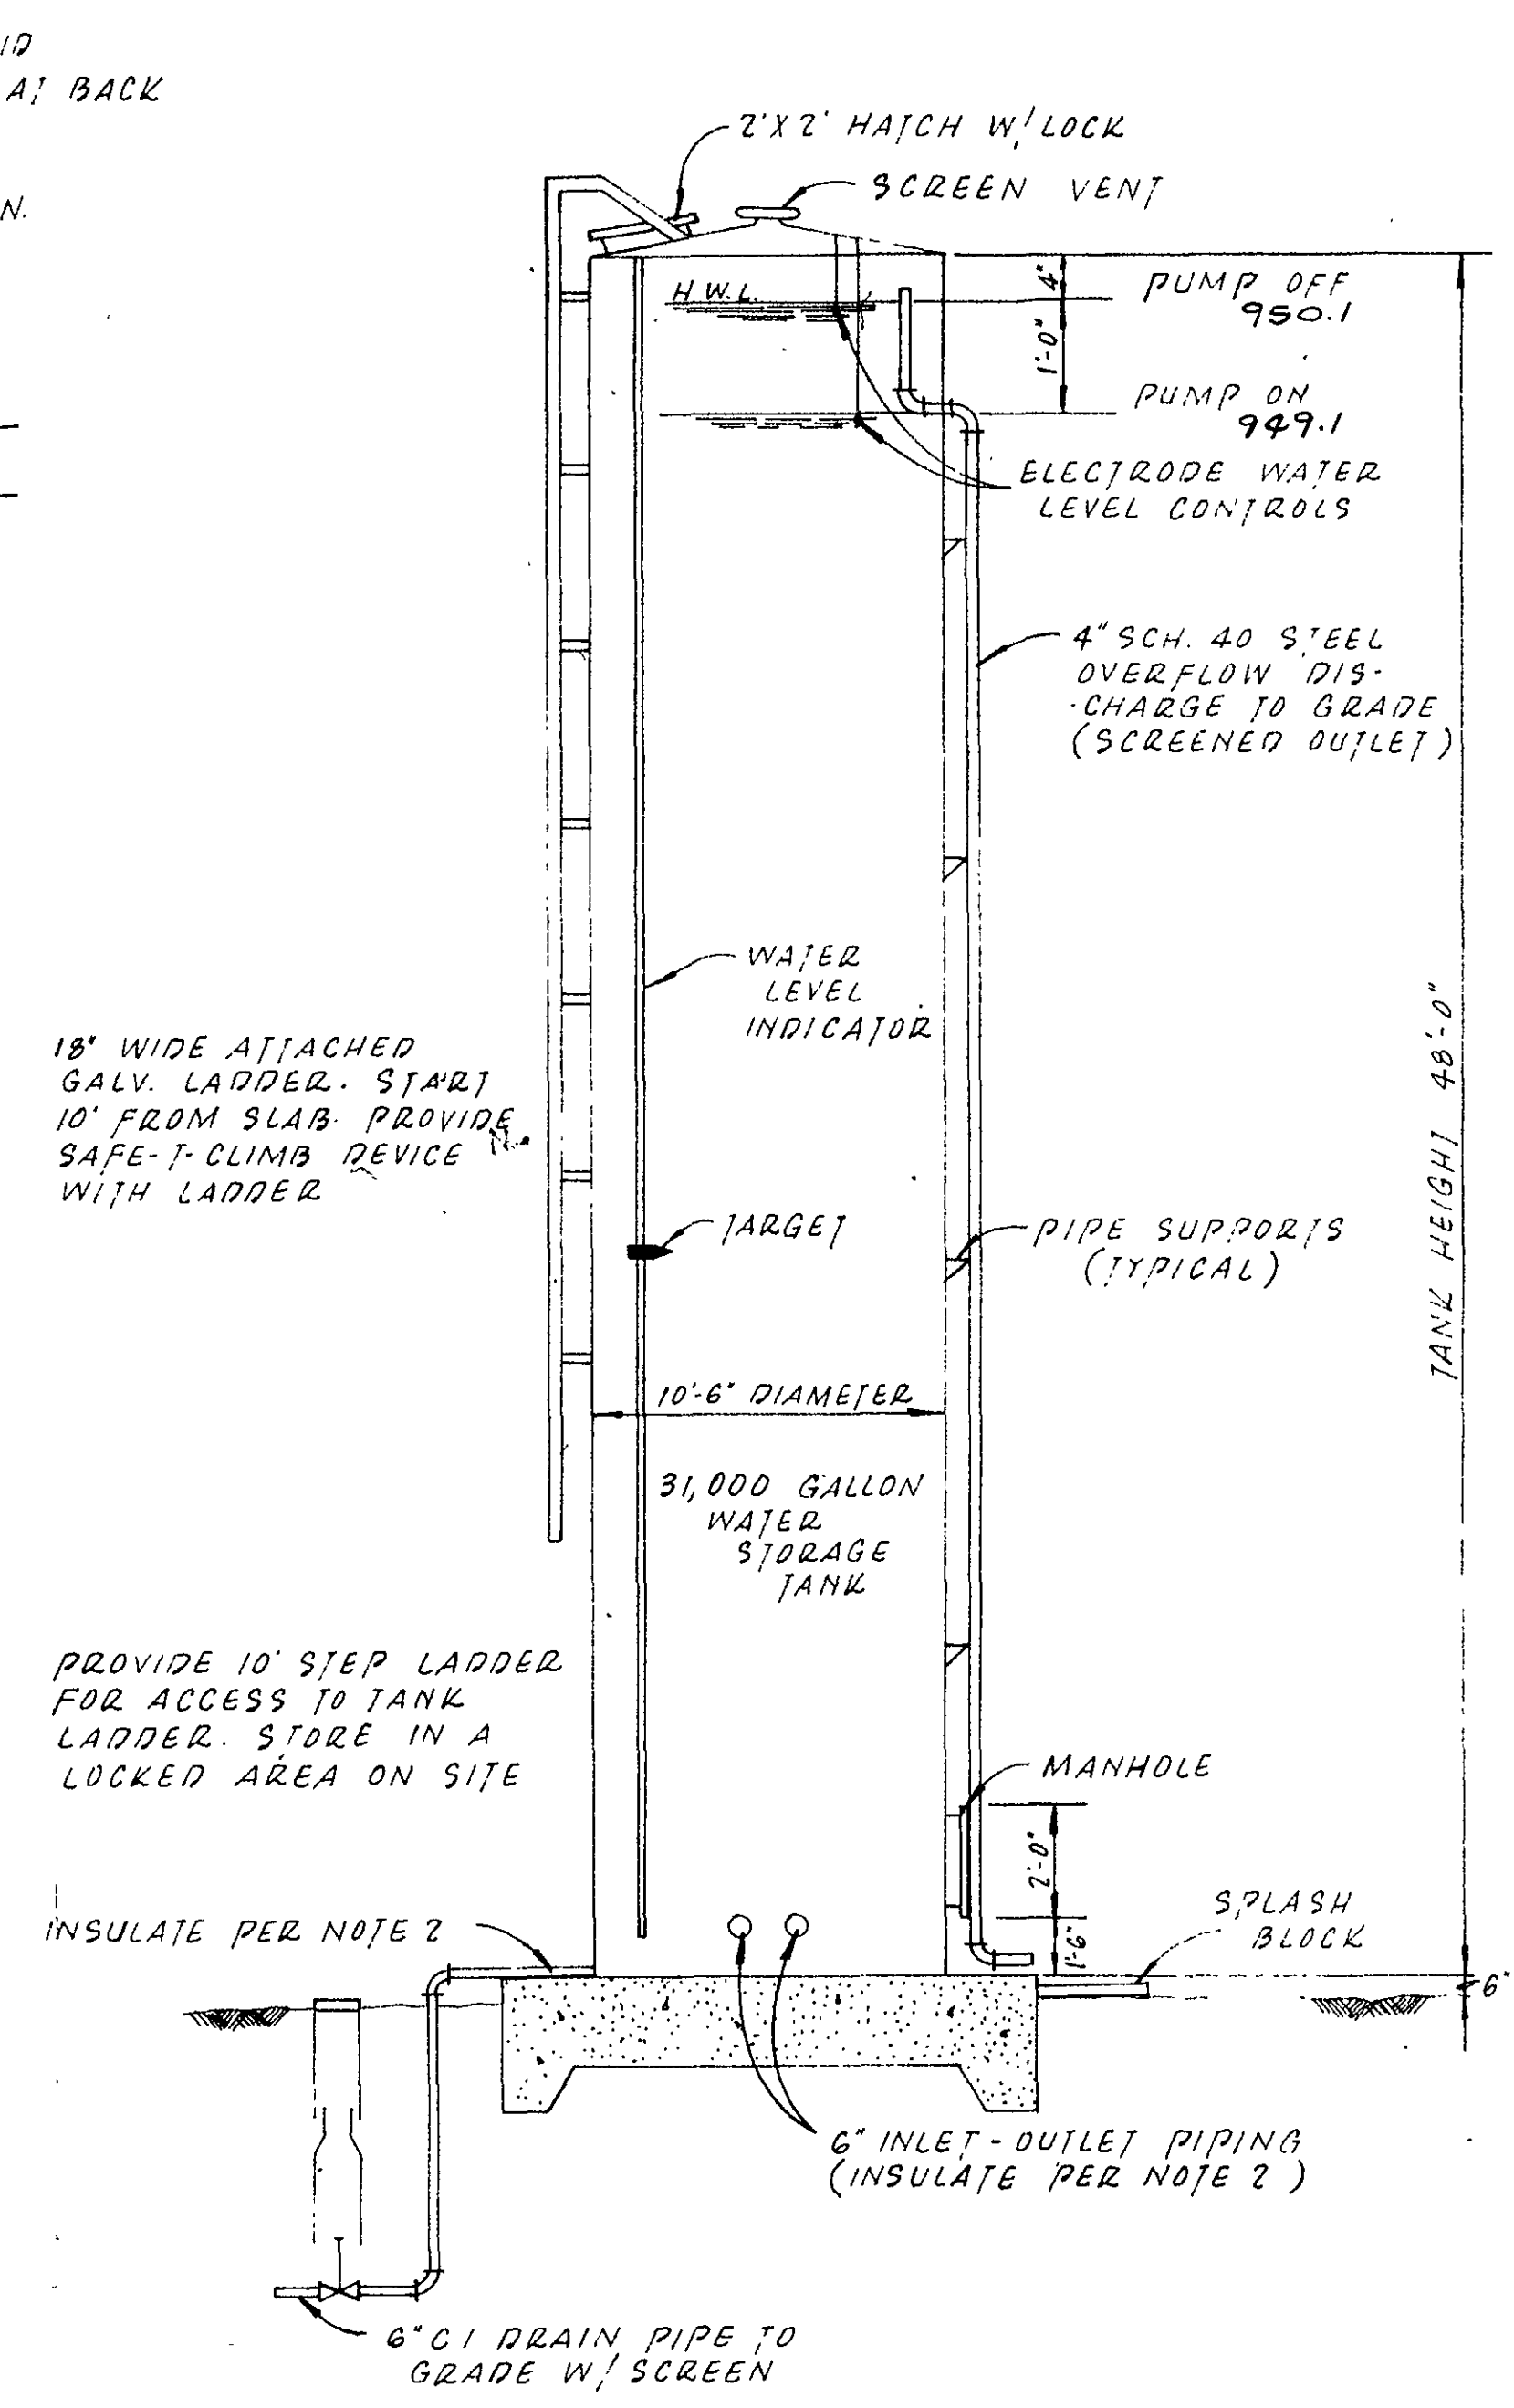

WATER STORAGE TANK ELEVATION

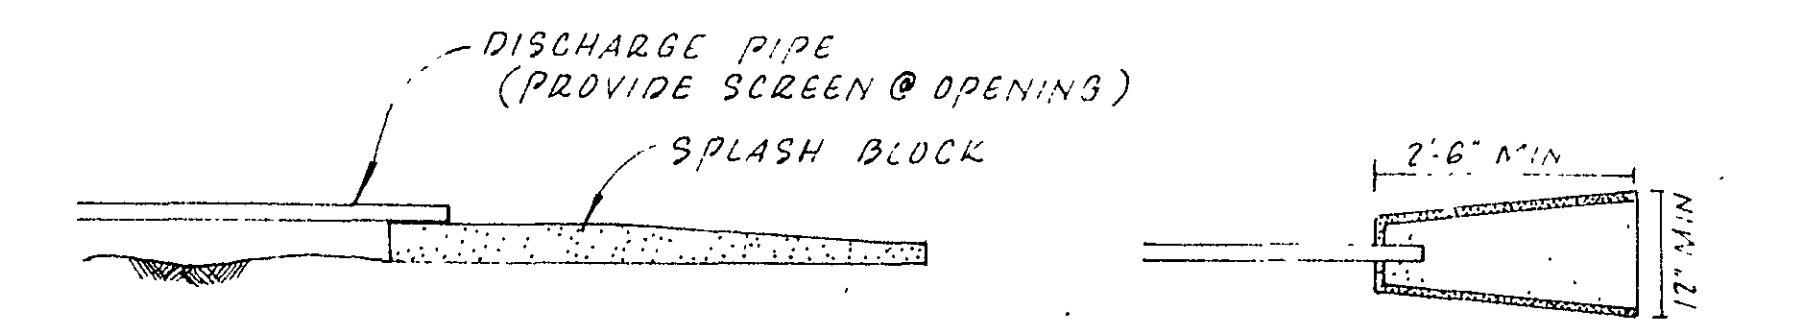

**EROSION CONTROL
ALL BLOW-OFFS AND DISCHARGES EMPTY INTO
SPLASH BLOCKS**

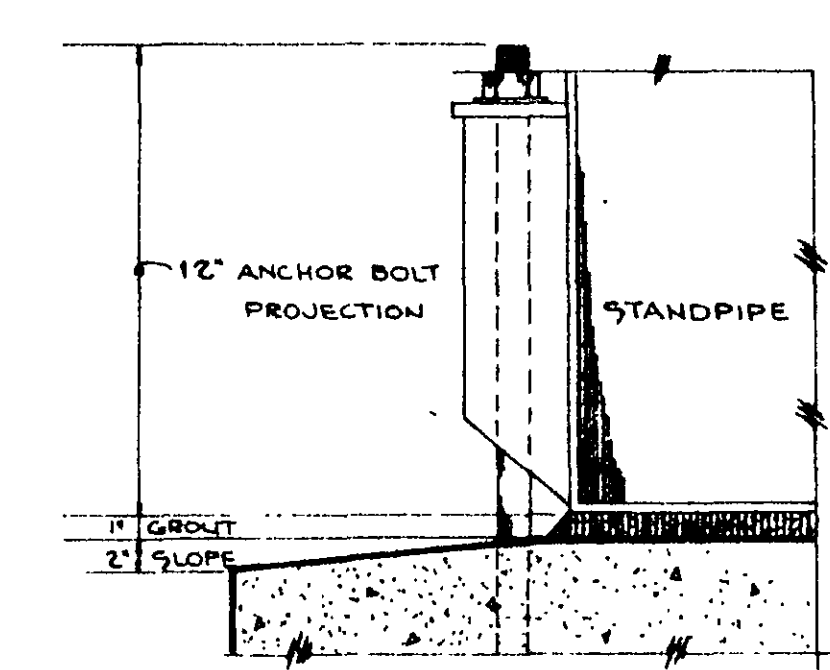

**TYPICAL DETAIL
NO SCALE**

Berkley Howell & Assoc. ENGINEERS • SURVEYORS • PLANNERS			
SCALE	APPROVED BY:	DRAWN BY:	
DATE 4-24-87		REVISED	
WINDING WATERS CENTRAL WATER SYSTEM			DRAWING NUMBER
MISC. DETAILS			6 OF 7