




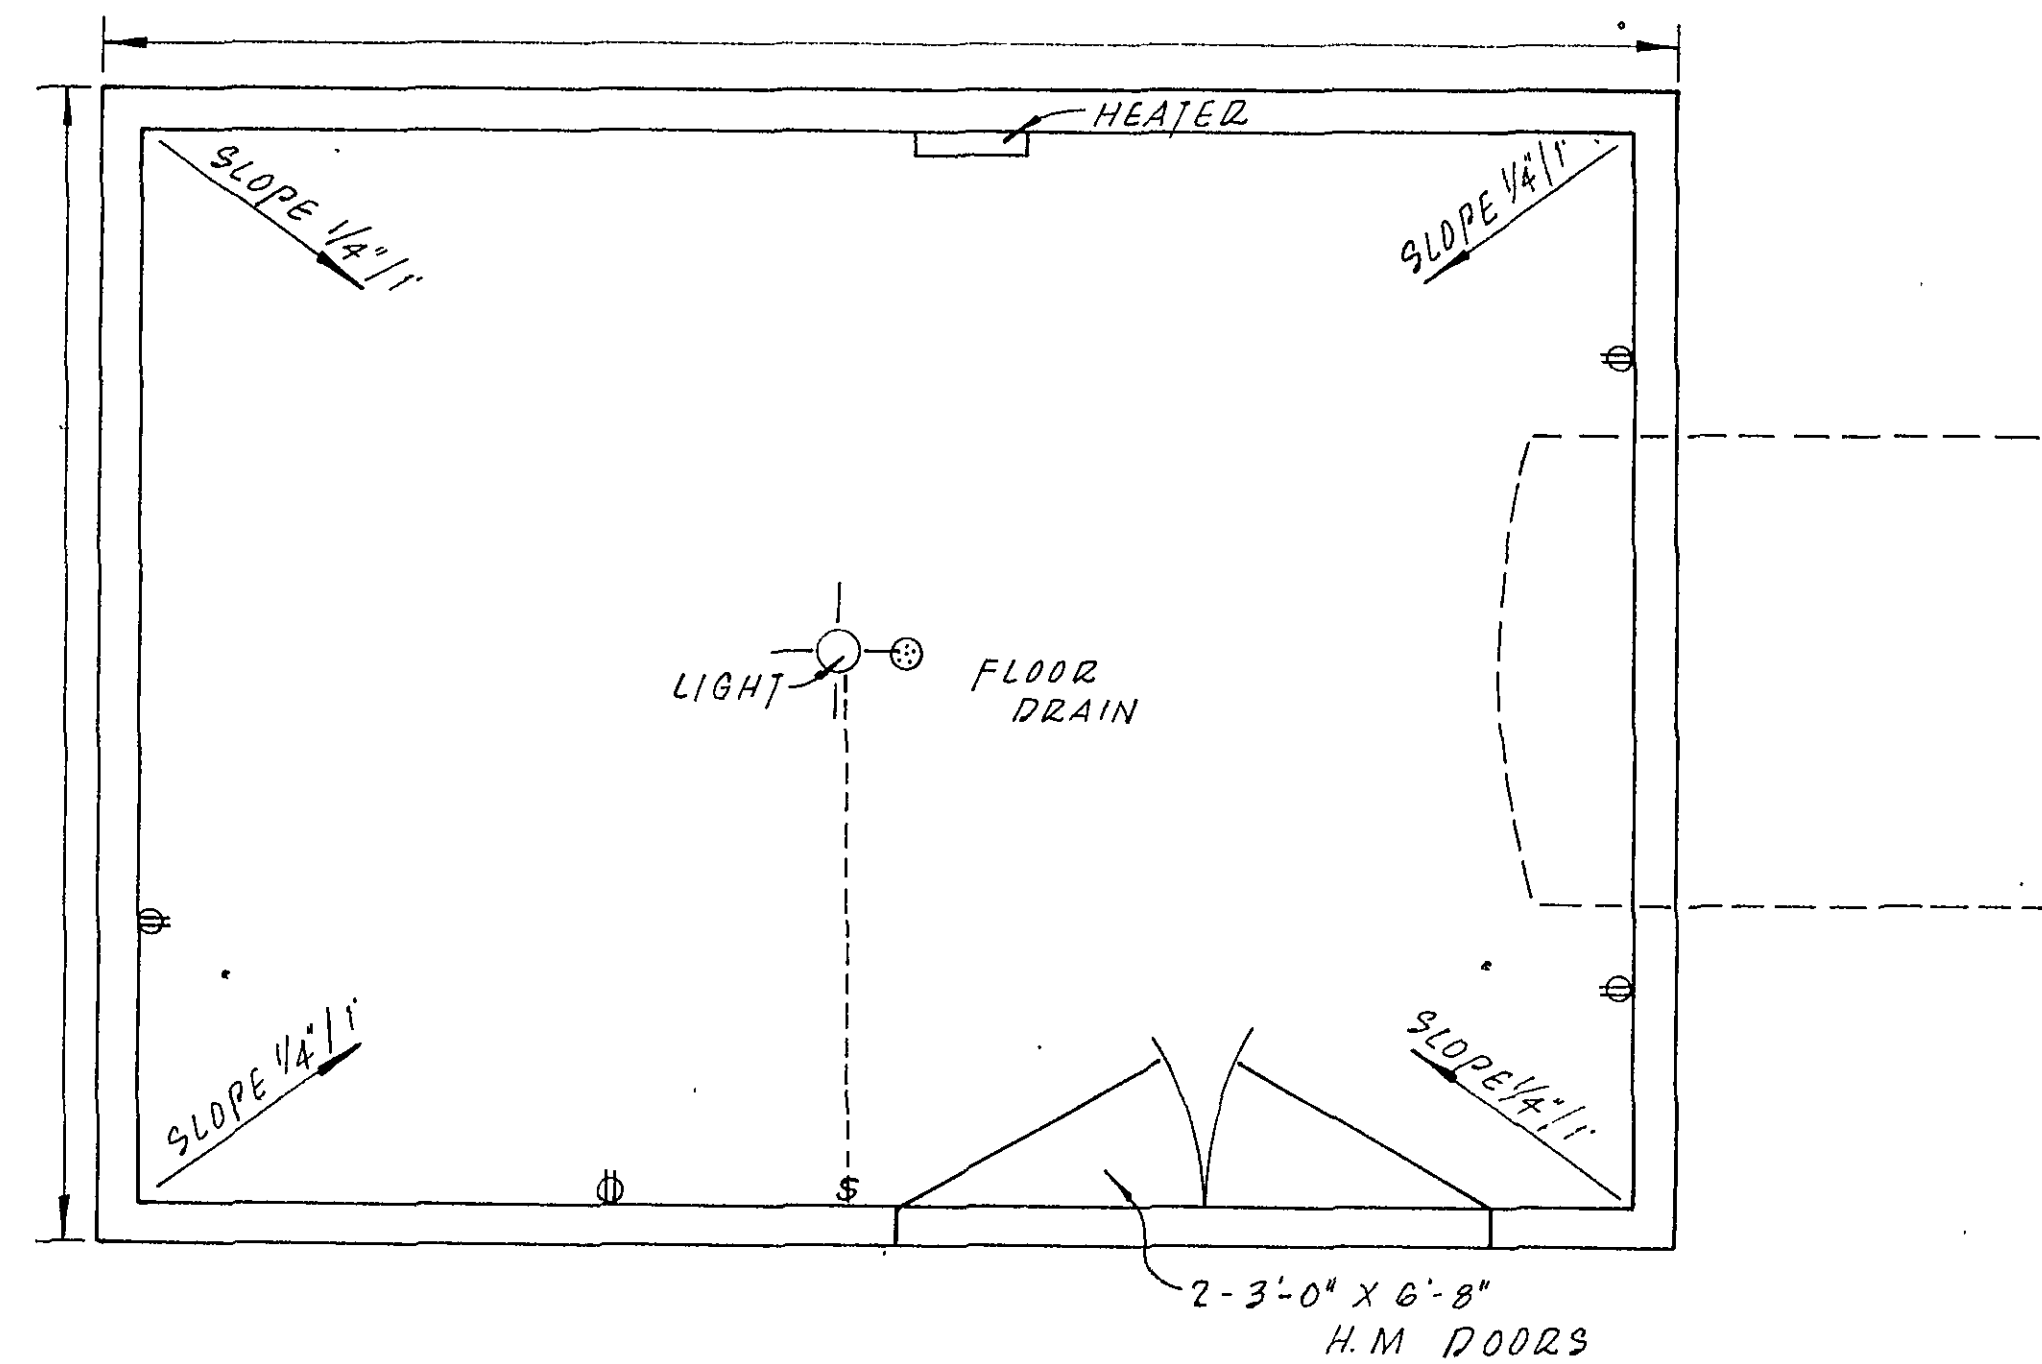


PUMP HOUSE PLAN

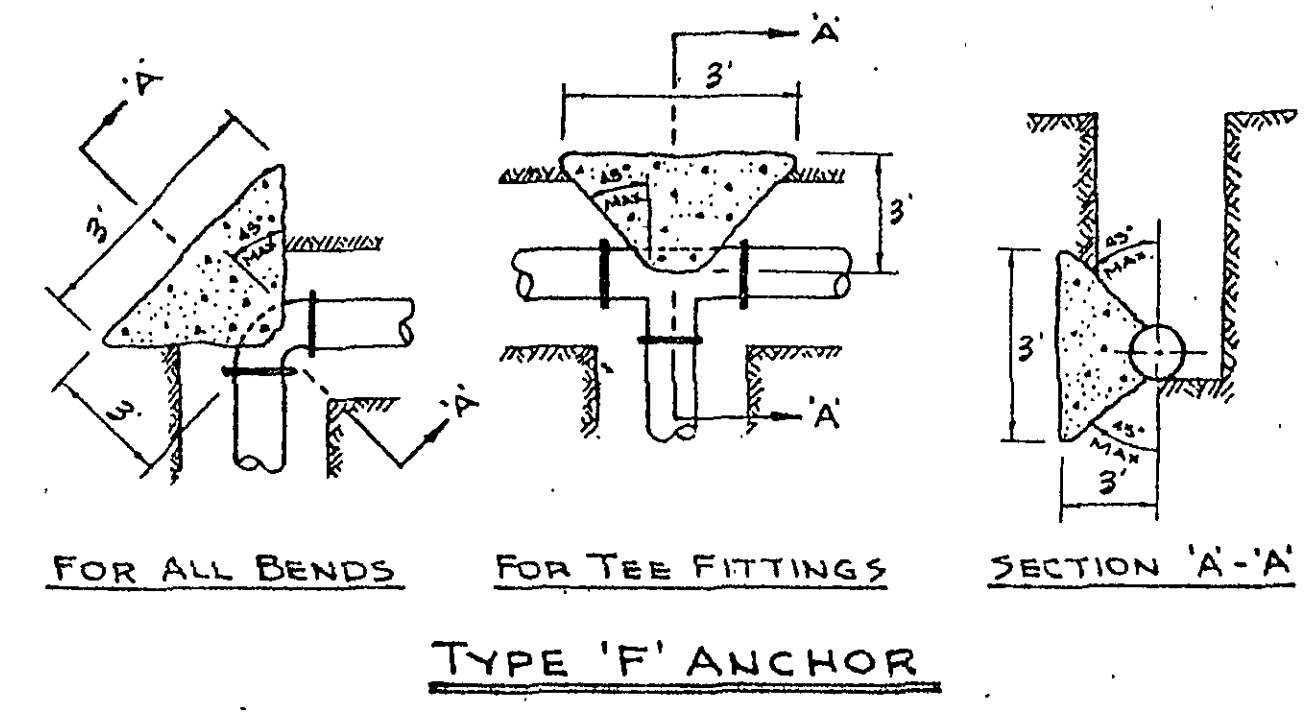


TYPE 'F' ANCHOR

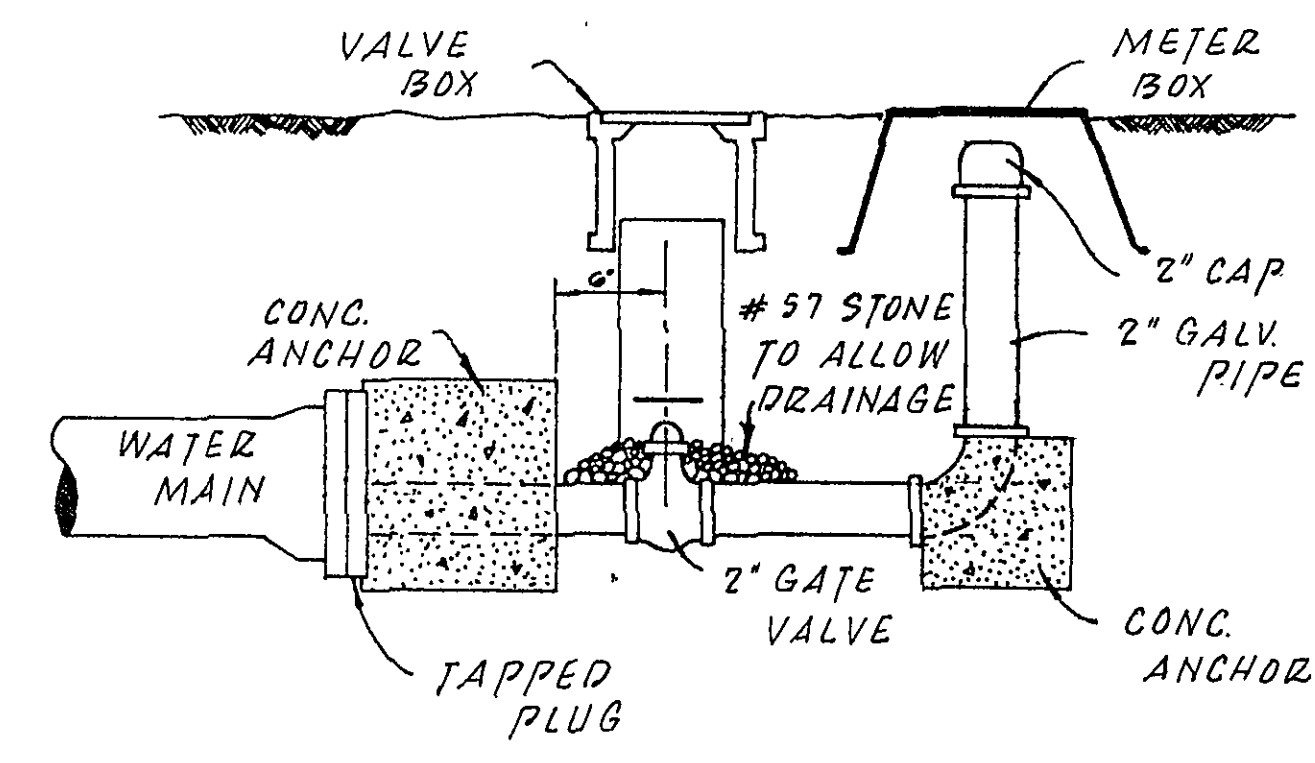


2" BLOW-OFF ASSEMBLY

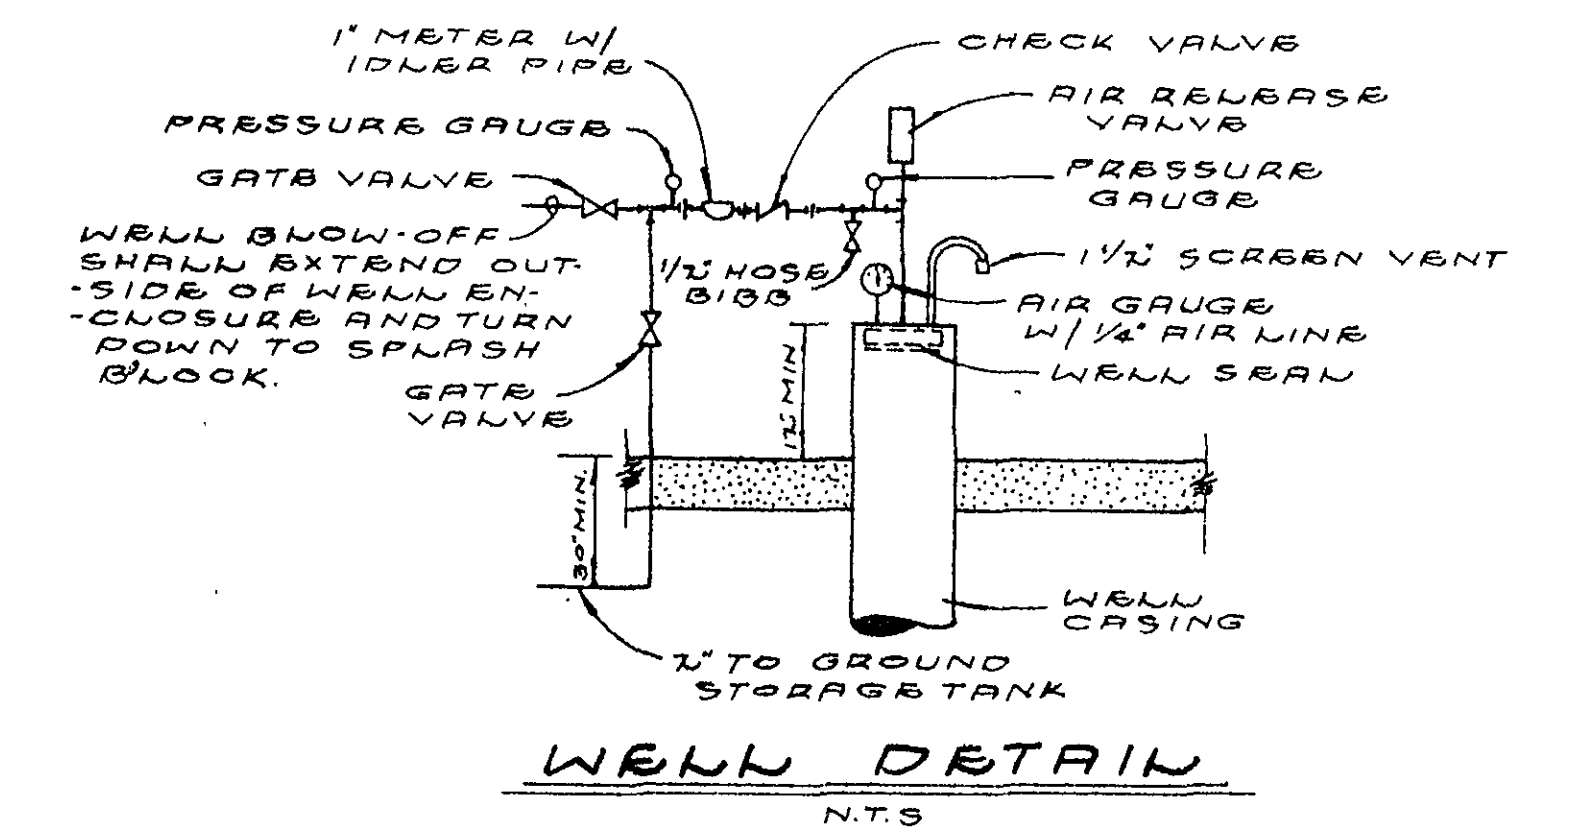


WELL DETAIL

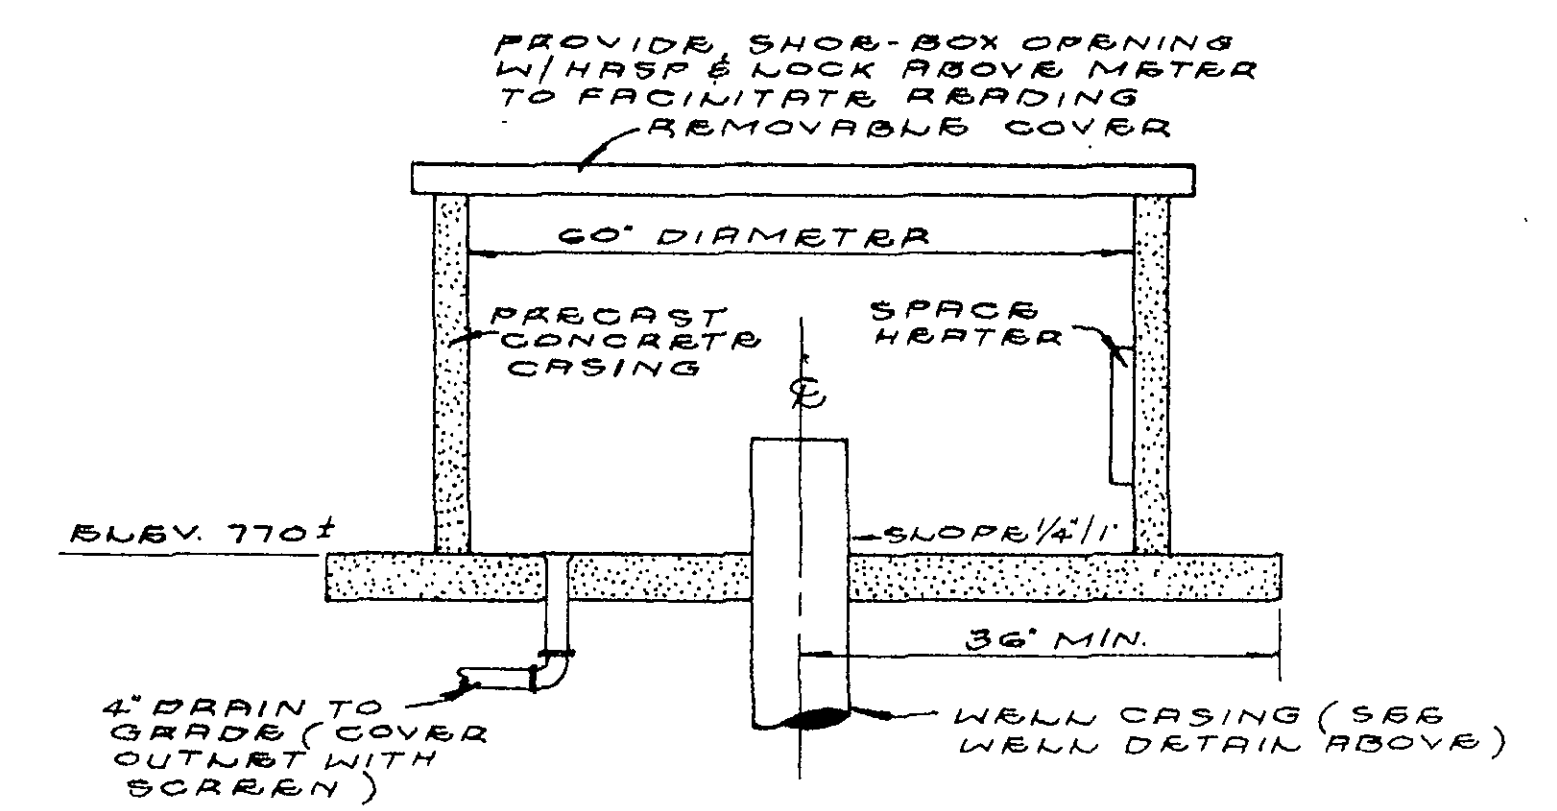

WELL HOUSING DETAIL

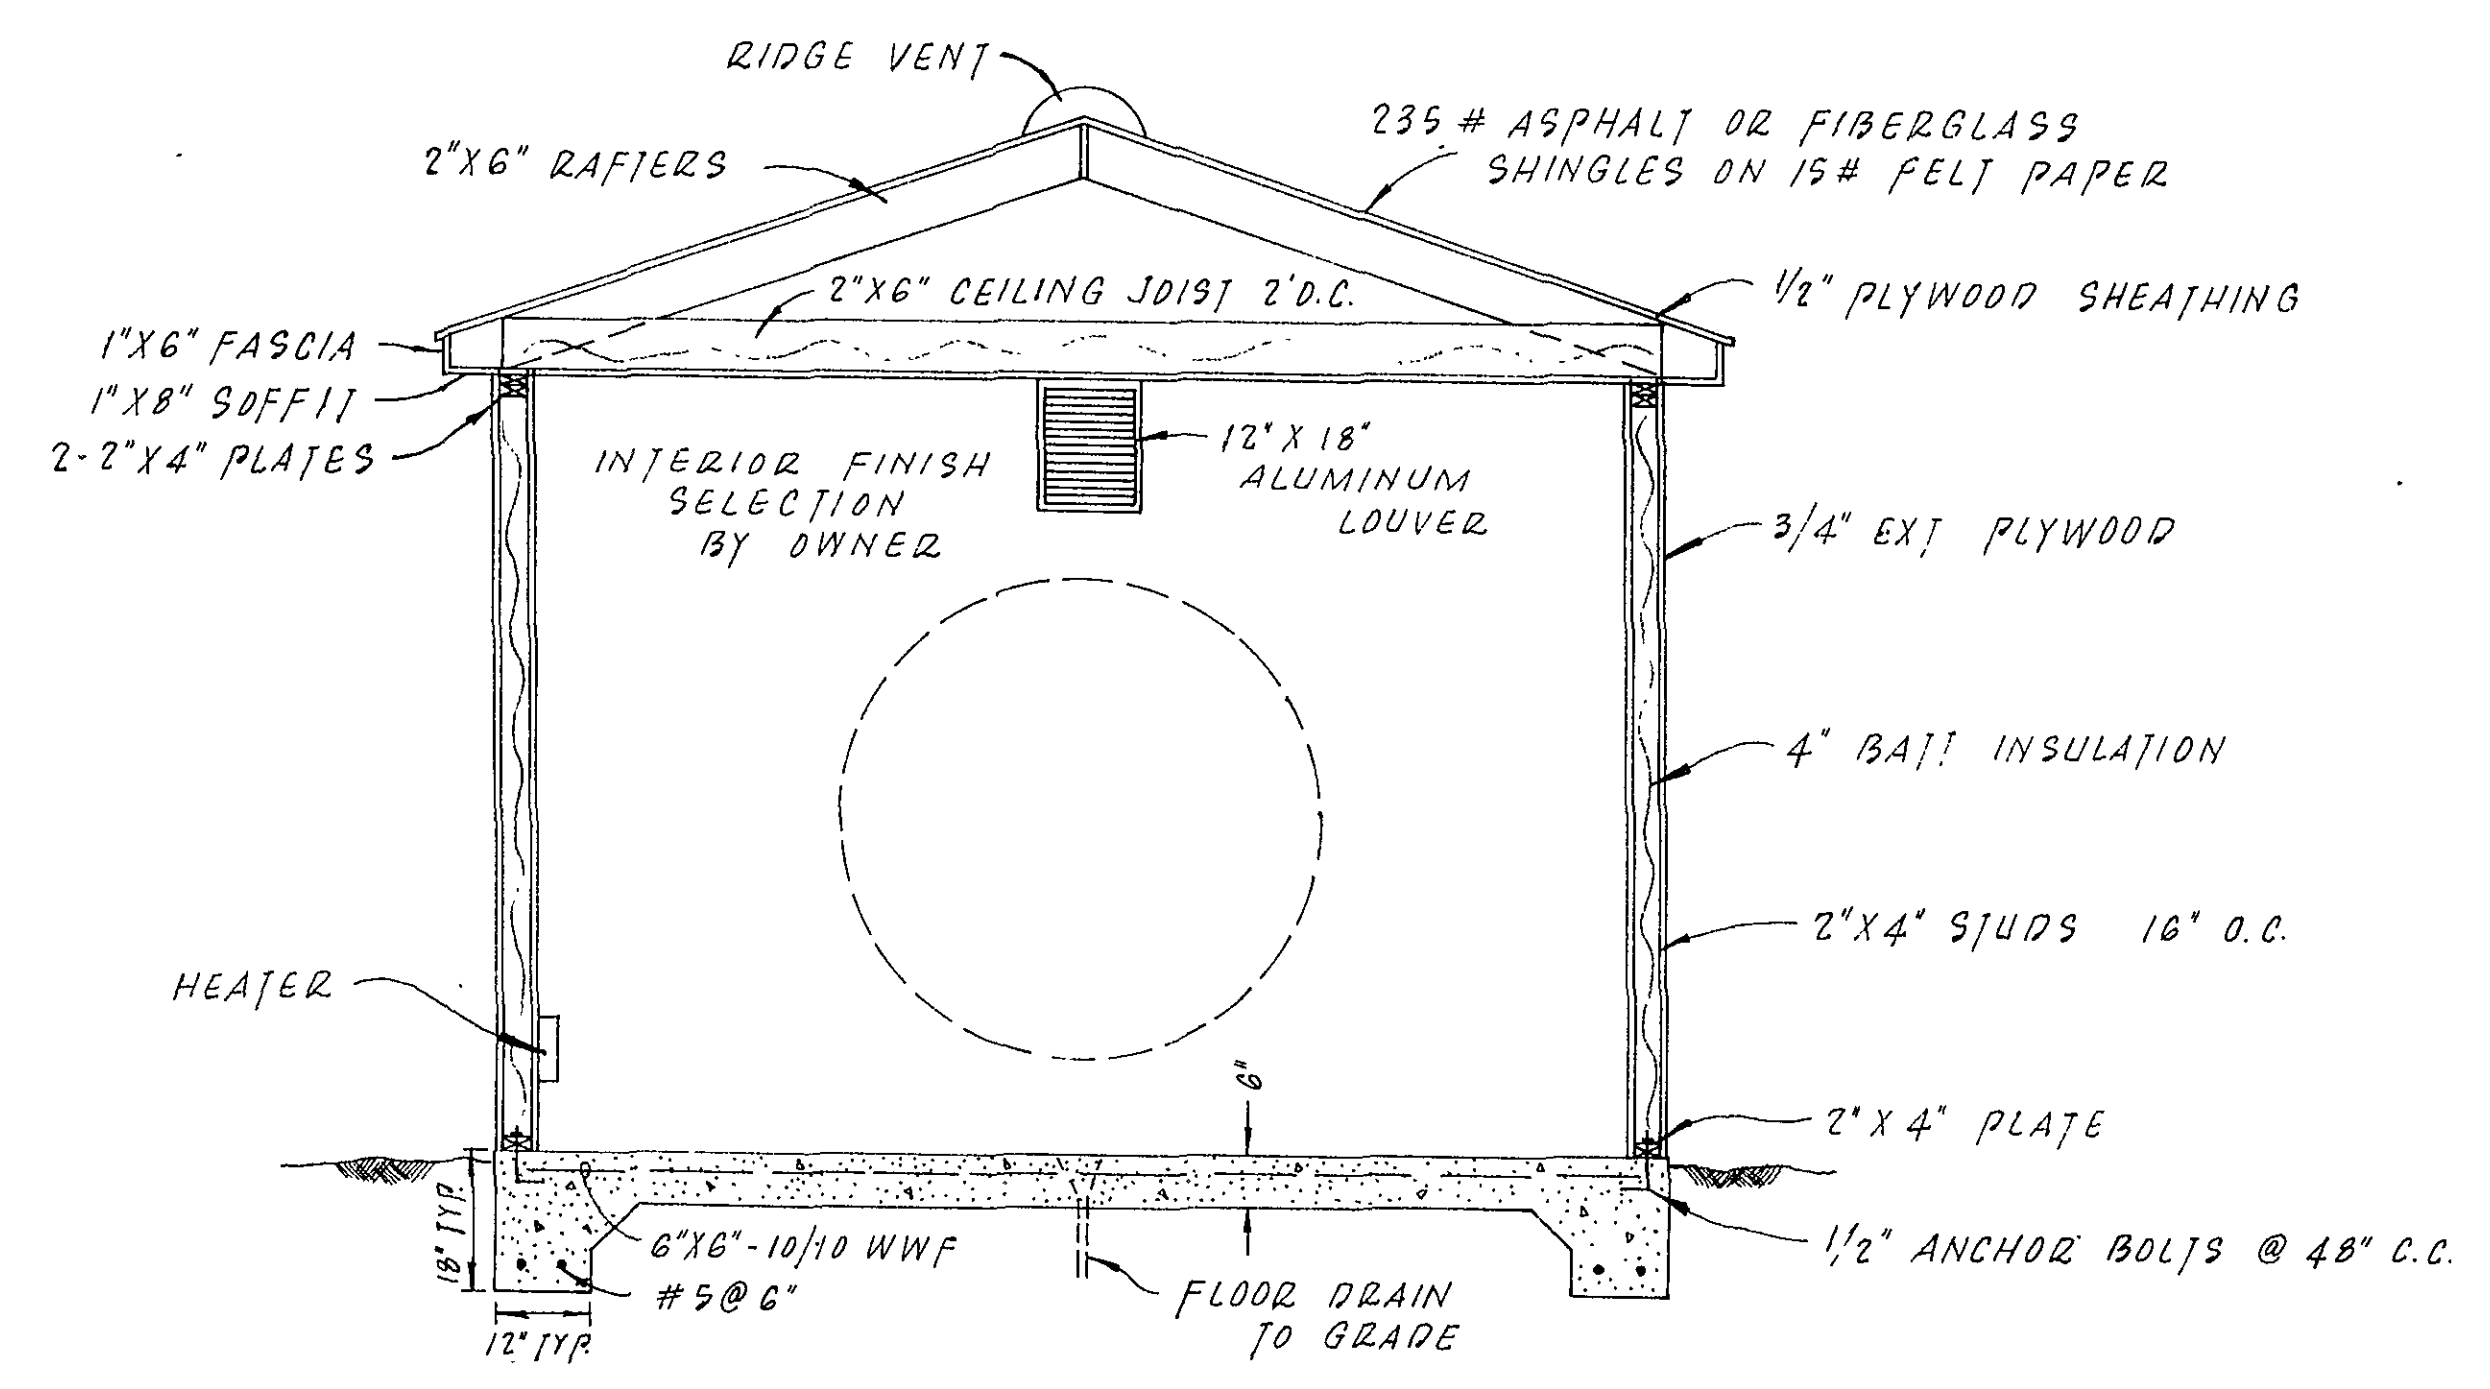

SECTION A-A

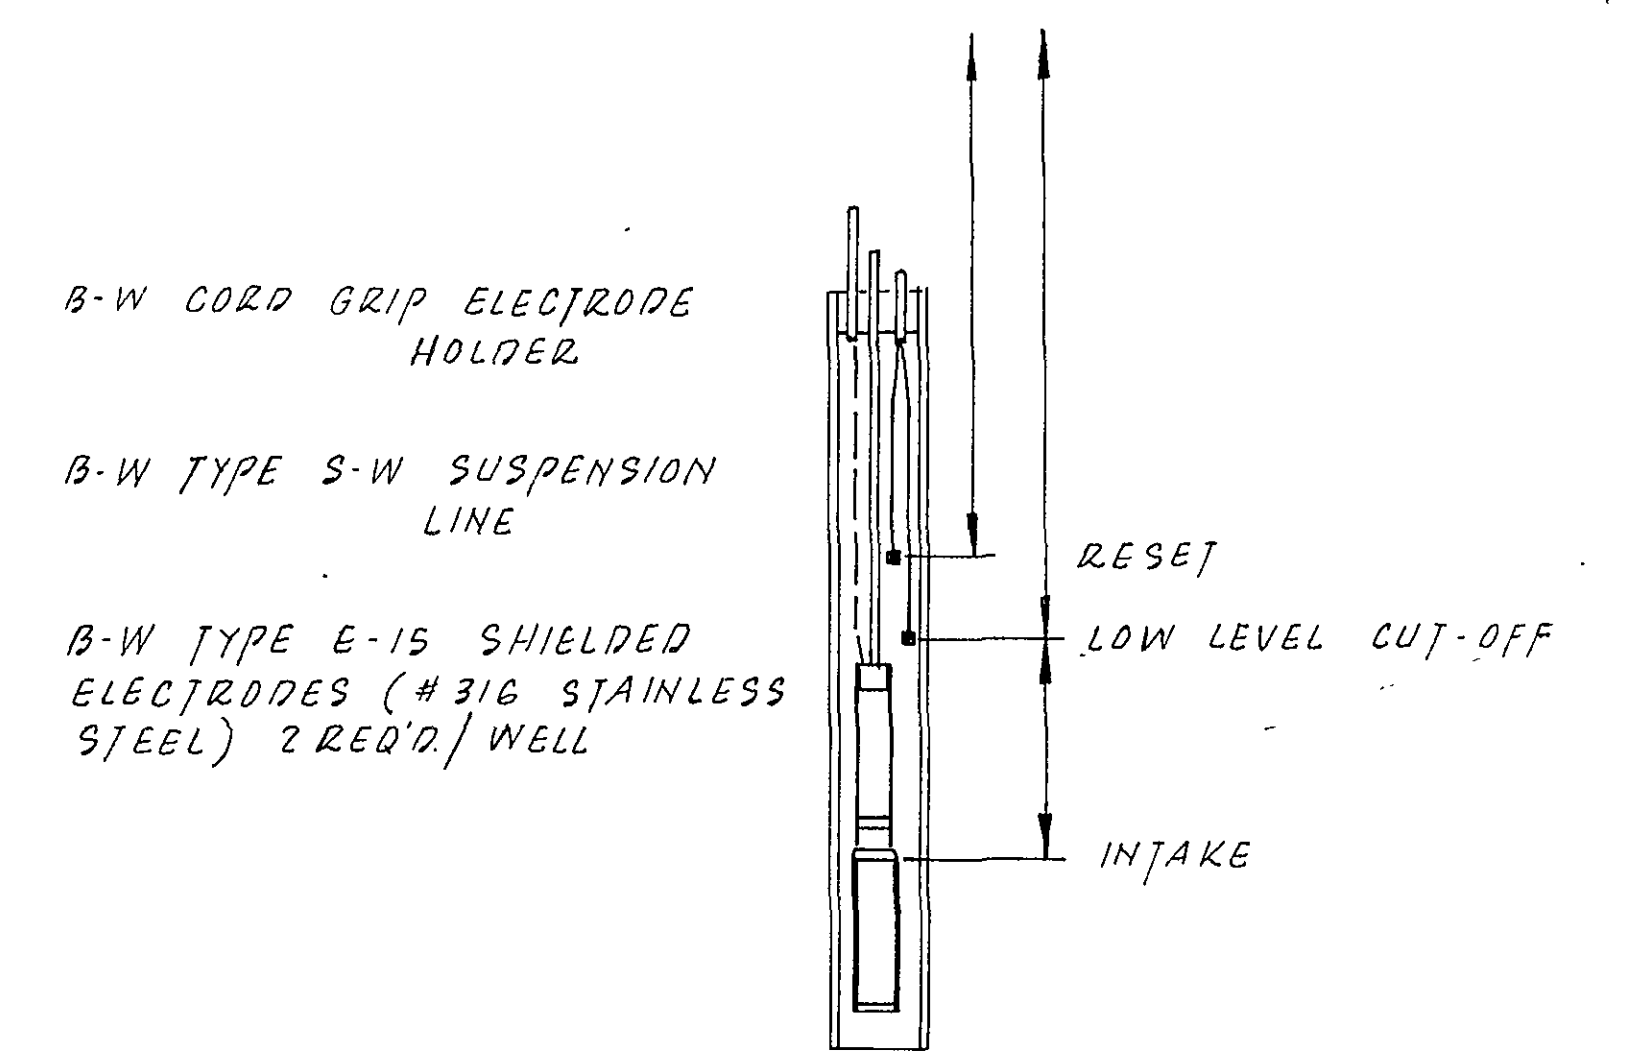

PUMP CONTROLS SCHEMATIC

Berkley Howell & Assoc. ENGINEERS • SURVEYORS • PLANNERS		
SCALE:	APPROVED BY:	DRAWN BY:
DATE: 4-7-87	REVIS:	REVIS:
WINDING WATERS CENTRAL WATER SYSTEM		
MISC. DETAILS		DRAWING NUMBER 7 OF 7