



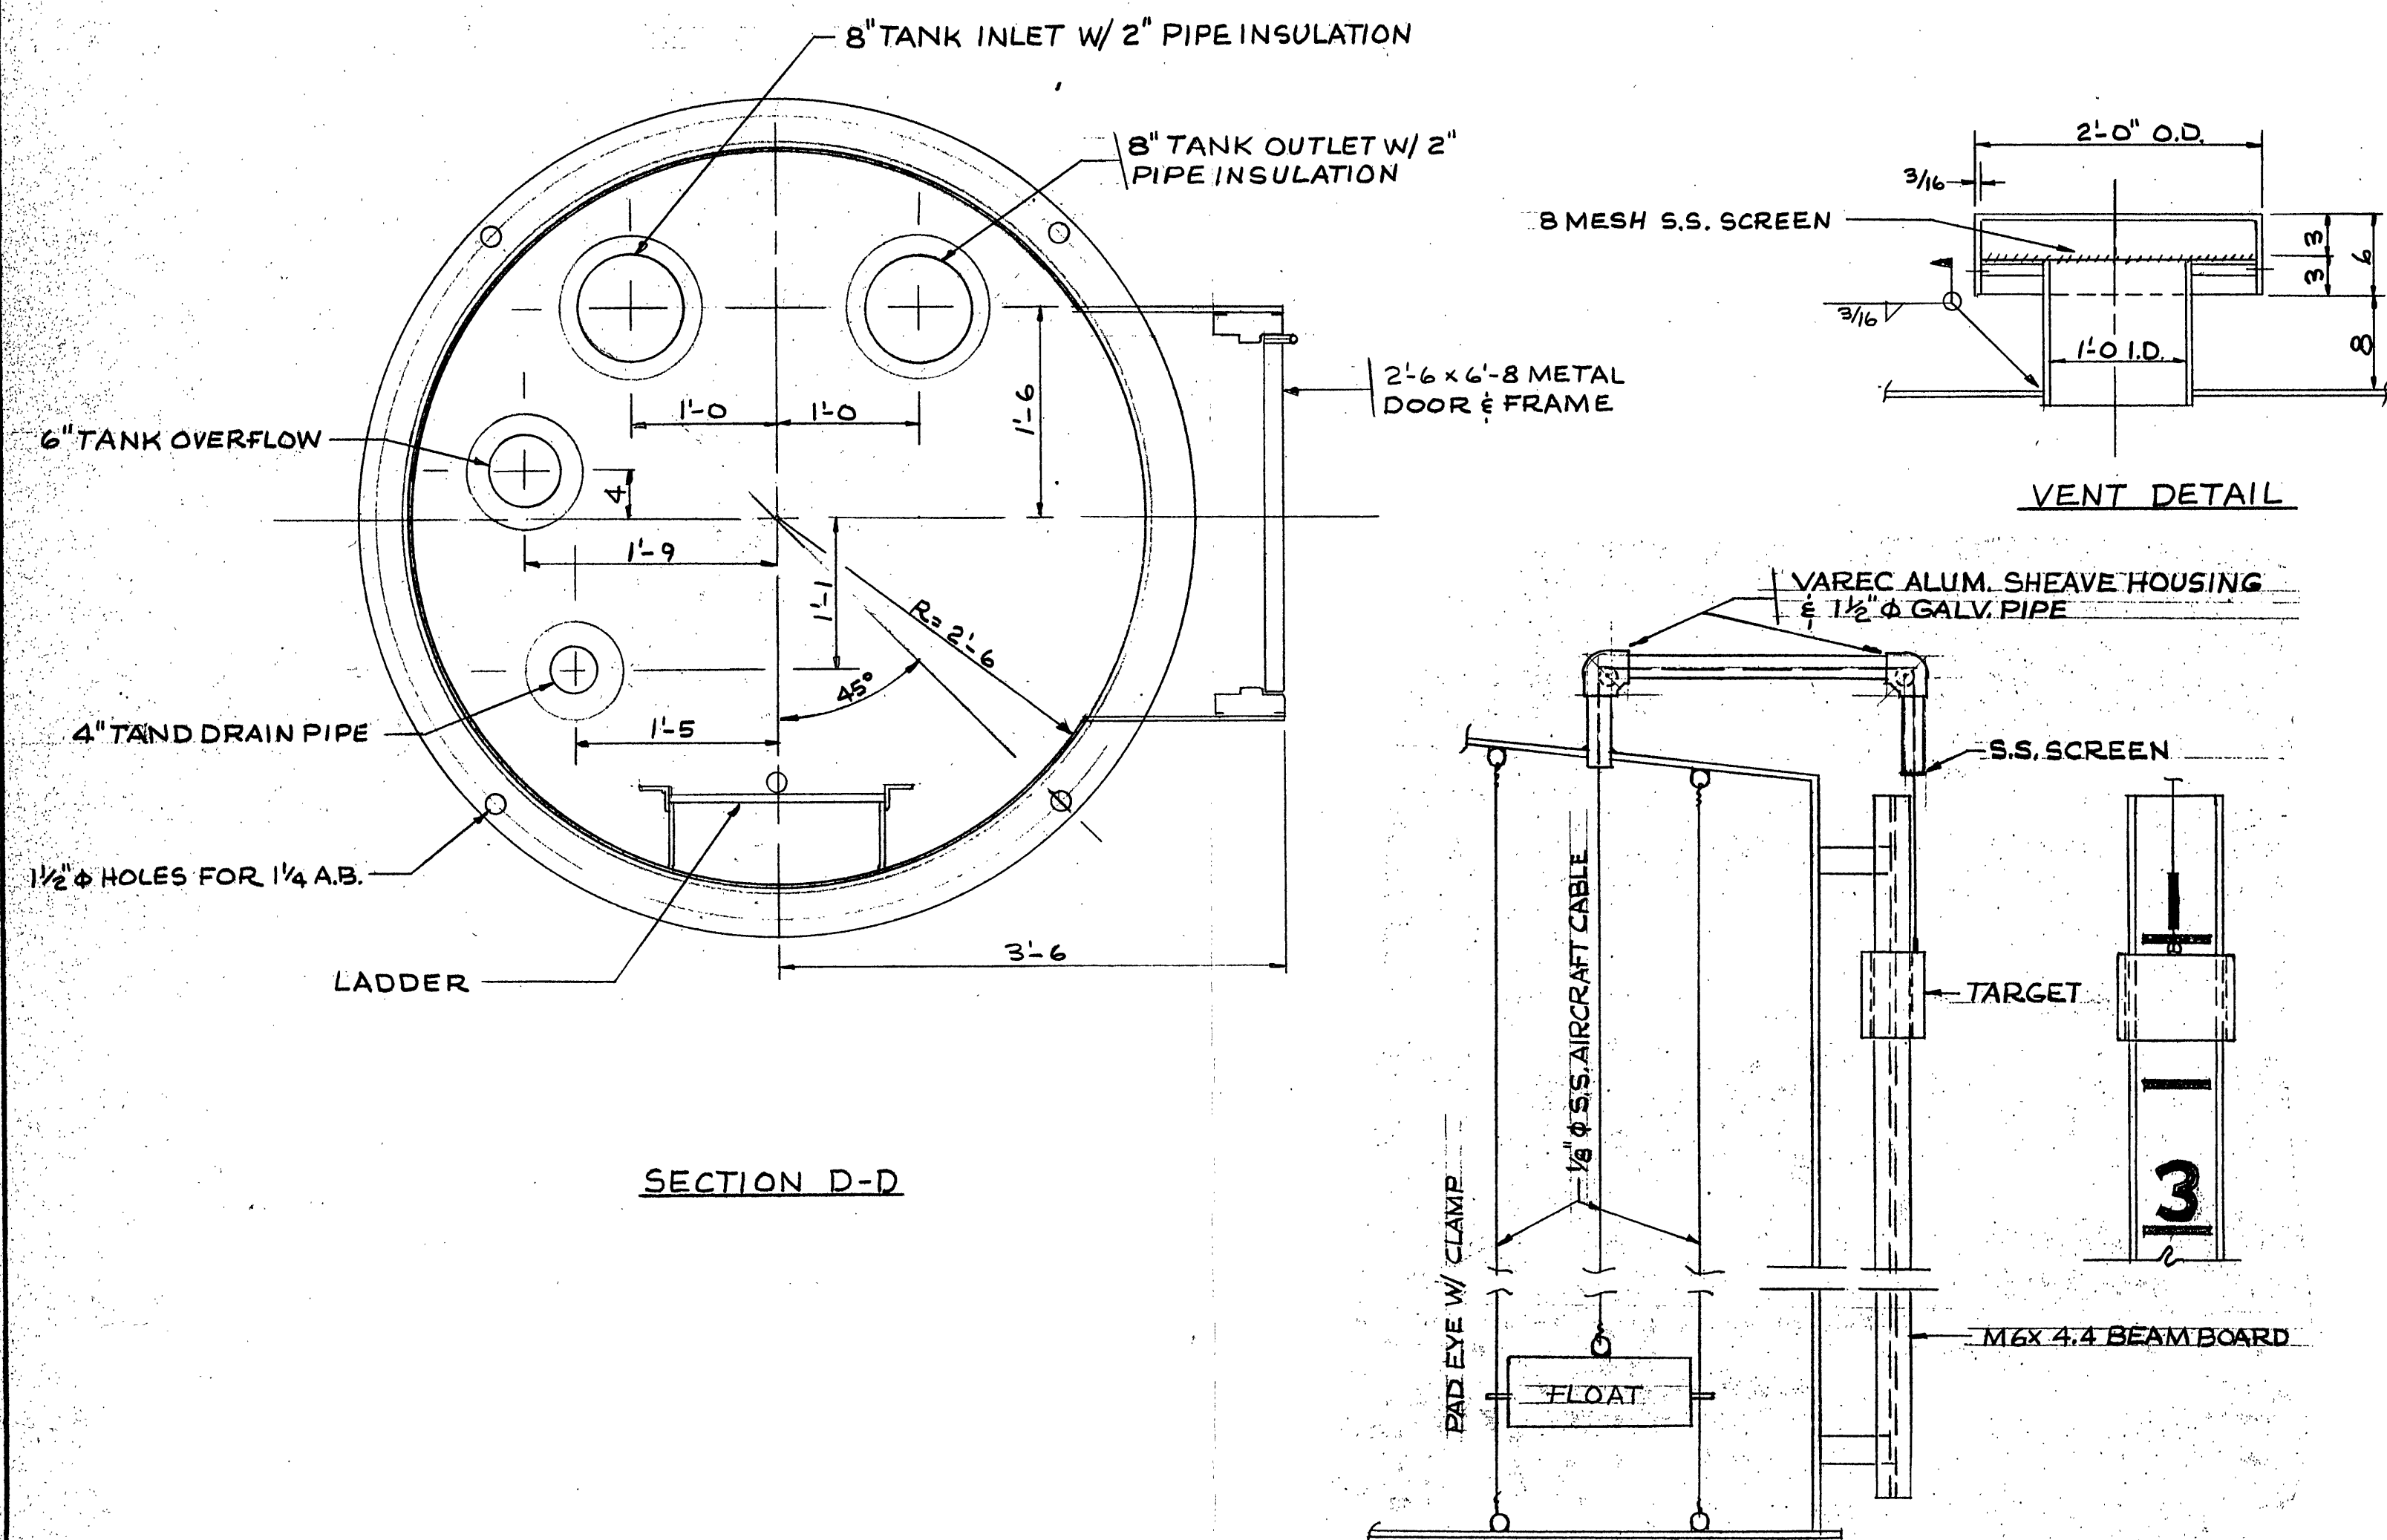


SECTION D-D


LIQUID LEVEL GAUGE DETAILS

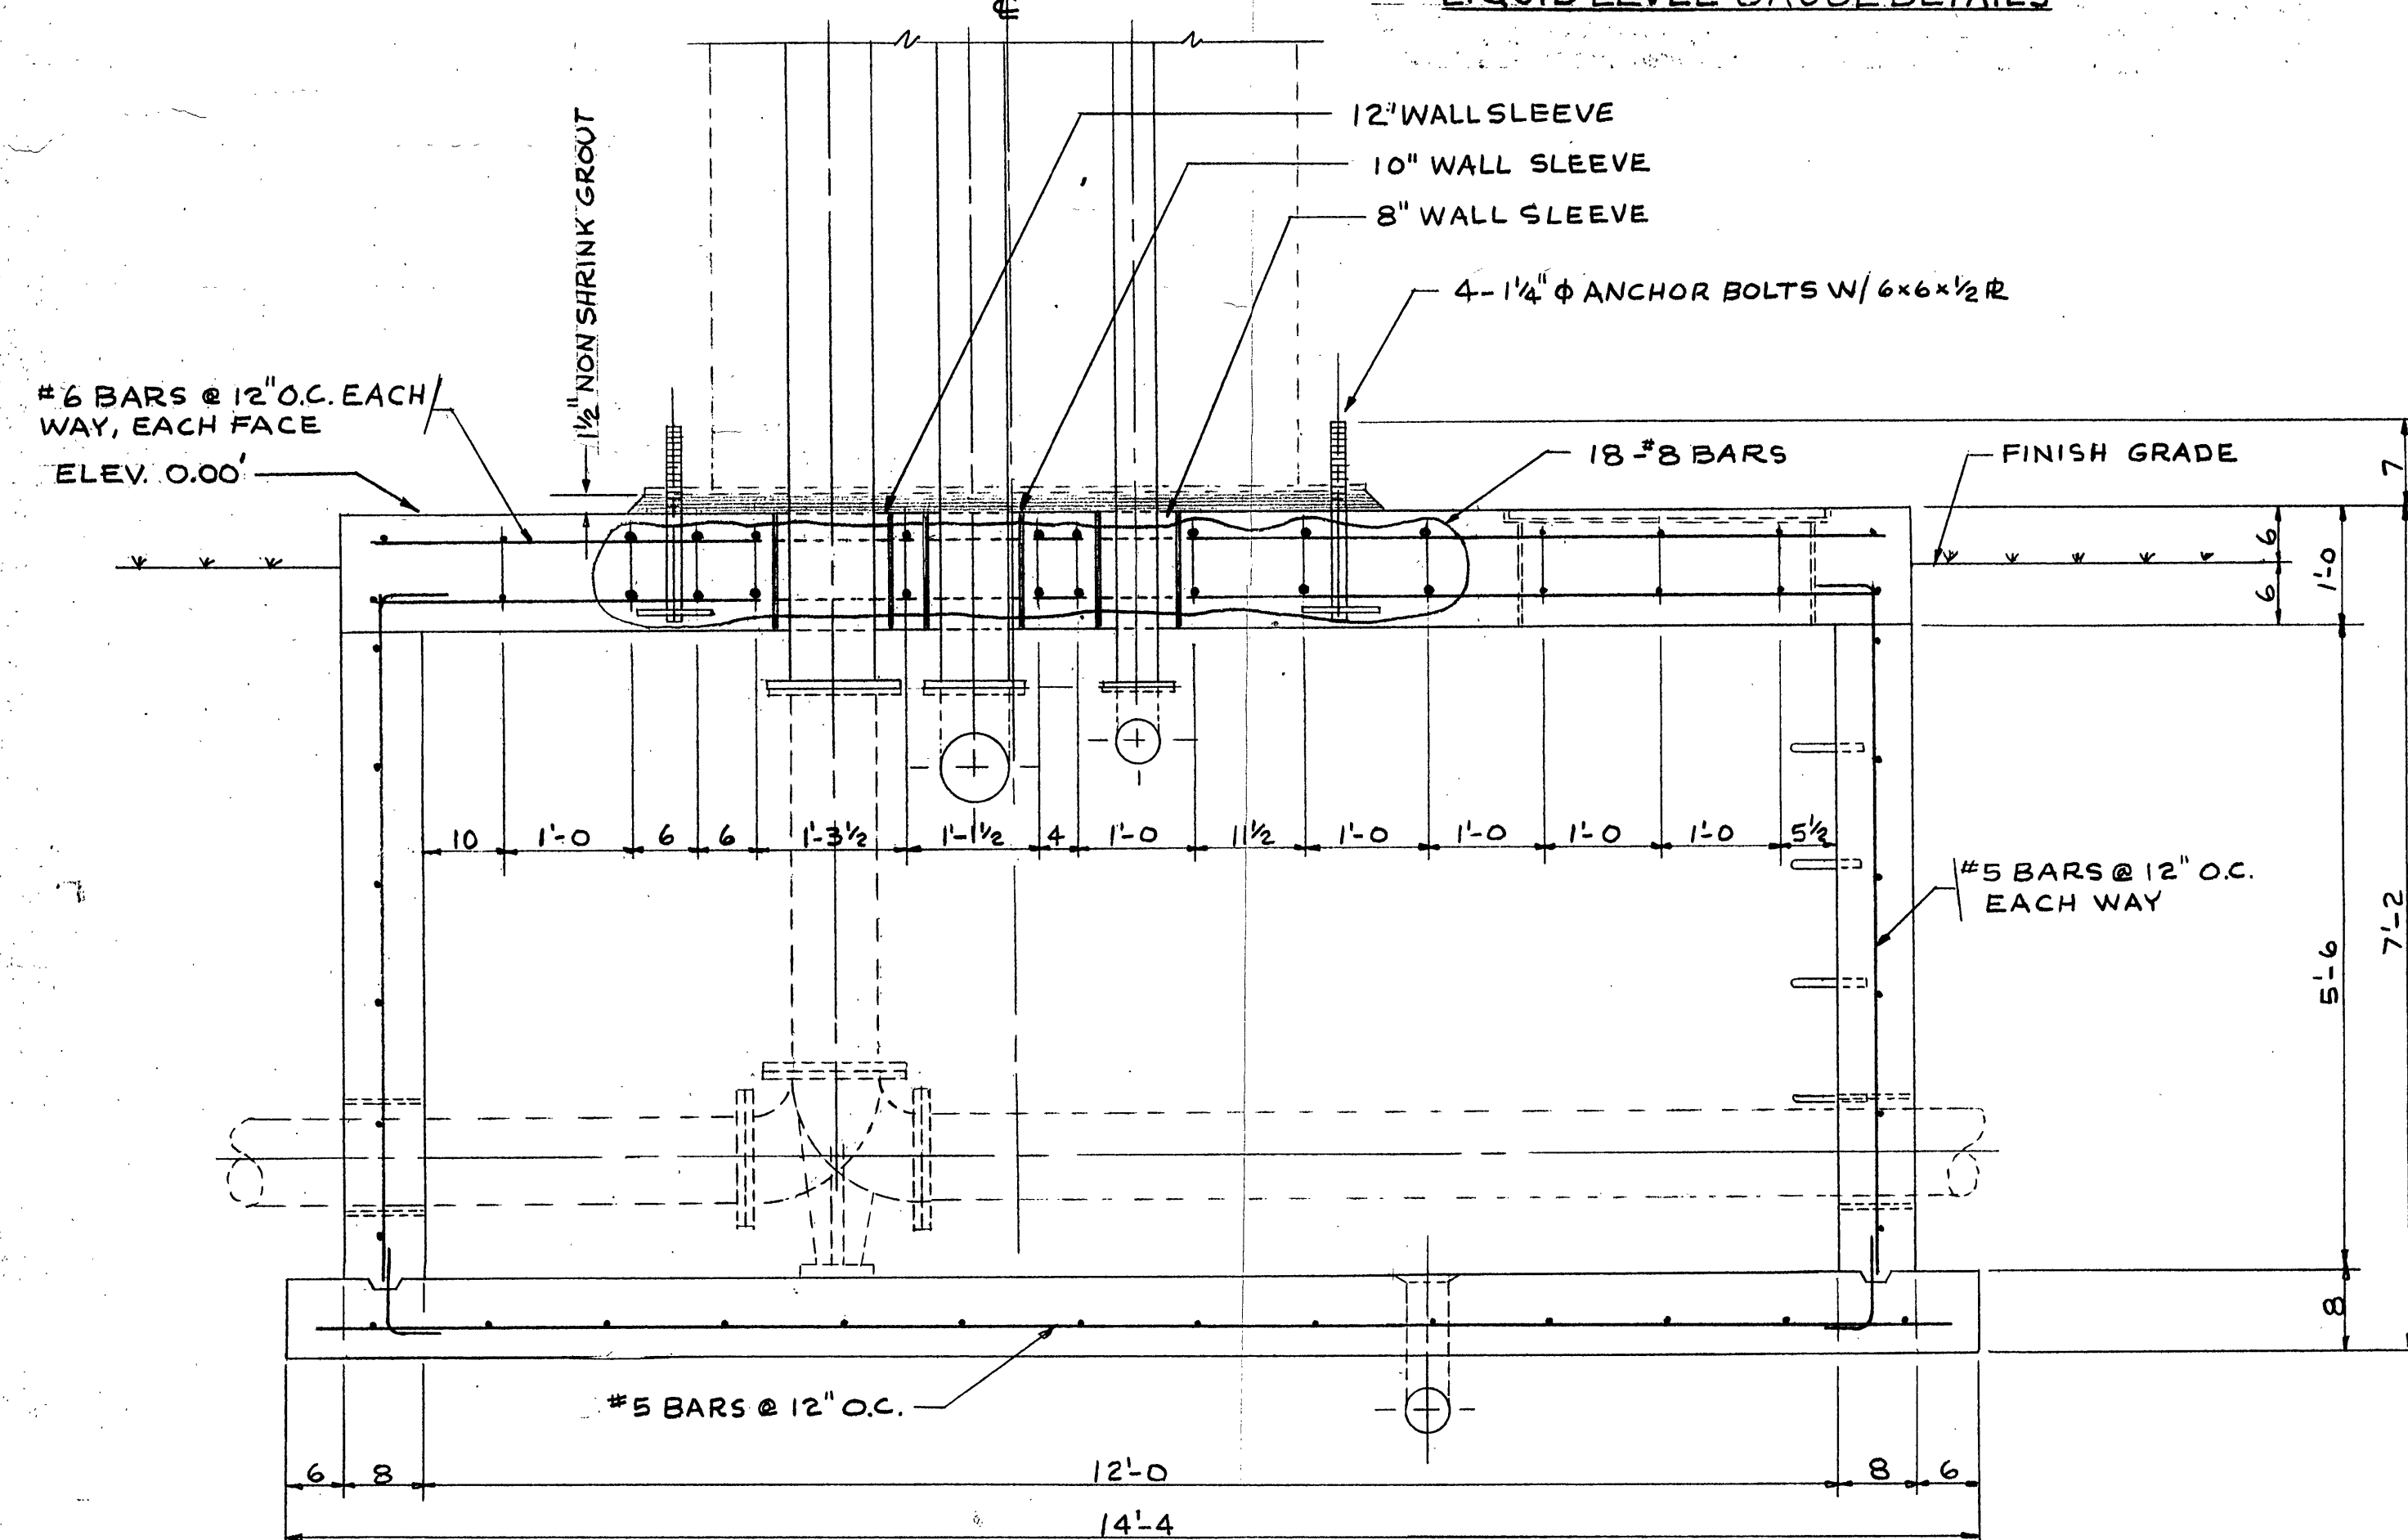


SECTION G-G

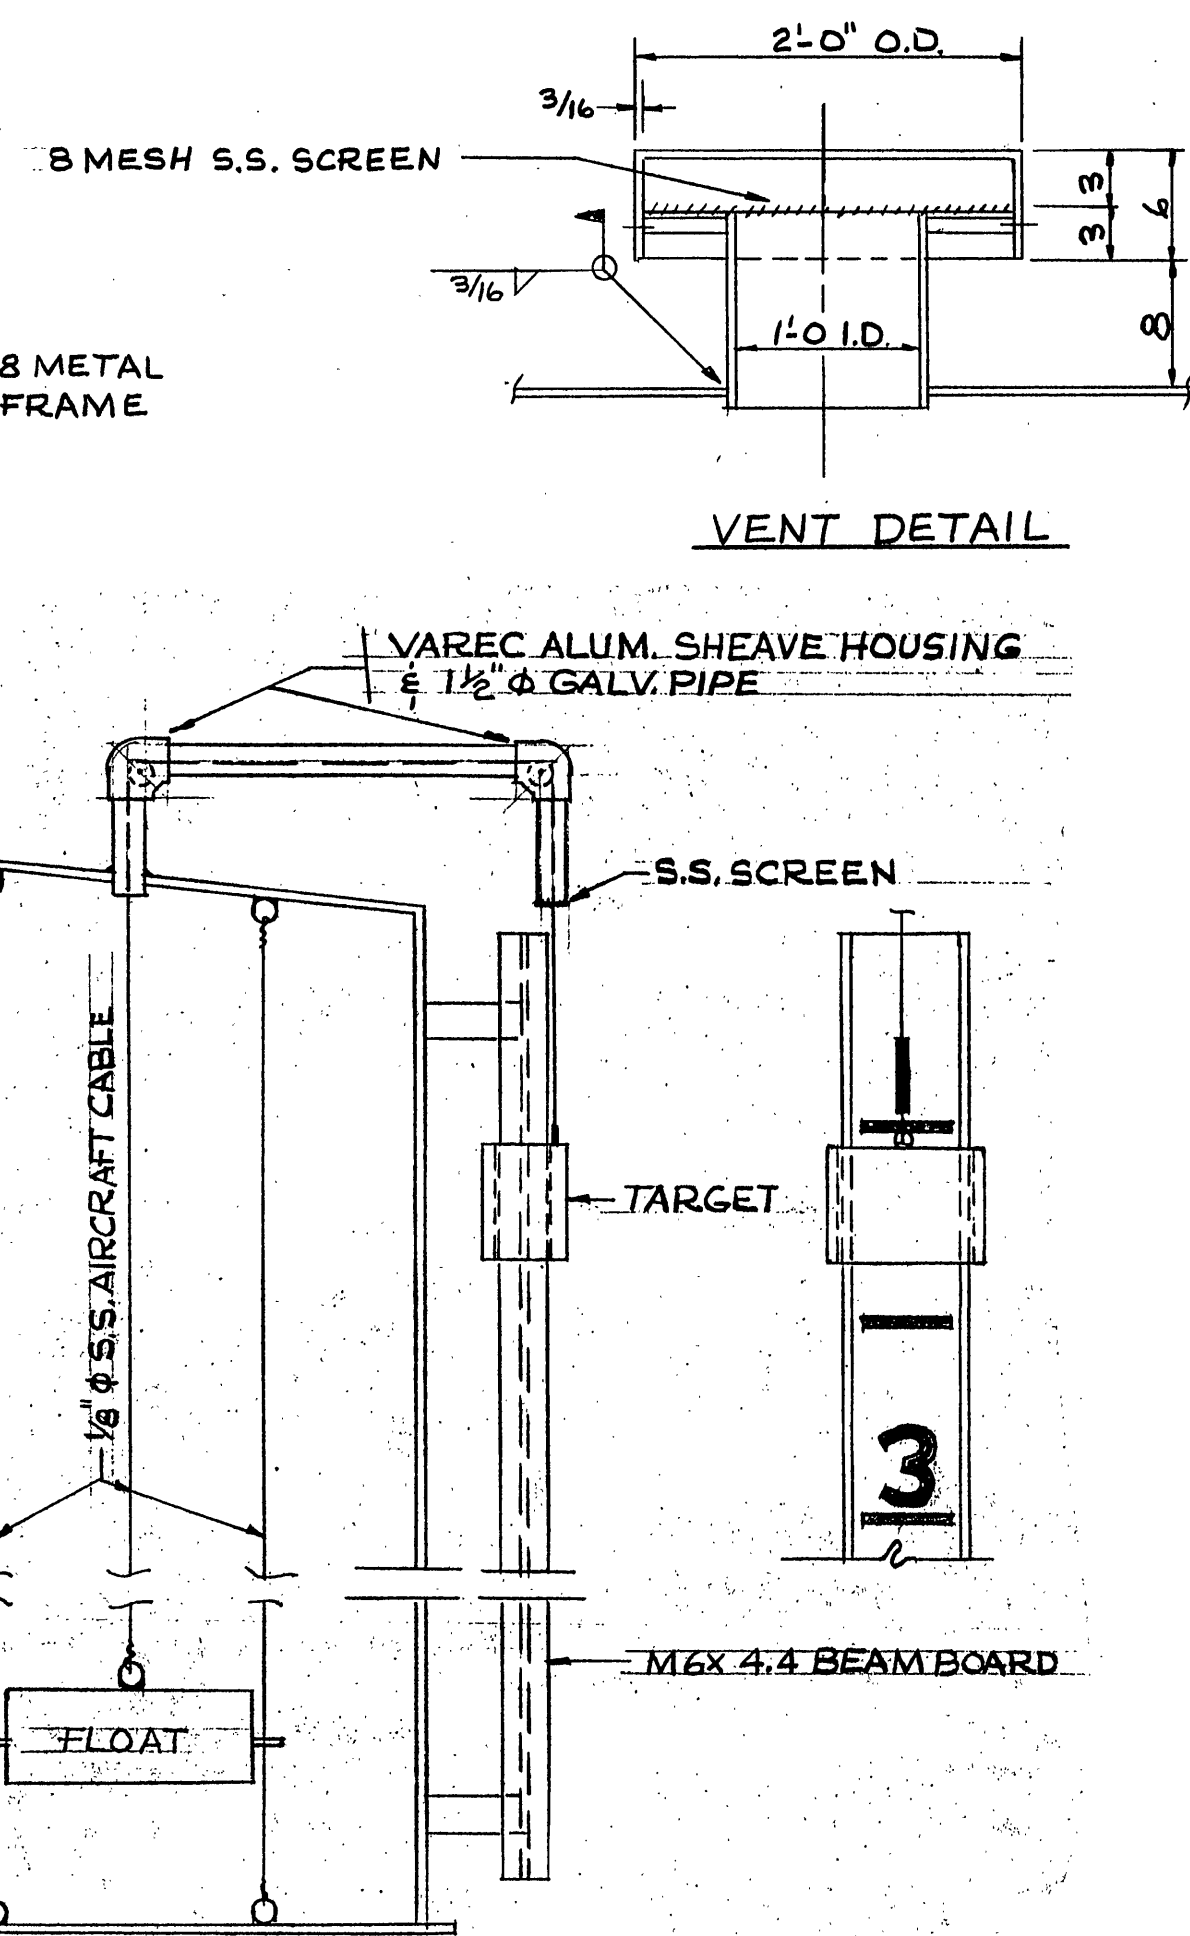

VENT DETAIL

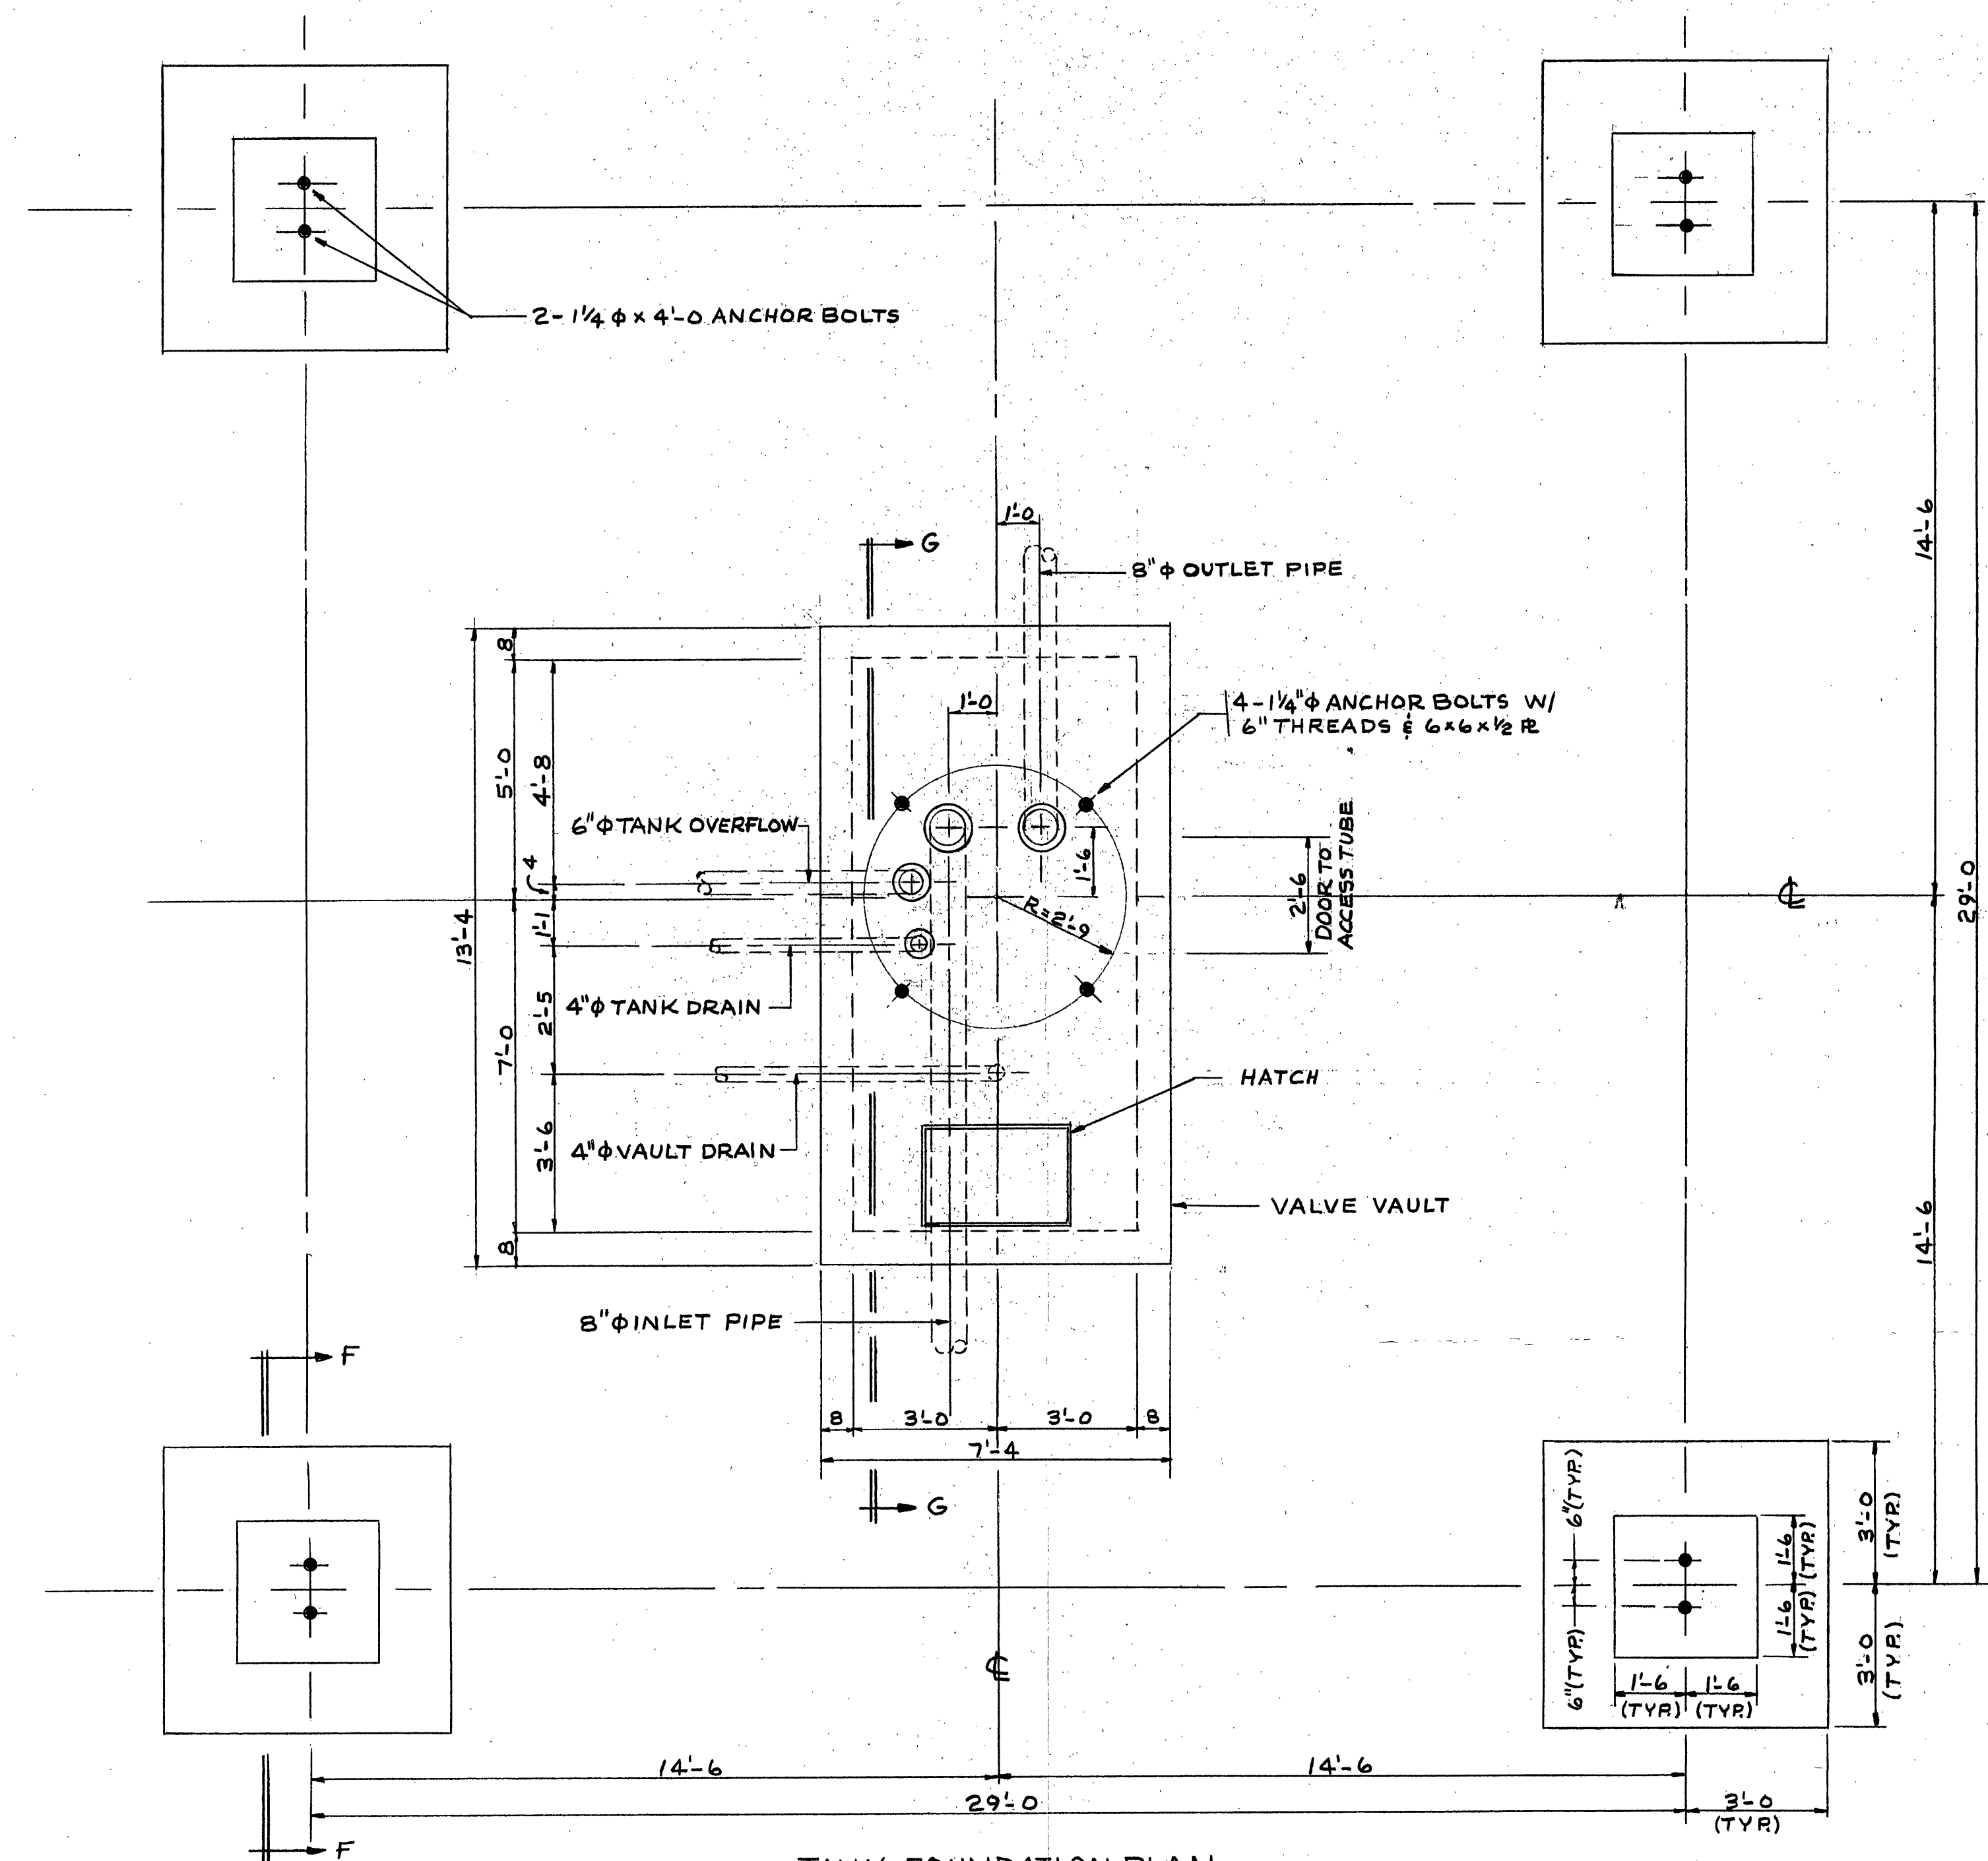

TANK FOUNDATION PLAN

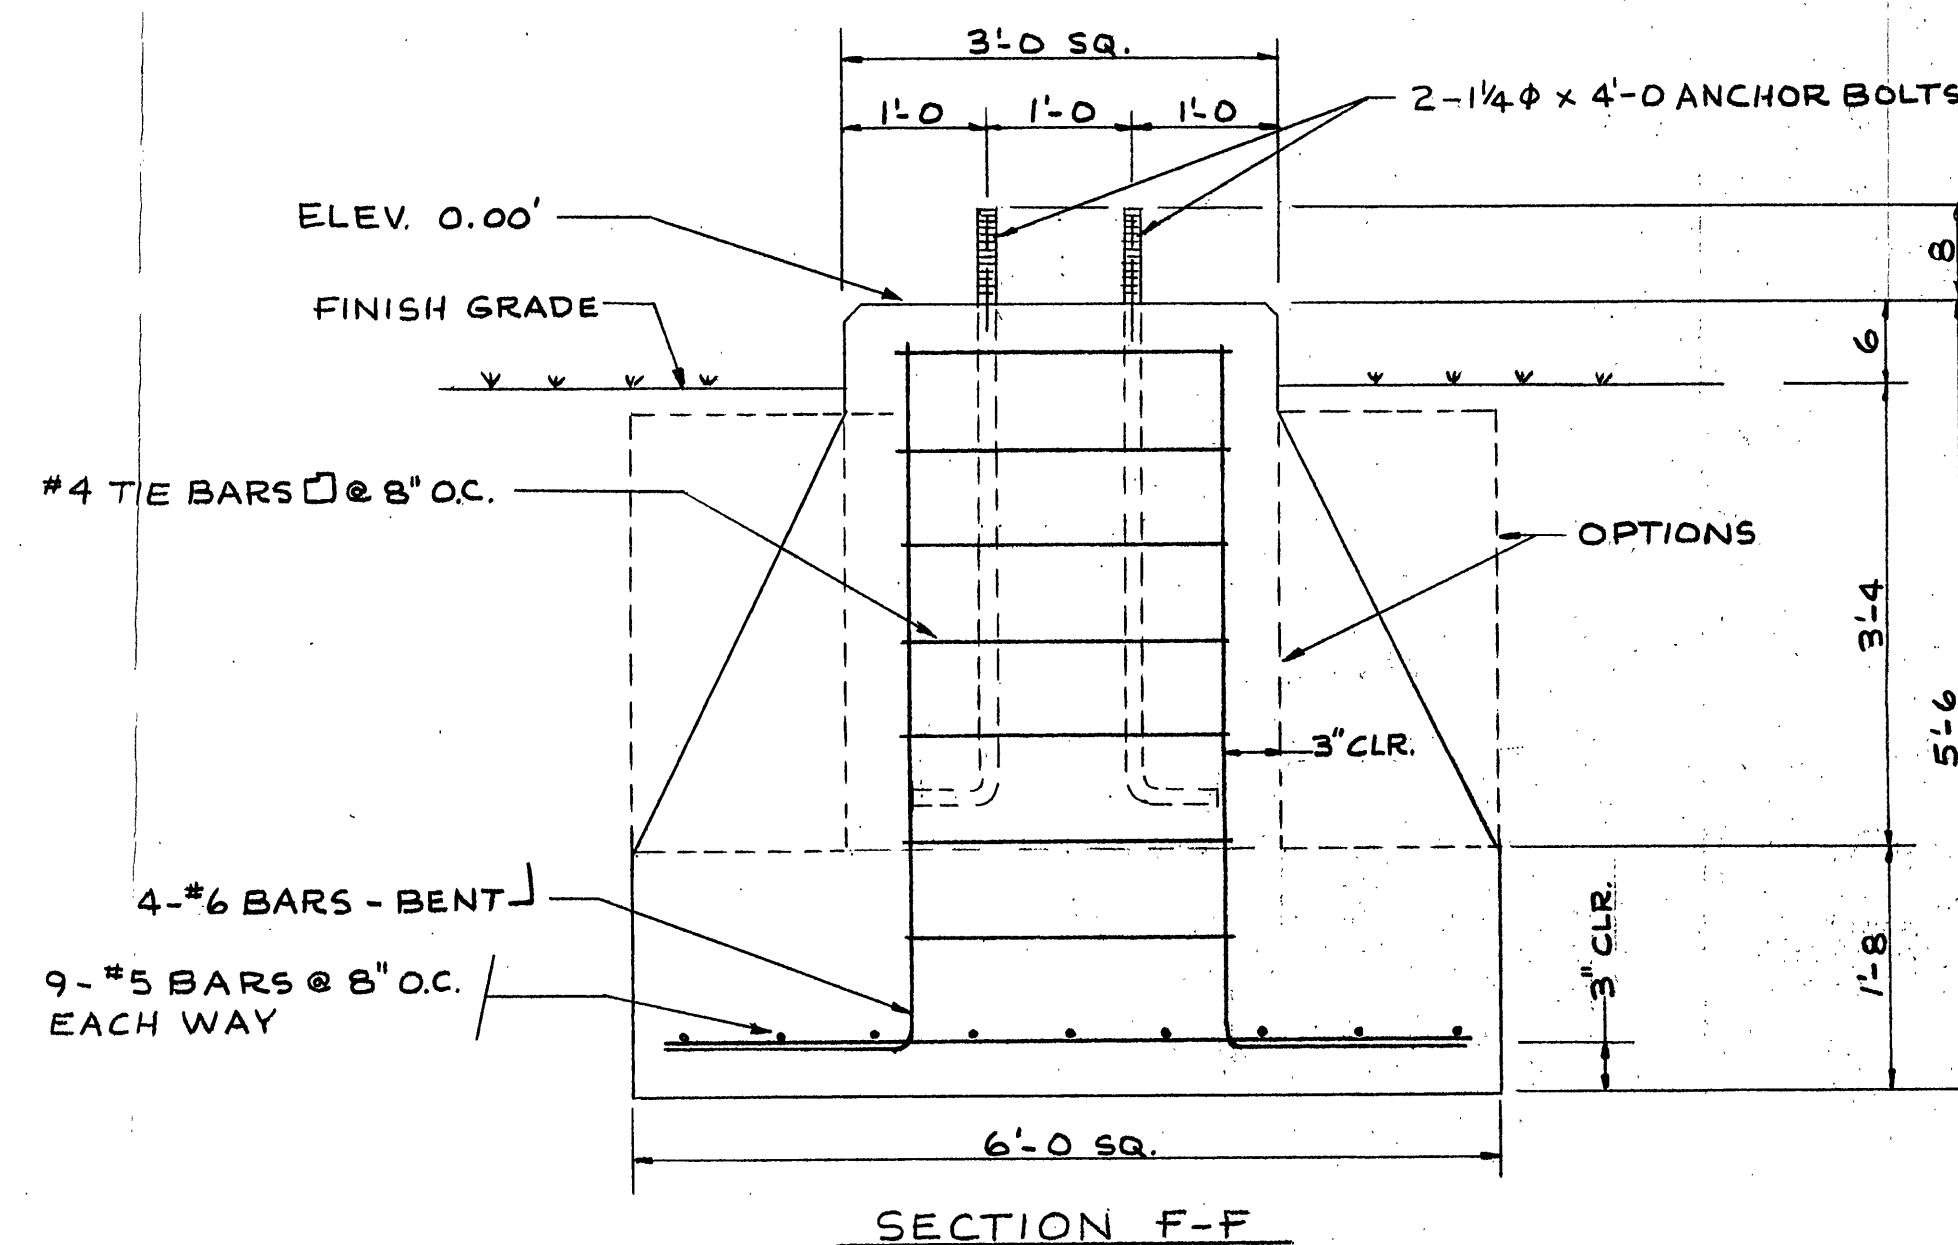

SECTION F-F

NOTES:

FOUNDATION & TANK DESIGNED PER AWWA-D100.
FOUNDATION DESIGNED FOR 9,000 PSF BEARING
CAPACITY AT 5'-0\"/>

INDUSTRIAL WELDING & MACHINE CORP.
ATKINS VIRGINIA

51,700 GALLON ELEVATED WATER STORAGE TANK

WATER FRONT SECTION #11
FRANKLIN COUNTY, VA
DATE 7-25-91

WILLARD CONSTRUCTION ROANOKE VALLEY, INC.
ROANOKE, VA
APPROVED BY

DRAWING NUMBER 2 of 2