


SHEET C05

SHEET C07

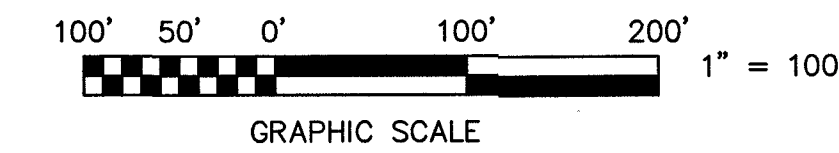

SMITH MOUNTAIN LAKE (JURISDICTIONAL WATERS) (OWNER: APPALACHIAN POWER COMPANY)


Materials
Water Info.

Pipe : 8" North American PVC C900 DR14
 6" " " " " "
 4" " " " " " "

Valves : All Mueller Valves
 8" : 27 turns, CCW ON
 6" : 21 turns, CCW ON
 4" : 15 turns, CCW ON

Service Line : 1" Endot HDPE SDR-9

Bore Pipe:
 8" American DIP CL 35/50
 16" steel casing pipe
 4" American DIP CL 52

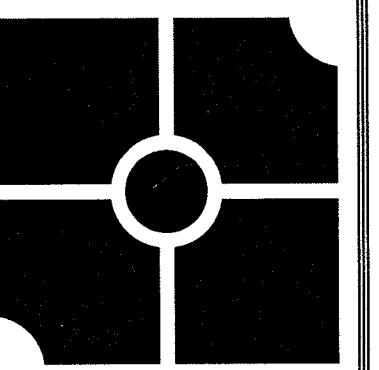


parker
DESIGN GROUP

2122 Carolina Ave, SW
 Roanoke, VA 24014
 Ph: 540-387-1153
 Fax: 540-389-5767

1915-B W. Cary Street
 Richmond, VA 23220
 Phone: 804-358-2947
 Fax: 804-359-9645
 www.parkerdg.com

These documents are the property of Parker Design Group (PDG) and may not be reproduced or used without the express permission of PDG. Any reuse of these documents without authorization of PDG will be at the sole risk of the individual or entity utilizing said documents.

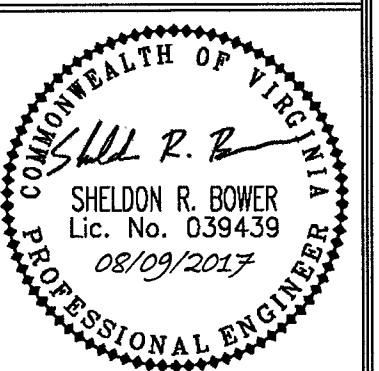

KENNEDY SHORES SUBDIVISION DEVELOPMENT PLAN

Tax # 0510001500
 Franklin County, Virginia

REVISIONS:	
2/10/2017 - 1ST SUB COMMENTS	
3/21/2017 - 2ND SUB COMMENTS	
4/14/2017 - 3RD SUB COMMENTS	
6/23/2017 - FIELD REVISION #1	
7/26/2017 - FIELD REVISION #2	
8/4/2017 - FIELD REVISION #3	
8/9/2017 - FIELD REVISION #4	
DESIGNED BY:	JMM/SRB
DRAWN BY:	JMM/JLK
CHECKED BY:	SRB


DATE:
6 JANUARY, 2017

SHEET TITLE:
OVERALL LAYOUT PLAN

SCALE:
1" = 100'

SHEET NO.

C04

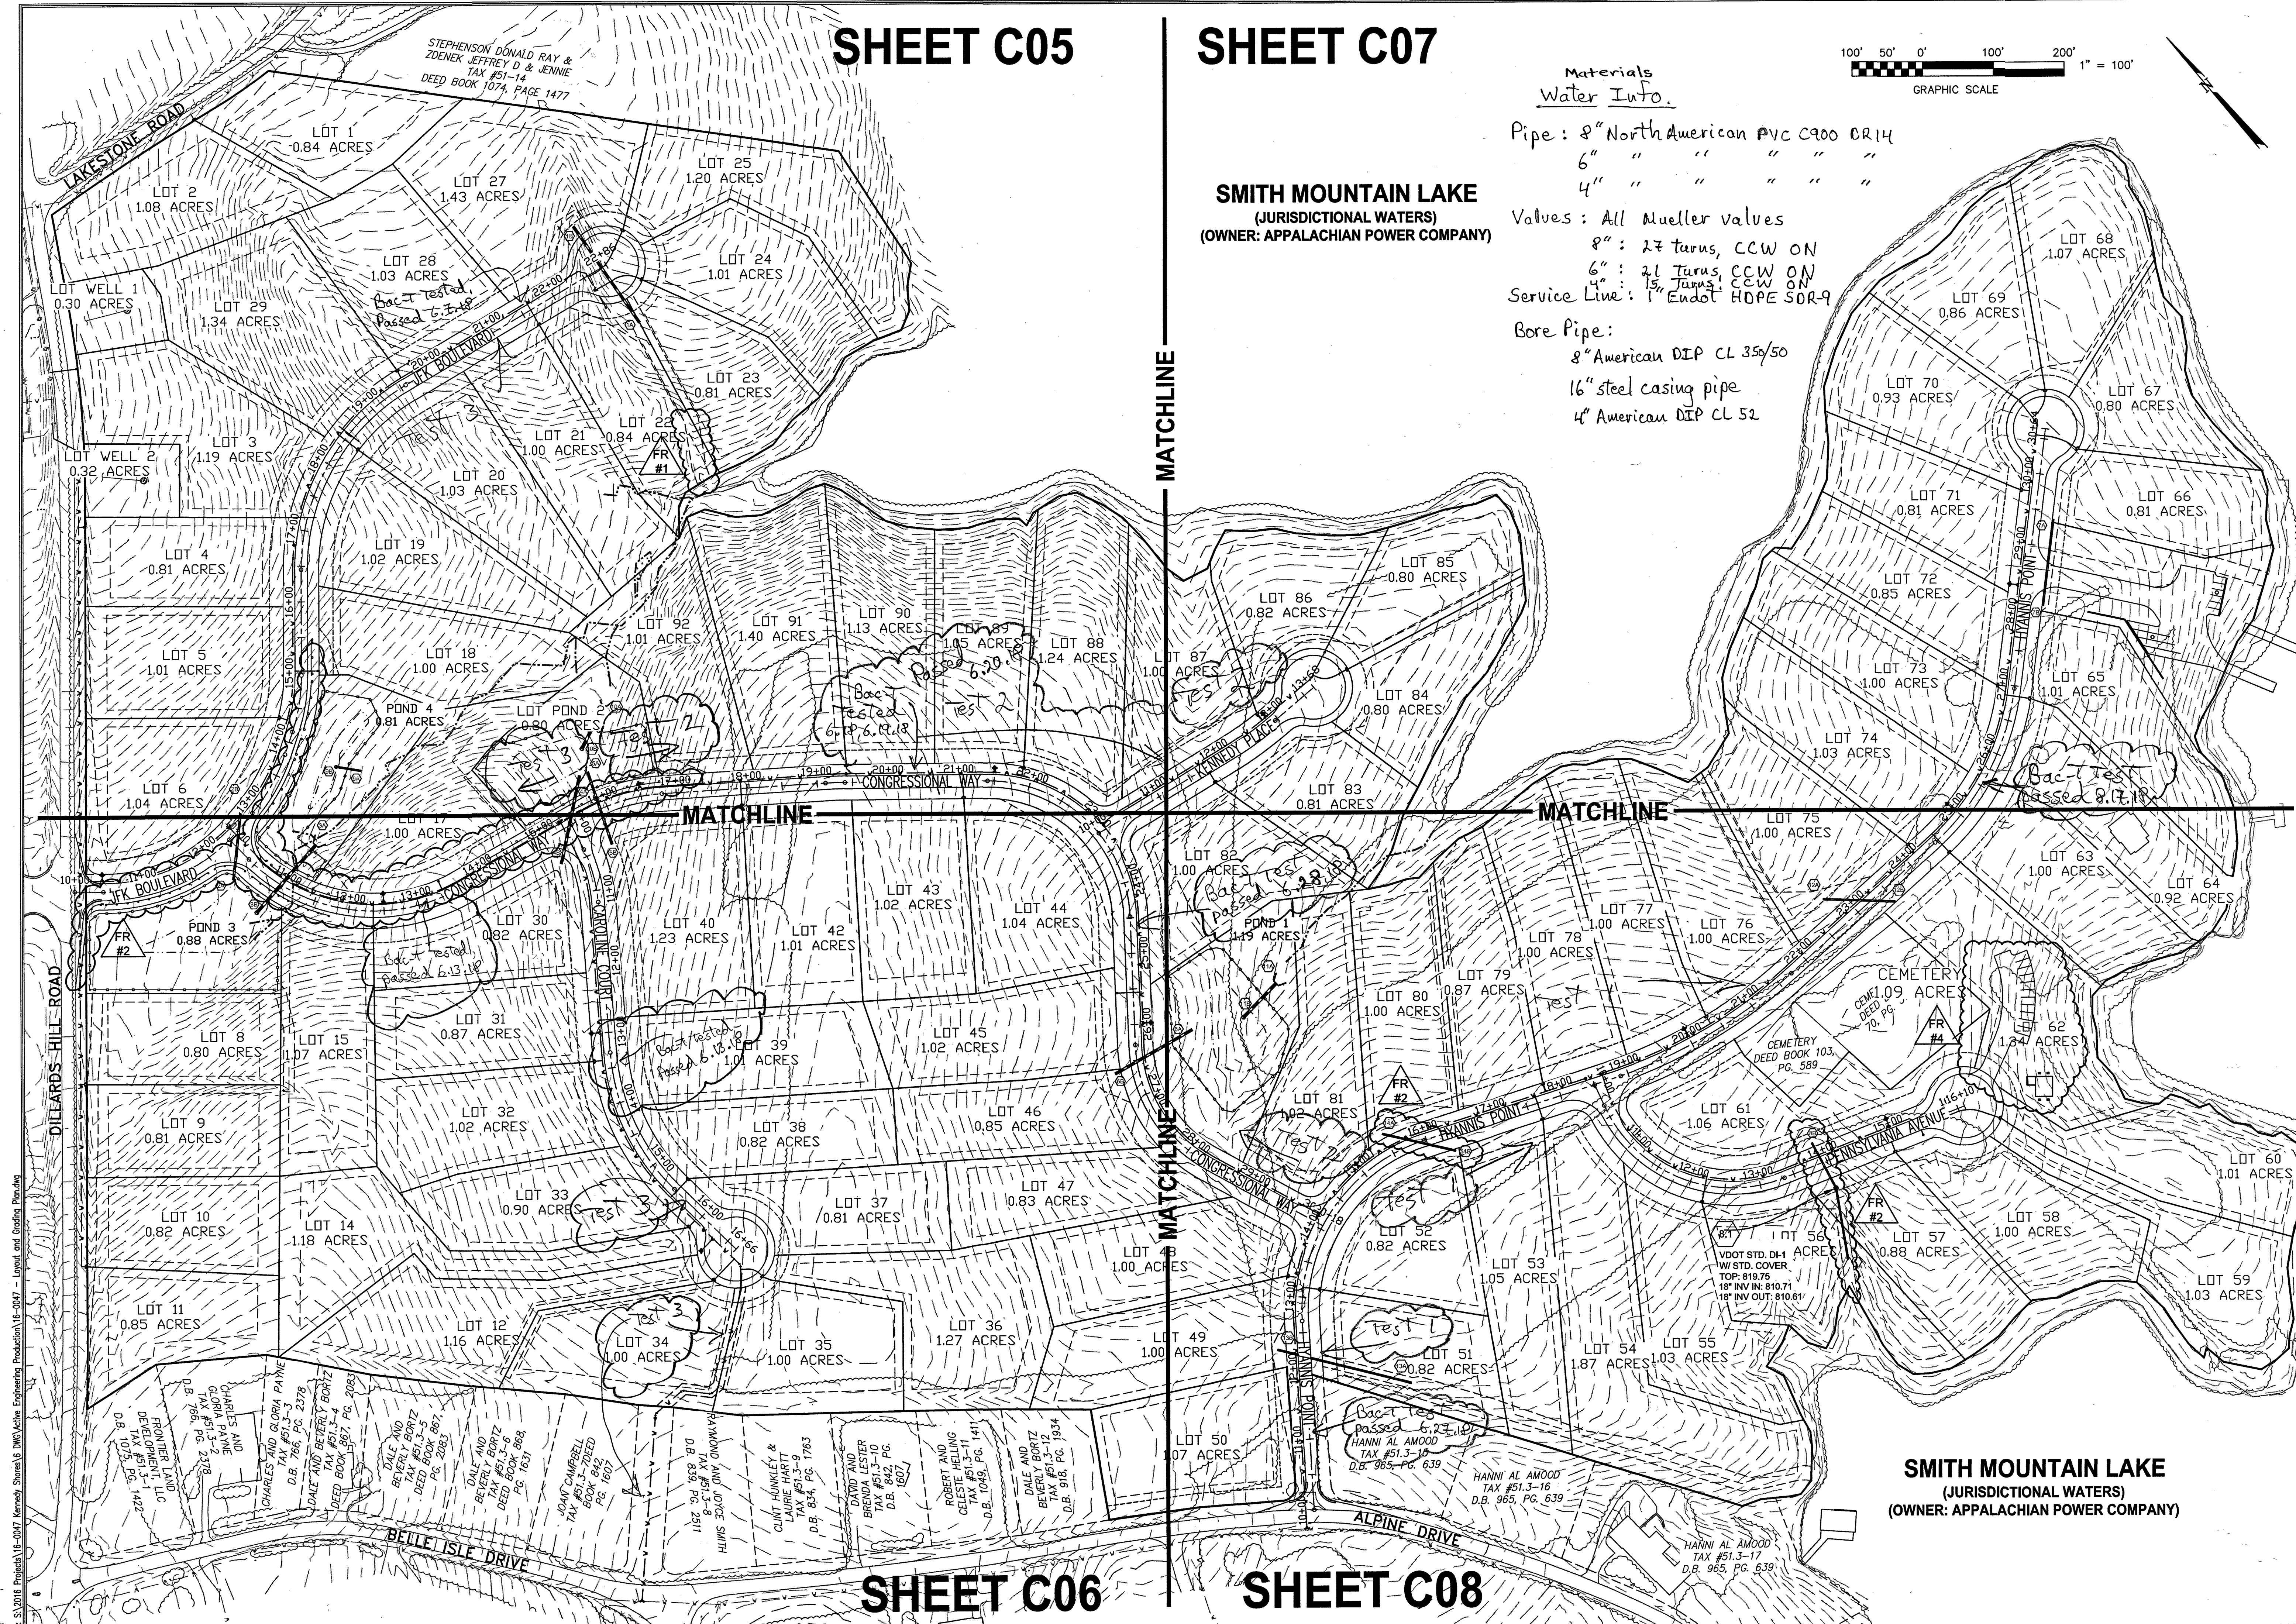

File: SJ2016 Projects\16-007 Kennedy Shores\DWG\Subdiv Development\16-007 - Layout and Grading Plan.dwg
 Date: 1/10/2017 10:00 AM
 User: JMM