

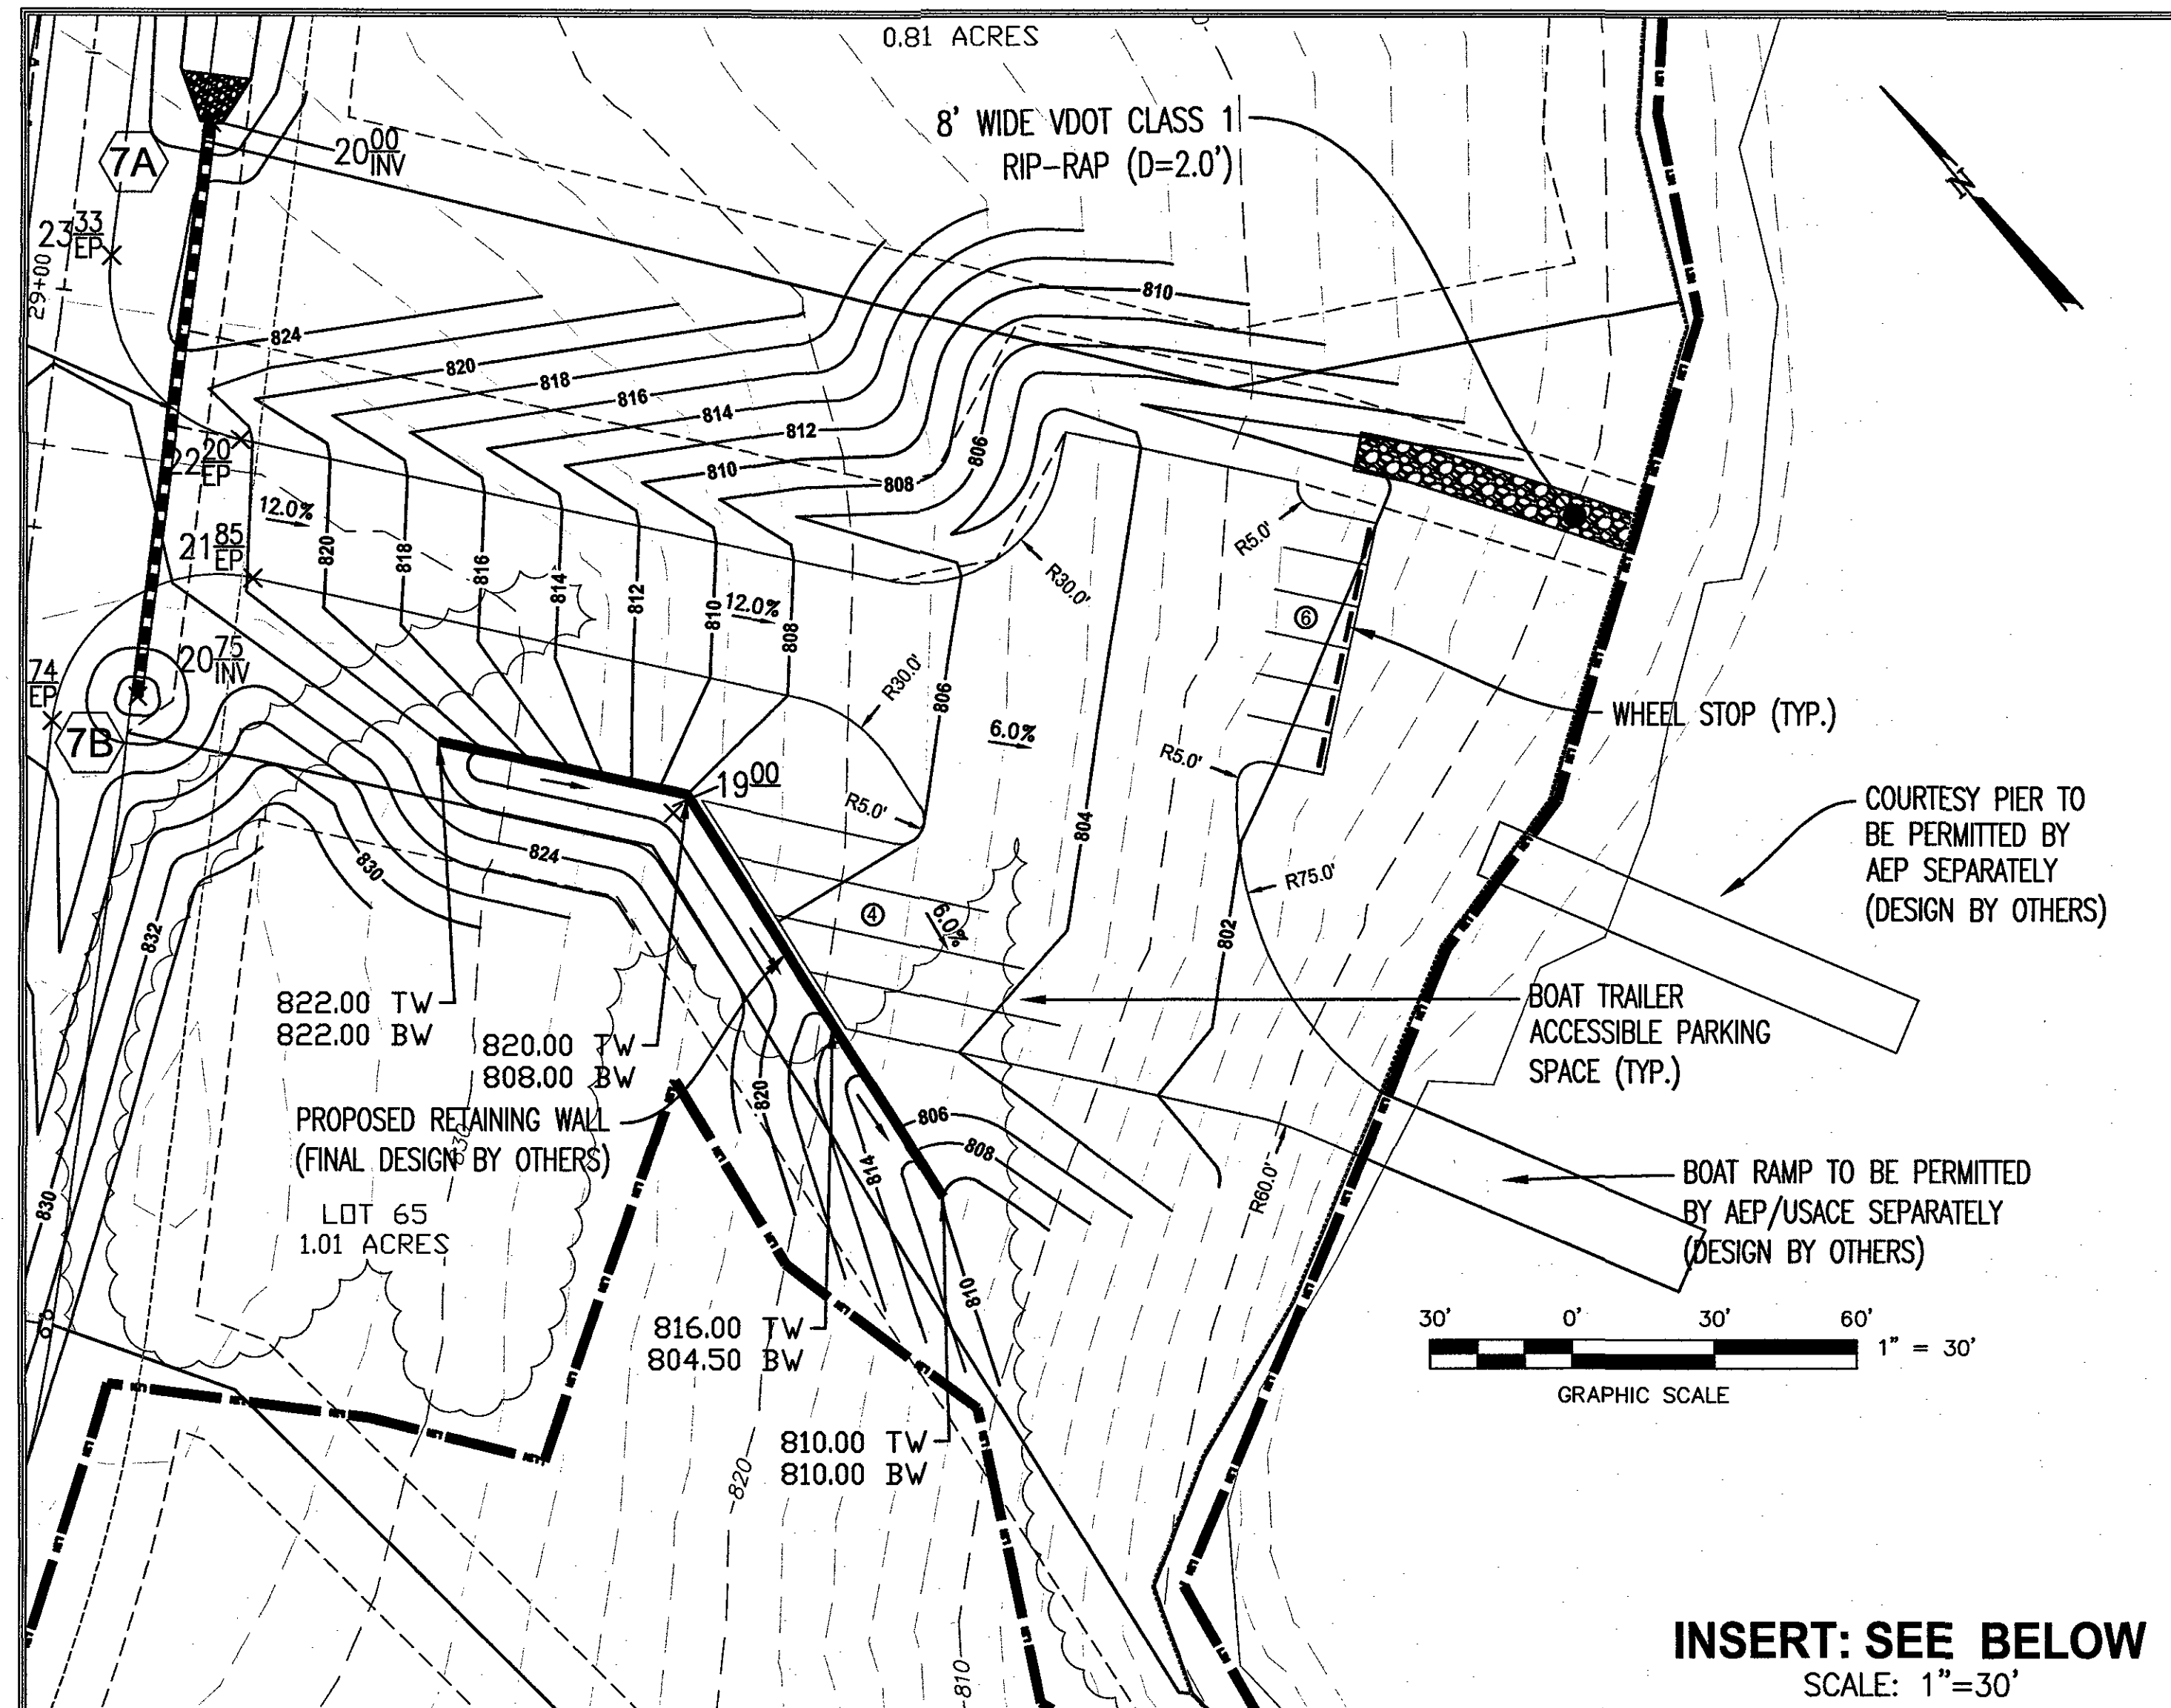


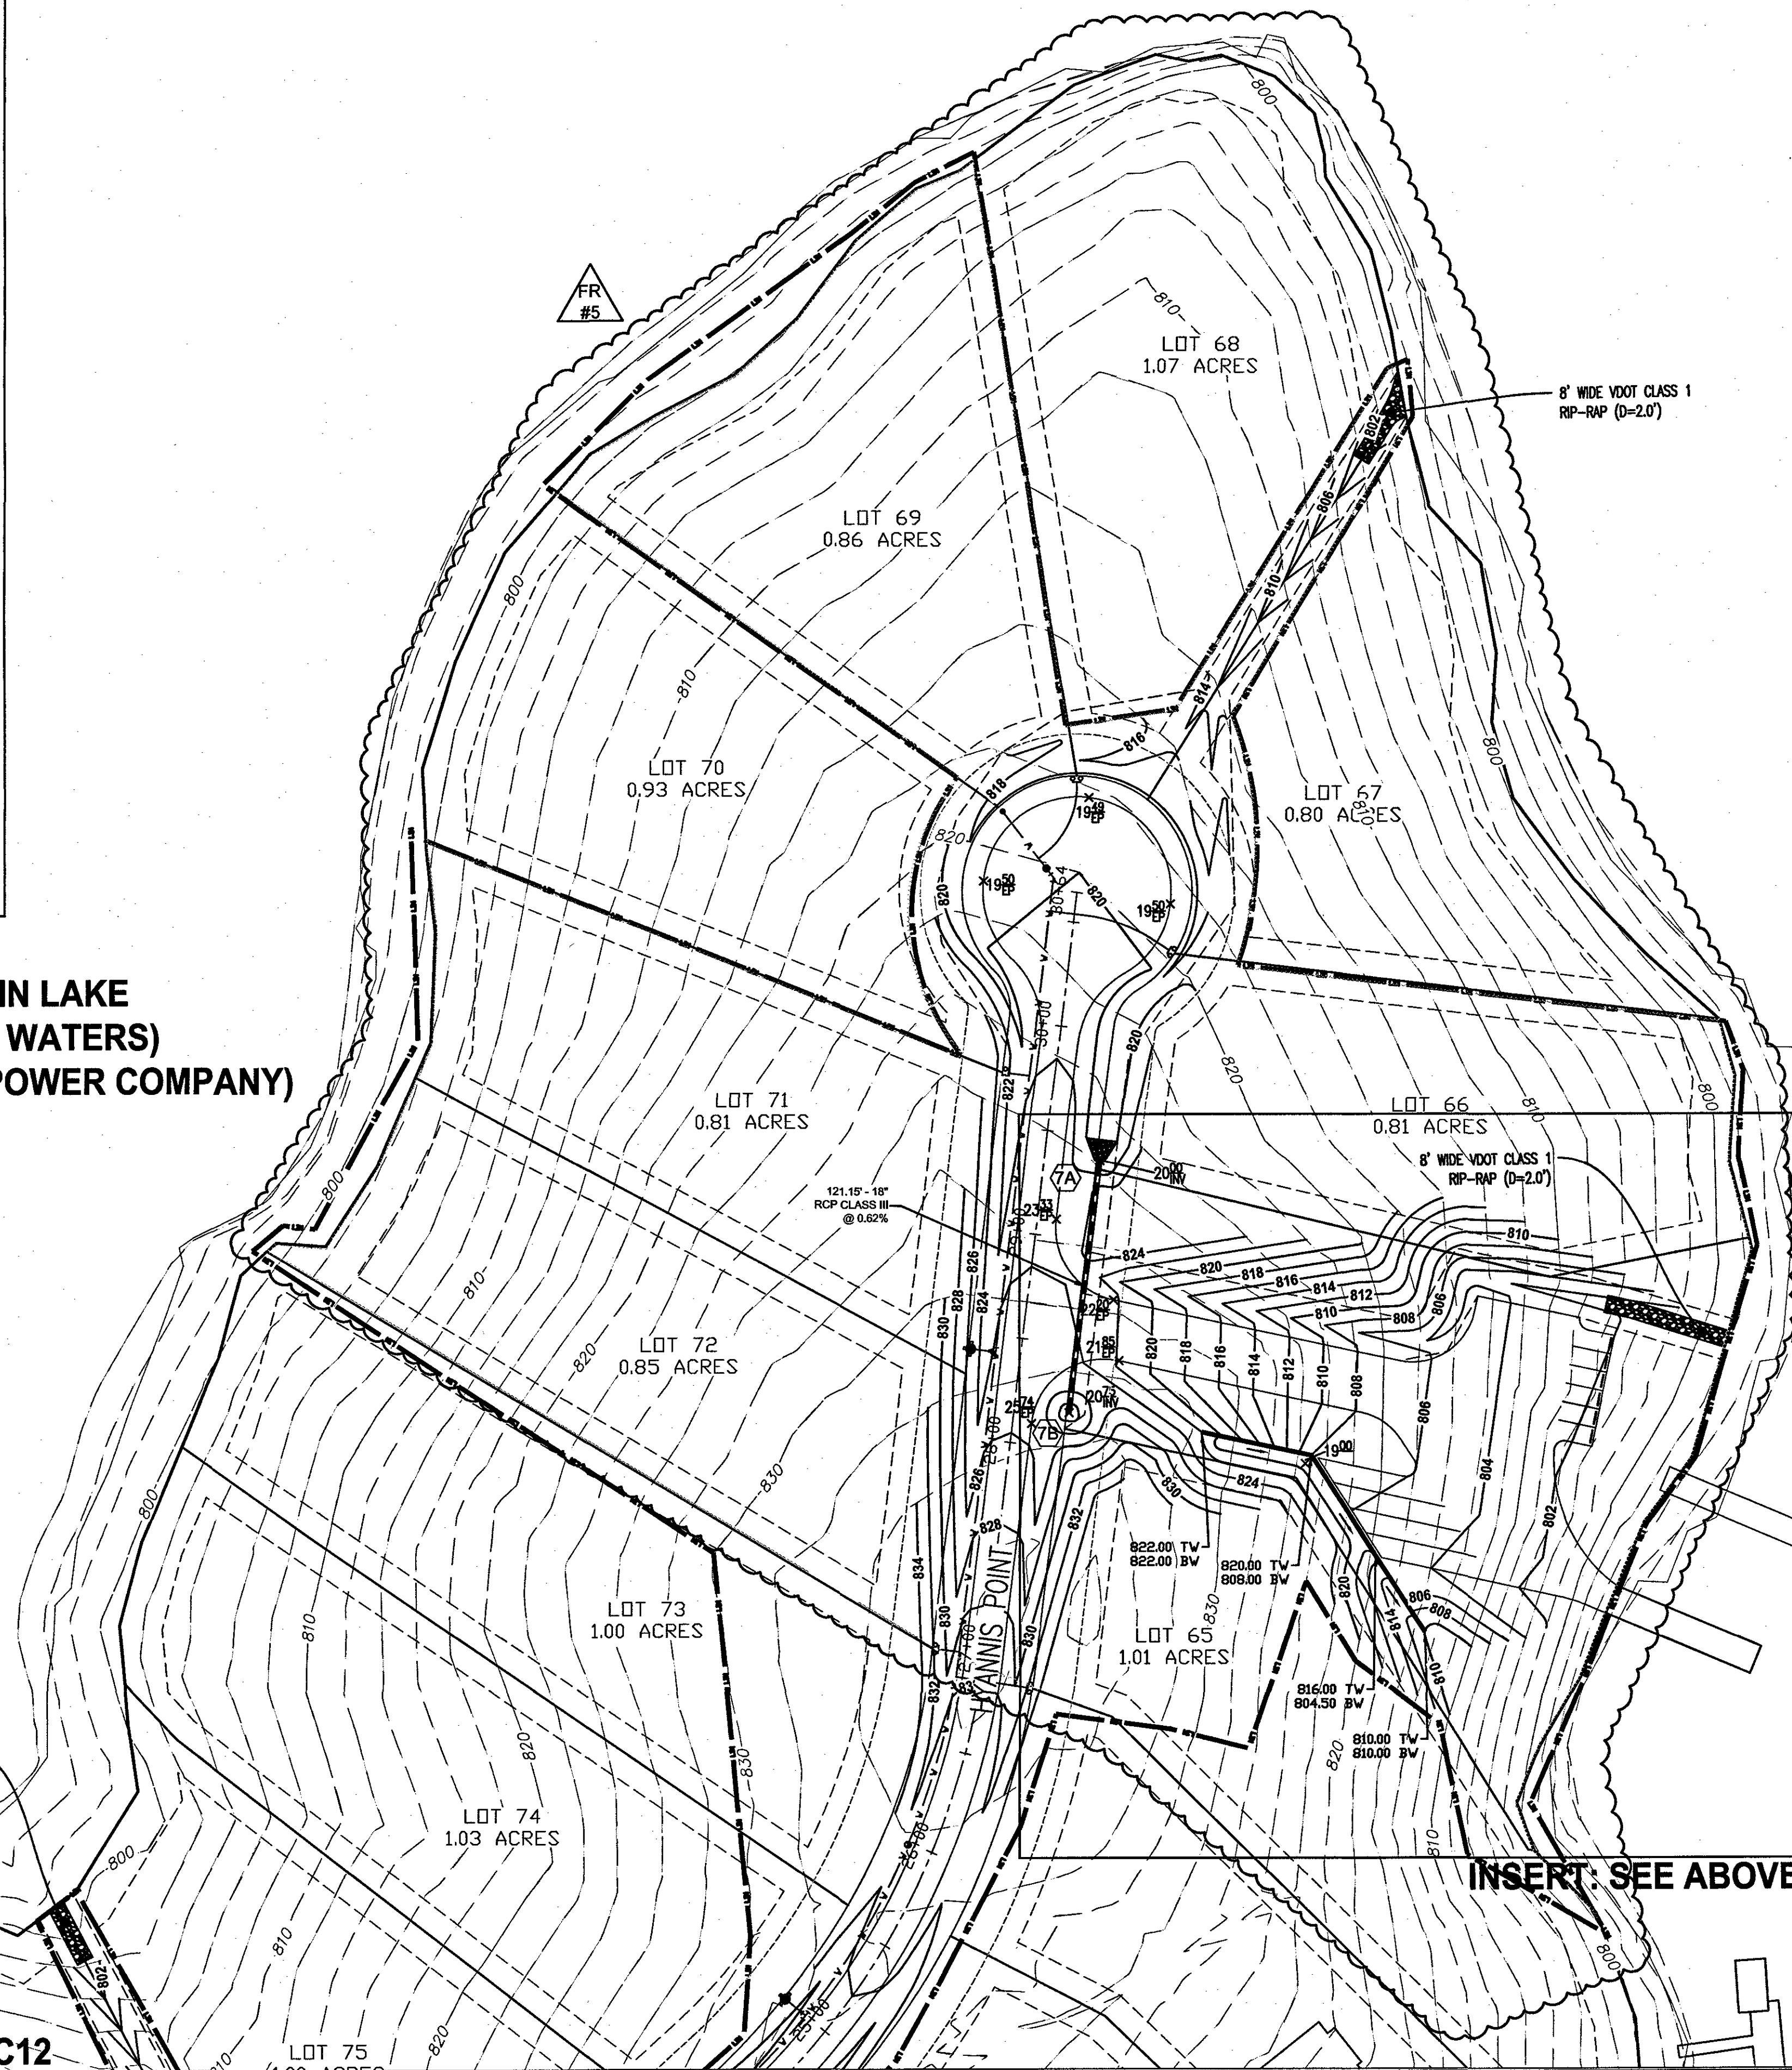

**SMITH MOUNTAIN LAKE
(JURISDICTIONAL WATERS)
(OWNER: APPALACHIAN POWER COMPANY)**

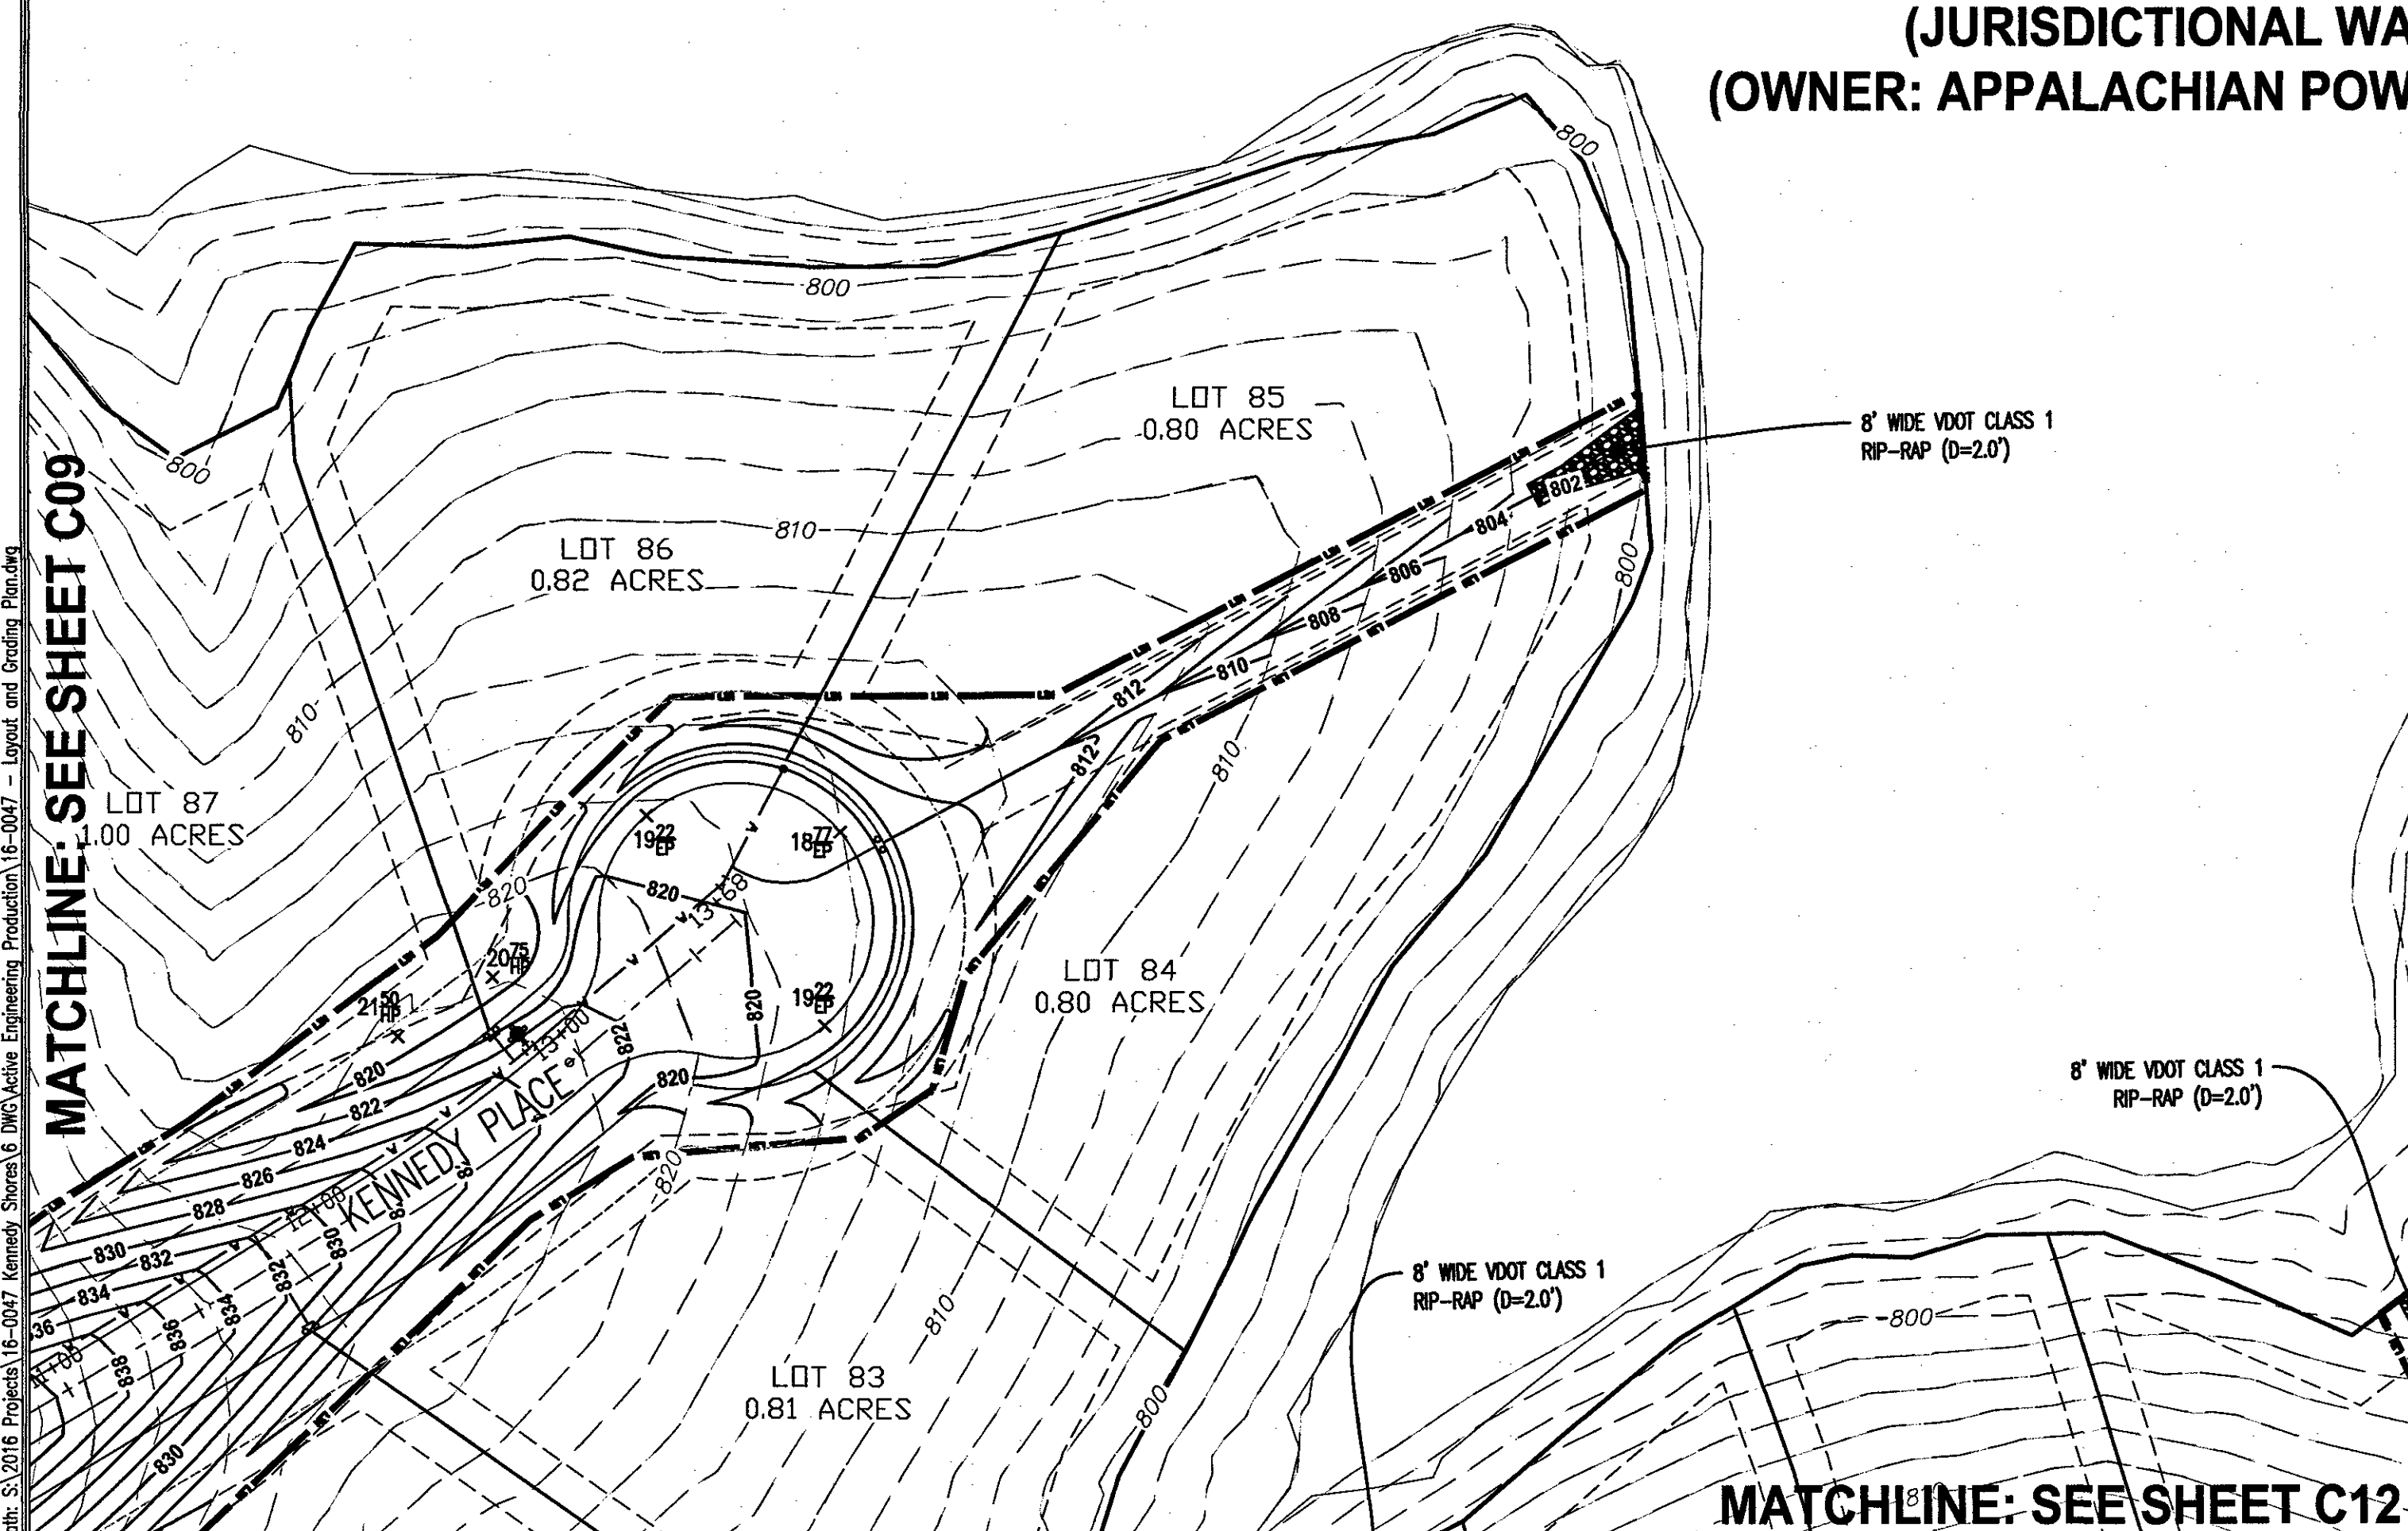

parker
DESIGN GROUP

2122 Carolina Ave. SW
Roanoke, VA 24014
Ph: 540-387-1153
Fax: 540-389-5767

1915-B W. Cary Street
Richmond, VA 23220
Phone: 804-358-2947
Fax: 804-359-9645
www.parkerdg.com

These documents are the property of Parker Design Group (PDG) and may not be reproduced or used without the express permission of PDG. Any reuse of these documents without authorization of PDG will be at the sole risk of the individual or entity utilizing said documents.

SHeldon R. BOWER
Lic. No. 039439
08/25/2017
PROFESSIONAL ENGINEER

**KENNEDY SHORES
SUBDIVISION DEVELOPMENT PLAN**

Tax # 0510001500
Franklin County, Virginia

REVISIONS:

DATE	DESCRIPTION
2/10/2017	1ST SUB COMMENTS
3/21/2017	2ND SUB COMMENTS
4/14/2017	3RD SUB COMMENTS
6/23/2017	FIELD REVISION #1
7/6/2017	FIELD REVISION #2
8/9/2017	FIELD REVISION #3
8/23/2017	FIELD REVISION #4

DESIGNED BY: JMM/SRB
DRAWN BY: JMM/JLK
CHECKED BY: SRB

DATE:
6 JANUARY, 2017

SHEET TITLE:
GRADING PLAN

SCALE:
1"=50'

SHEET NO.
C11