

INDEX OF SHEETS

SHEET NO.	1	TITLE SHEET
	1A	LOCATION MAP
	1B	RIGHT OF WAY DATA SHEET
	1C	REVISION DATA SHEET
	1D	MAINTENANCE OF TRAFFIC
	2	TYPICAL SECTIONS
	2A(1-2)	DRAINAGE TABULATION & SUMMARY
	2B-2D	DETAILS
	3-3A	PLAN AND PROFILE (STA. 12+97 TO STA. 16+75)
	3B	PROPERTY & UTILITY INFORMATION
	3C	ENTRANCE PROFILES
	4-4B	PLAN AND PROFILES (STA. 16+75 TO STA. 24+25)
	5-5B	PLAN AND PROFILES (STA. 24+25 TO STA. 28+51)
	6	JEFFERSON STREET PLAN
	6A	DETAILS
	7(1-5)	ROADWAY LIGHTING PLANS
	8(1-7)	LANDSCAPING PLANS
	9(1-6)	UTILITY ADJUSTMENT PLANS

17 SHEETS OF CROSS SECTIONS



FHWA-534 DATA 3J003

COMMONWEALTH OF VIRGINIA

DEPARTMENT OF HIGHWAYS AND TRANSPORTATION


PLAN AND PROFILE OF PROPOSED
STATE HIGHWAY

CITY OF ROANOKE

WELLS AVENUE

FROM: I ST. STREET, N.W.
TO: WILLIAMSON ROAD (BUS. ROUTE 11)

DESCRIPTION REFERENCE
EXIST. I ST. STREET
PROP CONST. CENTERLINE OF WELLS AVE.

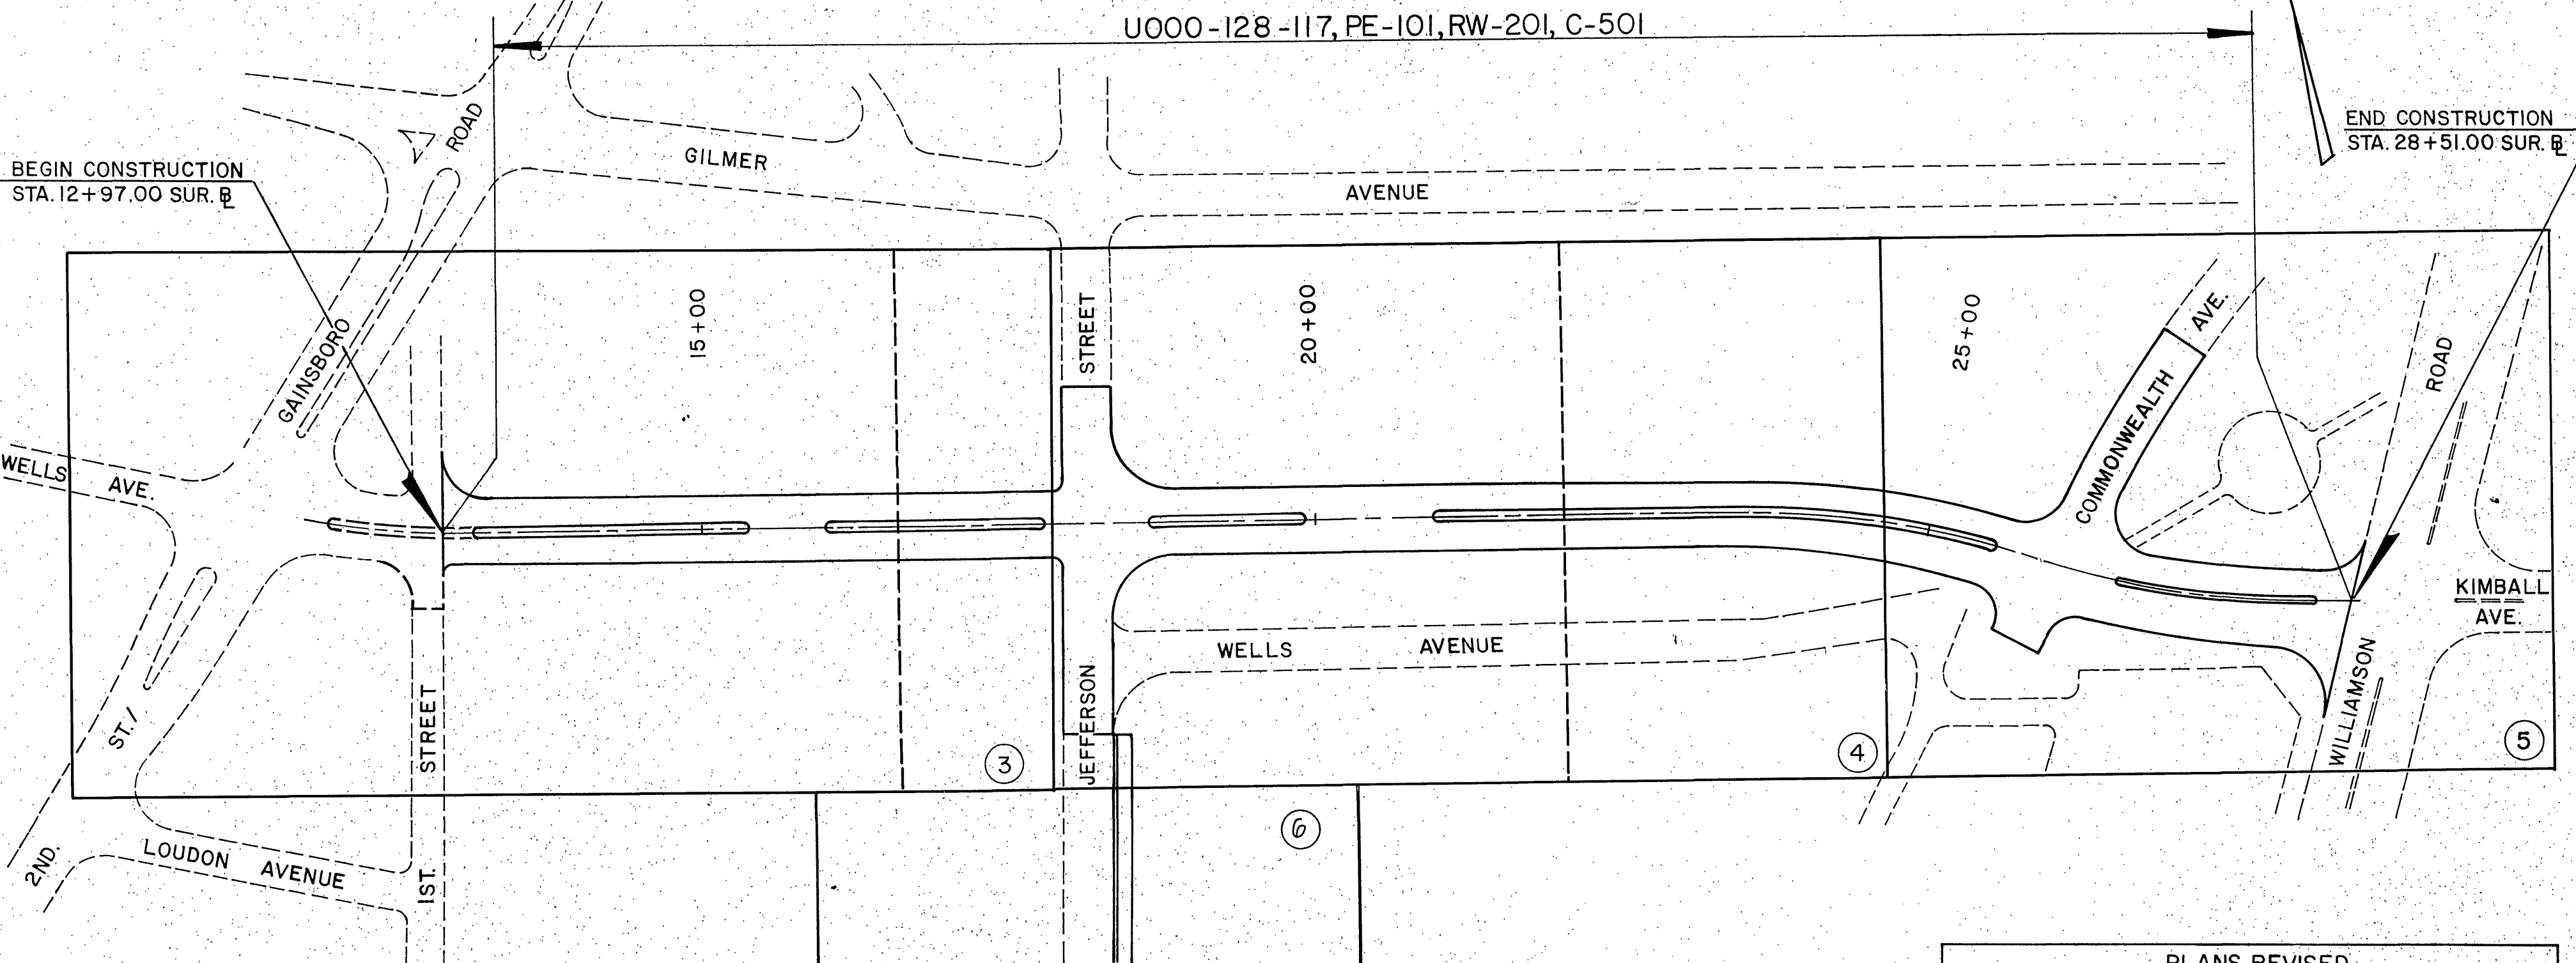

CITY OF ROANOKE POPULATION = 96,397 (1990 CENSUS)

STATE PROJ. NOS.	FHWA TYPE CODE	SECTION	PPMS NO.	FED. AID PROJ. NO.	EQUALITIES FEET	LENGTH INCL. BR. & BOX CULVS. FEET	LENGTH EXCL. BR. & BOX CULVS. FEET	TYPE PROJECT	DESCRIPTION
		PE-101	4679			1554.00	0.294	PREL. ENGR.	
		RW-201	4679			1554.00	0.294	R.O.W.	
		C-501	4679			1554.00	0.294	CONST.	FROM: I ST. STREET, N.W. TO: WILLIAMSON ROAD (BUS. ROUTE 11)

NOTE: LENGTH OF PROJECT BASED ON CONSTRUCTION CENTERLINE

FHWA REGION	STATE	FEDERAL AID PROJECT	ROUTE	STATE PROJECT	SHEET NO.	TOTAL SHEETS
3	VA.		WELLS AVE.	U000-128-117 SEE TABULATION BELOW FOR SECTION NUMBERS	1	

DESIGN	CLASSIFICATION
URBAN LOCAL STREET	DIVIDED-ROLLING 30 MPH MIN. DESIGN SPEED
	Fr: 2ND STREET, SW. To: WILLIAMSON ROAD
ADT 1988	6550
ADT 2010	19,000
DHV	
D (%)	
T (%)	
V (MPH)	*

* SEE PLAN AND PROFILE SHEETS FOR HORIZONTAL & VERTICAL CURVE DESIGN SPEED.

THESE PLANS ARE UNFINISHED
AND ARE NOT TO BE USED FOR
ANY TYPE OF CONSTRUCTION.

RECOMMENDED FOR APPROVAL FOR RIGHT OF WAY ACQUISITION	
8/20/93	DATE
8/24/93	DATE
8-24-93	DATE
8/24/93	DATE
	DATE

APPROVED FOR RIGHT OF WAY ACQUISITION	
8/24/93	DATE

RECOMMENDED FOR APPROVAL FOR CONSTRUCTION	
	DATE
	DATE
	DATE
	DATE

APPROVED FOR CONSTRUCTION	
	DATE

APPROVED	
	DATE

COPYRIGHT 1993, COMMONWEALTH OF VIRGINIA

PLAN NO.	PROJECT	FILE NO.	SHEET NO.
A	U000-128-117		1

CODE NO. 6010