

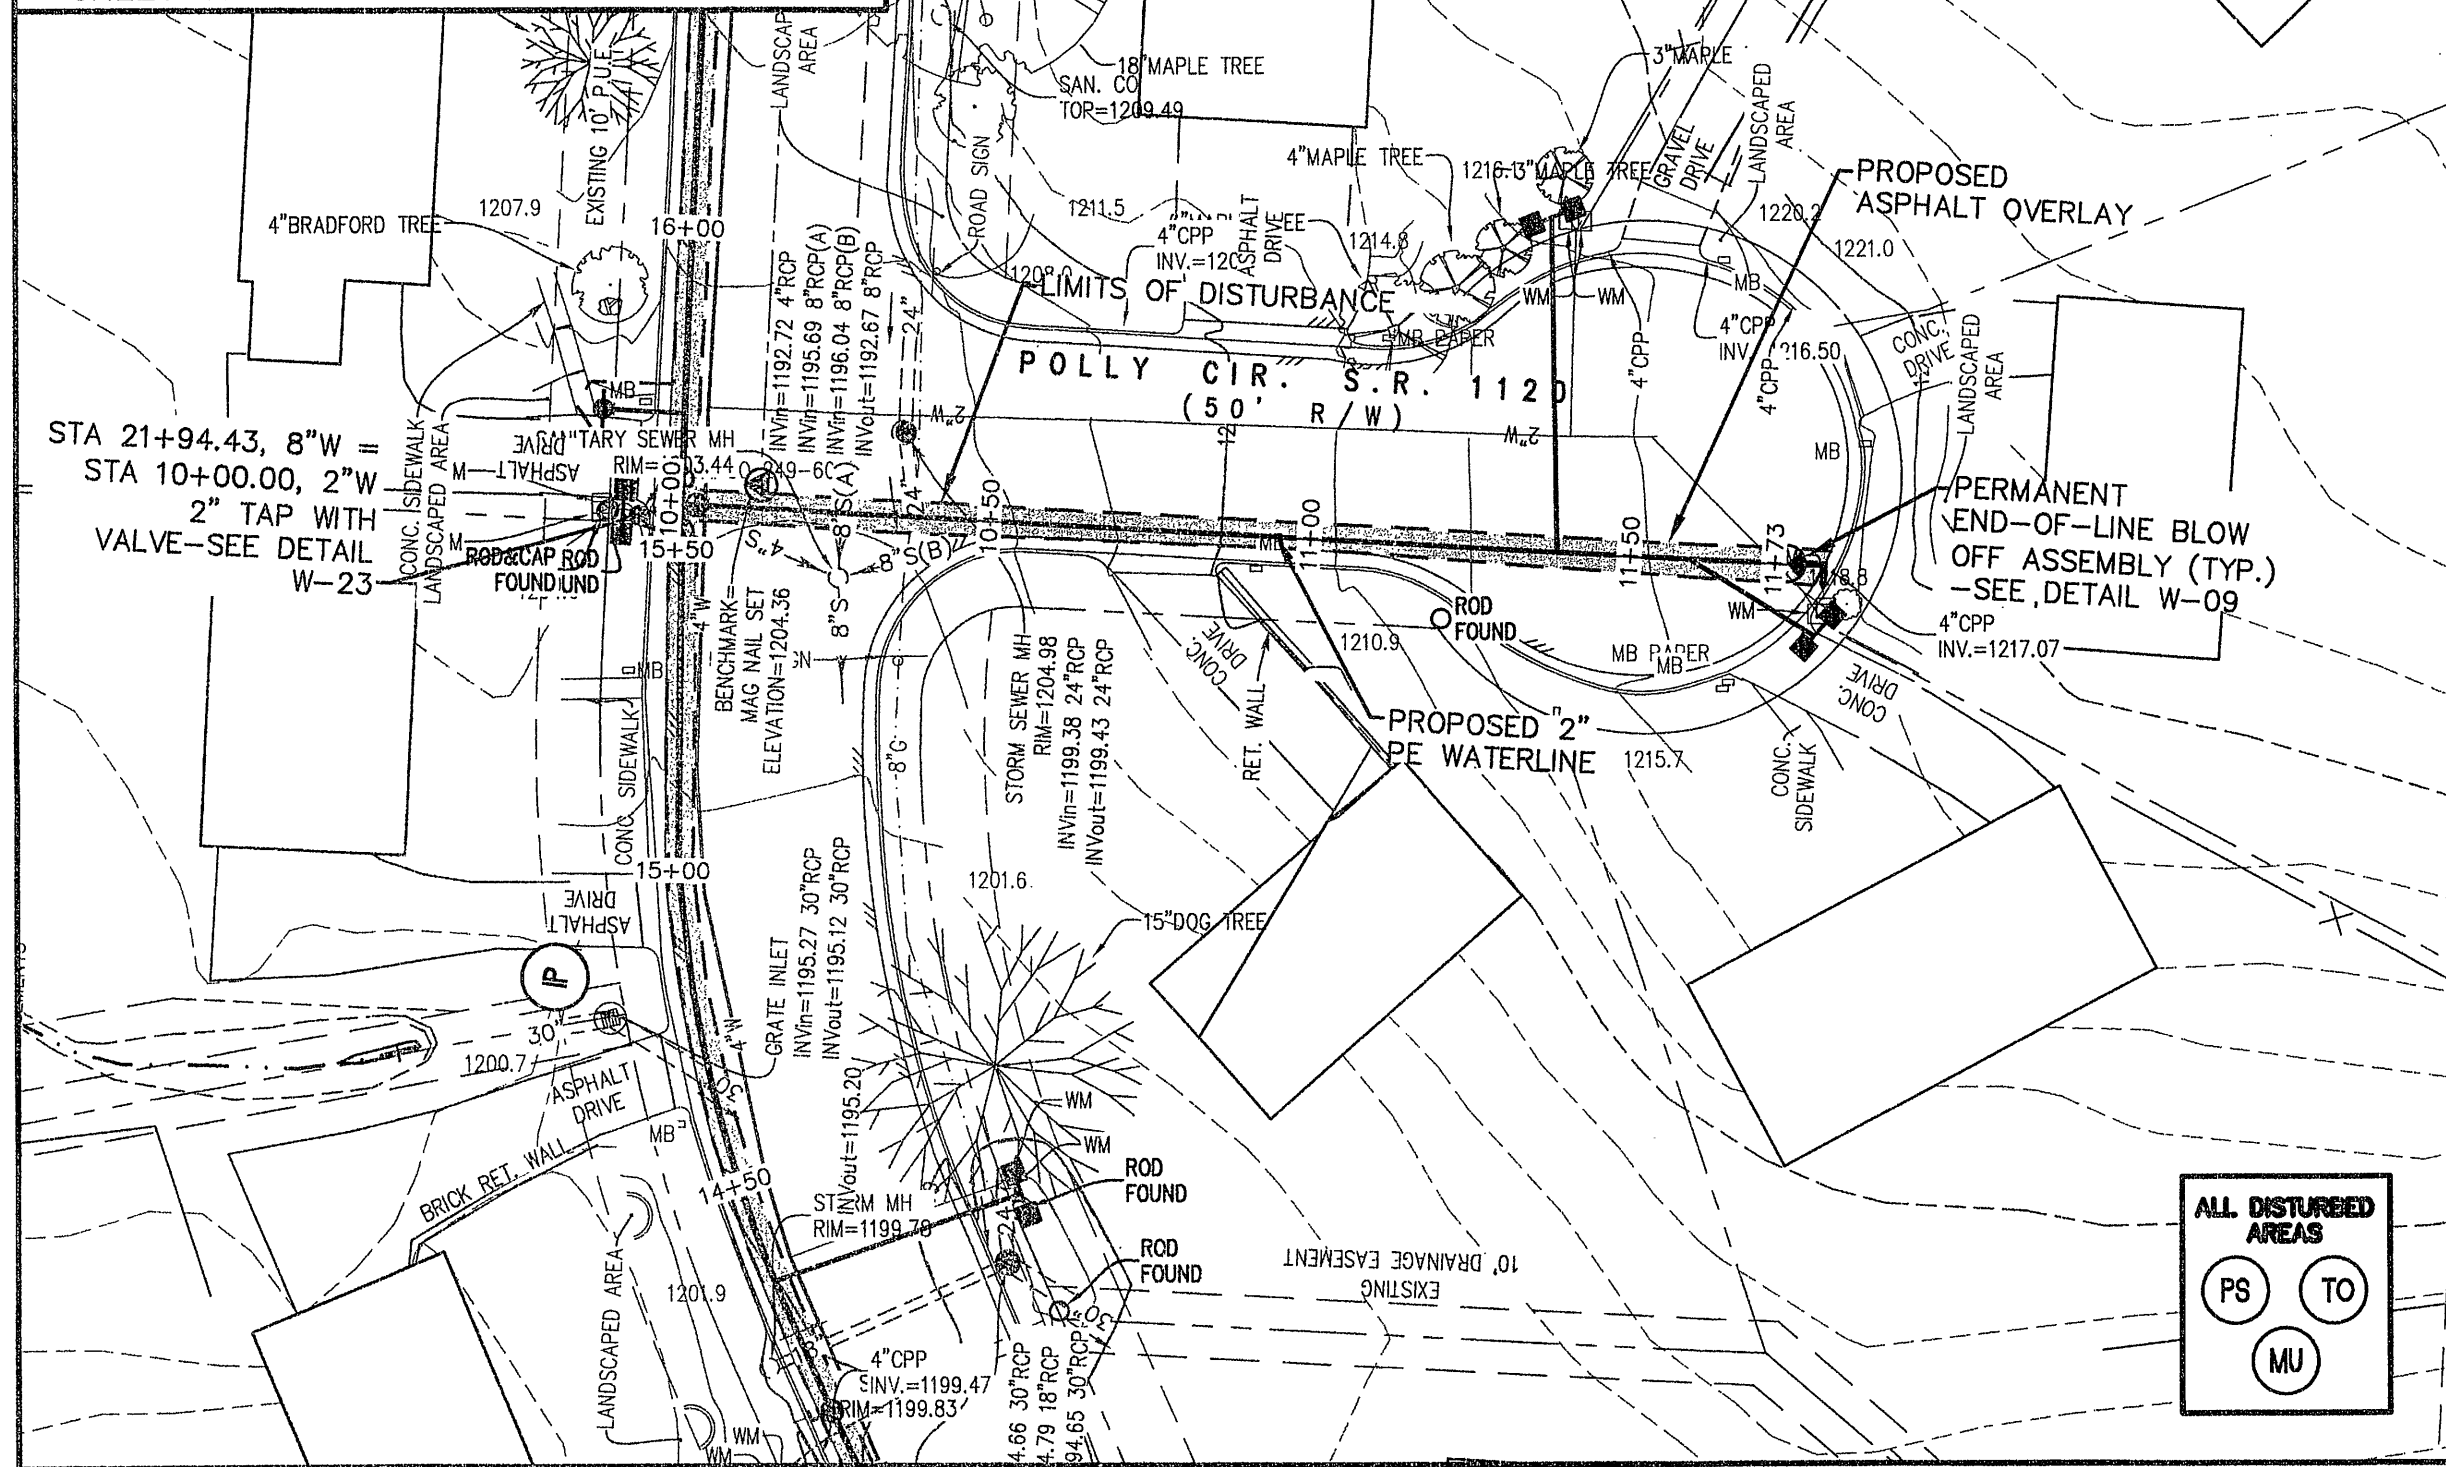
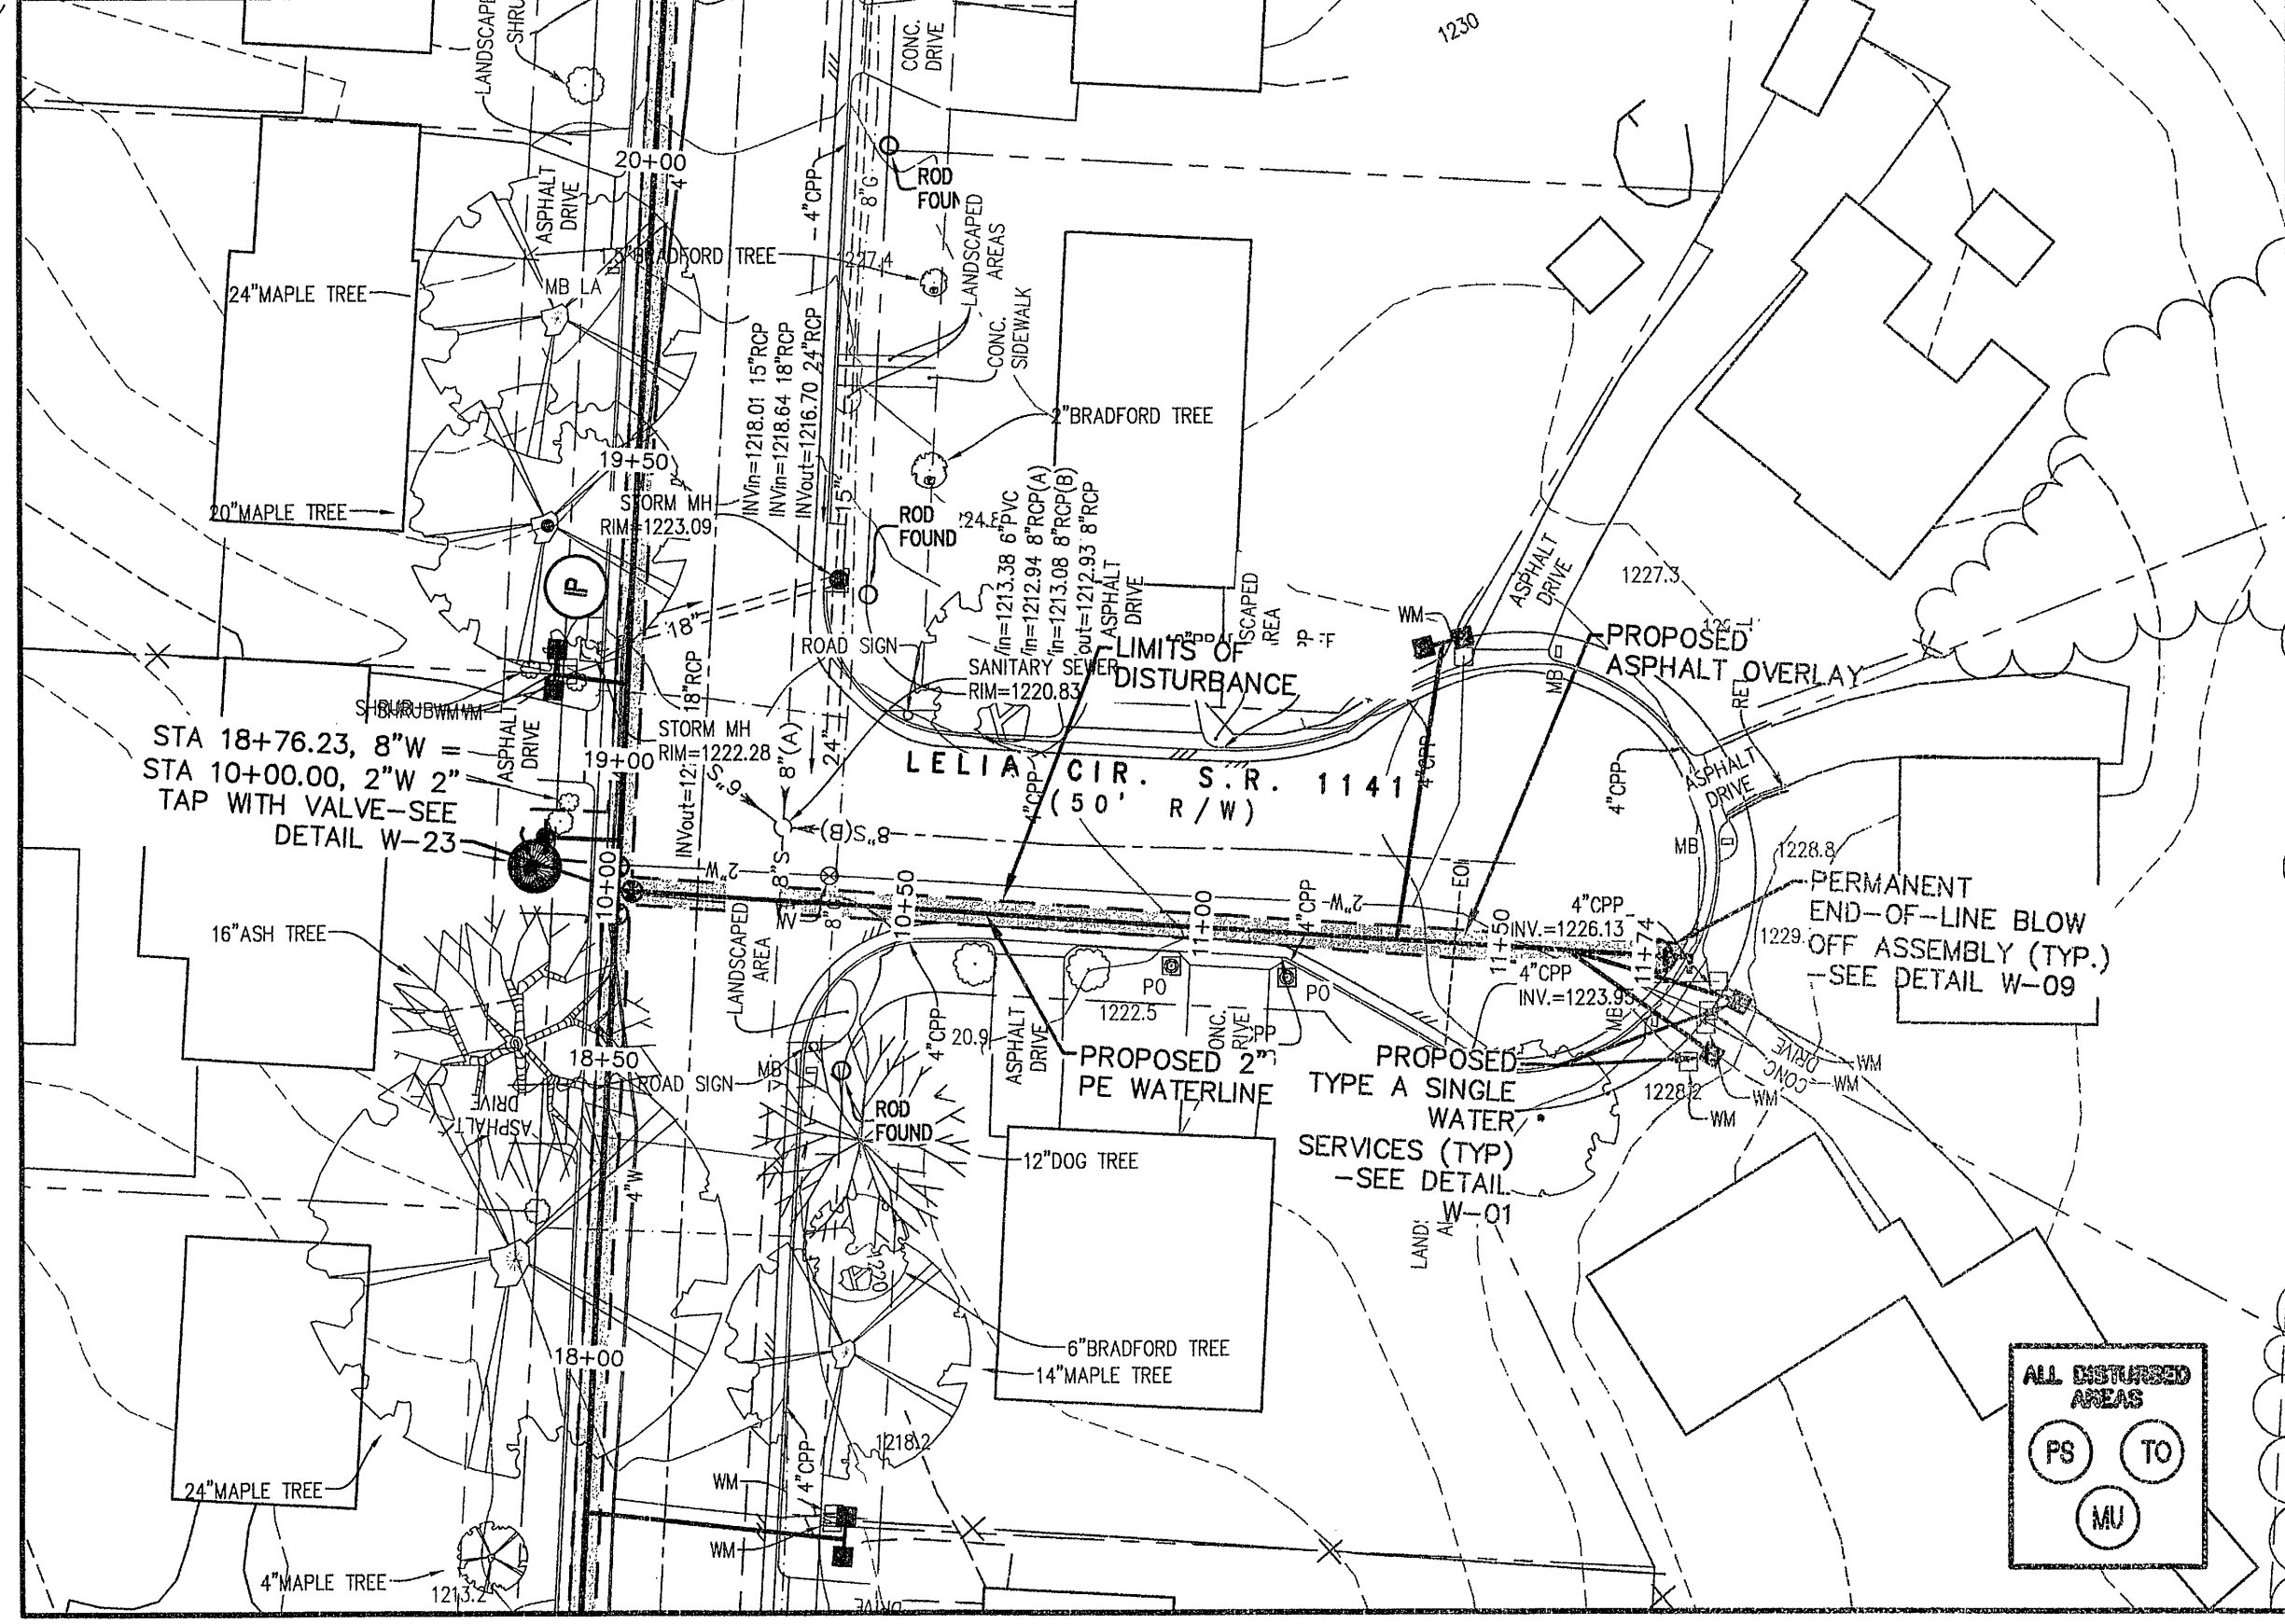




NOTE:
1. FOR INFORMATION REGARDING EROSION CONTROL FOR WATER SERVICE INSTALLATION, SEE DETAIL ON SHEET C2-04
2. FOR INFORMATION REGARDING MATERIAL STOCKPILING GUIDELINES, SEE DETAIL ON SHEET C2-04

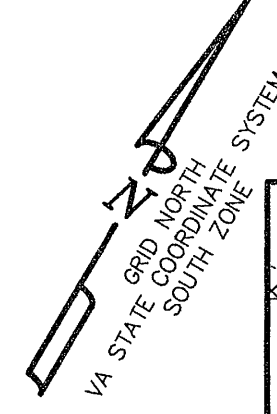


POLY CIRCLE PLAN
SCALE: 1"=30'

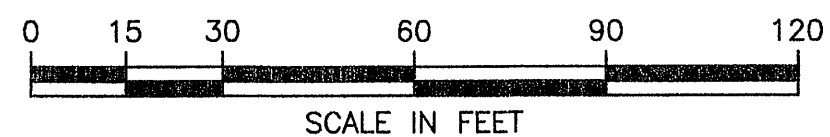

LELIA CIRCLE PLAN
SCALE: 1"=30'

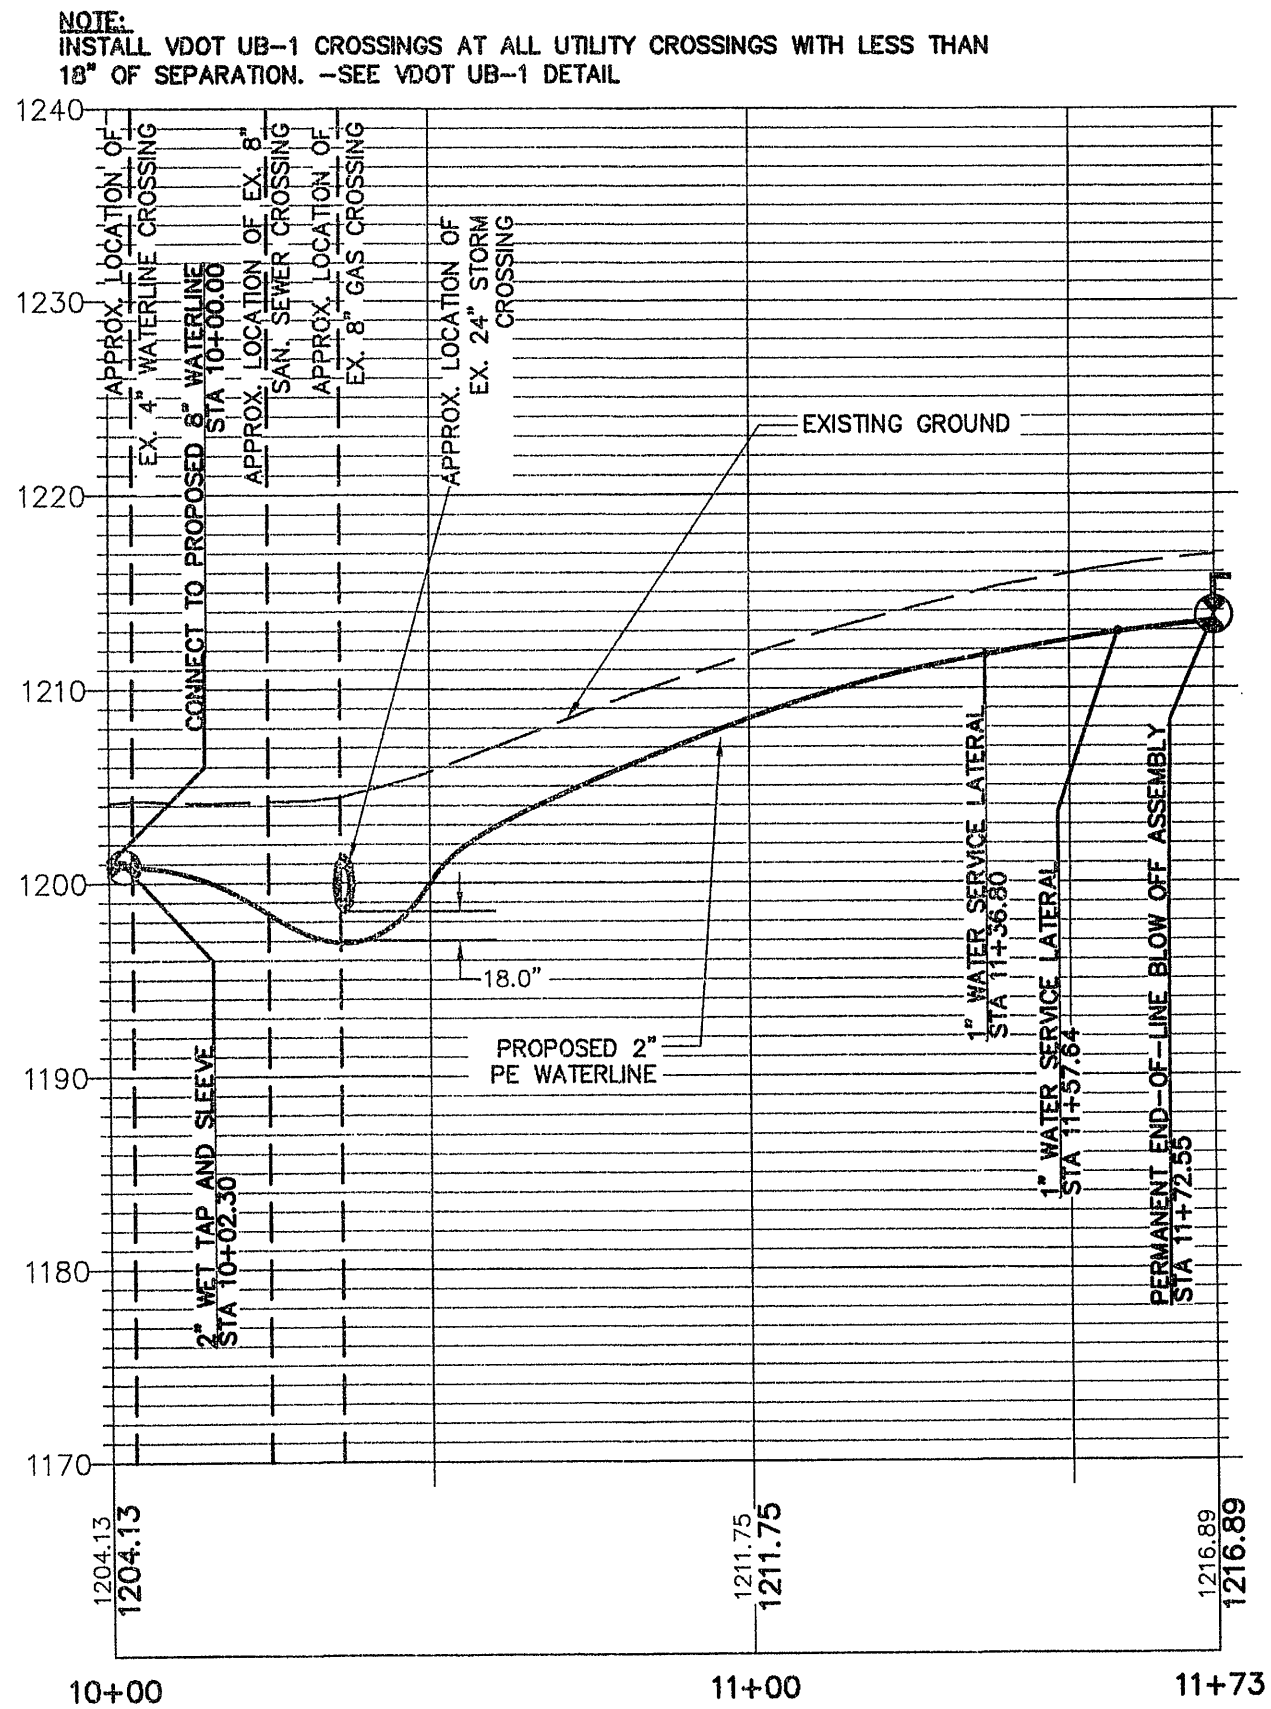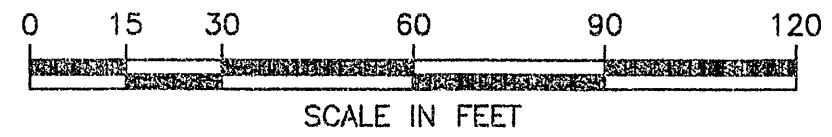

POLY CIRCLE PROFILE
SCALE: 1"=30'H, 1"=10'V

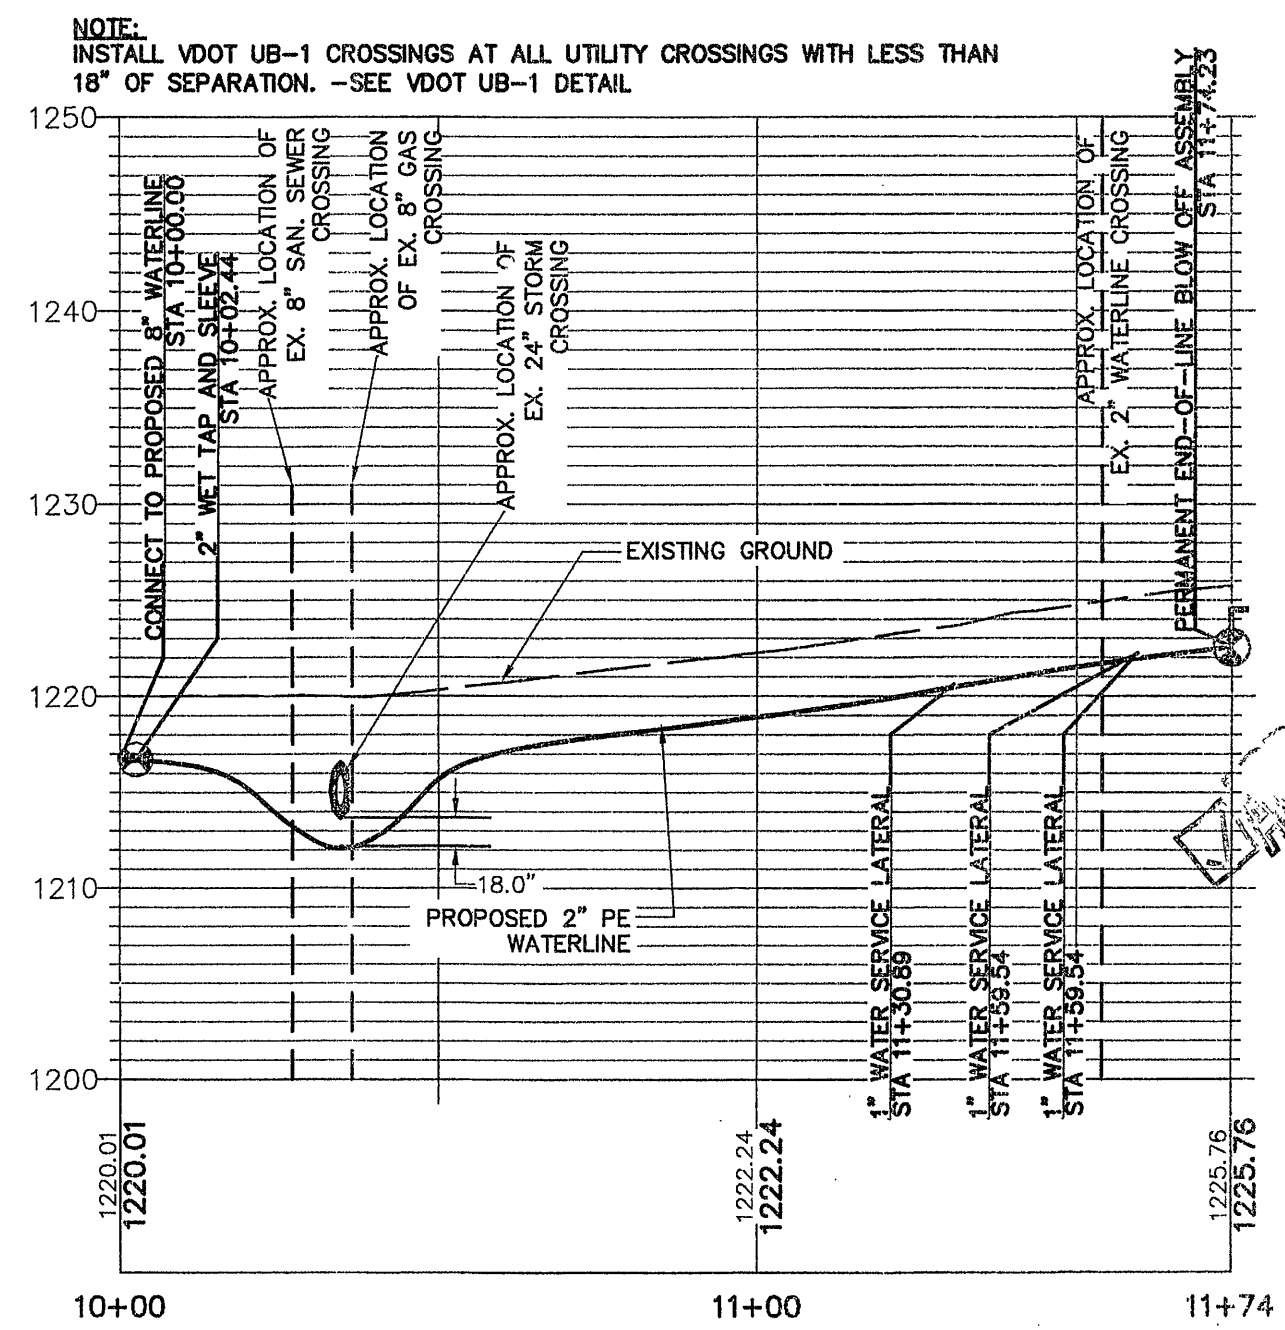


LELIA CIRCLE PROFILE
SCALE: 1"=30'H, 1"=10'V

GAY AND NEEL, INC.
CIVIL ENGINEERING
LAND PLANNING
SURVEYING
328 Mountain Avenue S.W.
Roanoke, Virginia 24016
Phone: (540) 345-1110 Fax: (540) 345-5560
Email: info@gayandneel.com

Poly Circle and Lelia Circle

Ingall Boulevard Waterline Replacement
Roanoke County, Virginia

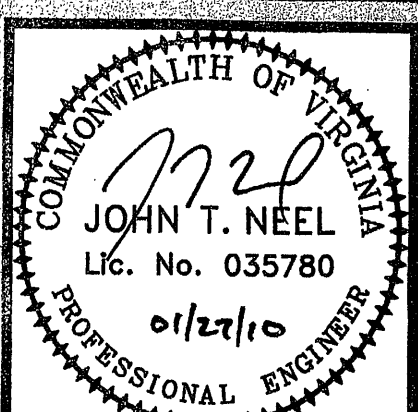

REVISED:	11/30/09
DESIGNED/CALC.:	TMK
CHECKED:	
DRAWN:	RWA
SCALE:	1"=30'
DATE:	01/08/09
JOB NO.	2119.0
SHEET	C1-05