

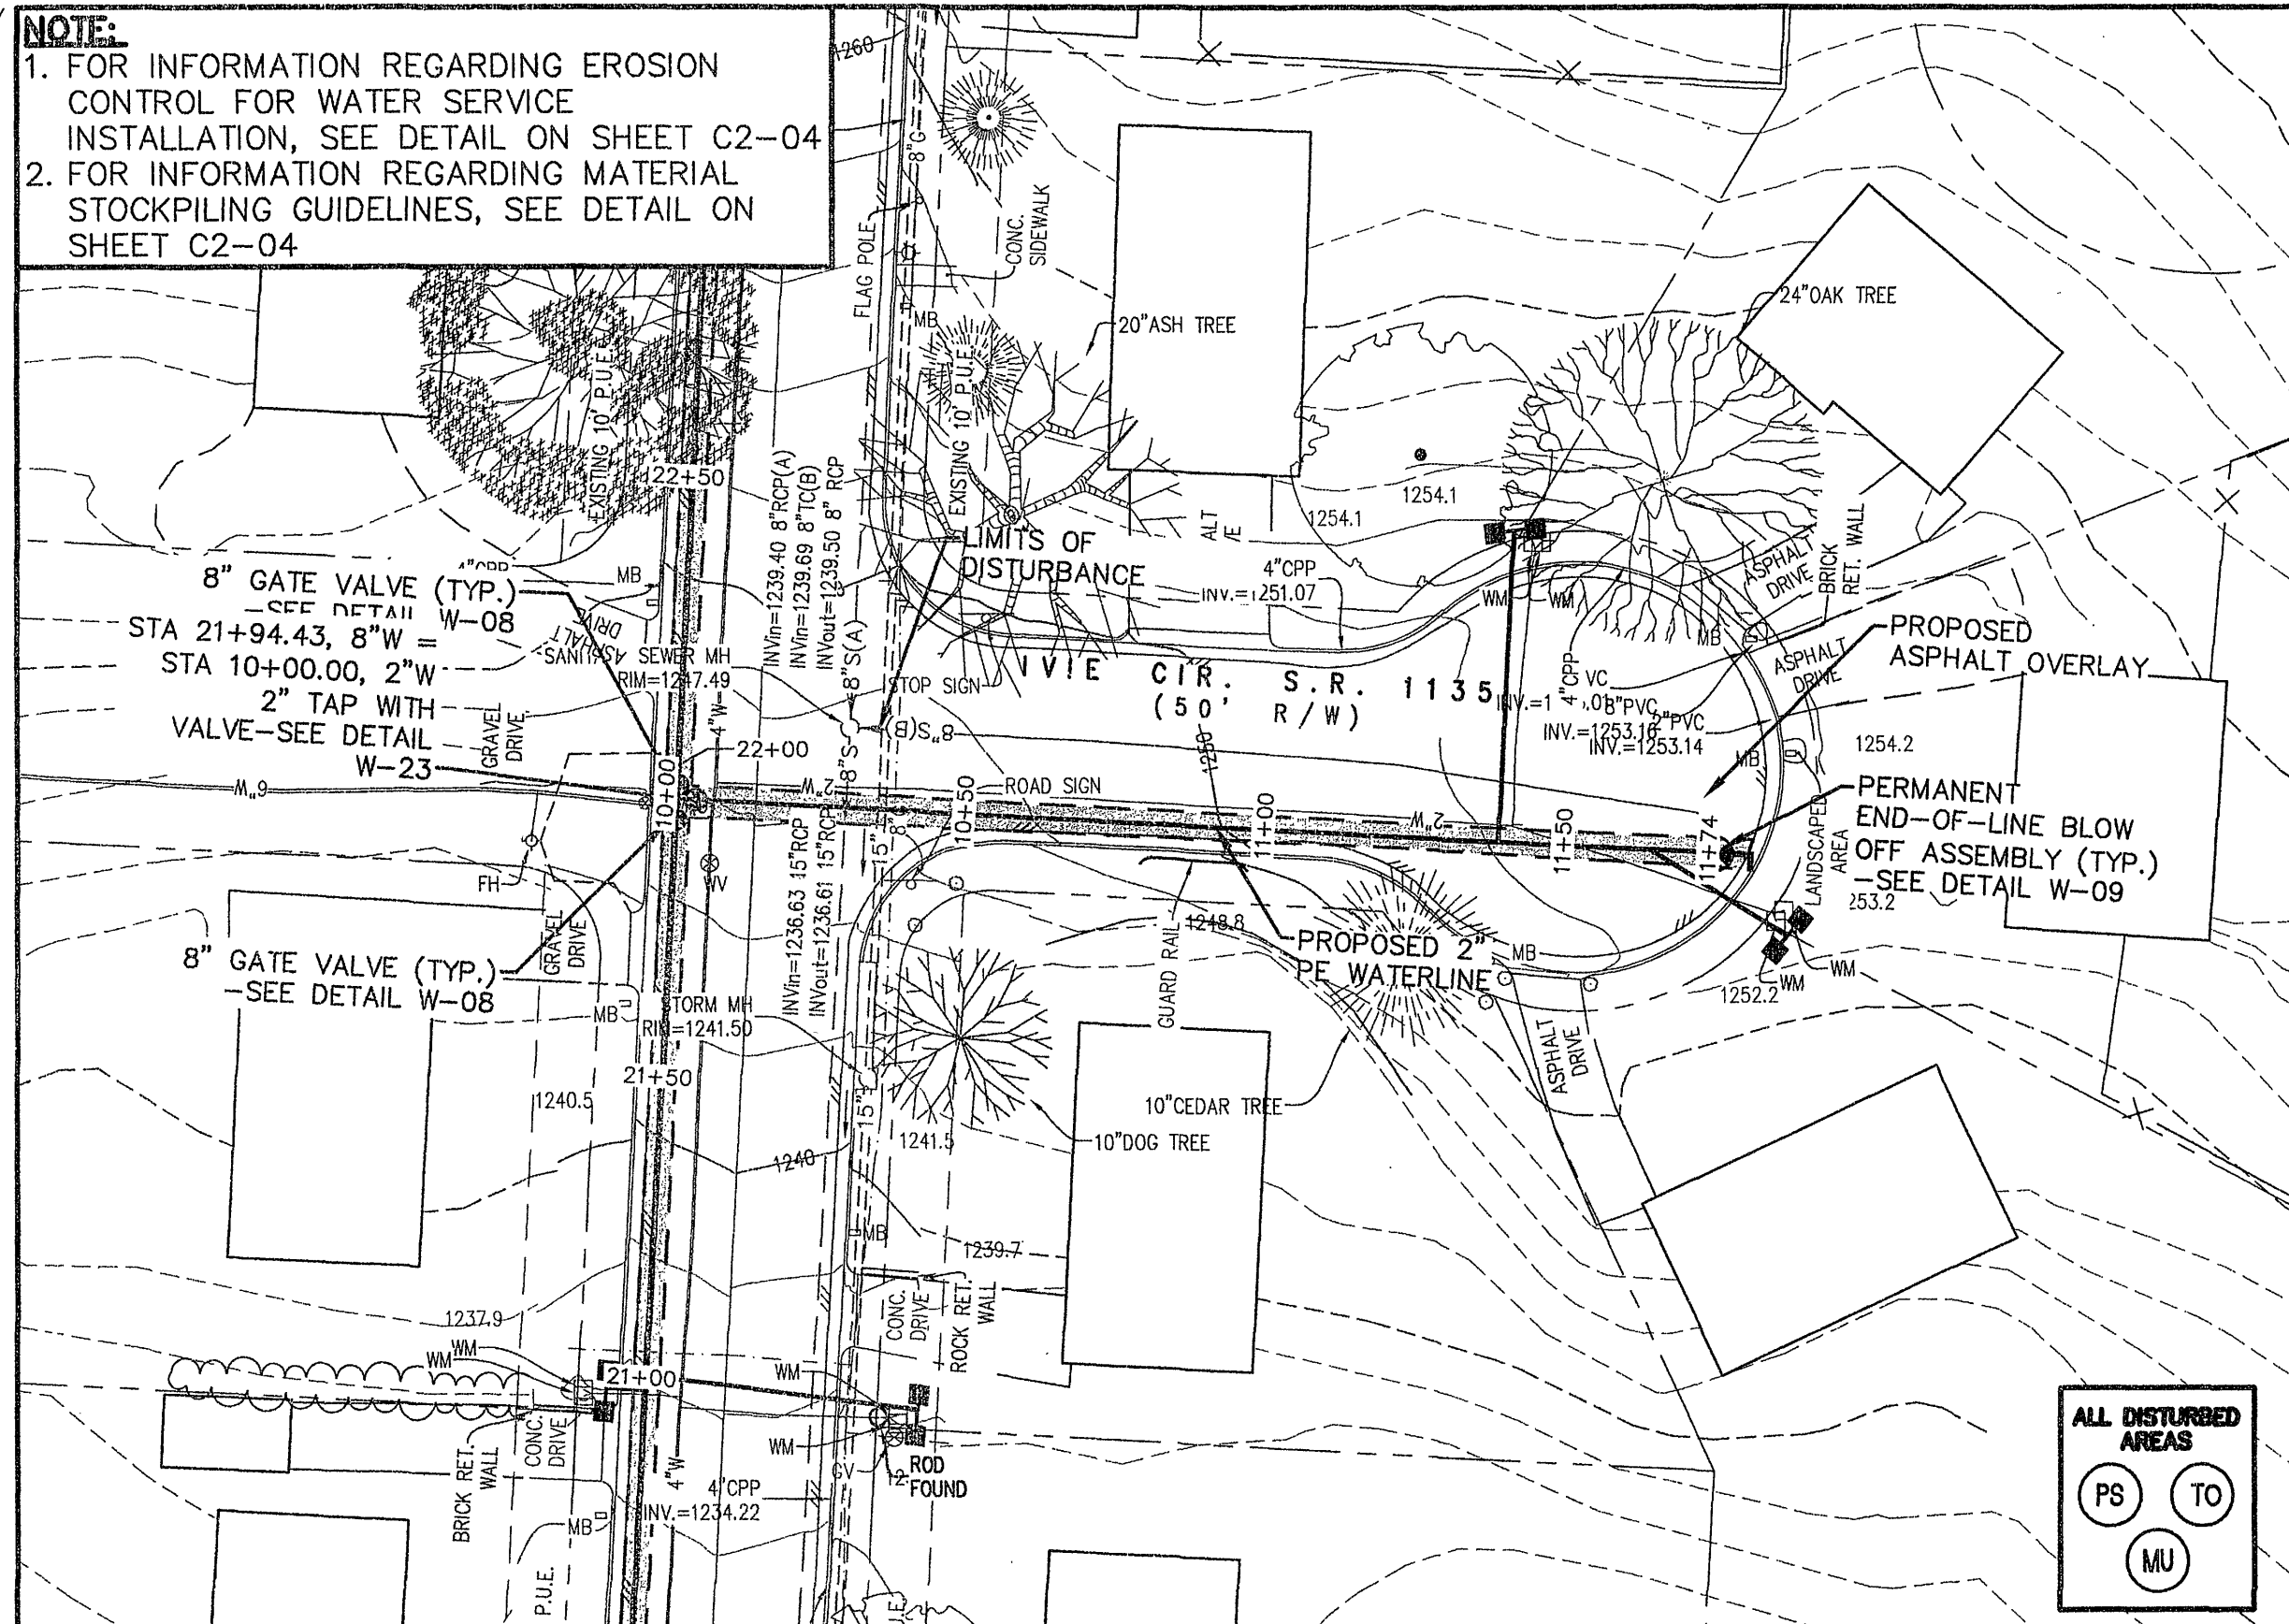
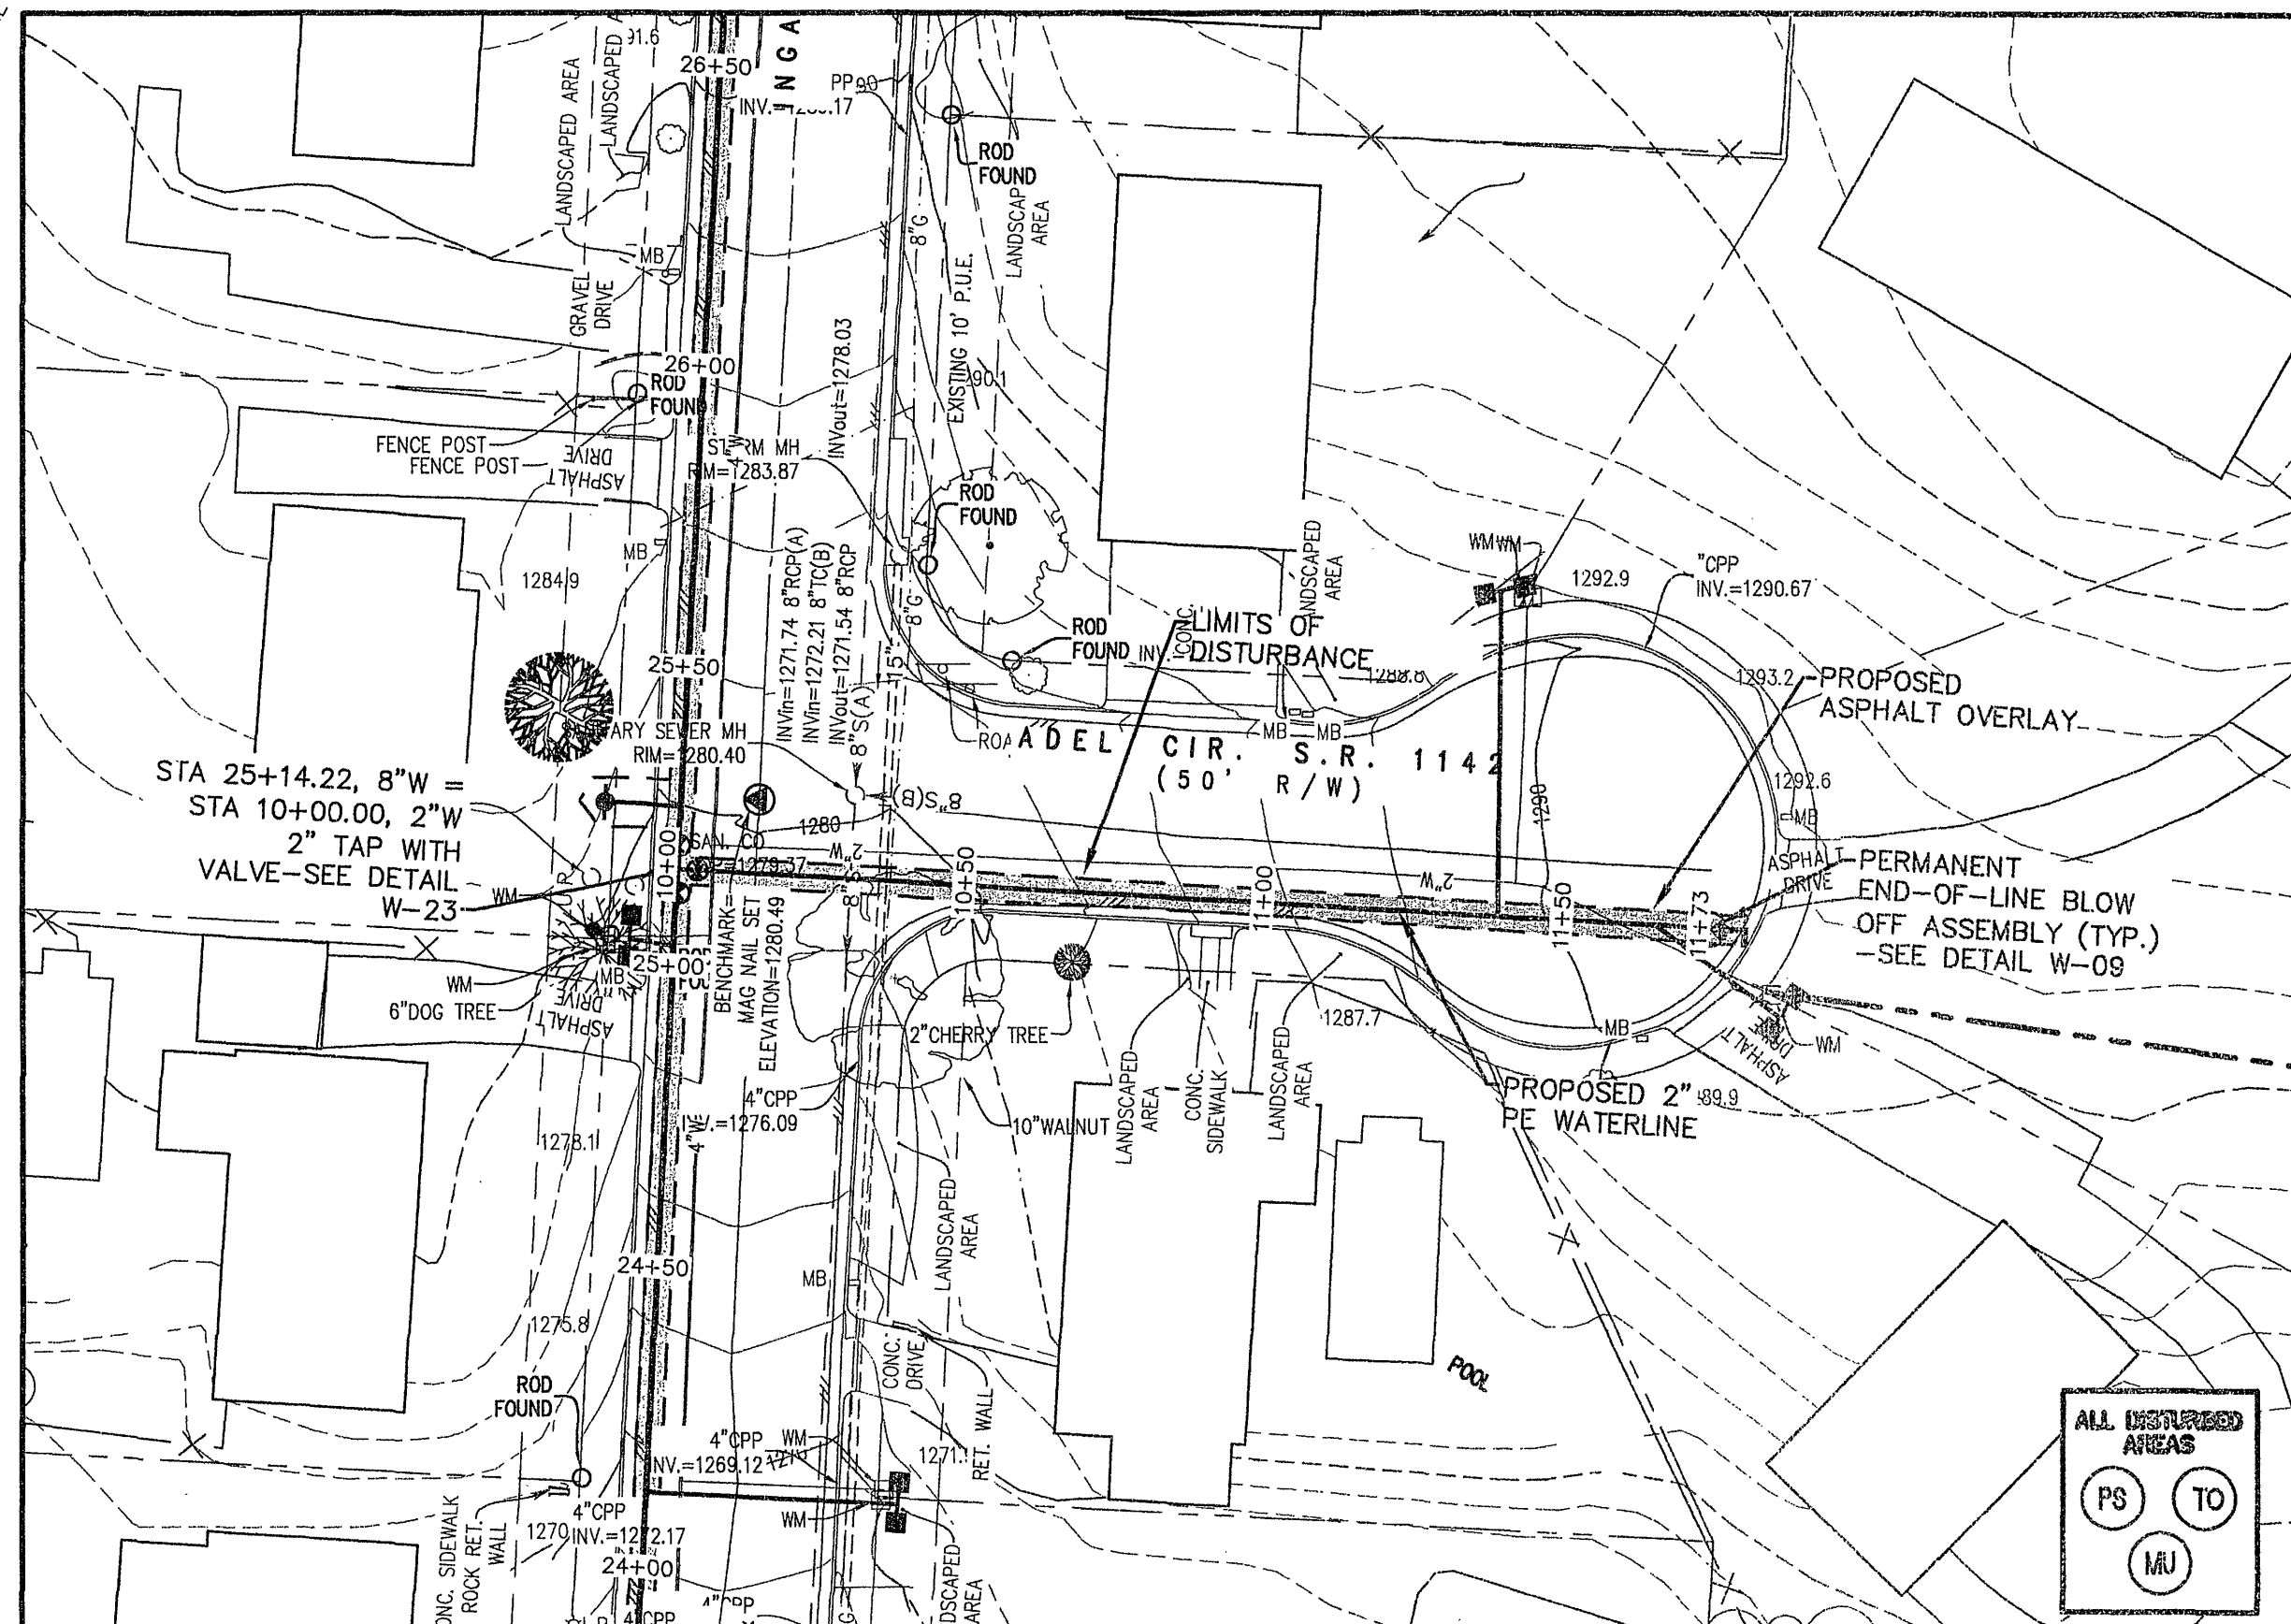




- NOTE:**
1. FOR INFORMATION REGARDING EROSION CONTROL FOR WATER SERVICE INSTALLATION, SEE DETAIL ON SHEET C2-04
 2. FOR INFORMATION REGARDING MATERIAL STOCKPILING GUIDELINES, SEE DETAIL ON SHEET C2-04

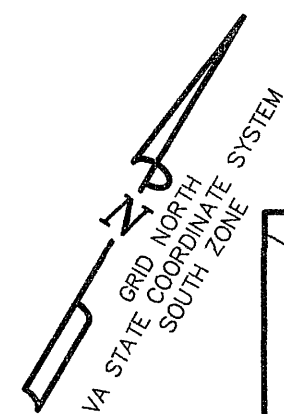


IVIE CIRCLE PLAN
SCALE: 1"=30'

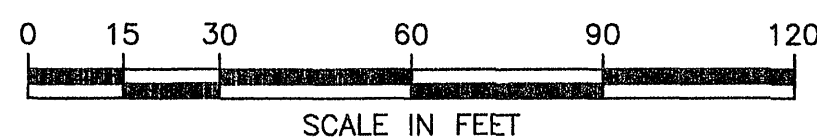

ADEL CIRCLE PLAN
SCALE: 1"=30'

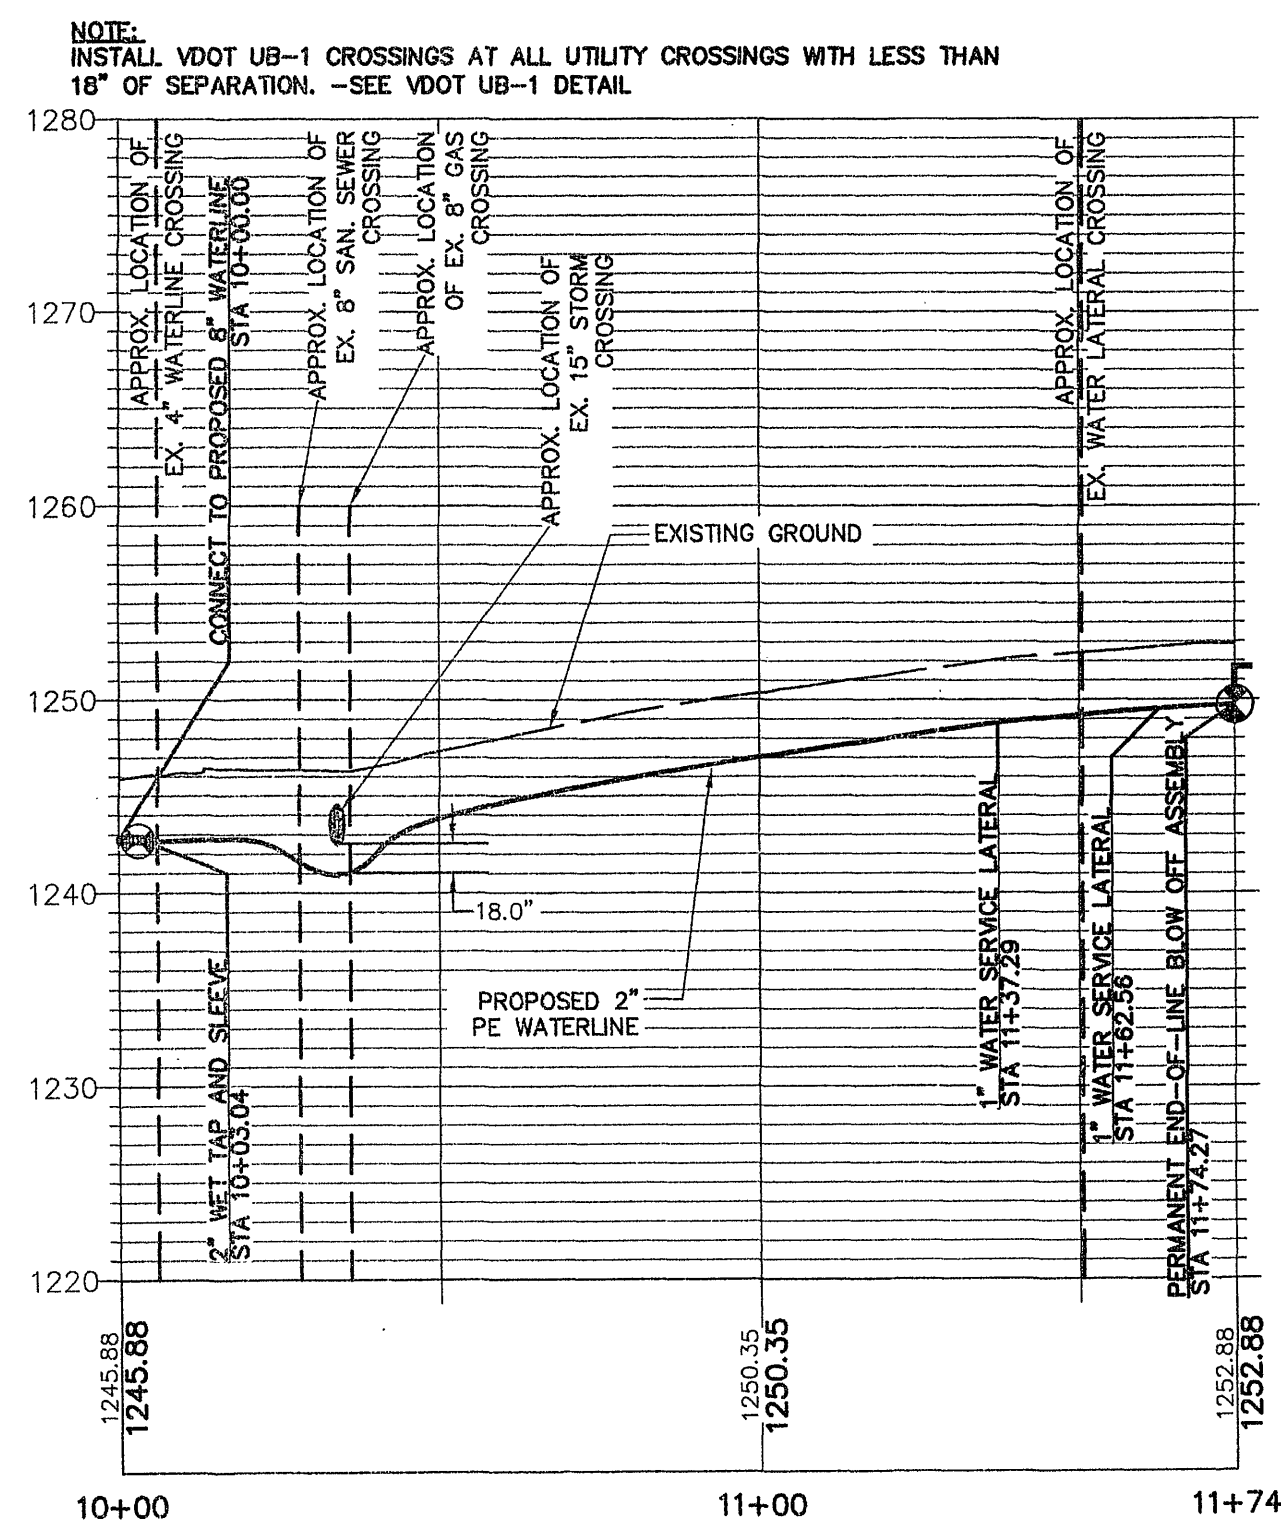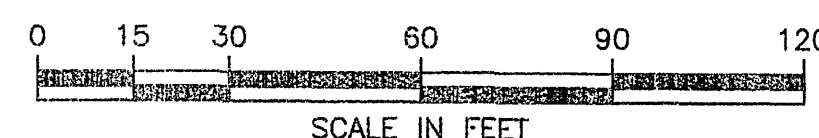

IVIE CIRCLE PROFILE
SCALE: 1"=30'H, 1"=10'V

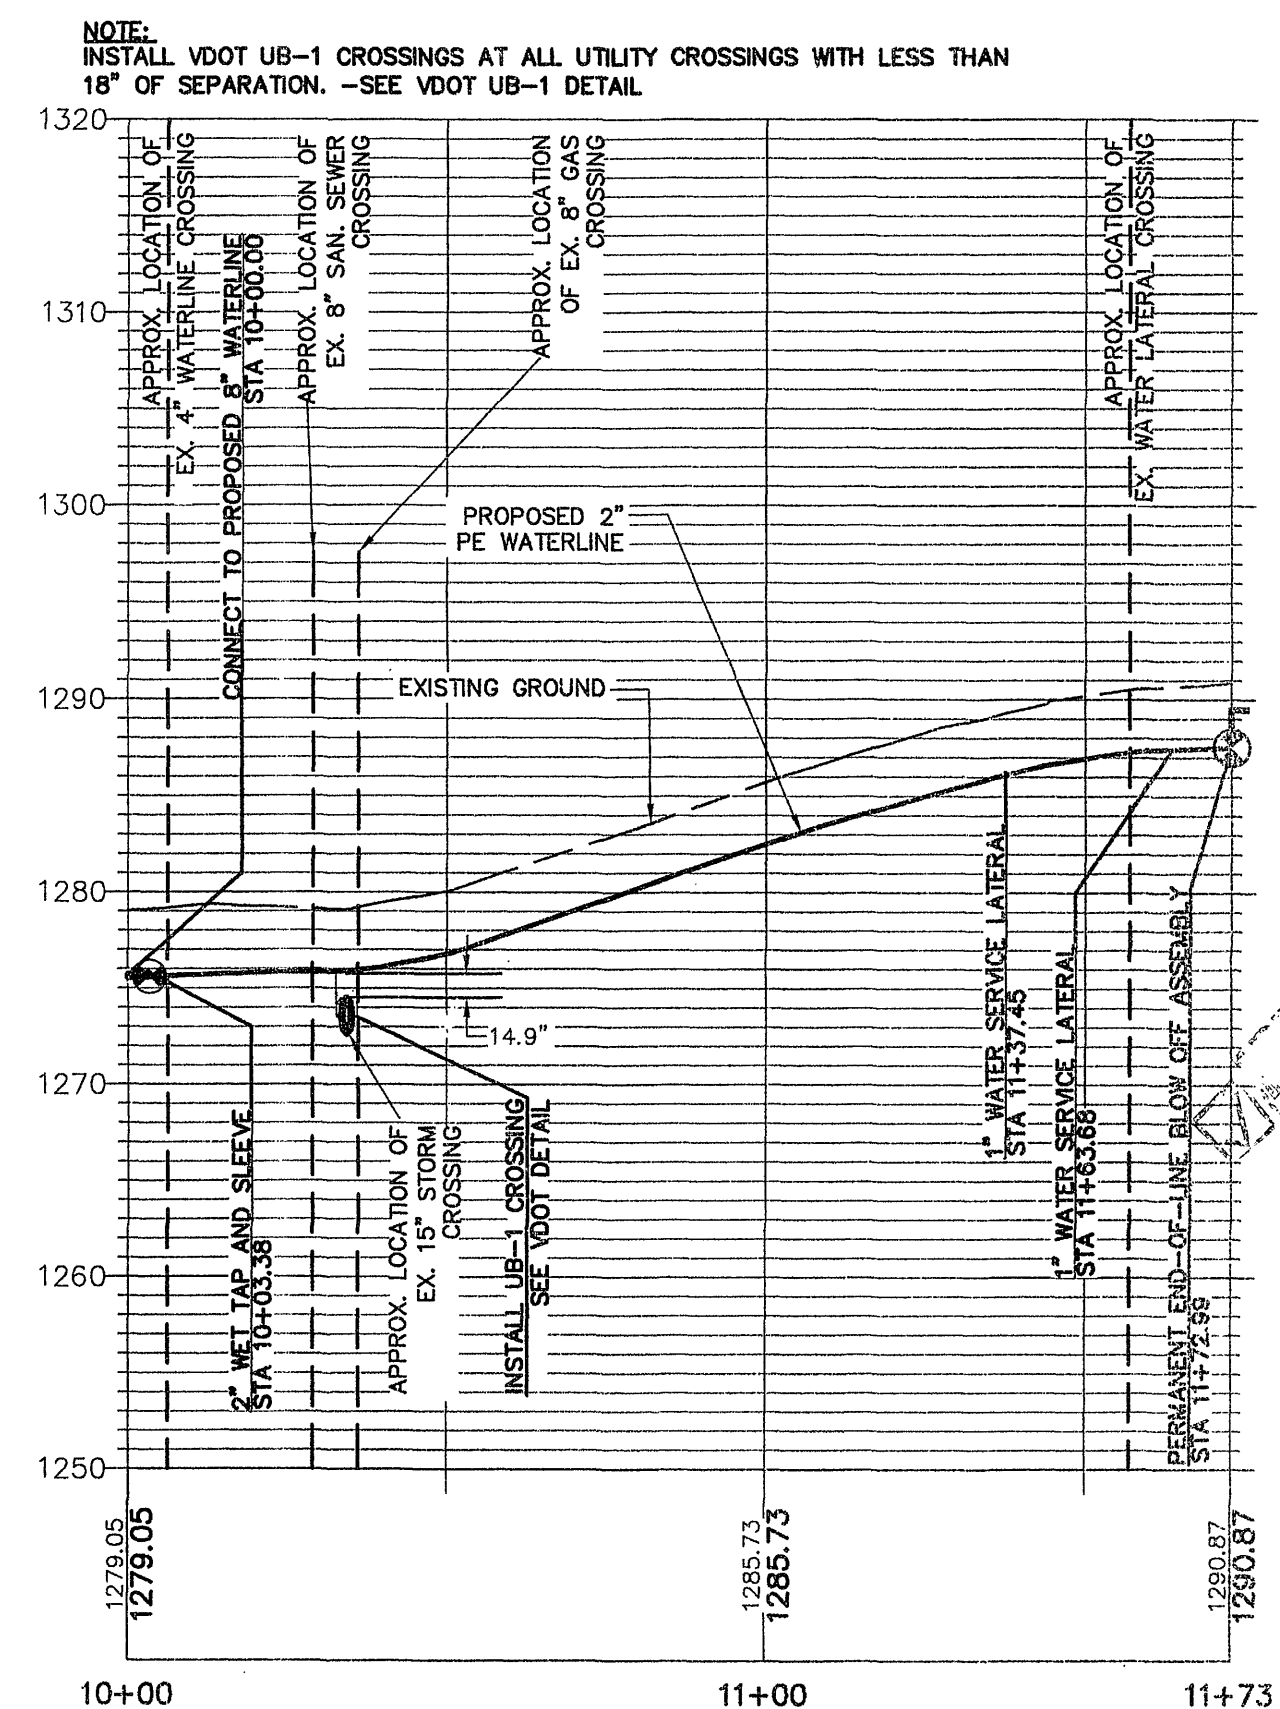

ADEL CIRCLE PROFILE
SCALE: 1"=30'H, 1"=10'V


GAY AND NEEL, INC.
CIVIL ENGINEERING
LAND ENGINEERING
SURVEYING

328 Mountain Avenue S.W.
Roanoke, Virginia 24016
Phone: (540) 345-1110 Fax: (540) 345-5560
Email: info@gayandneel.com

Ivie Circle and Adel Circle

Ingall Boulevard Waterline
Replacement

Roanoke County, Virginia

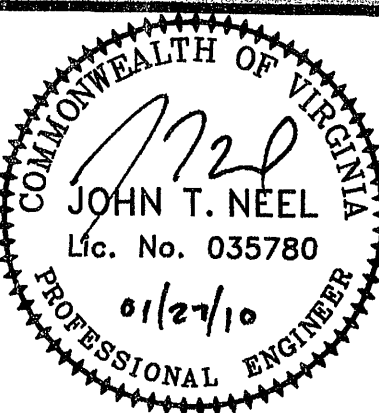

REVISED:

DESIGNED/CALC.: TMK
CHECKED: RWA
DRAWN: RWA
SCALE: 1"=30'
DATE: 01/08/09

JOB NO. 2119.0
SHEET C1-06