


VA STATE GRID NORTH
VA STATE GRID SOUTH
VA STATE GRID EAST
VA STATE GRID WEST


NOTE:

1. FOR INFORMATION REGARDING EROSION CONTROL FOR WATER SERVICE INSTALLATION, SEE DETAIL ON SHEET C2-04
2. FOR INFORMATION REGARDING MATERIAL STOCKPILING GUIDELINES, SEE DETAIL ON SHEET C2-04

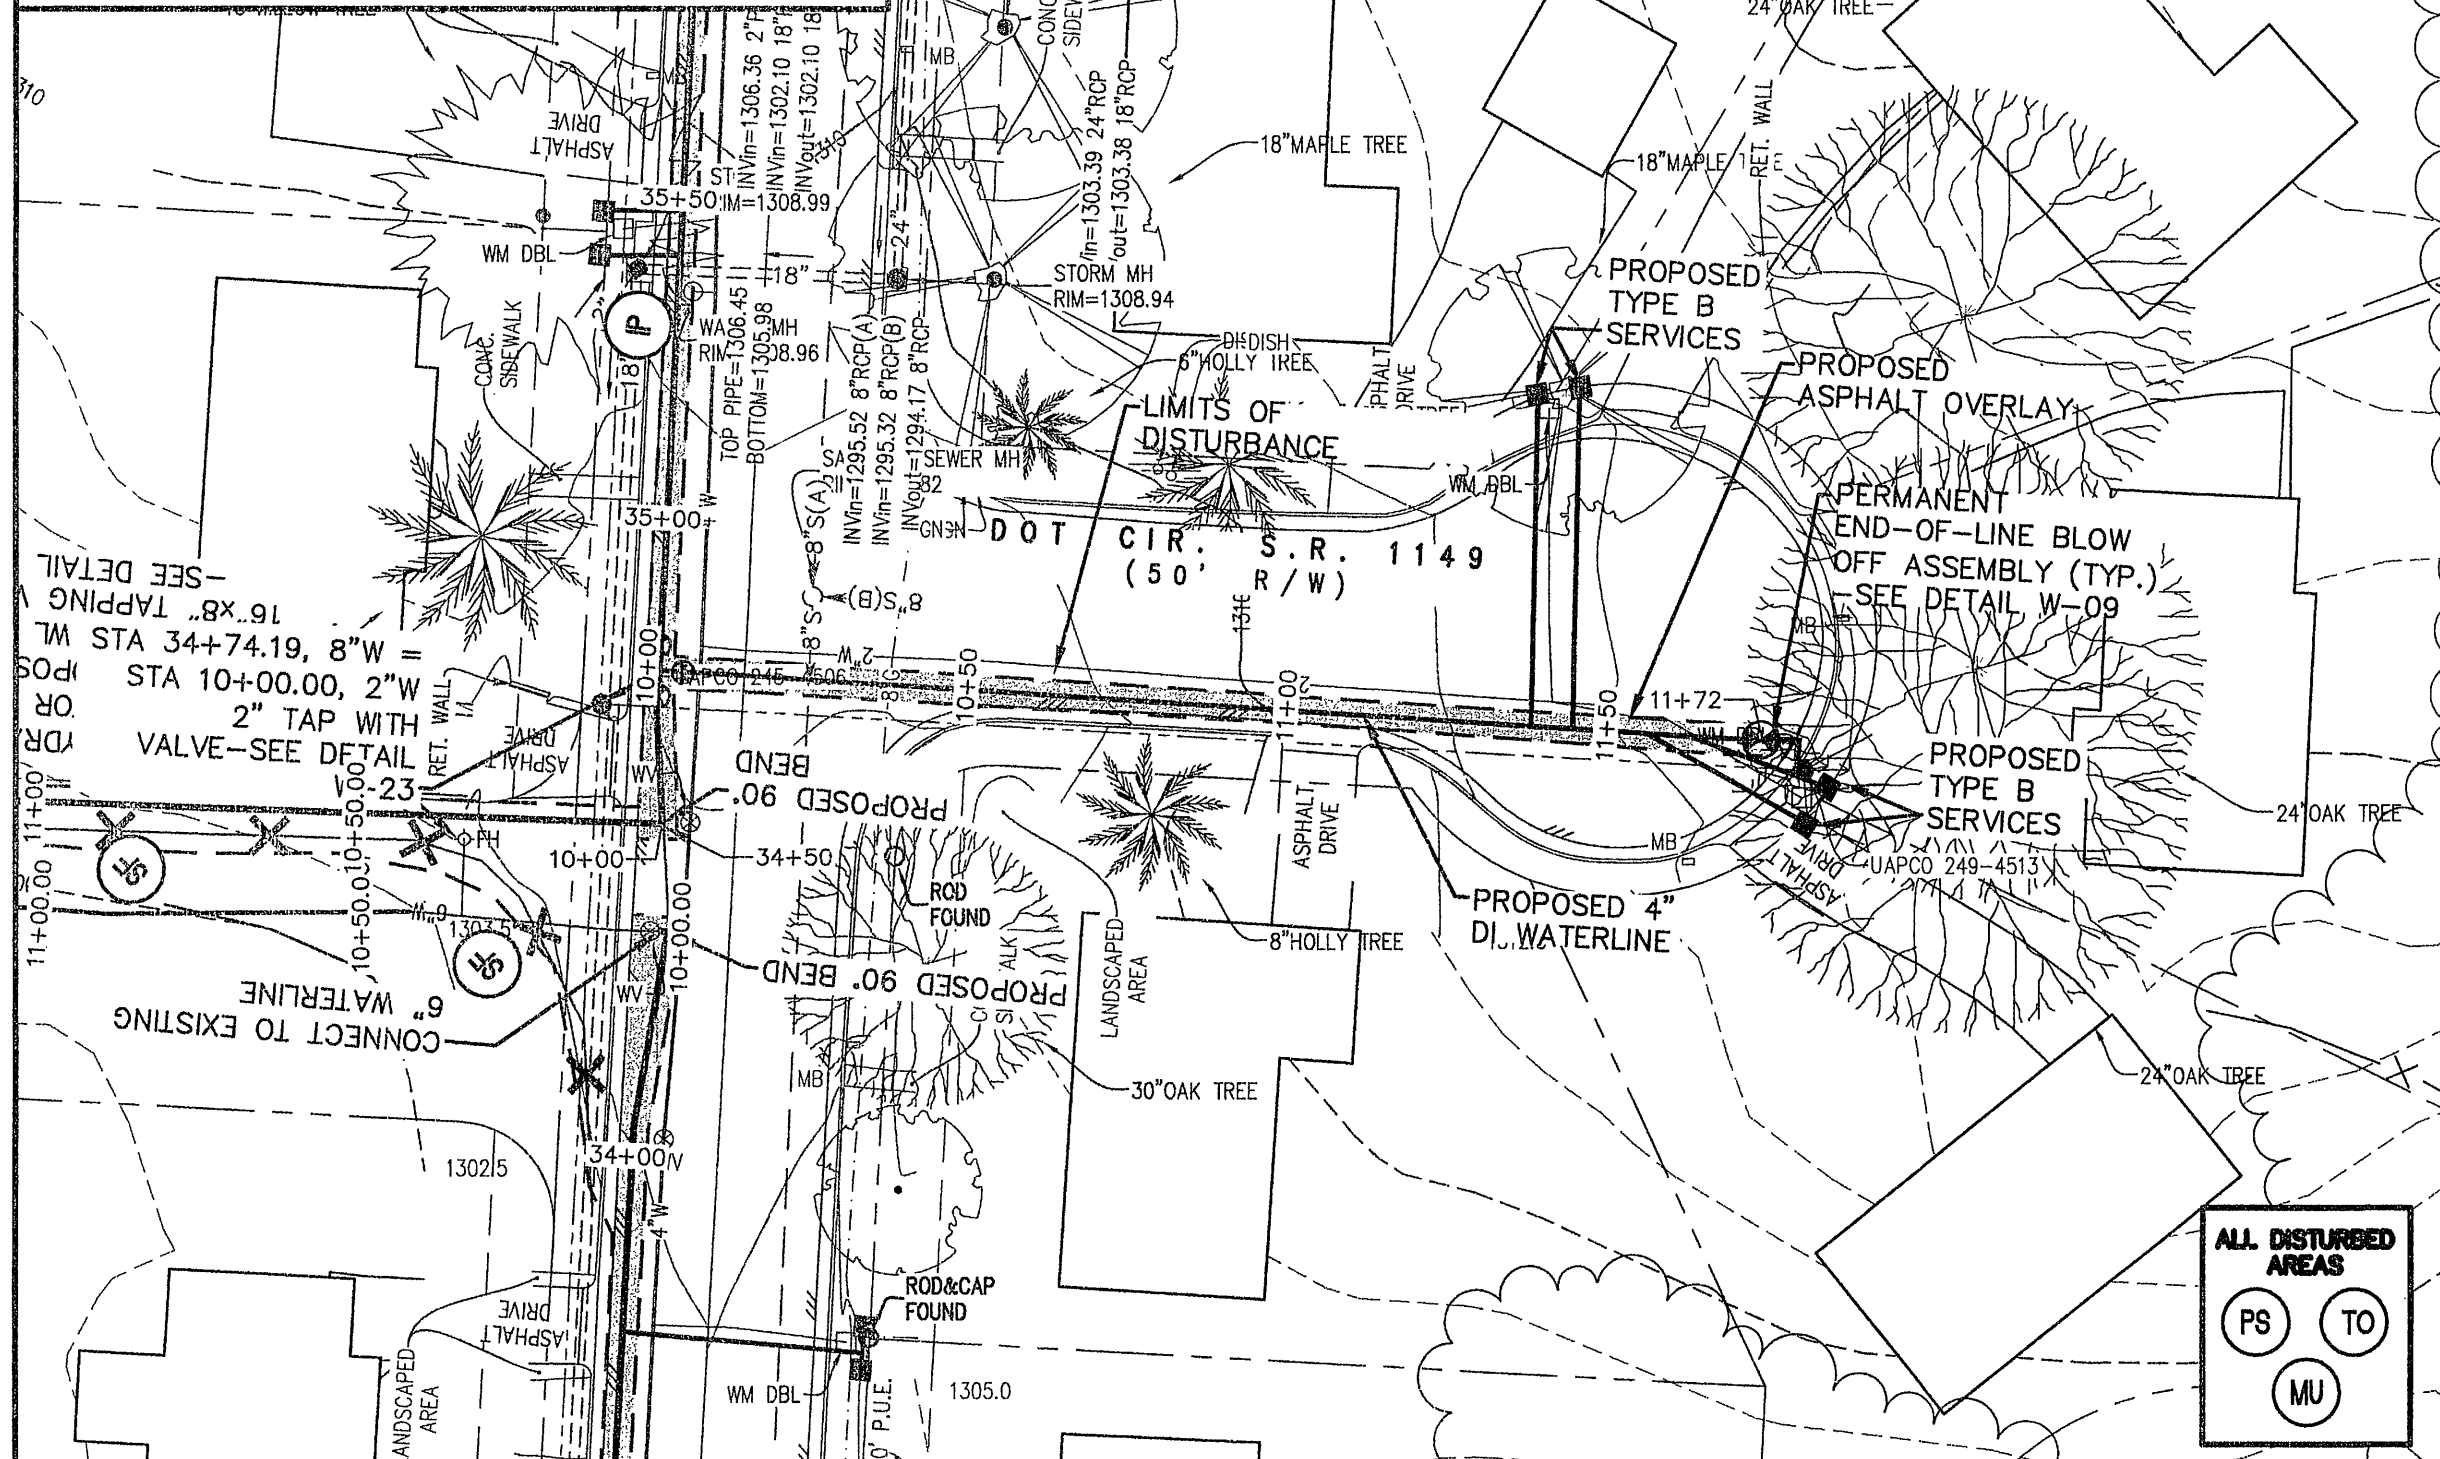

DOT CIRCLE PLAN


SCALE: 1"=30'

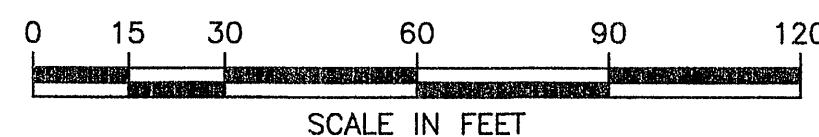

VA STATE GRID NORTH
VA STATE GRID SOUTH
VA STATE GRID EAST
VA STATE GRID WEST


NOTE:

1. FOR INFORMATION REGARDING EROSION CONTROL FOR WATER SERVICE INSTALLATION, SEE DETAIL ON SHEET C2-04
2. FOR INFORMATION REGARDING MATERIAL STOCKPILING GUIDELINES, SEE DETAIL ON SHEET C2-04

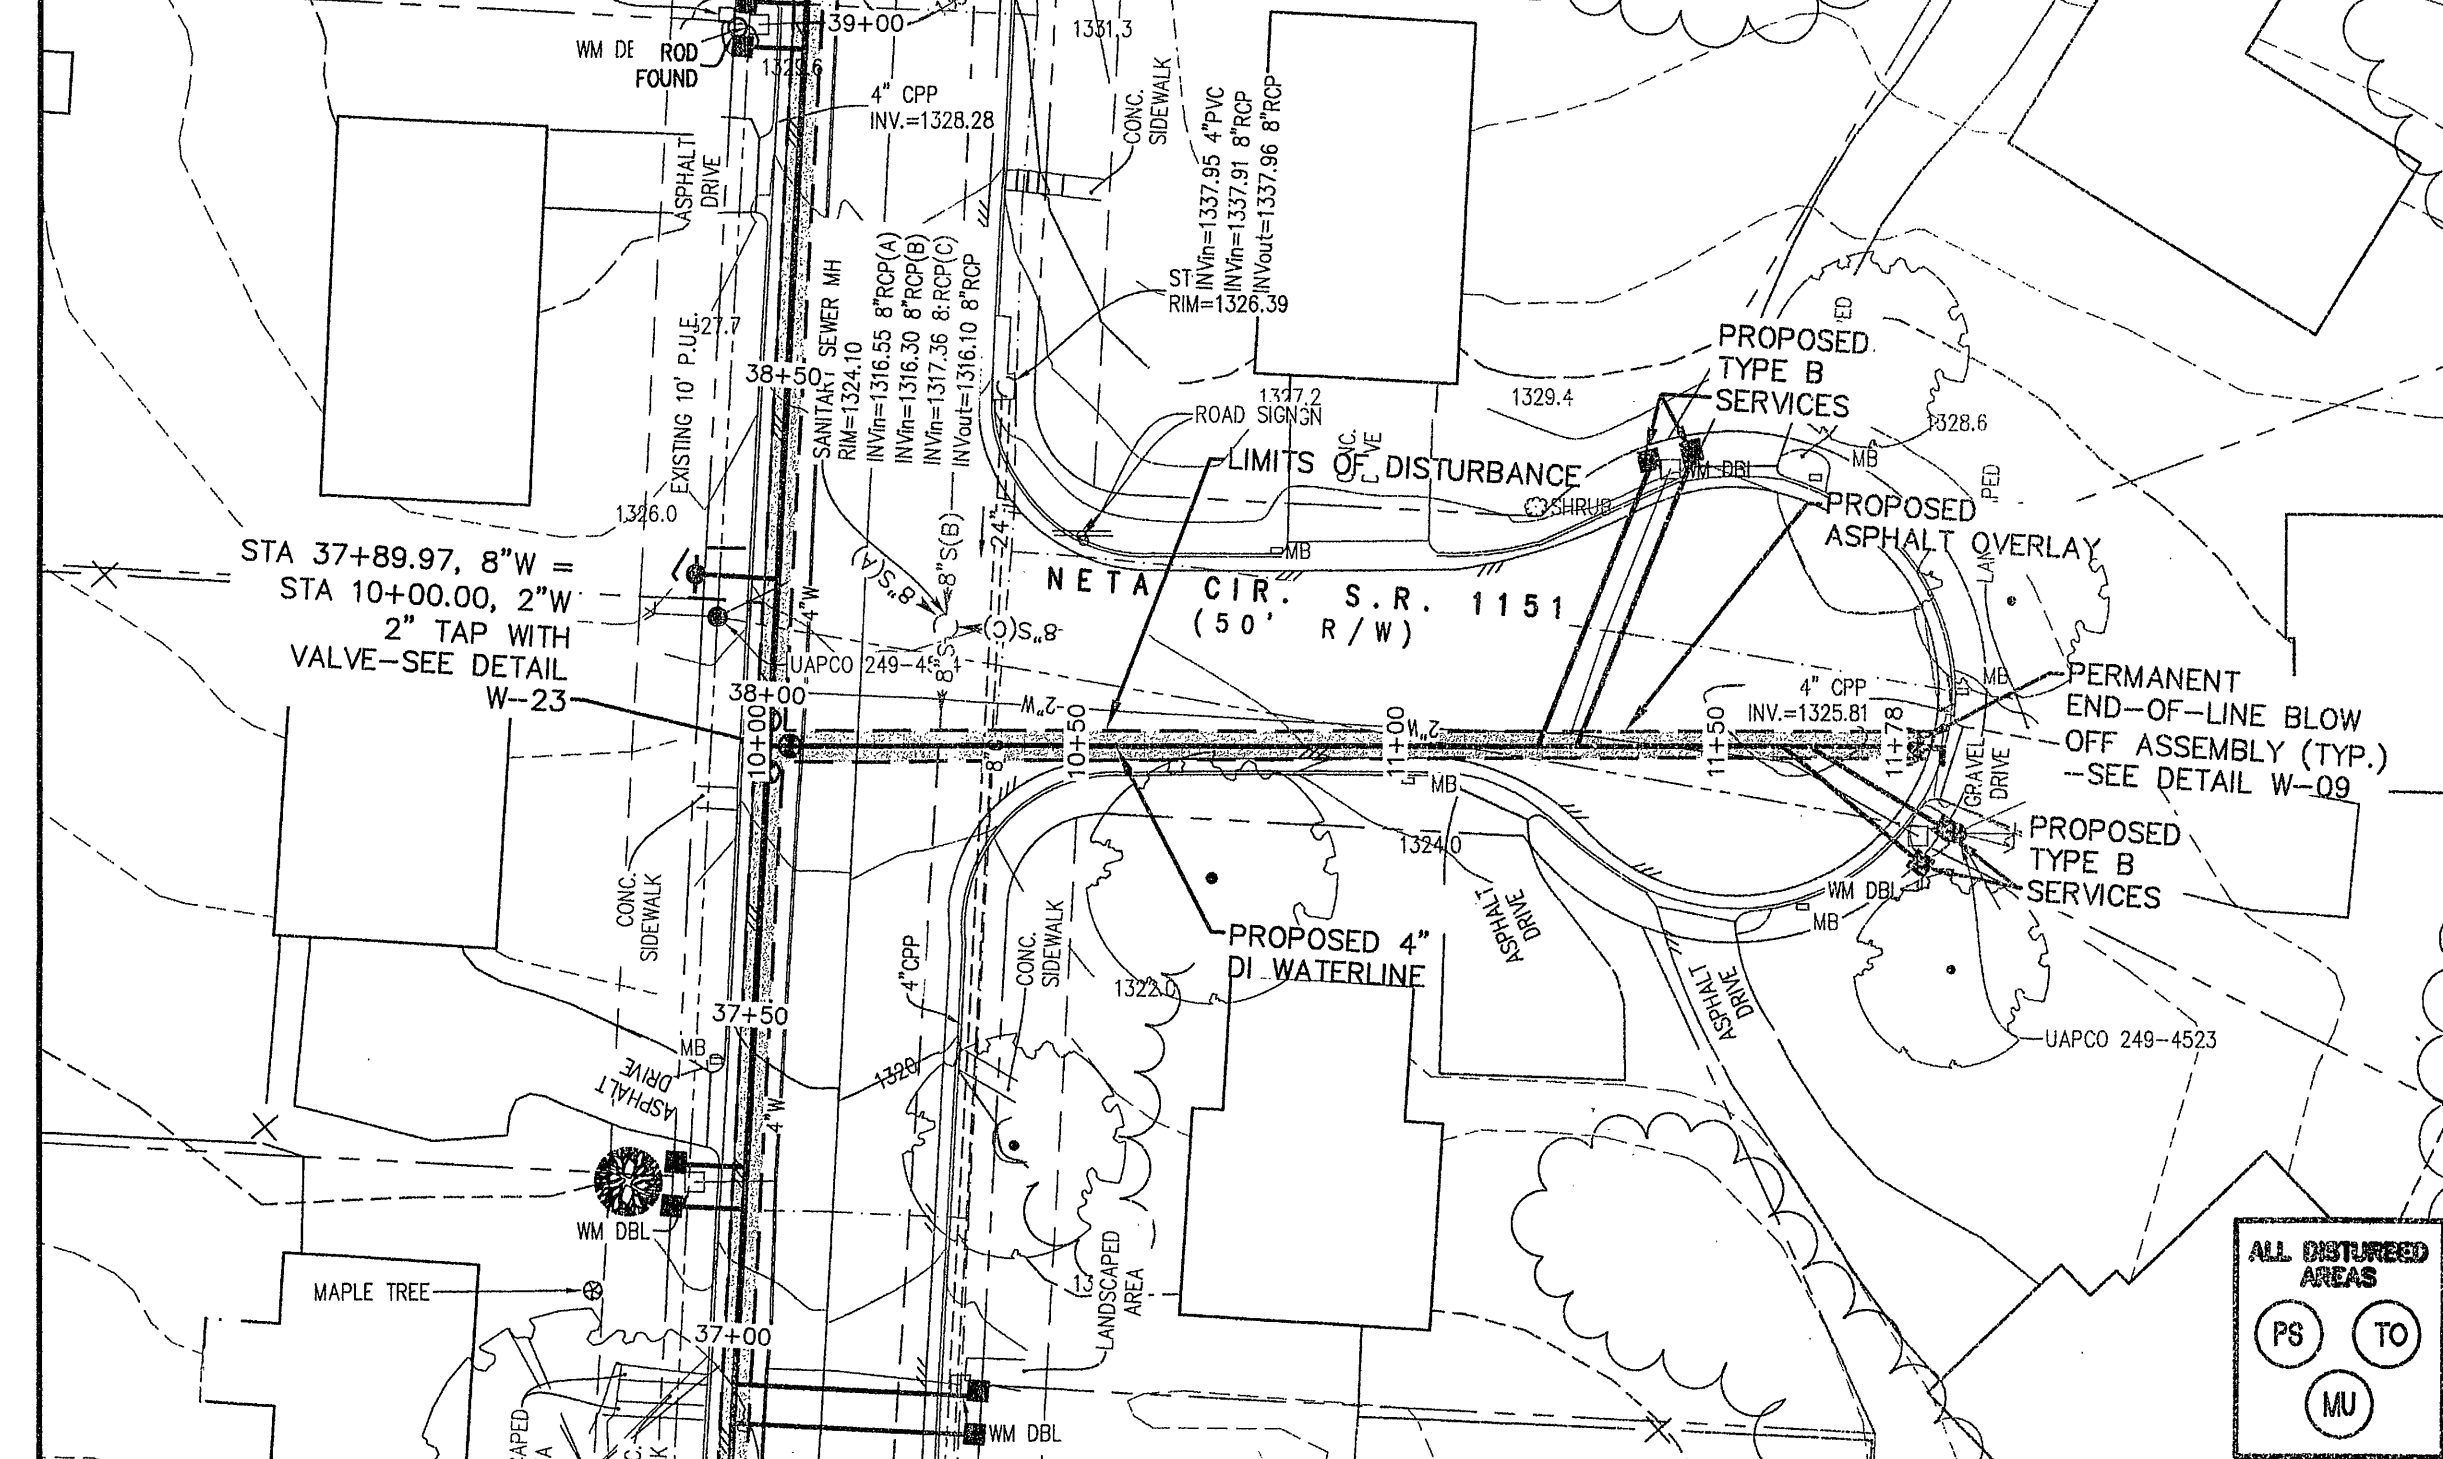


NETA CIRCLE PLAN

SCALE: 1"=30'

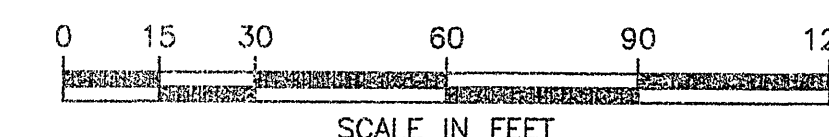


NOTE:

1. INSTALL VDOT UB-1 CROSSINGS AT ALL UTILITY CROSSINGS WITH LESS THAN 18" OF SEPARATION. - SEE VDOT UB-1 DETAIL

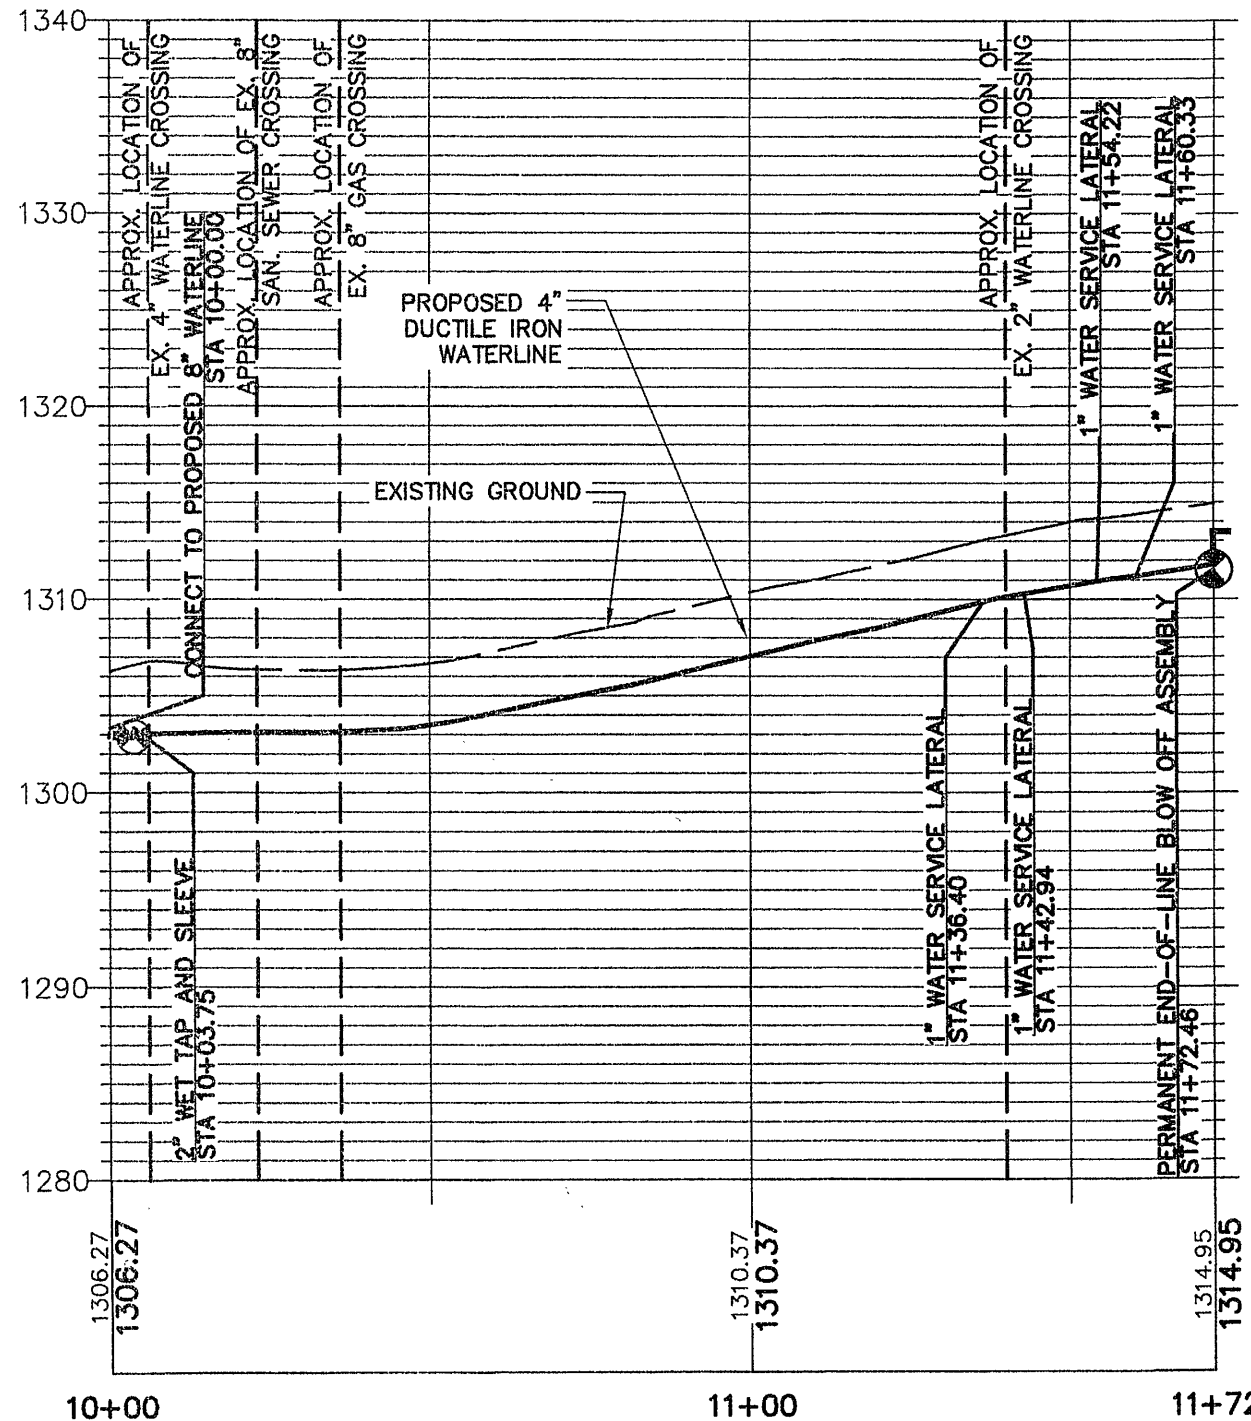


DOT CIRCLE

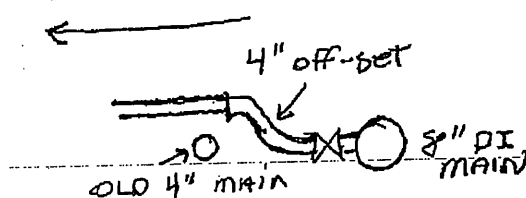

As-Built

As-Built

NETA CIRCLE

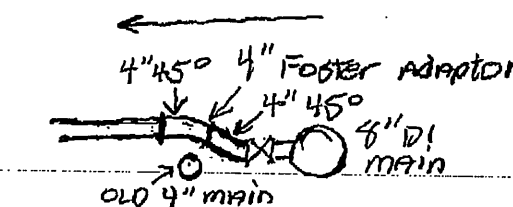


NETA CIRCLE PROFILE

SCALE: 1"=30'H, 1"=10'V

NOTE:

1. INSTALL VDOT UB-1 CROSSINGS AT ALL UTILITY CROSSINGS WITH LESS THAN 18" OF SEPARATION. - SEE VDOT UB-1 DETAIL

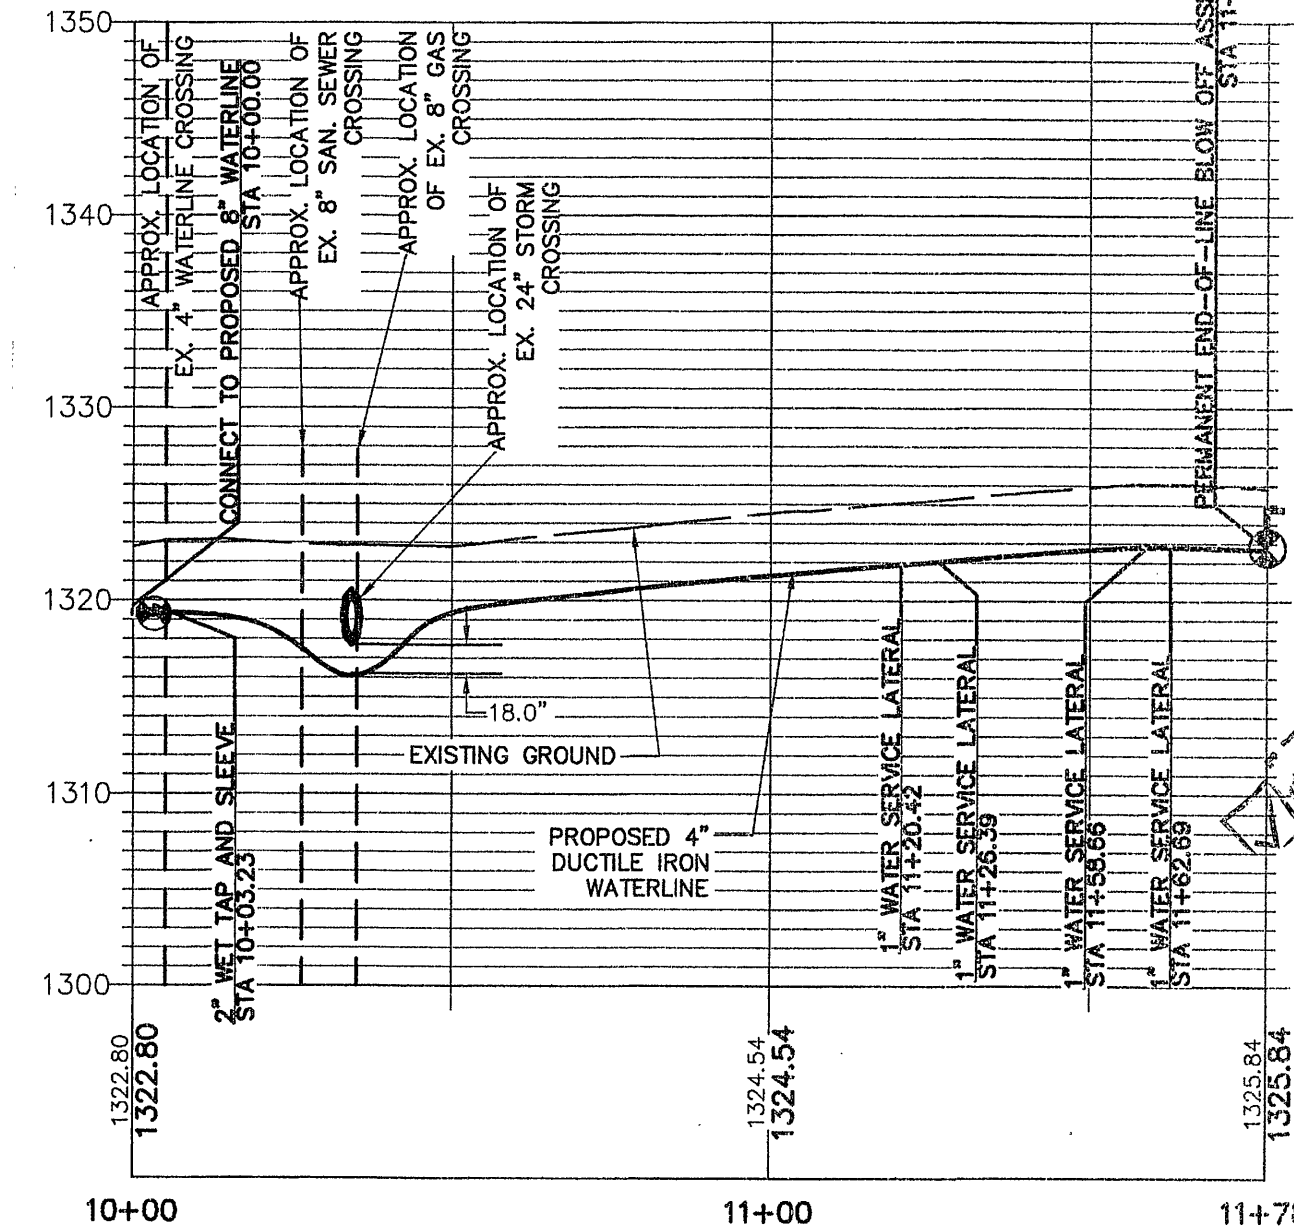

DOT CIRCLE PROFILE

SCALE: 1"=30'H, 1"=10'V

GAY AND NEEL, INC.



CIVIL ENGINEERING
LAND PLANNING
SURVEYING


328 Mountain Avenue S.W.
Roanoke, Virginia 24016

Phone: (540) 345-1110 Fax: (540) 345-5560
Email: info@gayandneel.com

Dot Circle and Neta Circle

Ingall Boulevard Waterline
Replacement

Roanoke County, Virginia

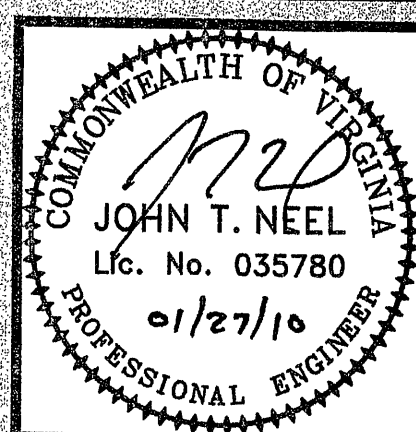

REVISED:

DESIGNED/CALC.: TMK
CHECKED: RWA
DRAWN: RWA
SCALE: 1"=30'
DATE: 01/08/09

JOB NO. 2119.0

SHEET C1-08