



# STREET RELOCATION AND CONSTRUCTION

## VICINITY OF ROANOKE MEMORIAL HOSPITAL

### ROANOKE, VIRGINIA

#### ABBREVIATIONS

CULV. CULVERT  
H.P. HIGH PRESSURE  
L.P. LOW PRESSURE  
S.S. SANITARY SEWER  
S<sub>t</sub> STORM SEWER  
W. WATER LINE  
C.B. CATCH BASIN  
D.I. DROP INLET  
C. & G. CURB & GUTTER  
M.H. MANHOLE  
T. TELEPHONE  
EL. ELEVATION  
G. GAS  
INV. INVERT  
P. PROPERTY LINE  
PROP. PROPOSED

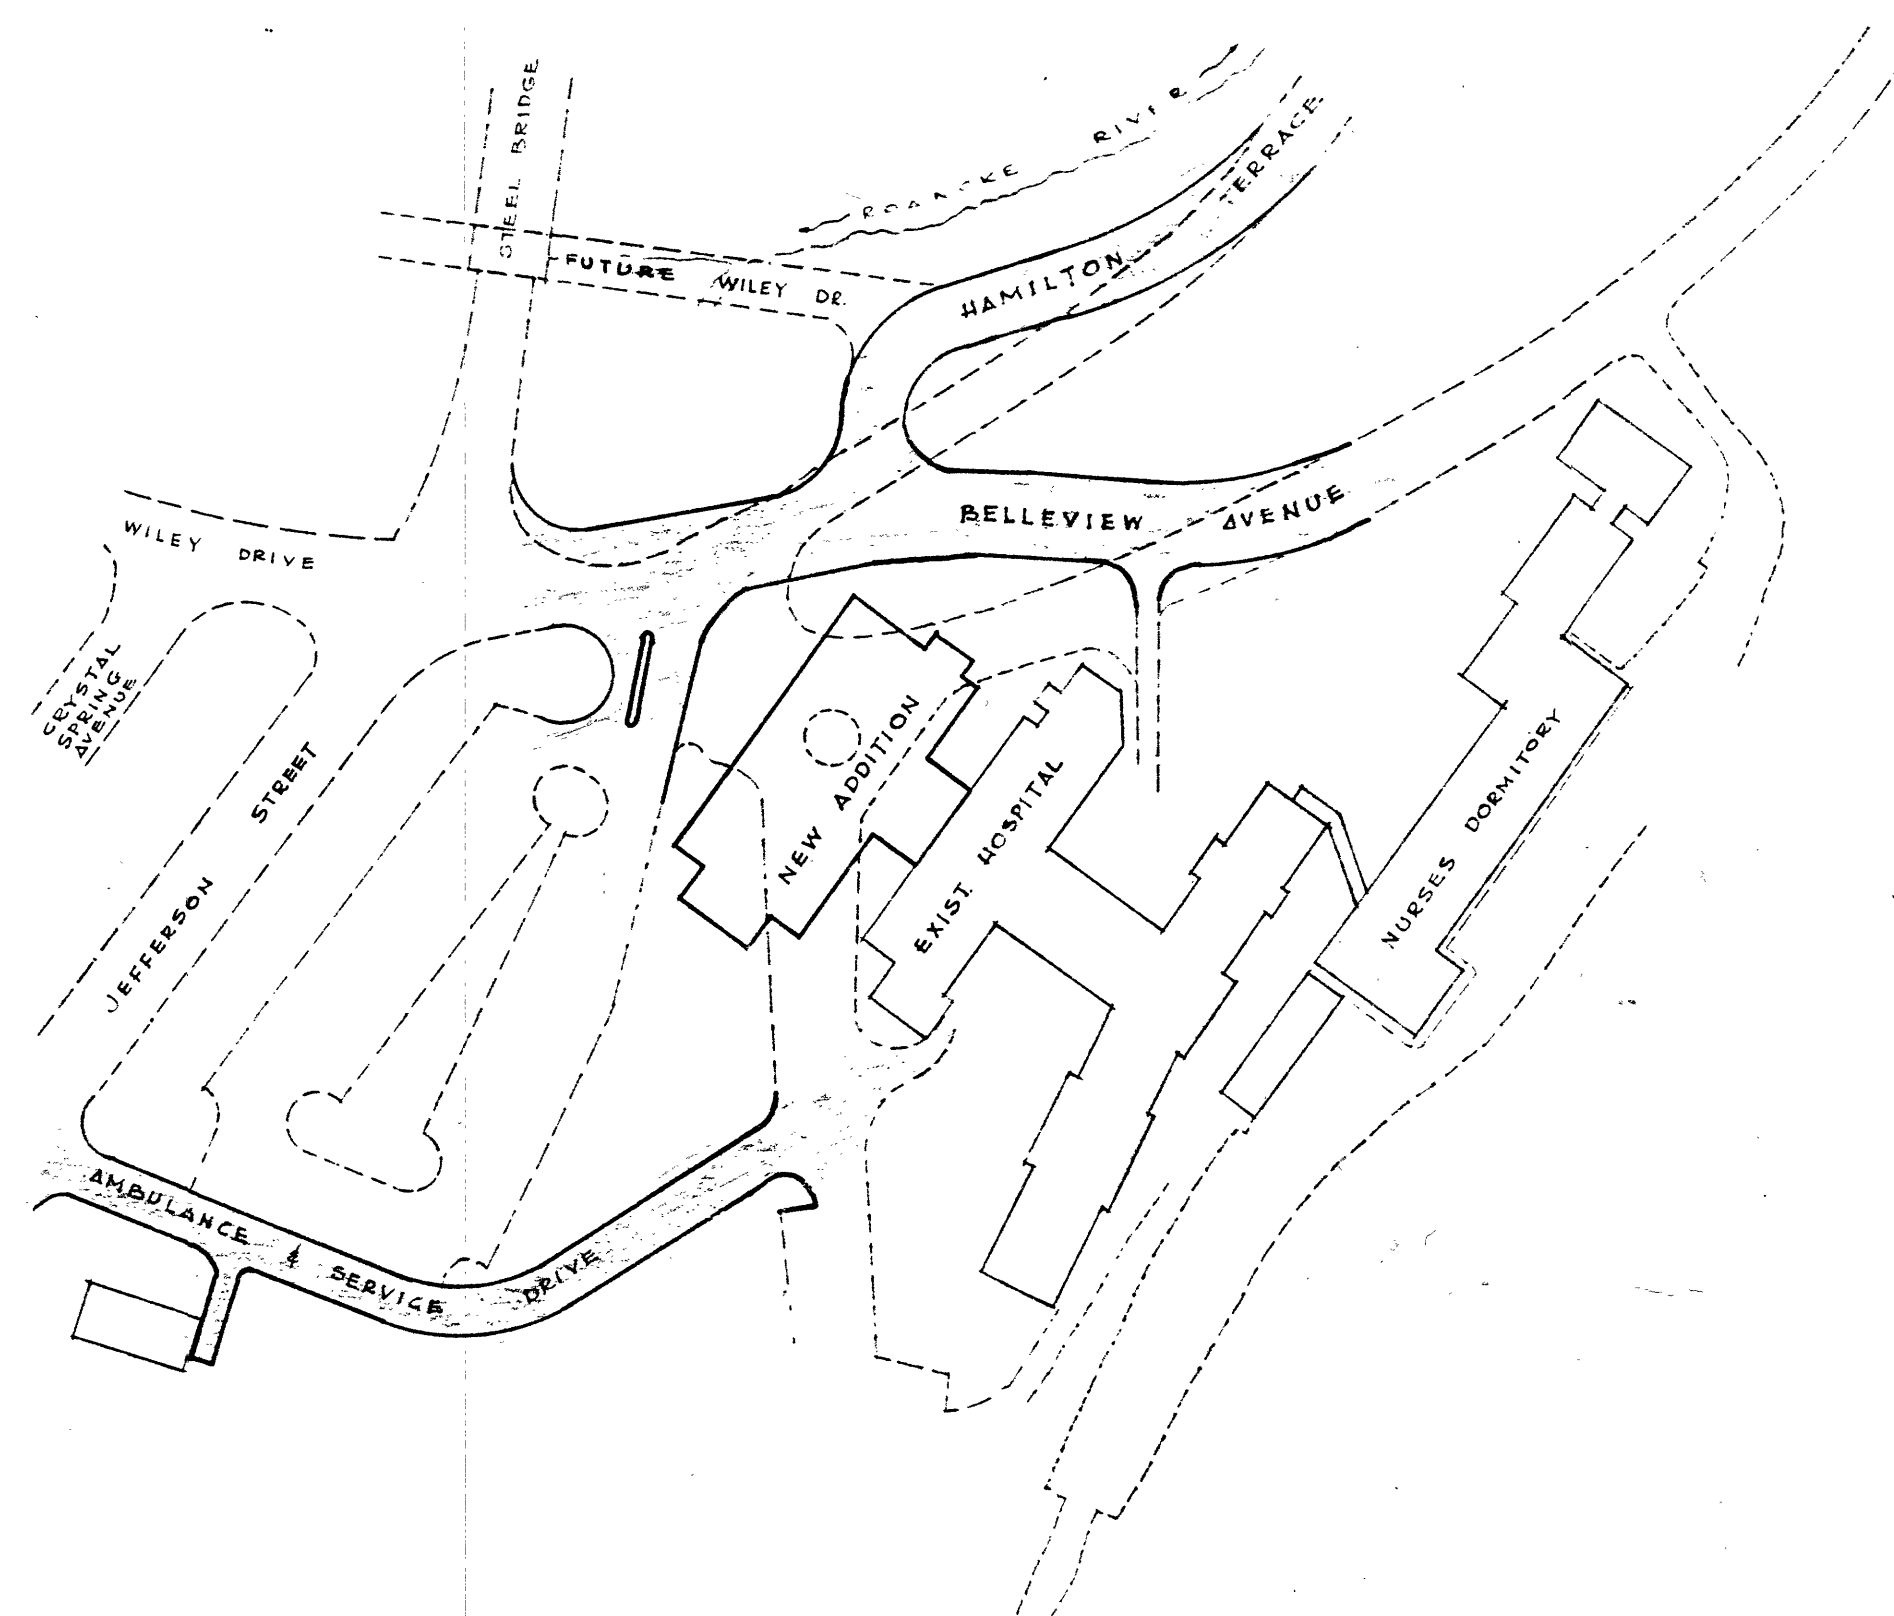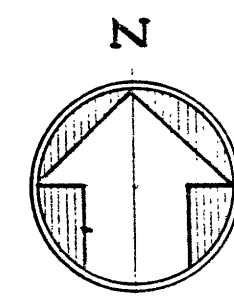

**SITE PLAN**  
SCALE: 1" = 100'

#### INDEX

- 1 TITLE SHEET
- 2 & 2A TYPICAL SECTION & SUMMARY
- 3 PLAN & PROFILE BELLEVUE & HAMILTON TERRACE
- 4 PLAN & PROFILE AMBULANCE ENTRANCE & SERVICE ENTRANCE
- 5 LARGE SCALE BELLEVUE AVE.
- 6 LARGE SCALE SERVICE DRIVE
- 7 DRAINAGE STRUCTURES
- 8 thru 16 X-SECTIONS
- 17 PROFILE SANITARY SEWER AND STORM DRAIN

DO NOT USE FOR CONSTRUCTION  
EUBANK, CALDWELL AND ASSOCIATES  
ARCHITECTS AND ENGINEERS  
ROANOKE VIRGINIA

**PRE-FINAL**

CITY OF ROANOKE		ROANOKE HOSPITAL ASSOCIATION	<b>EUBANK, CALDWELL AND ASSOCIATES</b> ARCHITECTS AND ENGINEERS 612 FIRST FEDERAL BUILDING ROANOKE, VIRGINIA COMM. NO. 6515 JUNE 20, 1966 SHEET NO. 1 Water Dept. #66-28 ENG. # 5002
DIRECTOR OF PUBLIC WORKS	PLANNING DIRECTOR	EUBANK, CALDWELL & ASSOCIATES	
CITY ENGINEER	WATER DEPARTMENT MANAGER	<i>Steven Franklin Jr. p.c.</i>	