





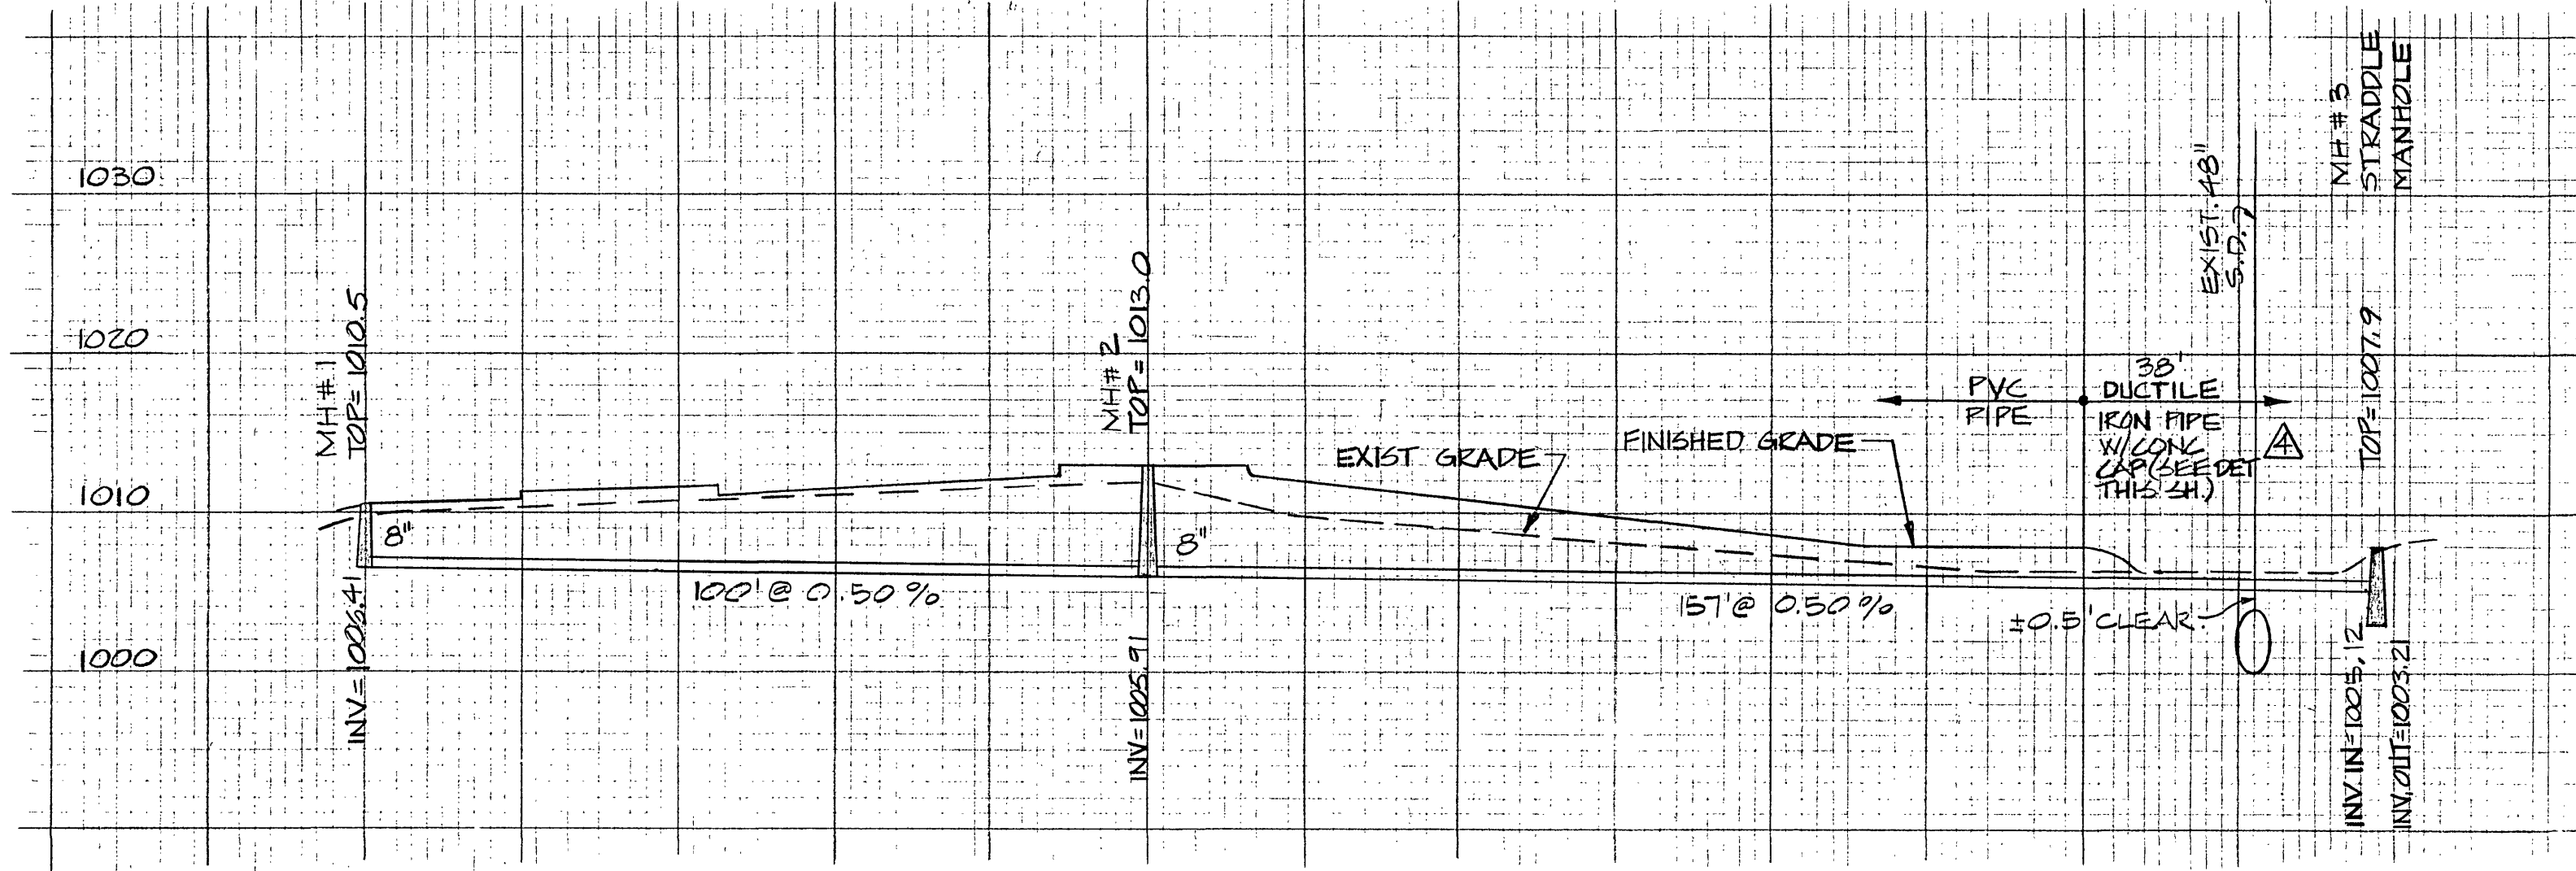


SANITARY SEWER PROFILE


1" = 20' H
1" = 10' V

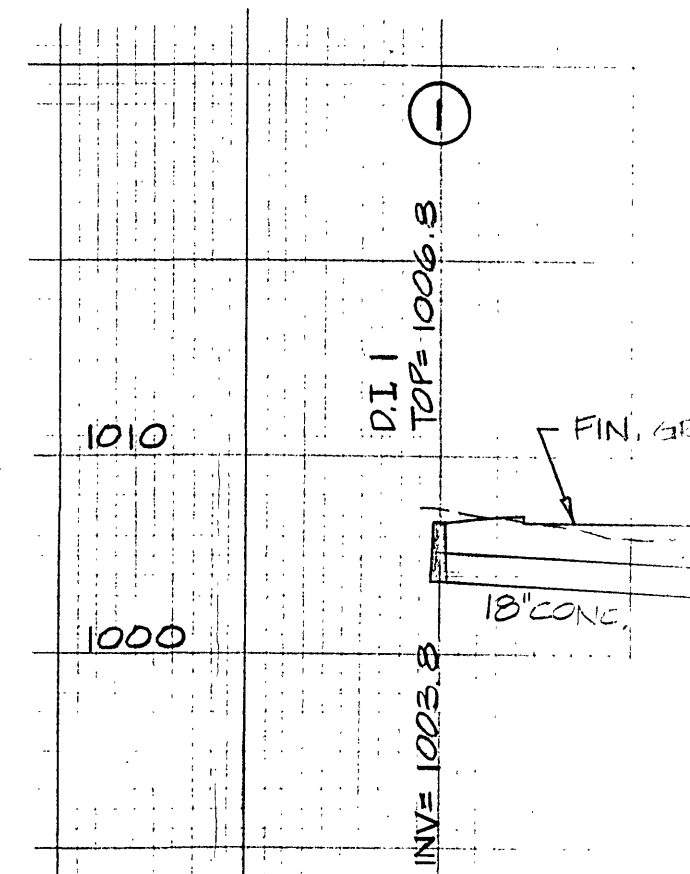

BRANDON AVE, S.W.

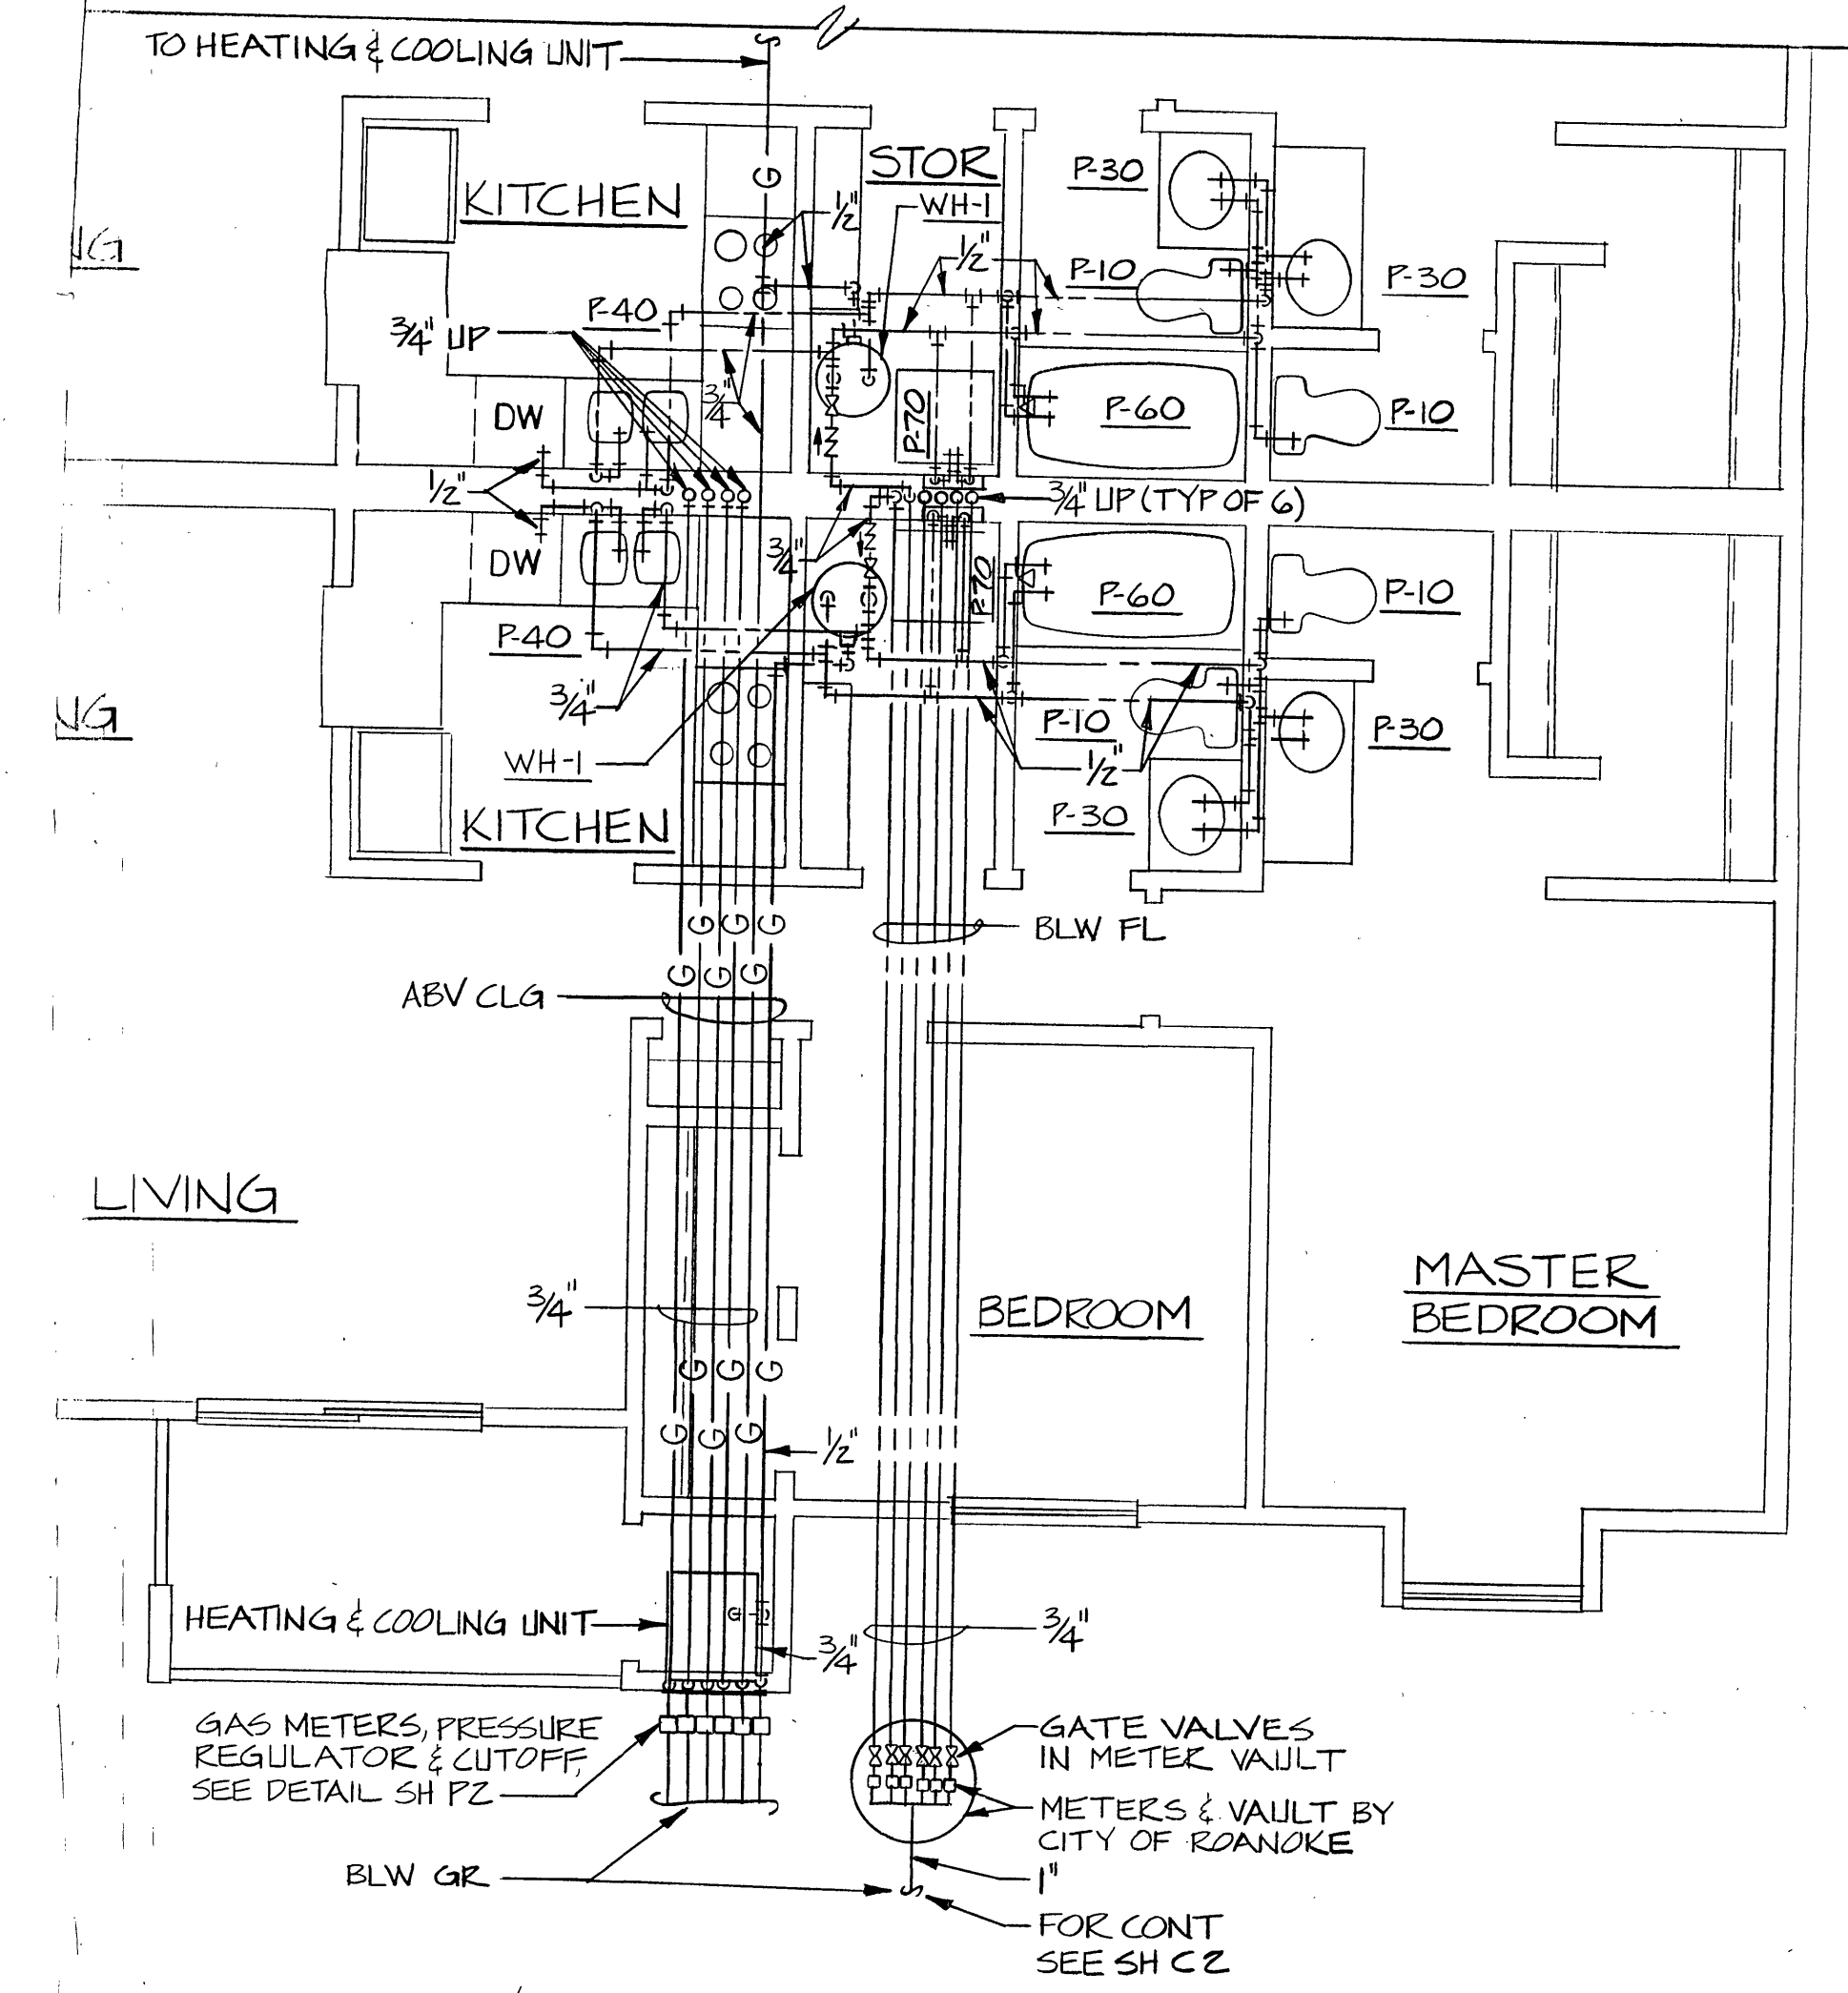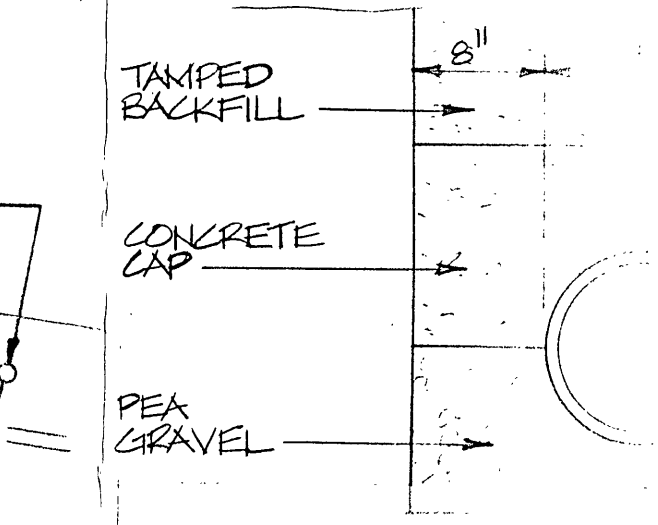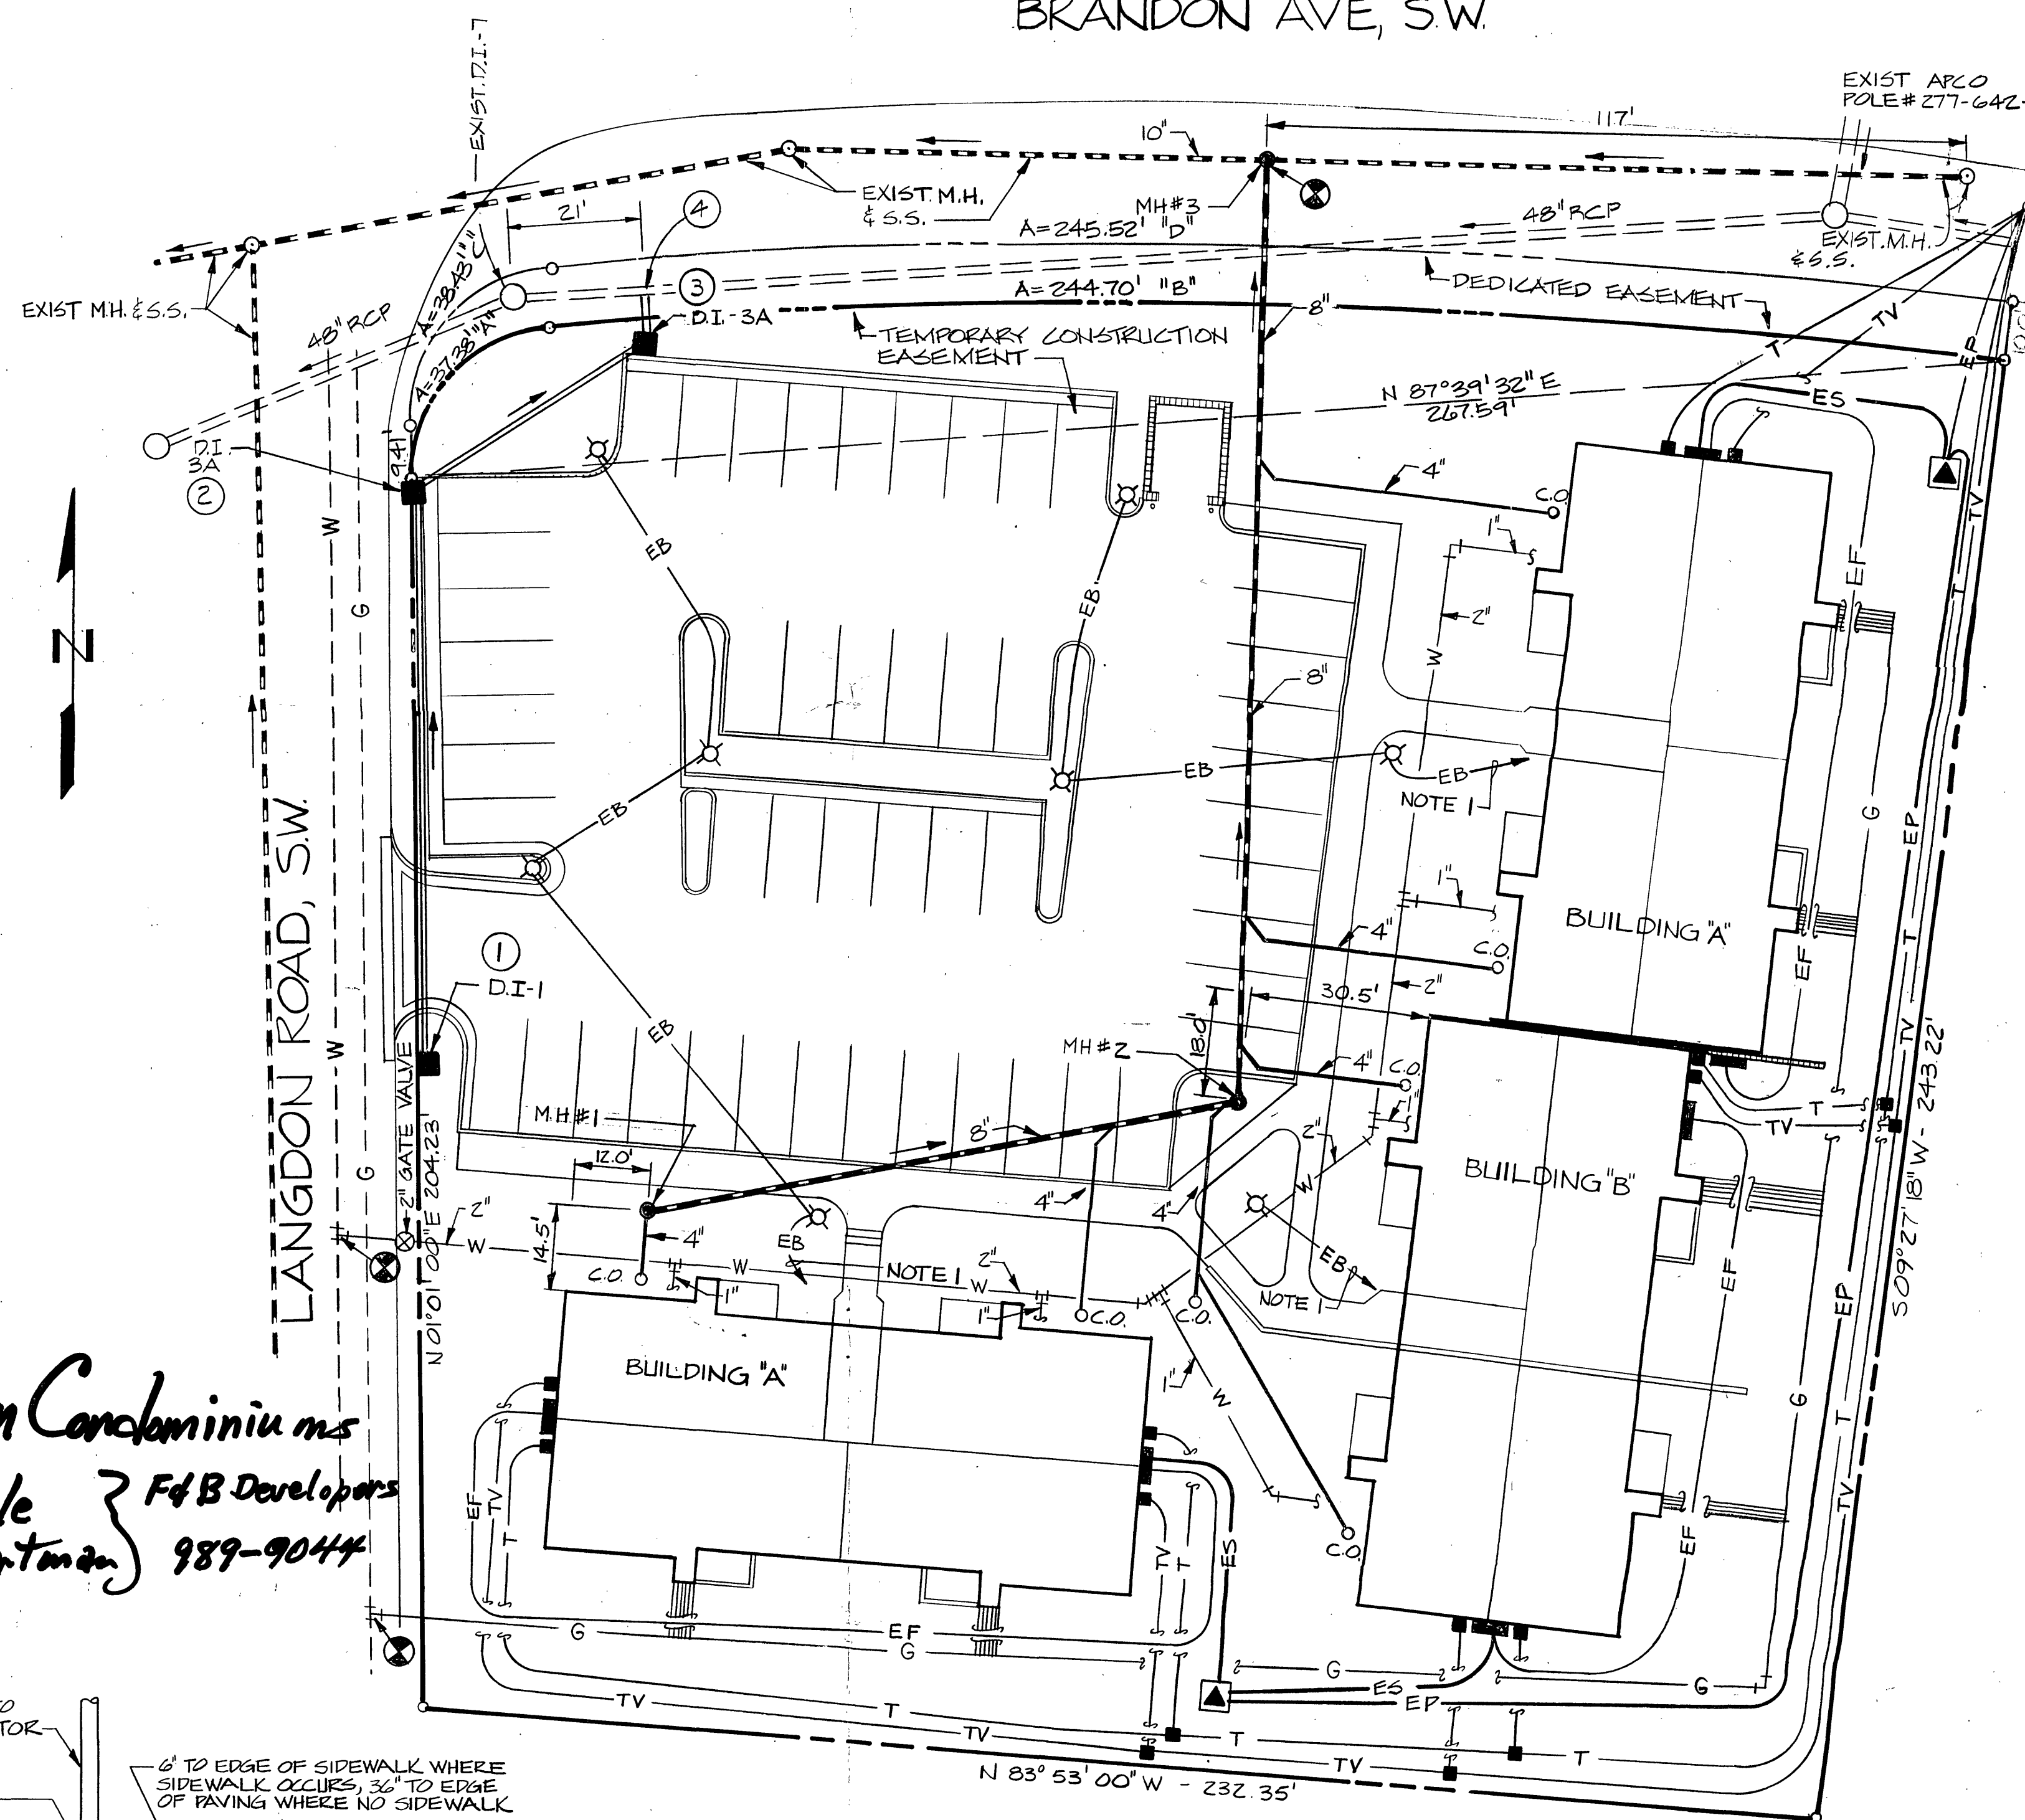

Langdon Condominiums
Kit Hole } F&B Developers
Jim Hartman 989-9044

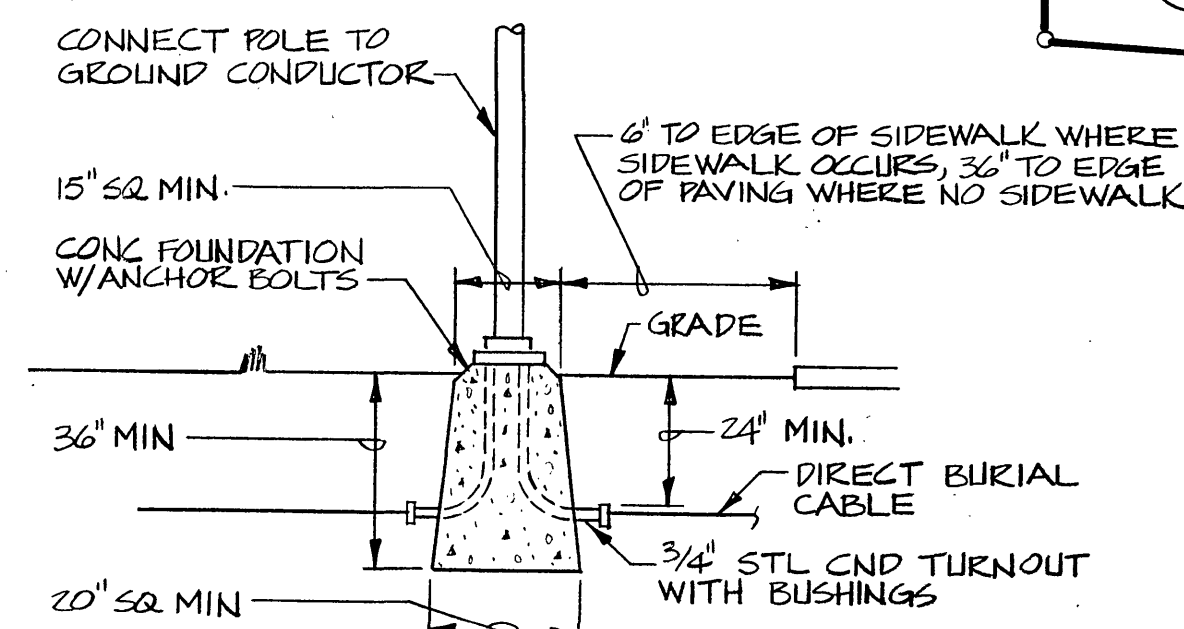

SITE UTILITIES & STORM DRAINAGE PLAN

1" = 20' - 0"
NOTE:
STORM SEWER, SANITARY SEWER & WATER DESIGN
WAS DONE BY BUFORD T. LUMSDEN & ASSOCIATES, P.C.
CERTIFIED LAND SURVEYOR, ROANOKE, VIRGINIA.

KEY	SCIENTIFIC NAME
T1	PIRUS STROBUS
T2	PIRUS EXCELSA
T3	CORNUS FLORIDA
T4	BETULA PAPPYRIFERA
T5	BETULA PAPPYRIFERA
T6	MALUS KATHERINI
S1	VIBURNUM RHYTHIOPHYLLUM
S2	JUNIPERUS HORIZONTALIS PLUMOSA
S3	JUNIPERUS CHINENSIS PRITZERIANA

COMMON NAME
WHITE PINE
NORWAY SPRUCE
WHITE DOGWOOD
CLUMP BIRCH
CANDY BIRCH
KATHERINE CHERRY

COMMON NAME
LEATHERLEAF VIBURNUM
REGULAR ANGIOPERM
PRITZER JUNIPER

DETAIL - LIGHTING FIXTURE TYPE "P"
NO SCALE

Changed to master meter instead of individual meters as shown.

MILLS, OBENCHAIN, OLIVER & WEBB, INC.
ARCHITECTS • ENGINEERS • PLANNERS
BLACKSBURG, VIRGINIA

designed JBO
drawn RLW
checked JBO

approved
comm. no. 8053
date 1 SEPT 81

LANGDON CONDOMINIUM
CITY OF ROANOKE,