

WESTERN VIRGINIA WATER AUTHORITY
FY2011 VCWRLF COLLECTION SYSTEM PROJECTS
CONTRACT 3: LARGE REPLACEMENT PROJECTS
MILL MOUNTAIN SEWER RELOCATION

"As-built Drawings" - 7/29/14
Submitted by: Prillaman & Pace, Inc.

LOAN IDENTIFICATION NO. C-515471
ROANOKE, VIRGINIA


CONTACT SUMMARY

OWNER: WESTERN VIRGINIA WATER AUTHORITY
ADDRESS: 601 S. JEFFERSON ST.
SUITE 300
ROANOKE, VA 24011

CONTACT: EARL SMITH P.E.
TELEPHONE NO: 540-853-5700
FAX NO: 540-853-1017

ENGINEER: DRAPER ADEN ASSOCIATES
2206 SOUTH MAIN STREET
BLACKSBURG, VIRGINIA 24060

CHA CONSULTING
1901 INNOVATION DRIVE, SUITE 2100
BLACKSBURG, VA 24060

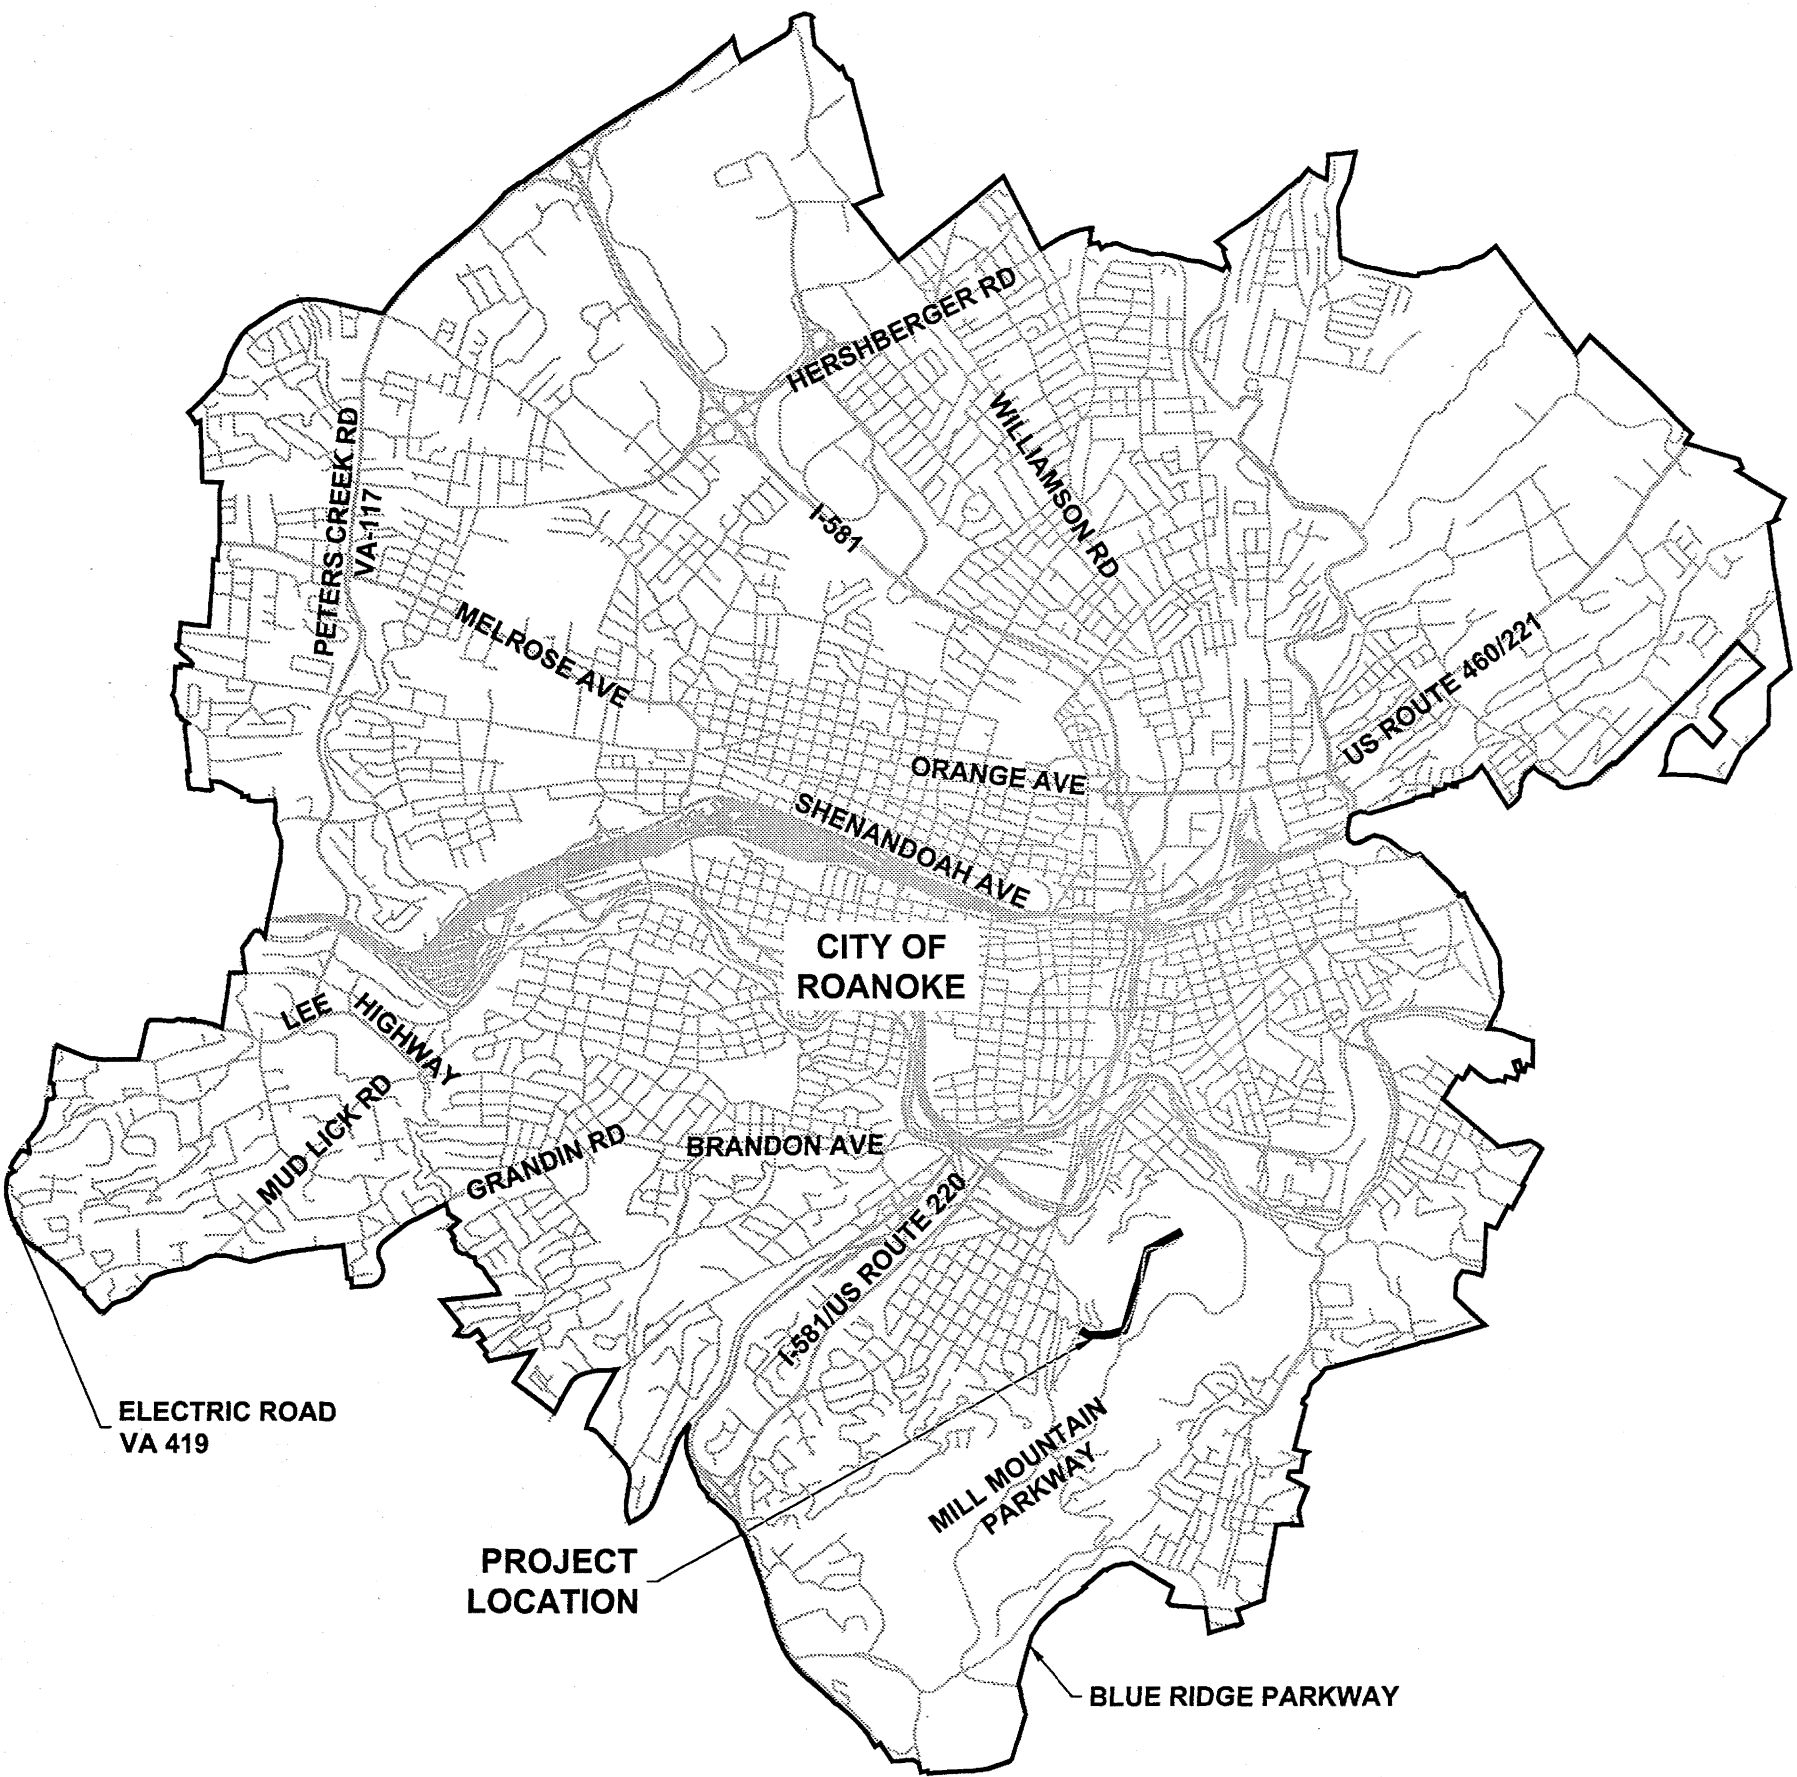

Drawing List

No.	Description
T-401	COVER SHEET
T-402	SEWER SHEET INDEX
C-401	SEWER PLAN
C-401A	SEWER PROFILE
C-402	SEWER PLAN AND PROFILE
C-403	SEWER PLAN AND PROFILE
C-404	SEWER PLAN AND PROFILE
C-405	SEWER PLAN AND PROFILE
ES-401	EROSION AND SEDIMENT CONTROL NARRATIVE AND DETAILS (SEE SPECIFICATIONS FOR TRAFFIC CONTROL PLANS.)

PROJECT DESCRIPTION


THIS PROJECT CONSISTS OF THE CONSTRUCTION AND INSTALLATION OF APPROXIMATELY 3,800 LF OF 8" SEWER AND 11 MANHOLES AS WELL AS APPROXIMATELY 1,200 LF OF 6" SEWER SERVICE LATERALS.

April 14, 2013
B11132B-04A



NOTE: CONTRACTOR TO CONTACT MISS UTILITY (811) IN ADVANCE OF PLANNED WORK. ADVANCE TIME PERIOD SHALL BE IN ACCORDANCE WITH CURRENT MISS UTILITY GUIDELINES (www.missutilityofvirginia.com).

These documents, including drawings and specifications, were prepared by Draper Aden Associates and CHA Consulting, Consulting Engineers, pursuant to a contract by and between Draper Aden Associates and CHA Consulting and Western Virginia Water Authority with respect to the project described in said contract. Any reuse or modification of said documents (whether hard copy or electronic) without written verification or adaptation by Draper Aden Associates and CHA Consulting for the specific purpose intended will be at the sole risk of the individual or entity utilizing said documents, drawings and specifications and such use is without the authorization of Draper Aden Associates and CHA Consulting. Draper Aden Associates and CHA Consulting, Consulting Engineers, shall have no legal liability resulting from any and all claims, damages, losses, and expenses, including attorney's fees arising out of the unauthorized use of these documents, drawings, specifications, reports, and studies prepared as a result of the aforesaid contract.

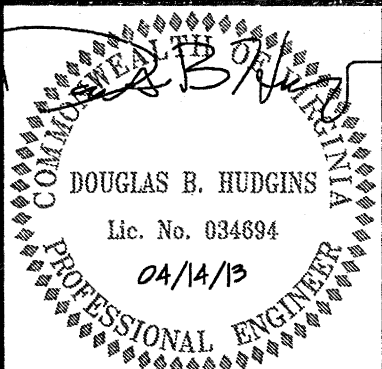

Draper Aden Associates
Engineering • Surveying • Environmental Services
2206 South Main Street
Blacksburg, VA 24060
540-552-0444 Fax: 540-552-0291



COVER SHEET
WESTERN VIRGINIA WATER AUTHORITY FY2011
VCWRLF COLLECTION SYSTEM PROJECTS
MILL MOUNTAIN SEWER RELOCATION
ROANOKE, VIRGINIA

REVISIONS

DESIGNED BY: MJM/BSR
DRAWN BY: MJM/BSR
CHECKED BY: DBH
SCALE: AS NOTED
DATE: 04/14/13
PROJECT NUMBER: 24495.1004 (CHA)
B11132B-04X (DAA)

T-401

AS-BUILT
Inspector Mark Sink