
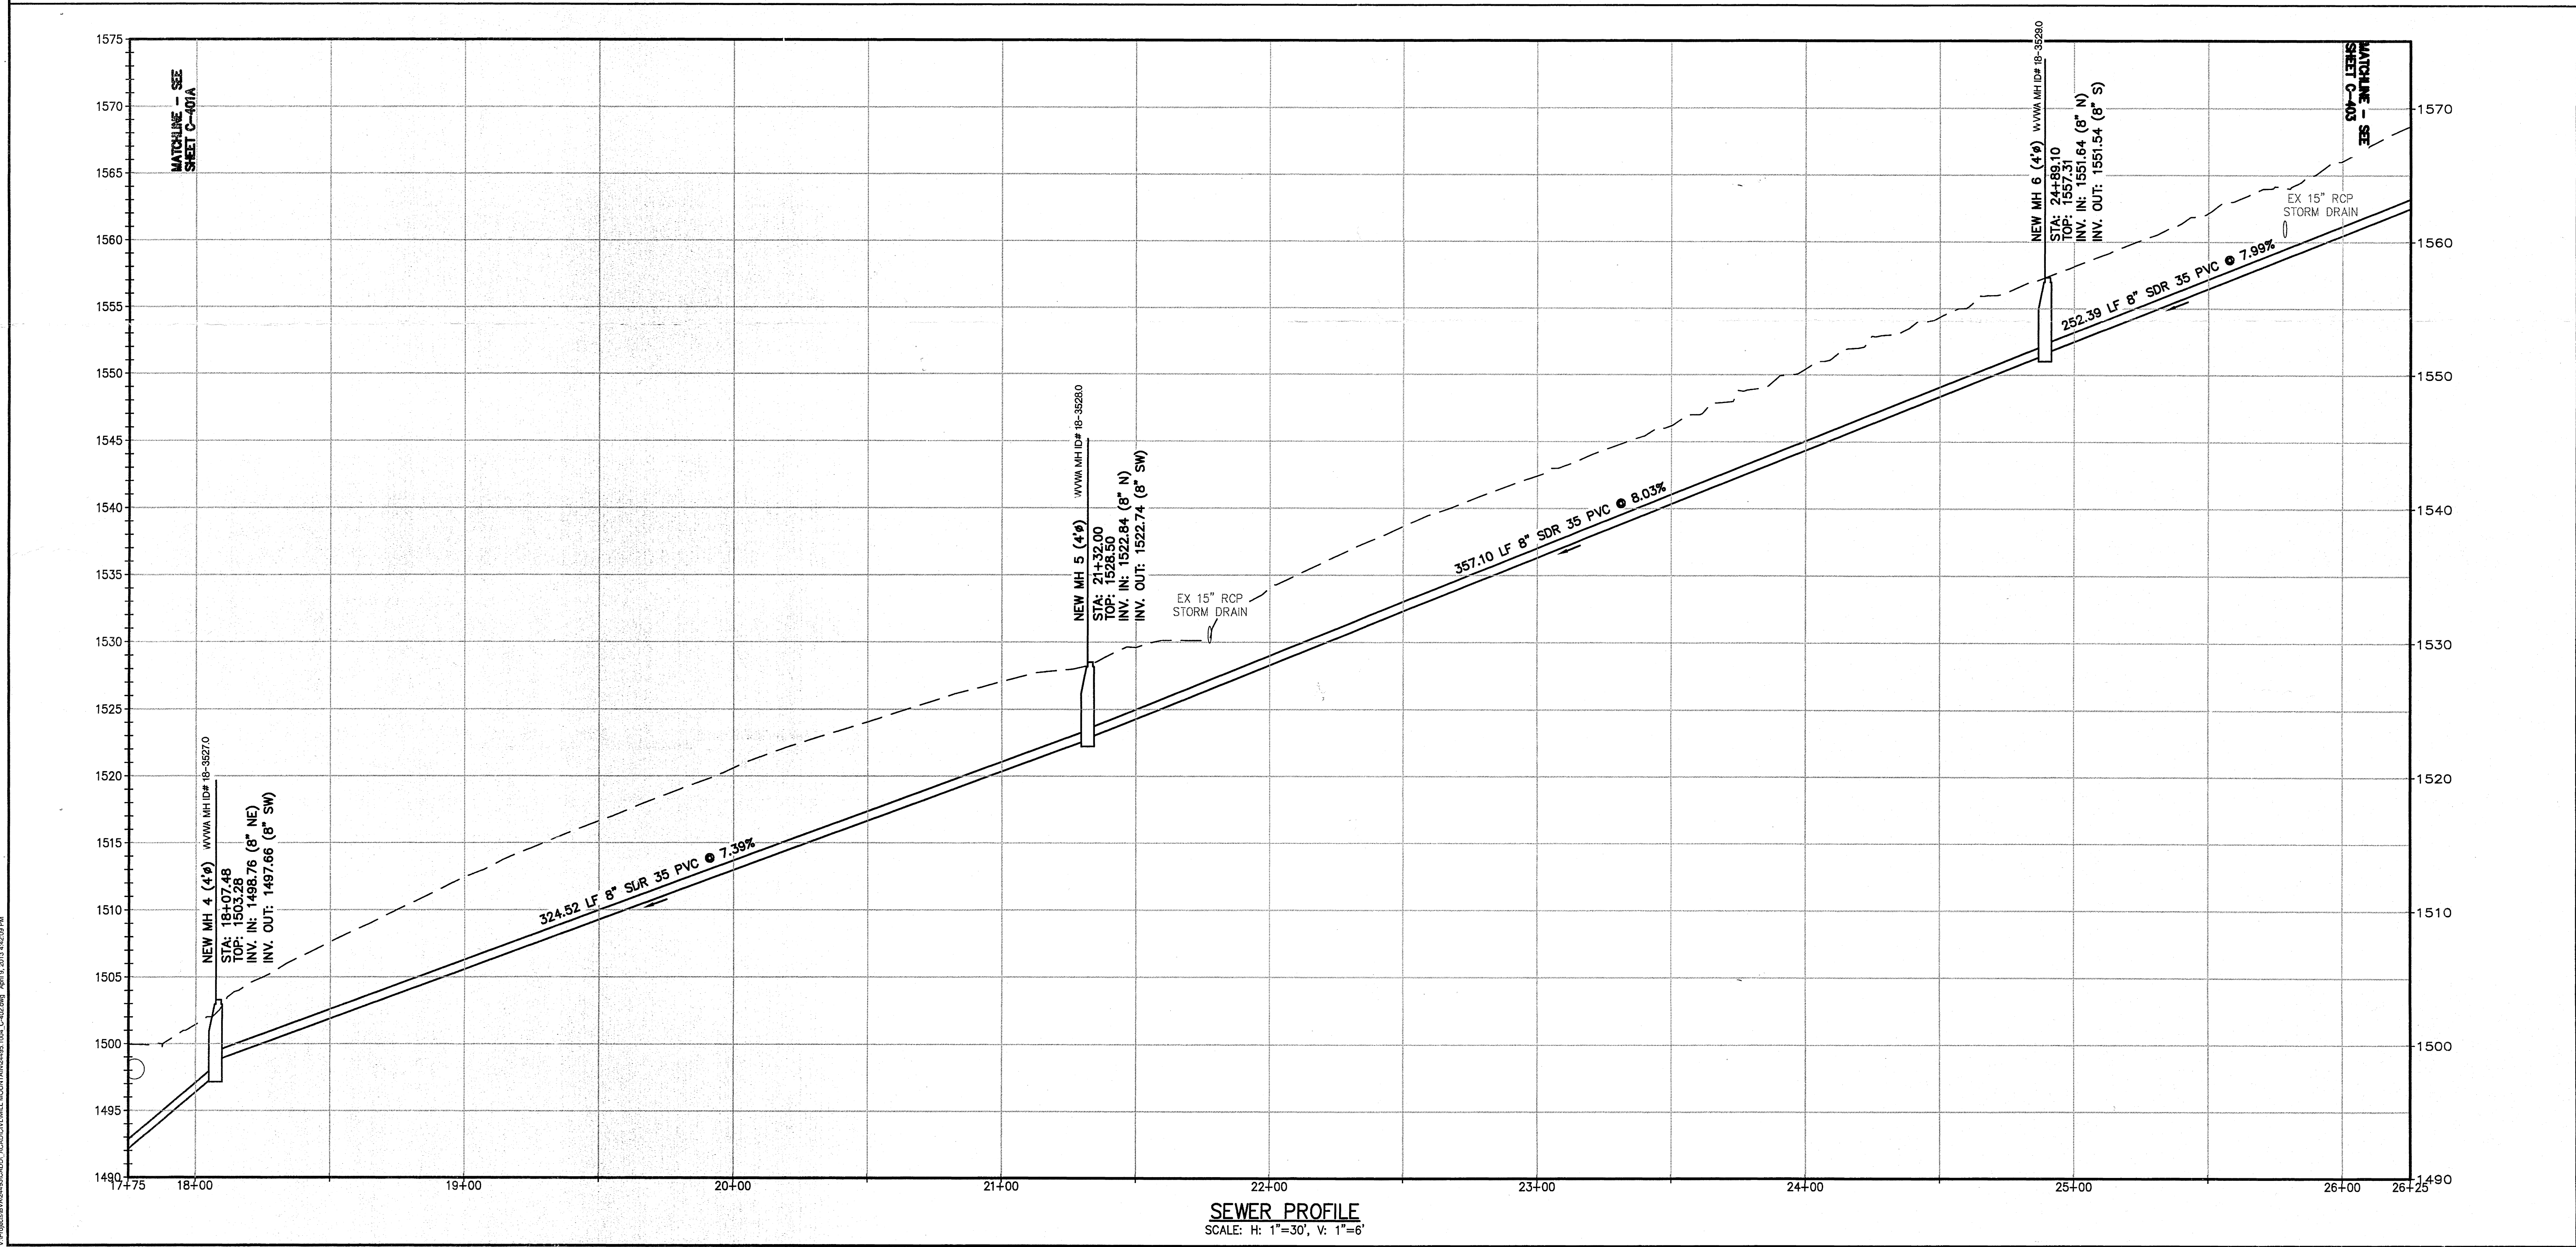


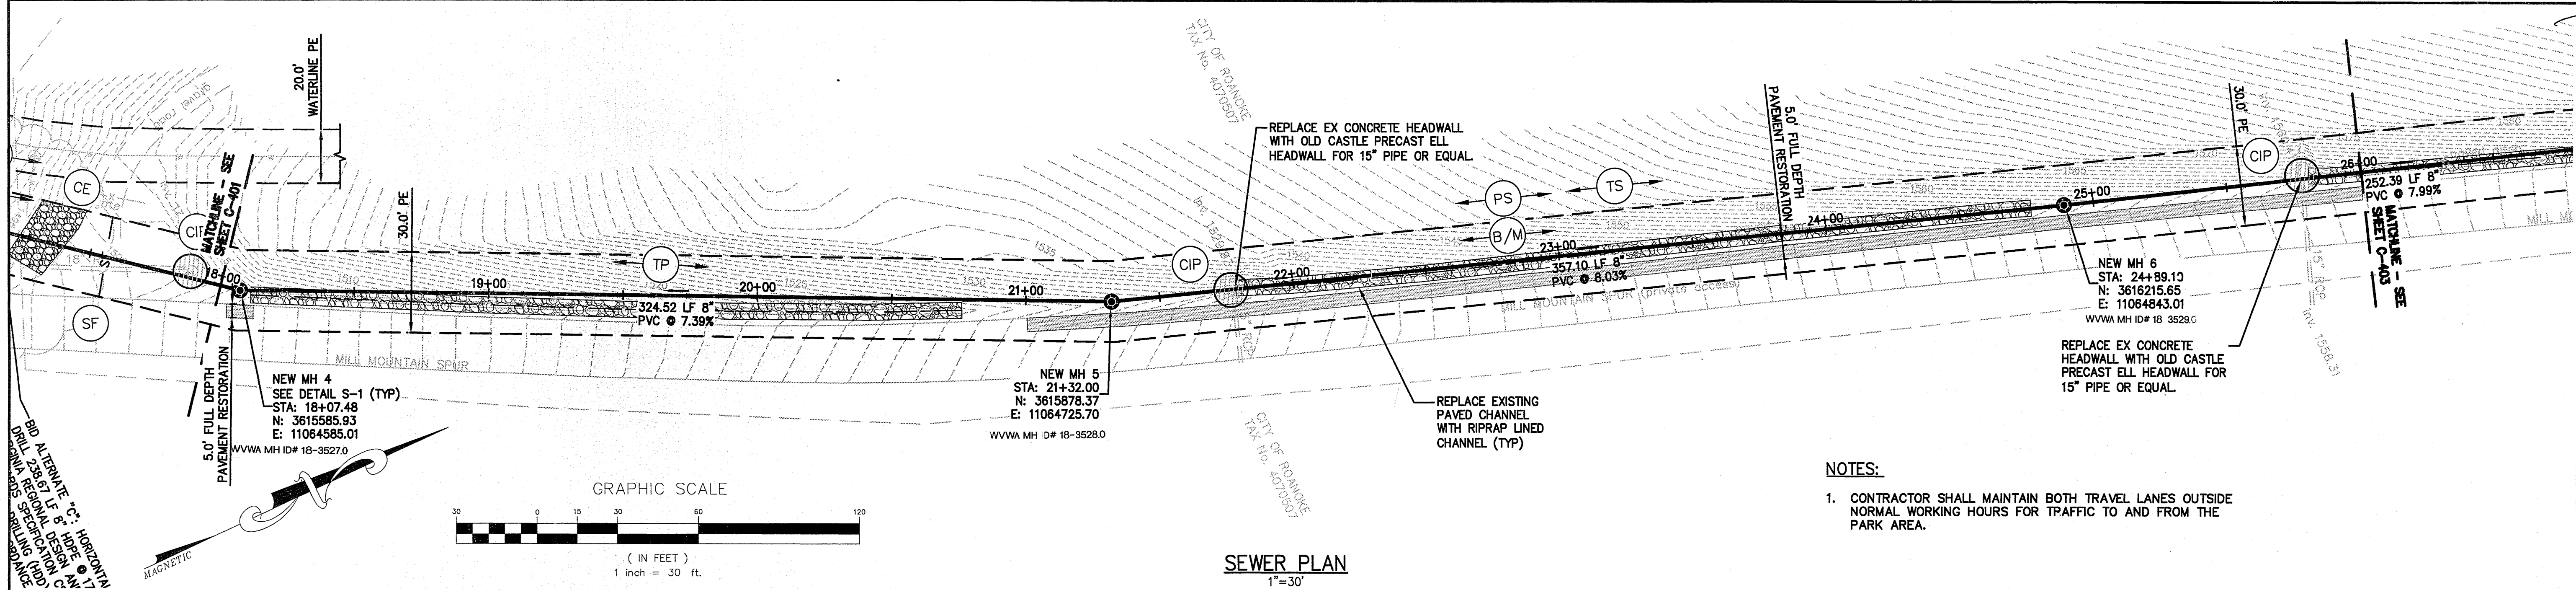

DOUGLAS B. HUGHES
Lic. No. 034694
04/14/13
PROFESSIONAL ENGINEER

Draper Aden Associates
Engineering • Surveying • Environmental Services
2206 South Main Street
Blacksburg, VA 24060
Main: (540) 552-0444 Fax: 540-552-0291

CHA
1901 Innovation Drive, Suite 2100
Blacksburg, VA 24060
Main: (540) 552-8548 • www.chacompanies.com

SEWER PLAN AND PROFILE
WESTERN VIRGINIA WATER AUTHORITY FY2011
VCWRLF COLLECTION SYSTEM PROJECTS
MILL MOUNTAIN SEWER RELOCATION
ROANOKE, VIRGINIA

REVISIONS
DESIGNED BY: MJM/BSR
DRAWN BY: MJM/BSR
CHECKED BY: DBH
SCALE: AS NOTED
DATE: 04/14/13
PROJECT NUMBER: 24495.1004 (CHA) B11132B-04X (DAA)

C-402