
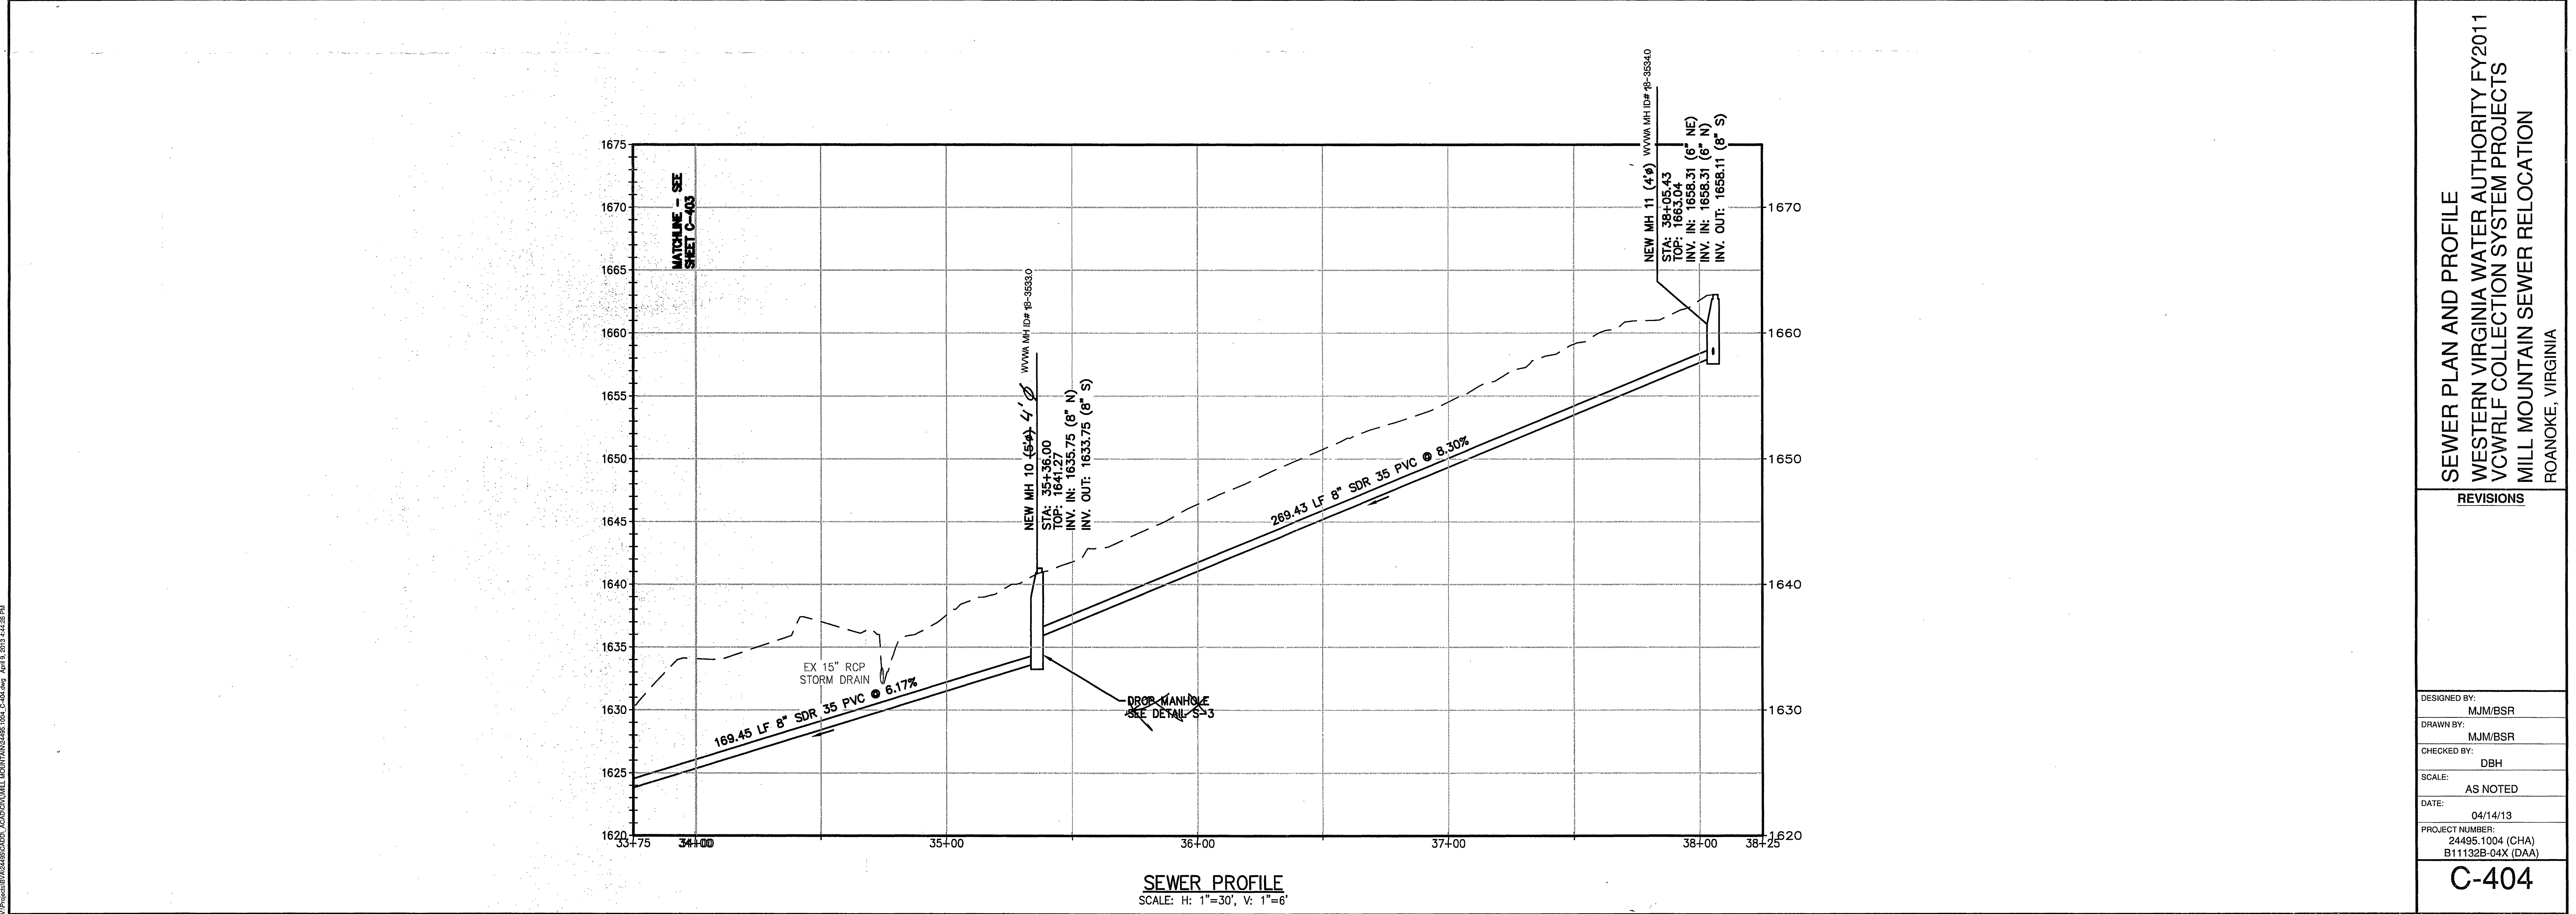


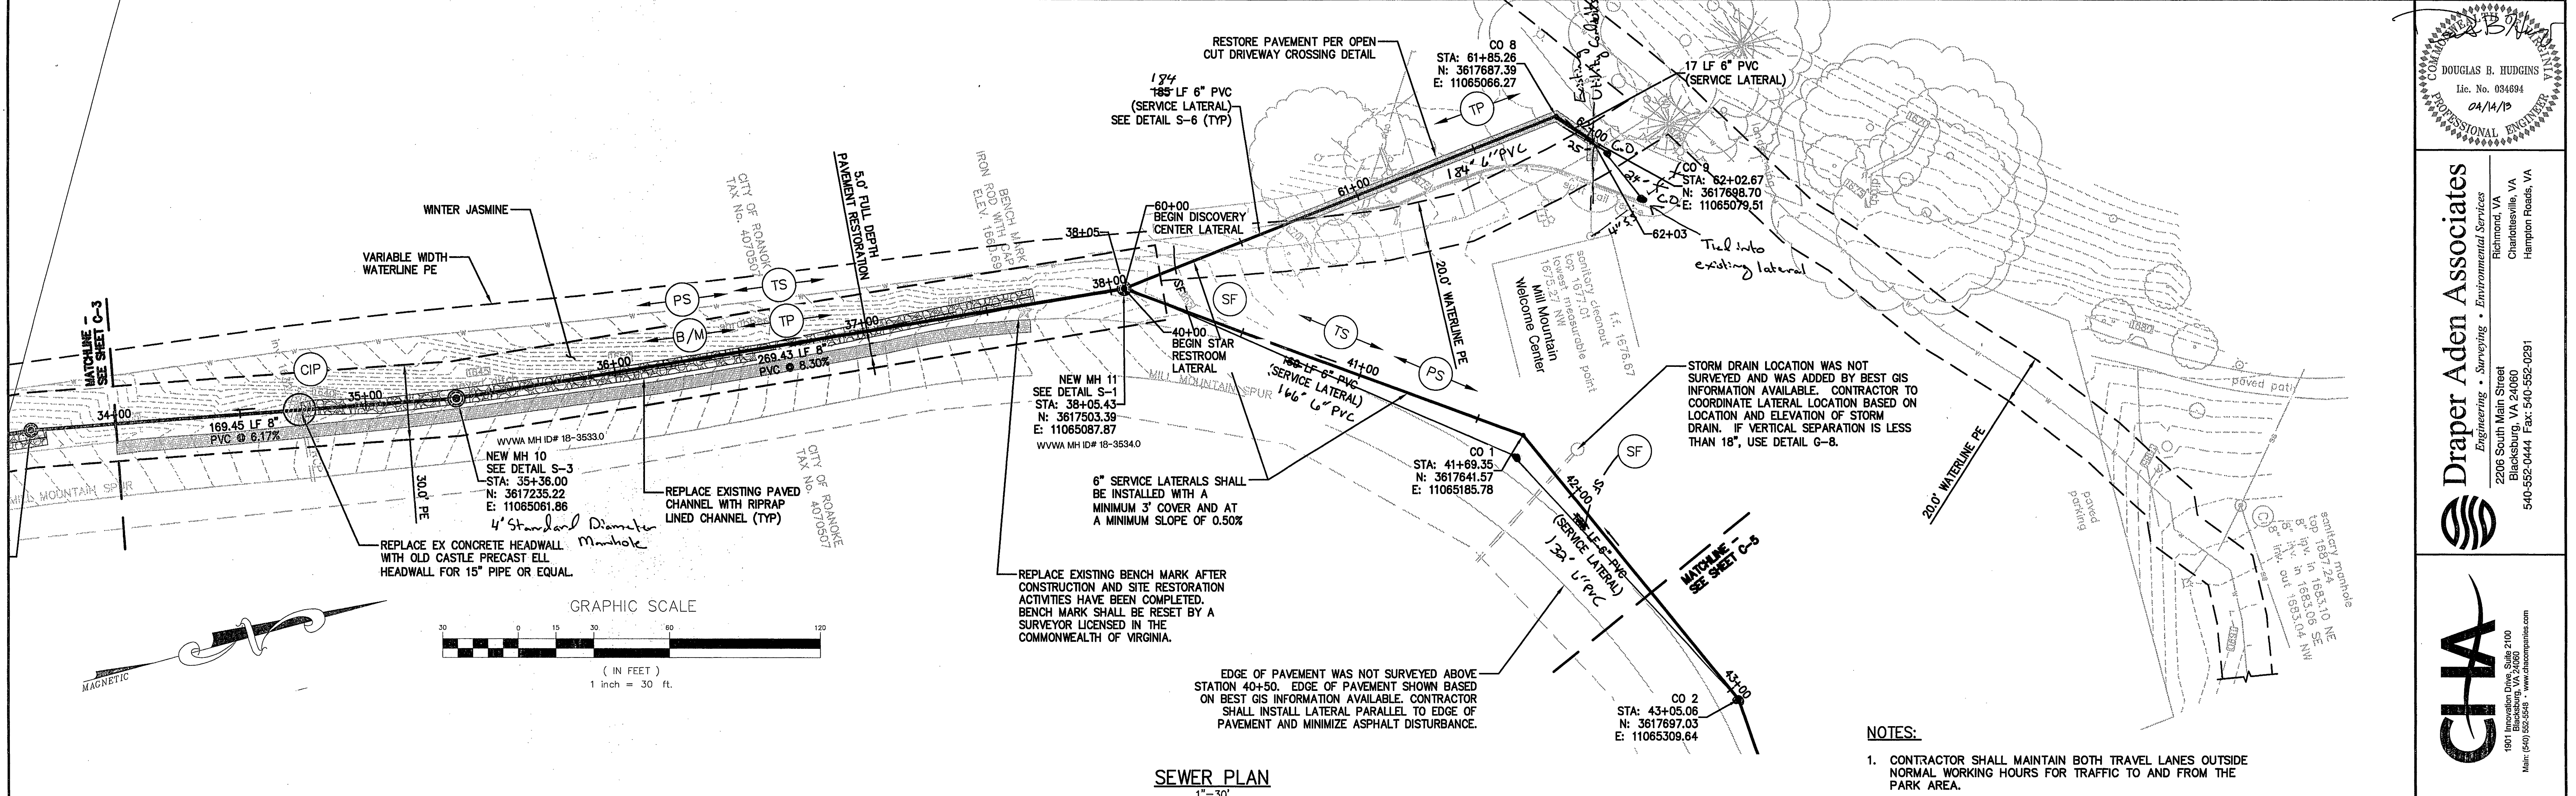

DOUGLAS B. HUDGINS
Lic. No. 034694
04/14/13
PROFESSIONAL ENGINEER

Draper Aden Associates
Engineering • Surveying • Environmental Services
2206 South Main Street
Blacksburg, VA 24060
540-552-0444 Fax: 540-552-0281

1901 Innovation Drive, Suite 2100
Blacksburg, VA 24060
Main: (540) 552-5545 • www.chaengineers.com

SEWER PLAN AND PROFILE
WESTERN VIRGINIA WATER AUTHORITY FY2011
VCWRLF COLLECTION SYSTEM PROJECTS
MILL MOUNTAIN SEWER RELOCATION
ROANOKE, VIRGINIA

REVISIONS

DESIGNED BY:	MJM/BSR
DRAWN BY:	MJM/BSR
CHECKED BY:	DBH
SCALE:	AS NOTED
DATE:	04/14/13
PROJECT NUMBER:	24495.1004 (CHA) B11132B-04X (DAA)

C-404