


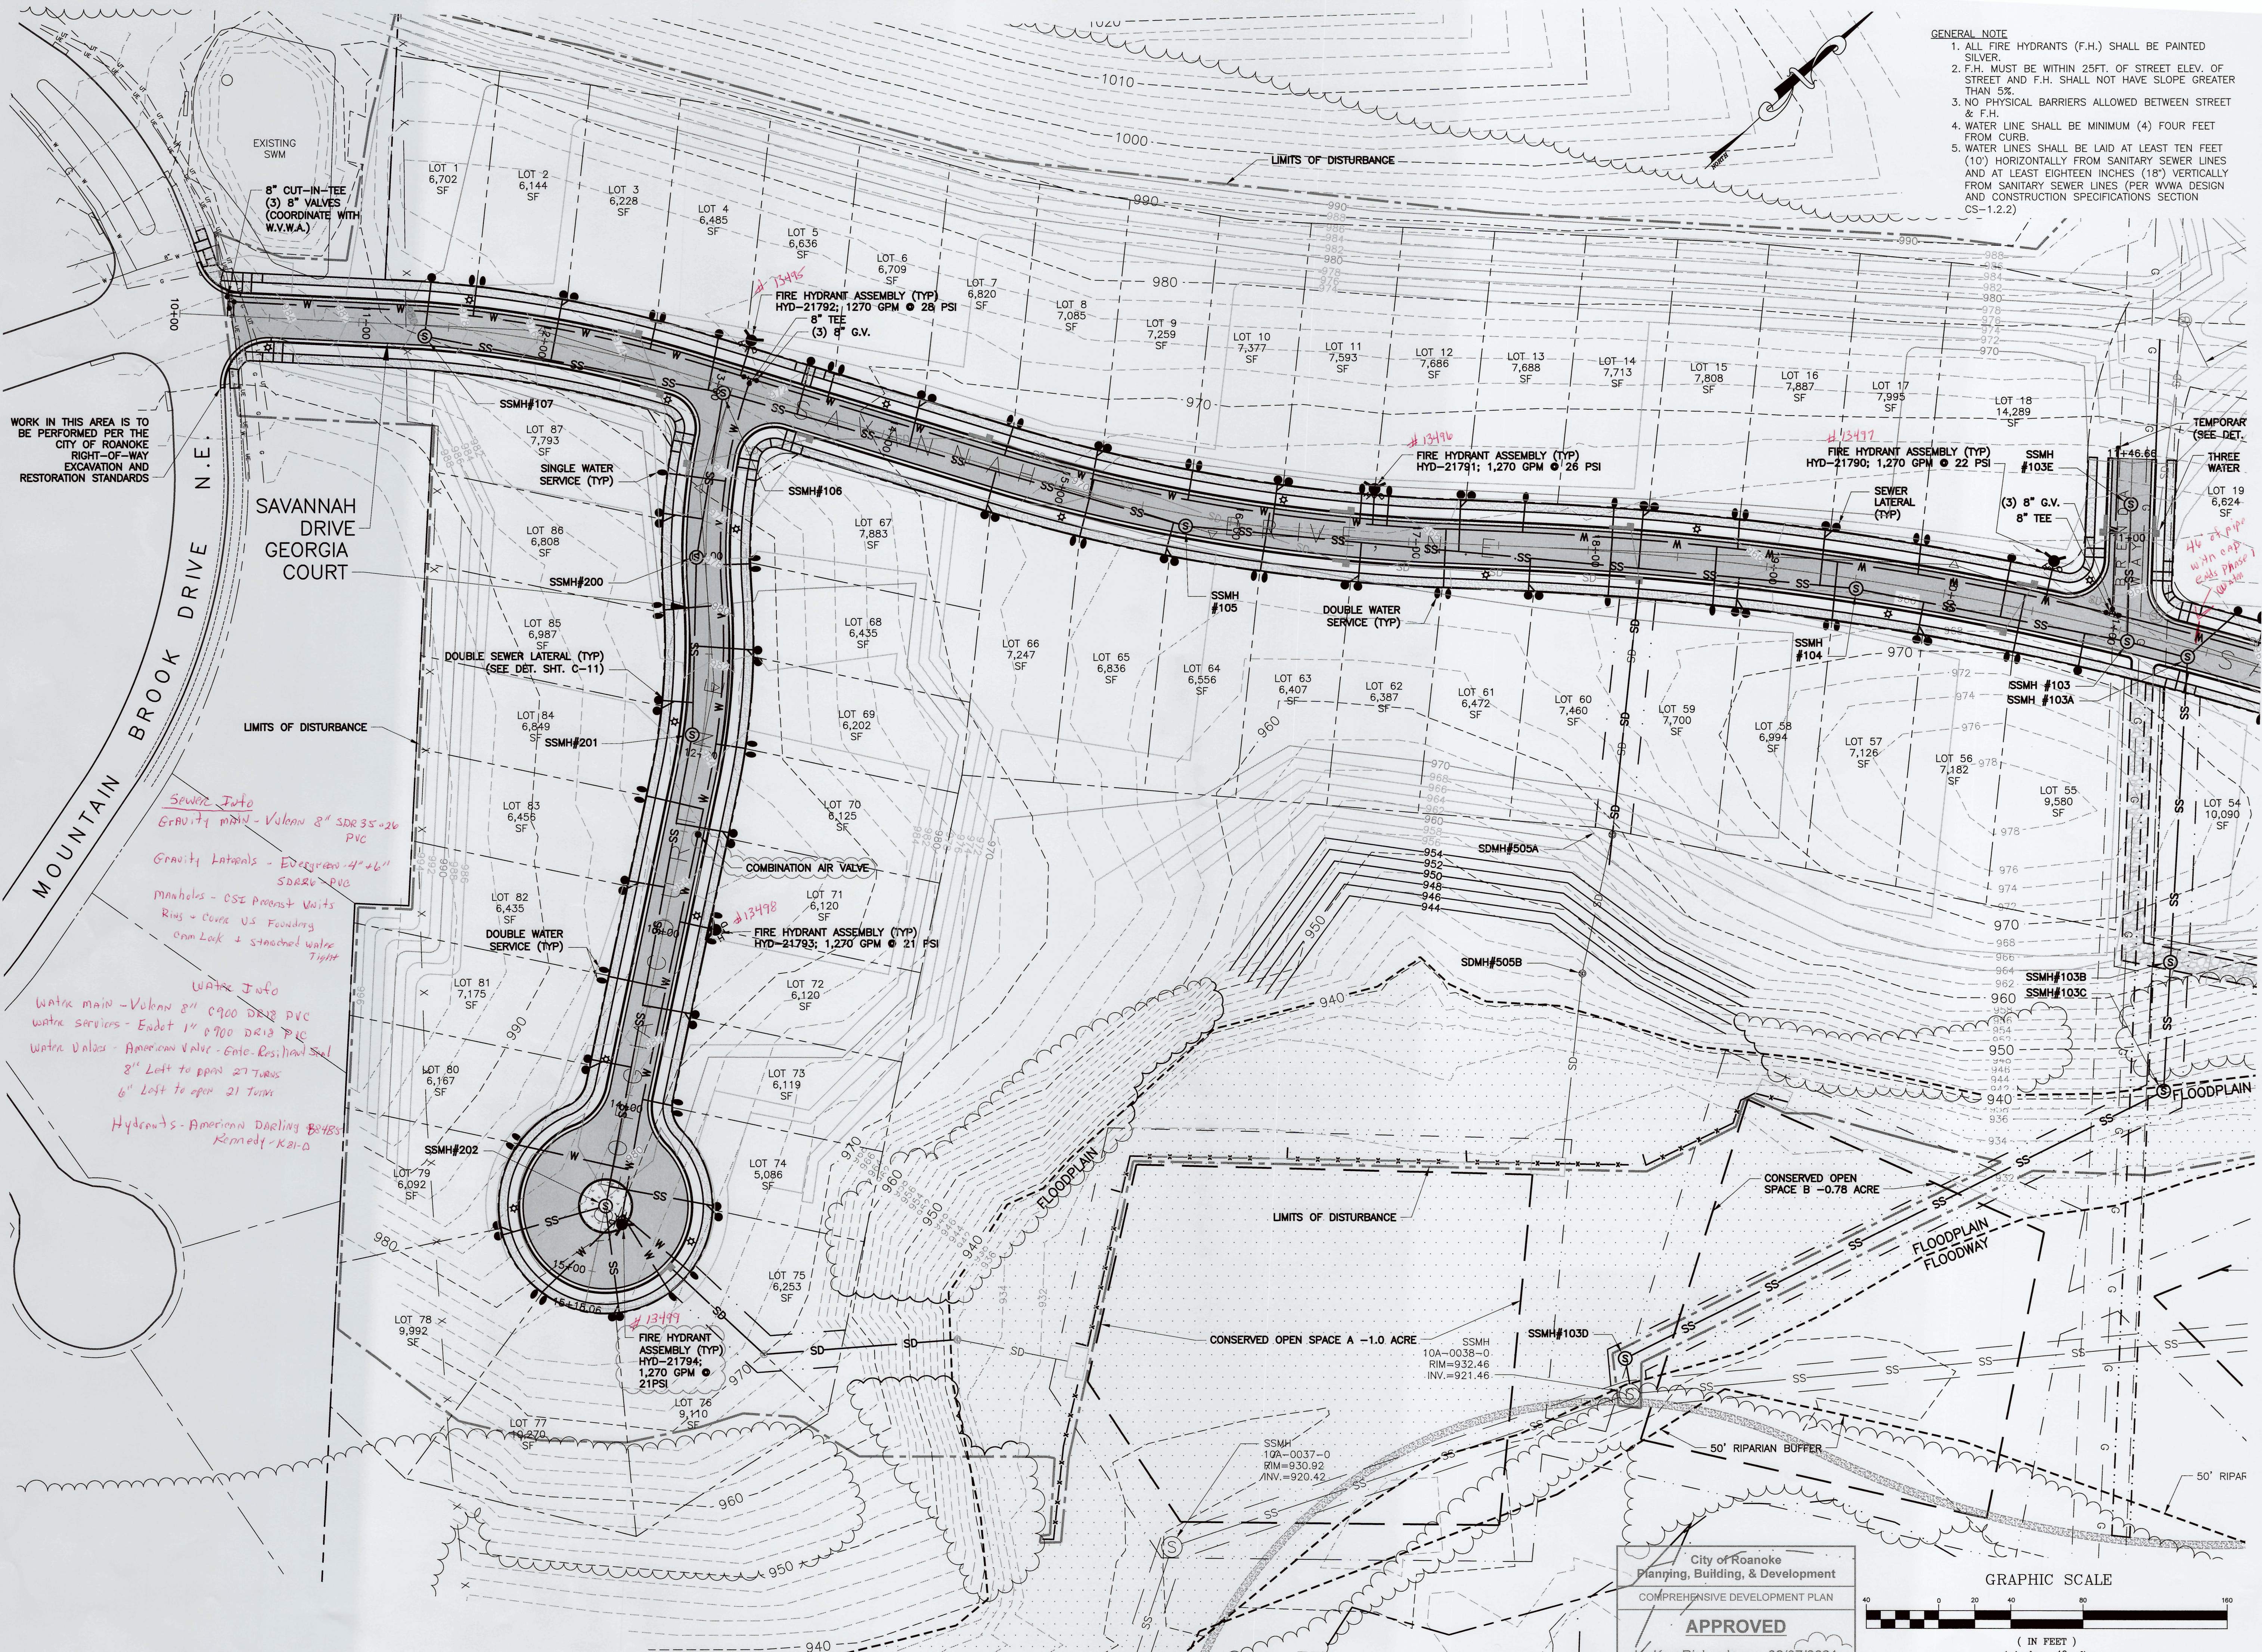

- GENERAL NOTE
1. ALL FIRE HYDRANTS (F.H.) SHALL BE PAINTED SILVER.
 2. F.H. MUST BE WITHIN 25FT. OF STREET ELEV. OF STREET AND F.H. SHALL NOT HAVE SLOPE GREATER THAN 5%.
 3. NO PHYSICAL BARRIERS ALLOWED BETWEEN STREET & F.H.
 4. WATER LINE SHALL BE MINIMUM (4) FOUR FEET FROM CURB.
 5. WATER LINES SHALL BE LAID AT LEAST TEN FEET (10') HORIZONTALLY FROM SANITARY SEWER LINES AND AT LEAST EIGHTEEN INCHES (18") VERTICALLY FROM SANITARY SEWER LINES (PER WWA DESIGN AND CONSTRUCTION SPECIFICATIONS SECTION CS-1.2.2)

**MEREDITH
ENGINEERING-SURVEYING P.L.L.C.**


www.inwpc.net
ph: 540.353.048
dmeredith@inwpc.com

1647 Millwood Dr.
Salem, Virginia 24153

my as-built
08/04/2022
Mark A.A.

**MOUNTAIN BROOK VILLAS
COMPREHENSIVE
DEVELOPMENT PLAN
UTILITY PLAN
ROANOKE, VIRGINIA**

No.	Description	Date	By

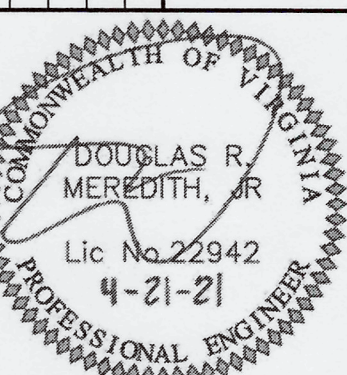

Drawn By	MCP
Checked By	RCW
Project Date	08/17/20
Drawing	4343
Commission No.	4343