
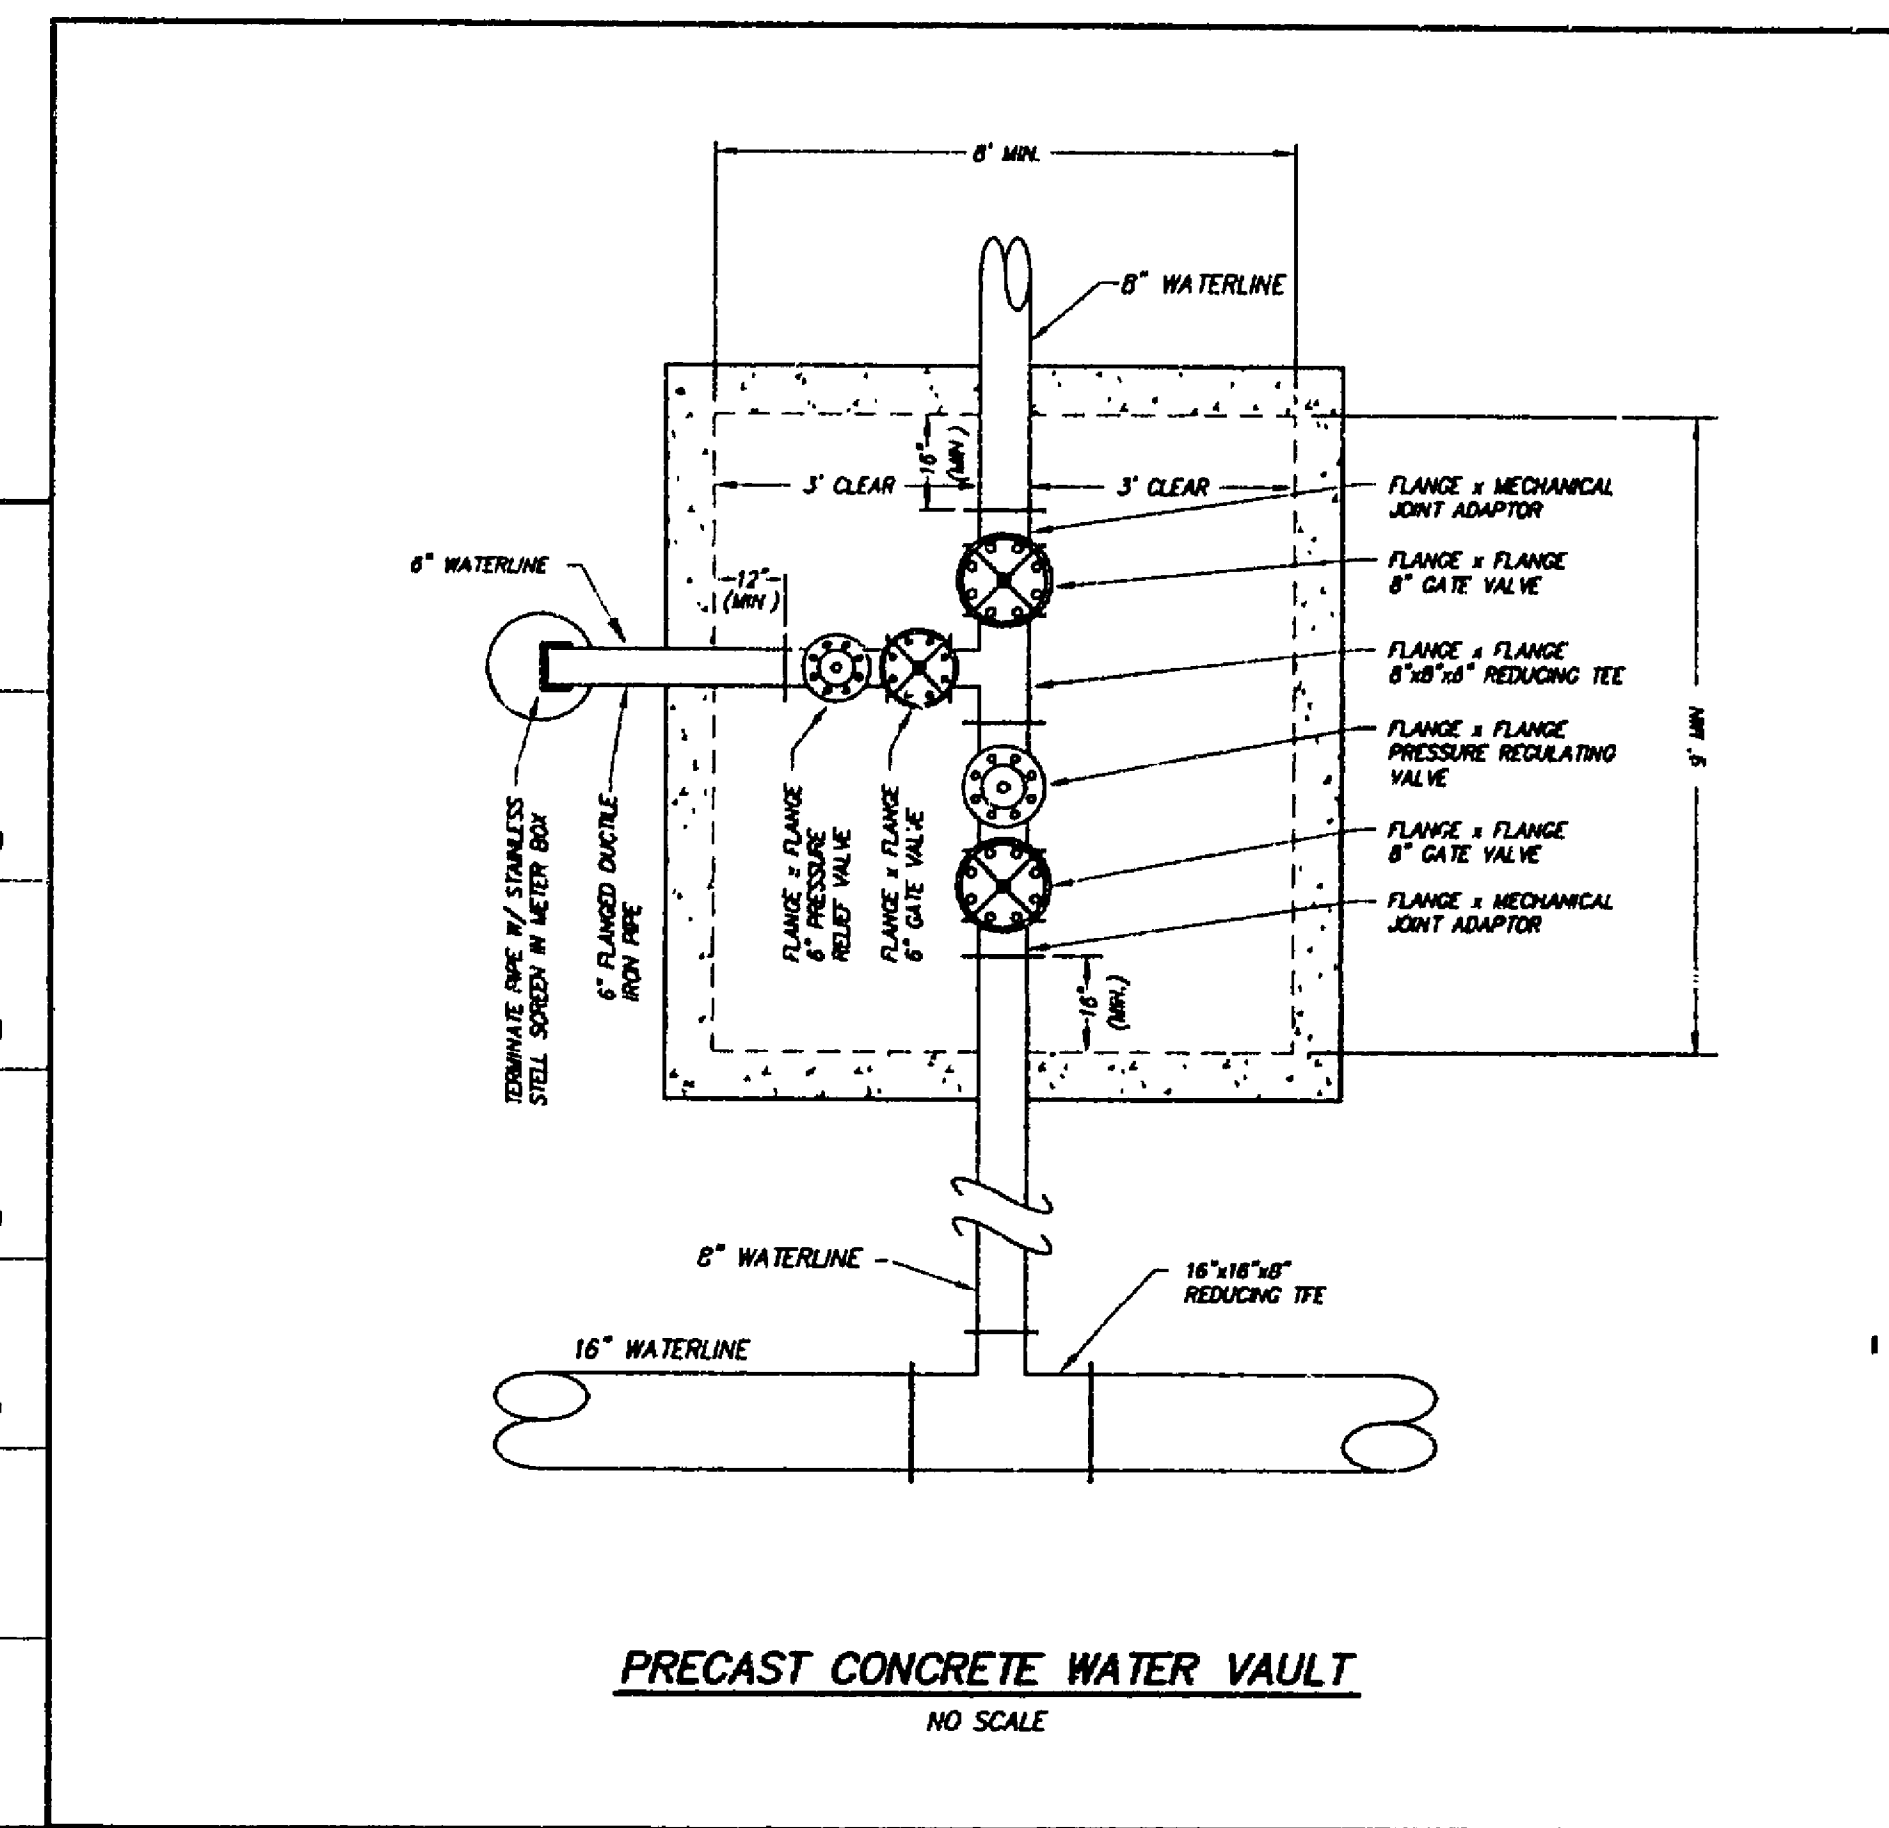
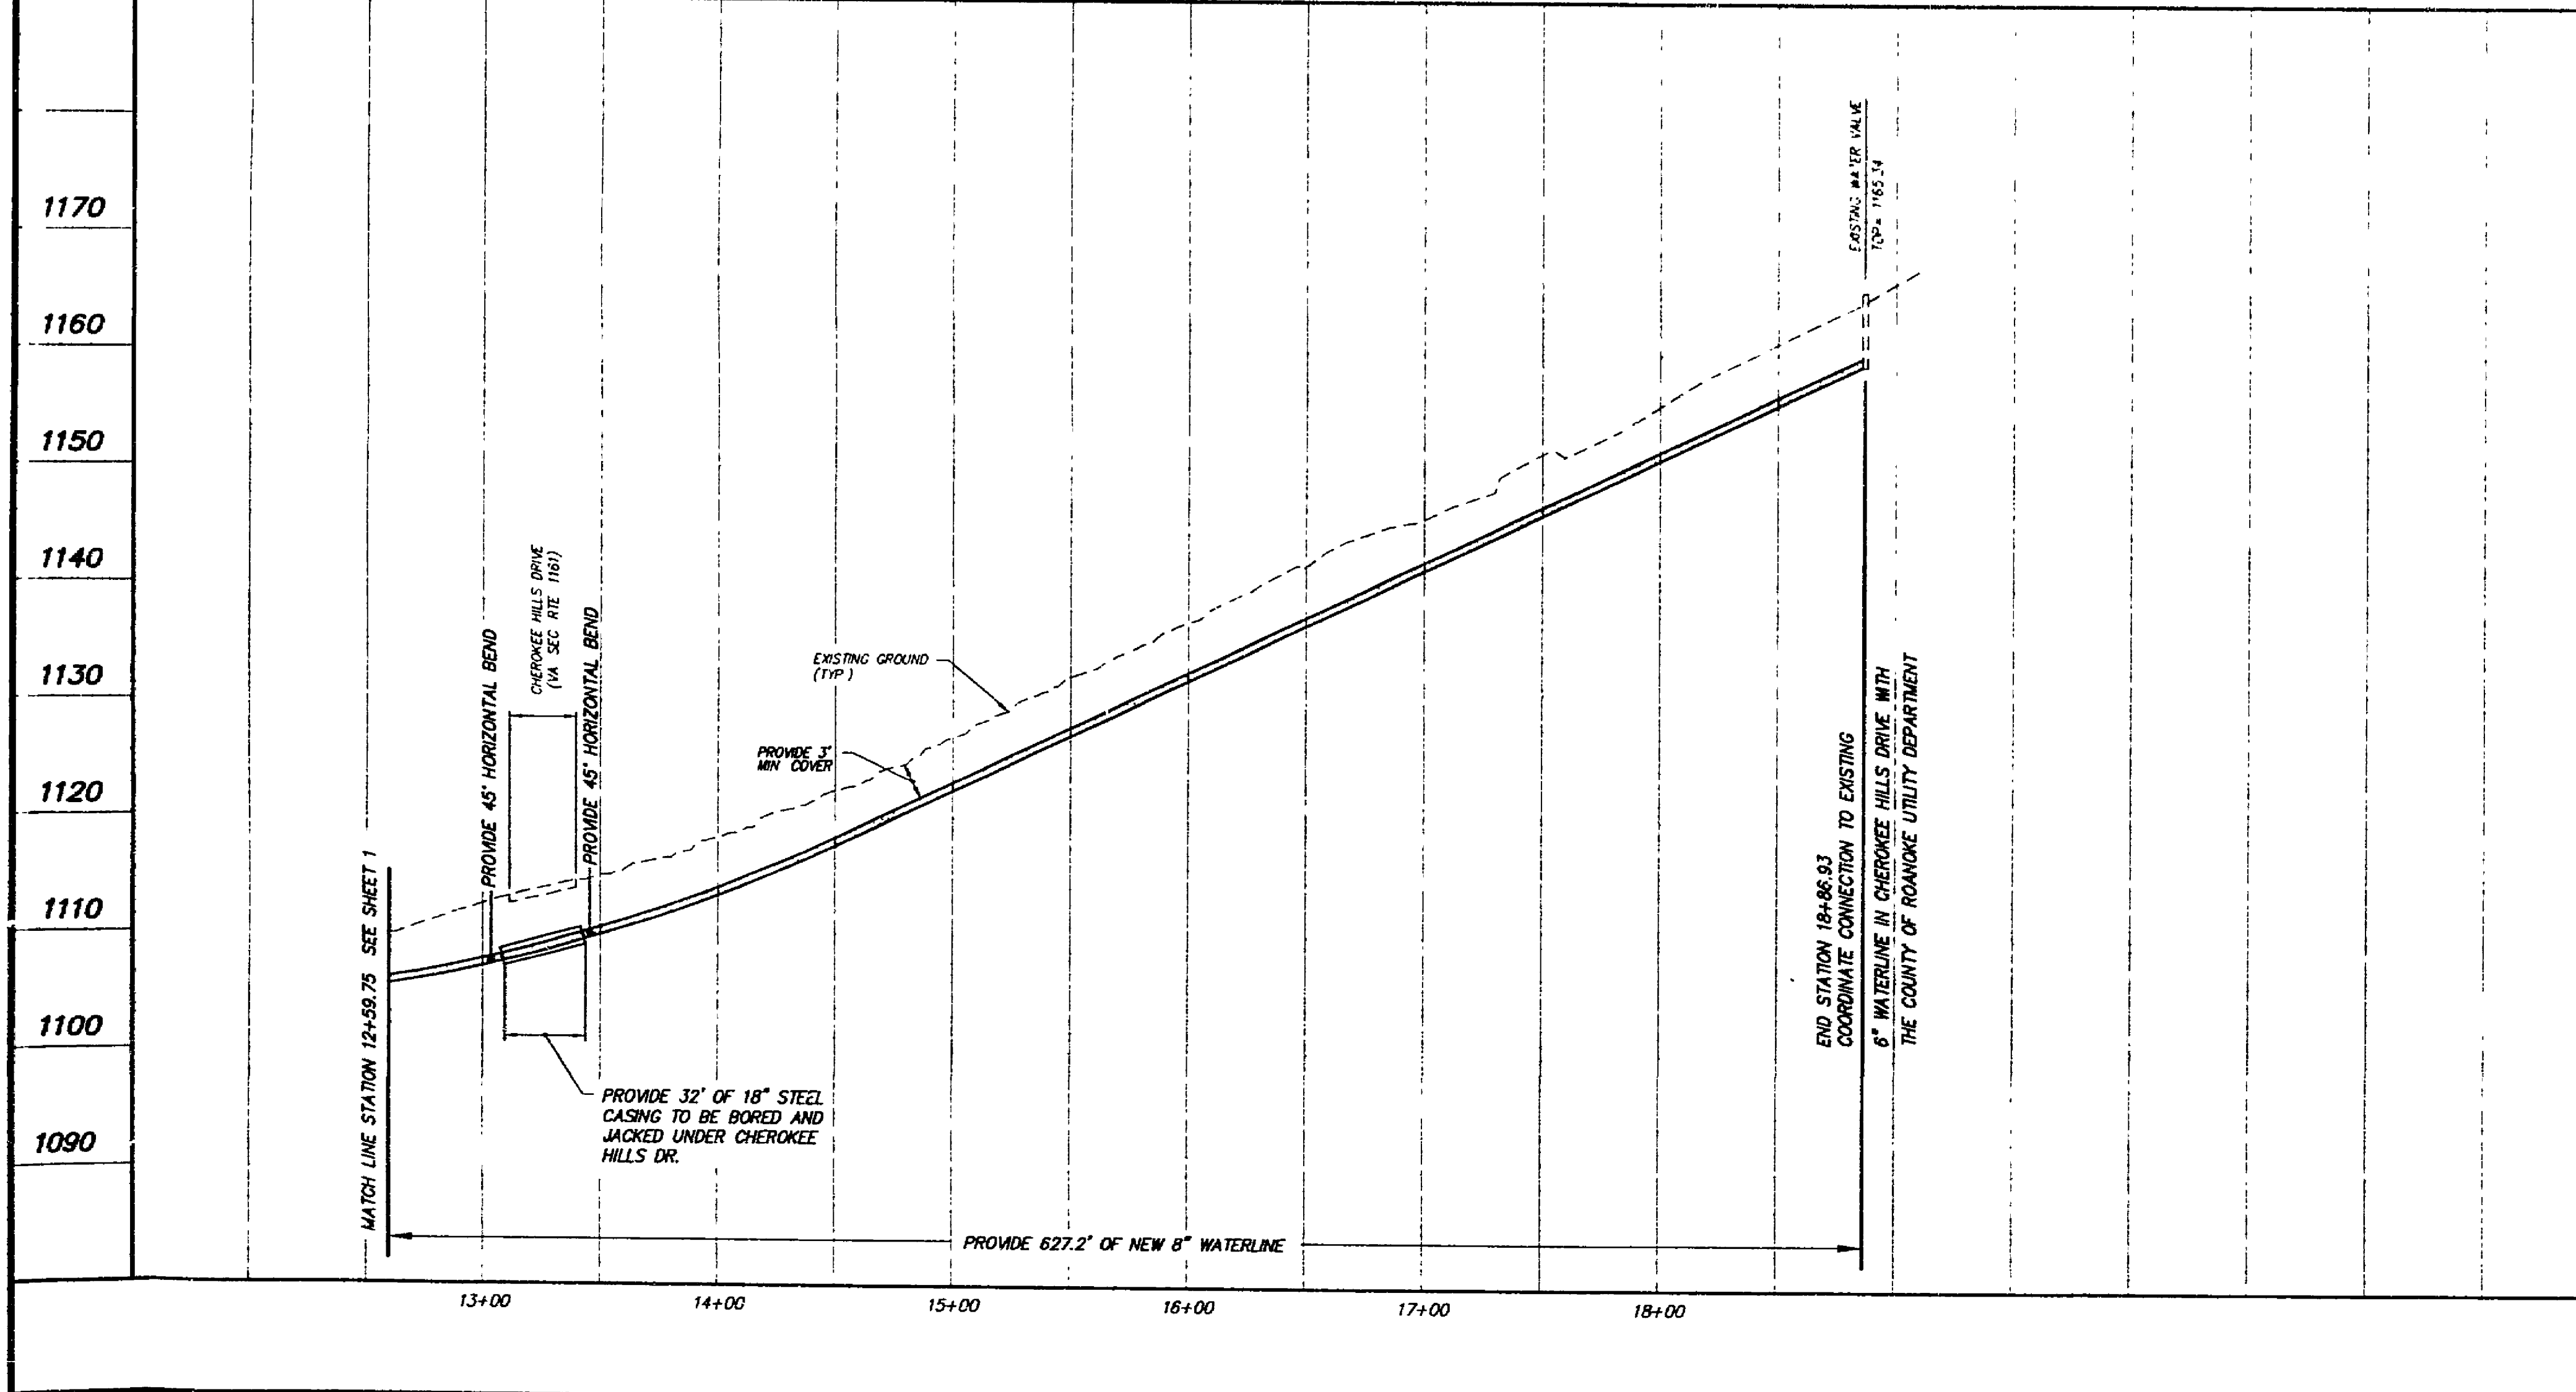


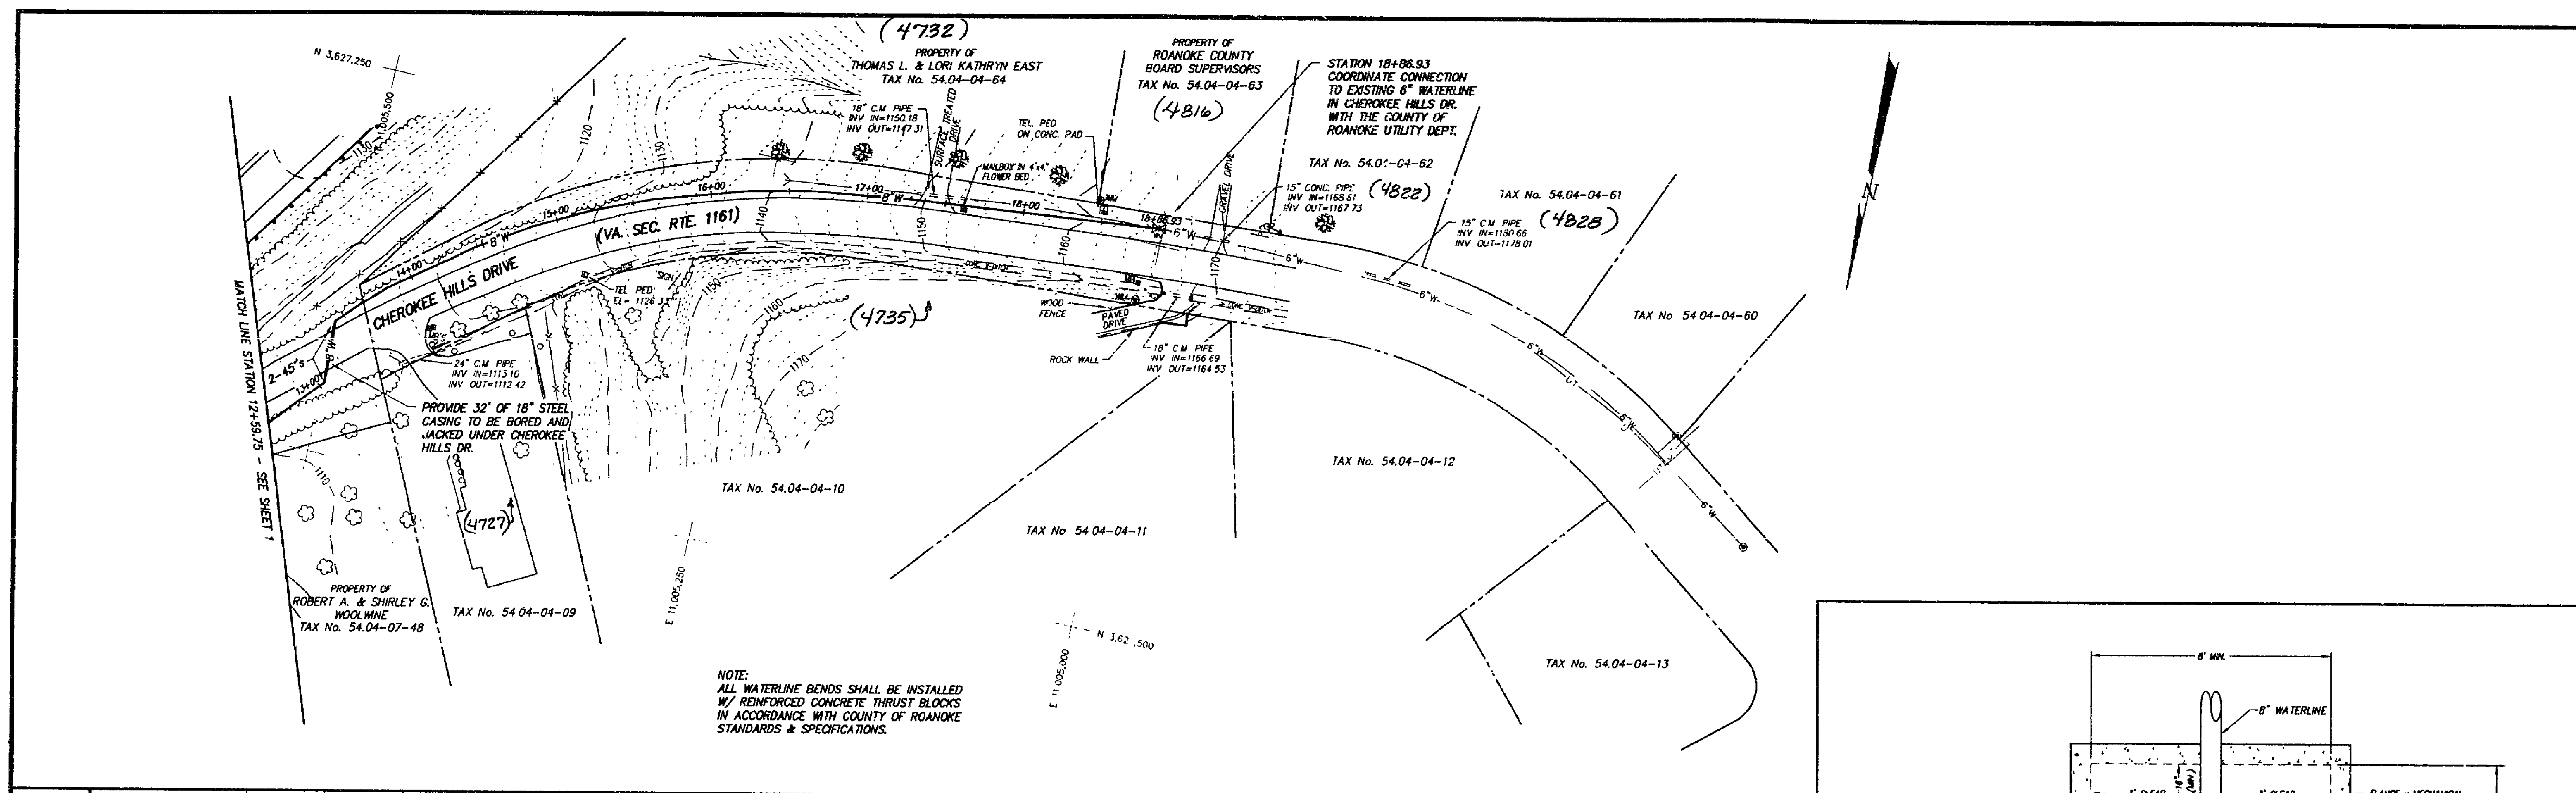

50' 25' 0' 50' 100' 1" = 50'

GRAPHIC SCALE

PLAN AND PROFILE FOR
NORTH LOOP WATER TRANSMISSION MAIN
PHASE 1
FOR
THE COUNTY OF ROANOKE
SITUATE CATAMBA MAGISTERIAL DISTRICT
COUNTY OF ROANOKE, VIRGINIA
SCALE: AS SHOWN DATE: JANUARY 5, 1996

DESIGNED BY: C. L. WHITE
DRAWN BY: J. J. BERGLOFF
CHECKED BY: F. B. CALDWELL
W.O. # 92-1077
N.B.
TAX NO.

FRANK B. CALDWELL, III
NO. 9184
PROFESSIONAL ENGINEER

T. P. PARKER & SON
816 Boulevard
Post Office Box 39
Salem, Virginia 24153
Telephone: 540-387-1163
FAX: 540-388-0767

TPP&S
ENGINEERS
SURVEYORS
PLANNERS