
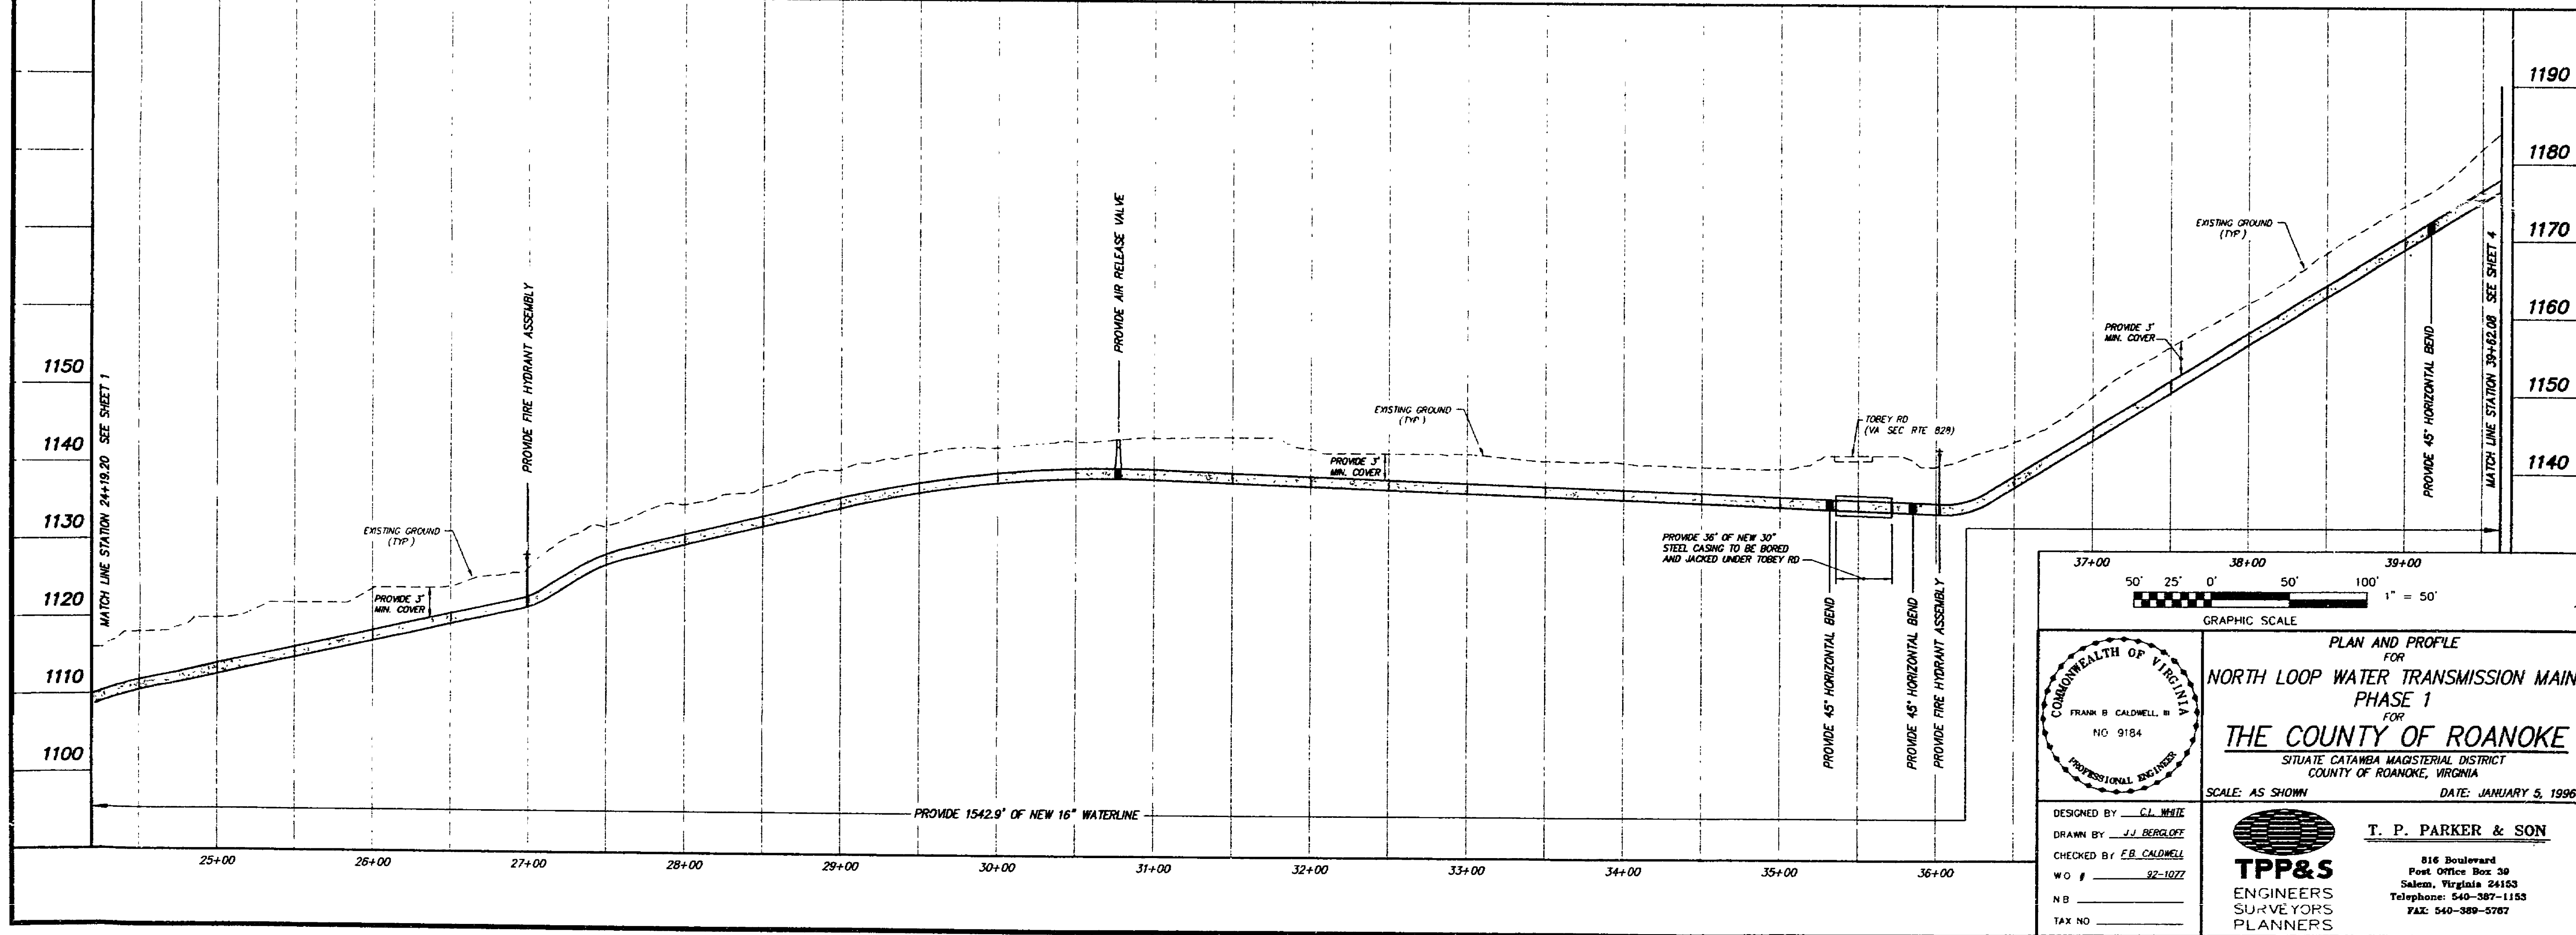


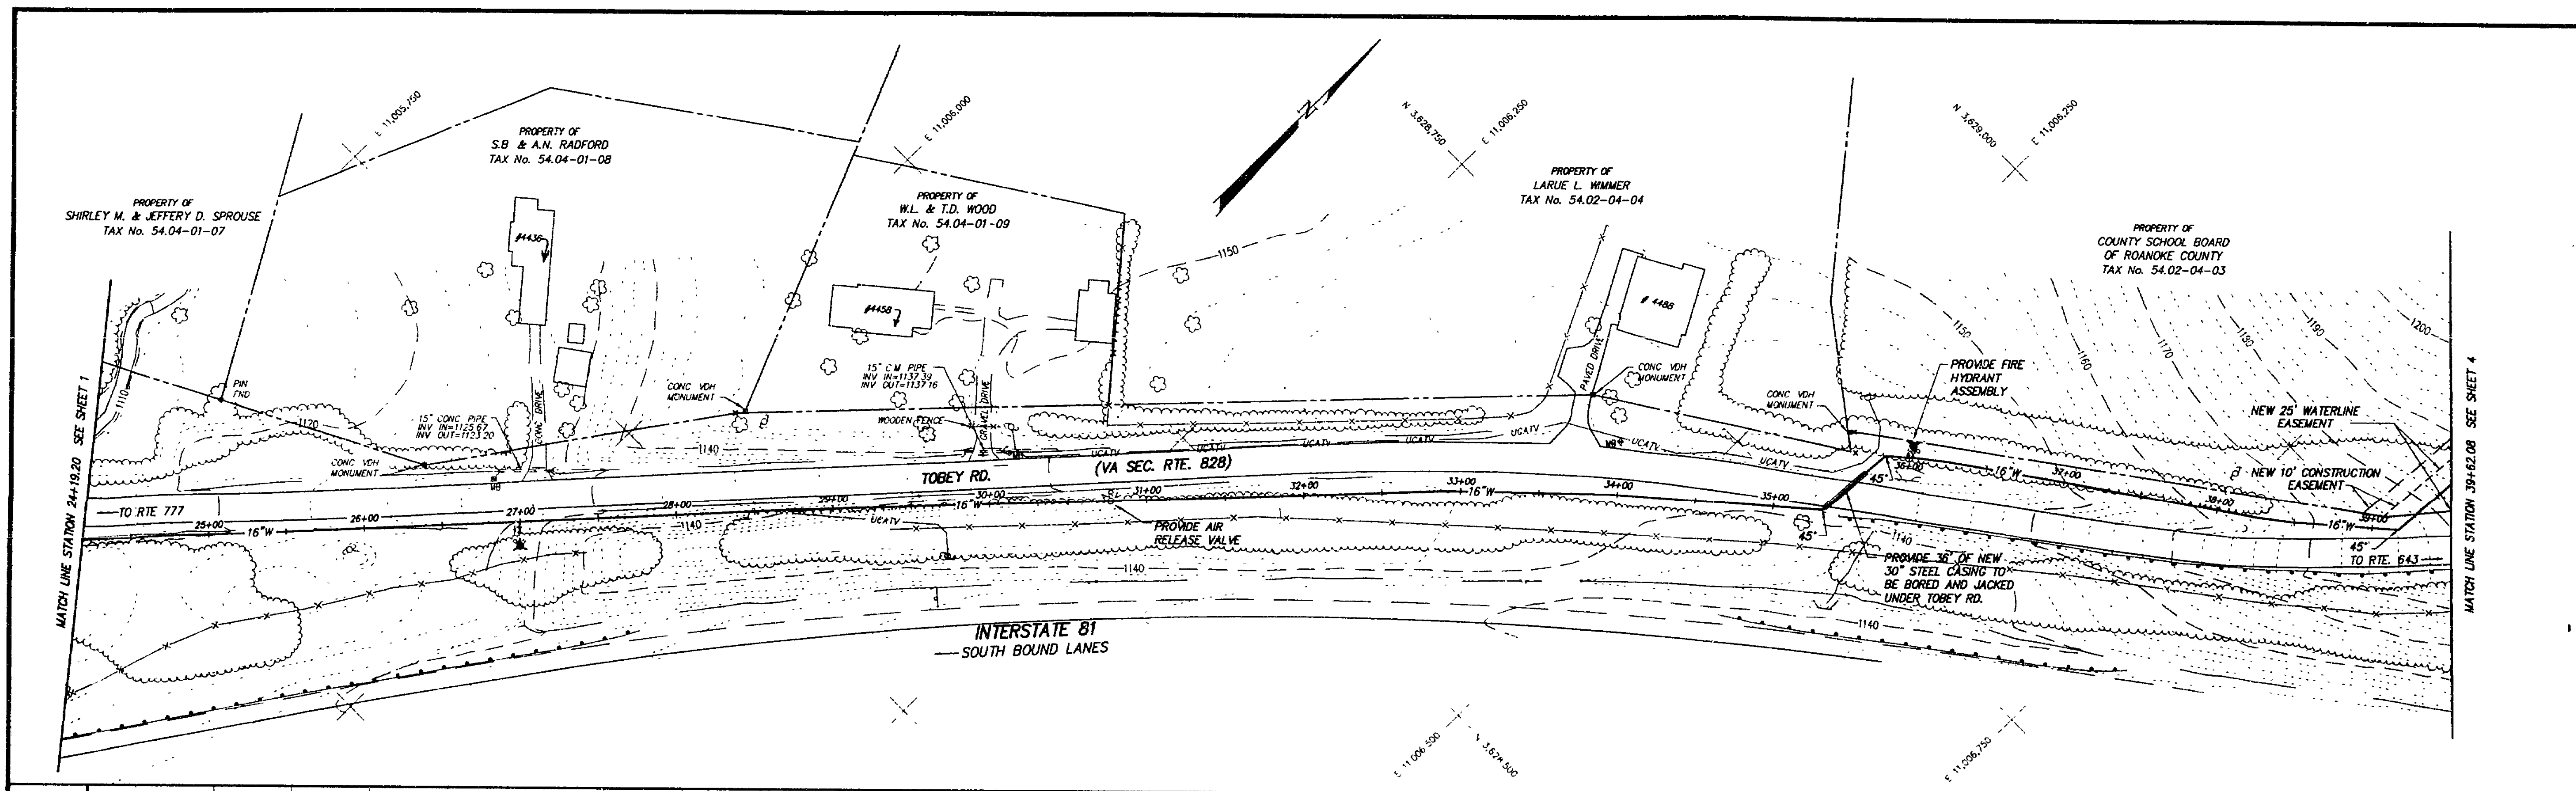

37+00 38+00 39+00
50' 25' 0' 50' 100' 1" = 50'
GRAPHIC SCALE

COMMONWEALTH OF VIRGINIA
FRANK B. CALDWELL, II
NO. 9184
PROFESSIONAL SURVEYOR

DESIGNED BY C.J. WHITE
DRAWN BY J.J. BERGLOFF
CHECKED BY F.B. CALDWELL
W.O. # 92-1077
N.B.
TAX NO.

PLAN AND PROFILE
FOR
NORTH LOOP WATER TRANSMISSION MAIN
PHASE 1
FOR
THE COUNTY OF ROANOKE
SITUATE CATAMBA MAGISTERIAL DISTRICT
COUNTY OF ROANOKE, VIRGINIA
SCALE: AS SHOWN DATE: JANUARY 5, 1996

T. P. PARKER & SON
816 Boulevard
Post Office Box 30
Salem, Virginia 24153
Telephone: 540-387-1153
FAX: 540-389-5707

TPP&S
ENGINEERS
SURVEYORS
PLANNERS