

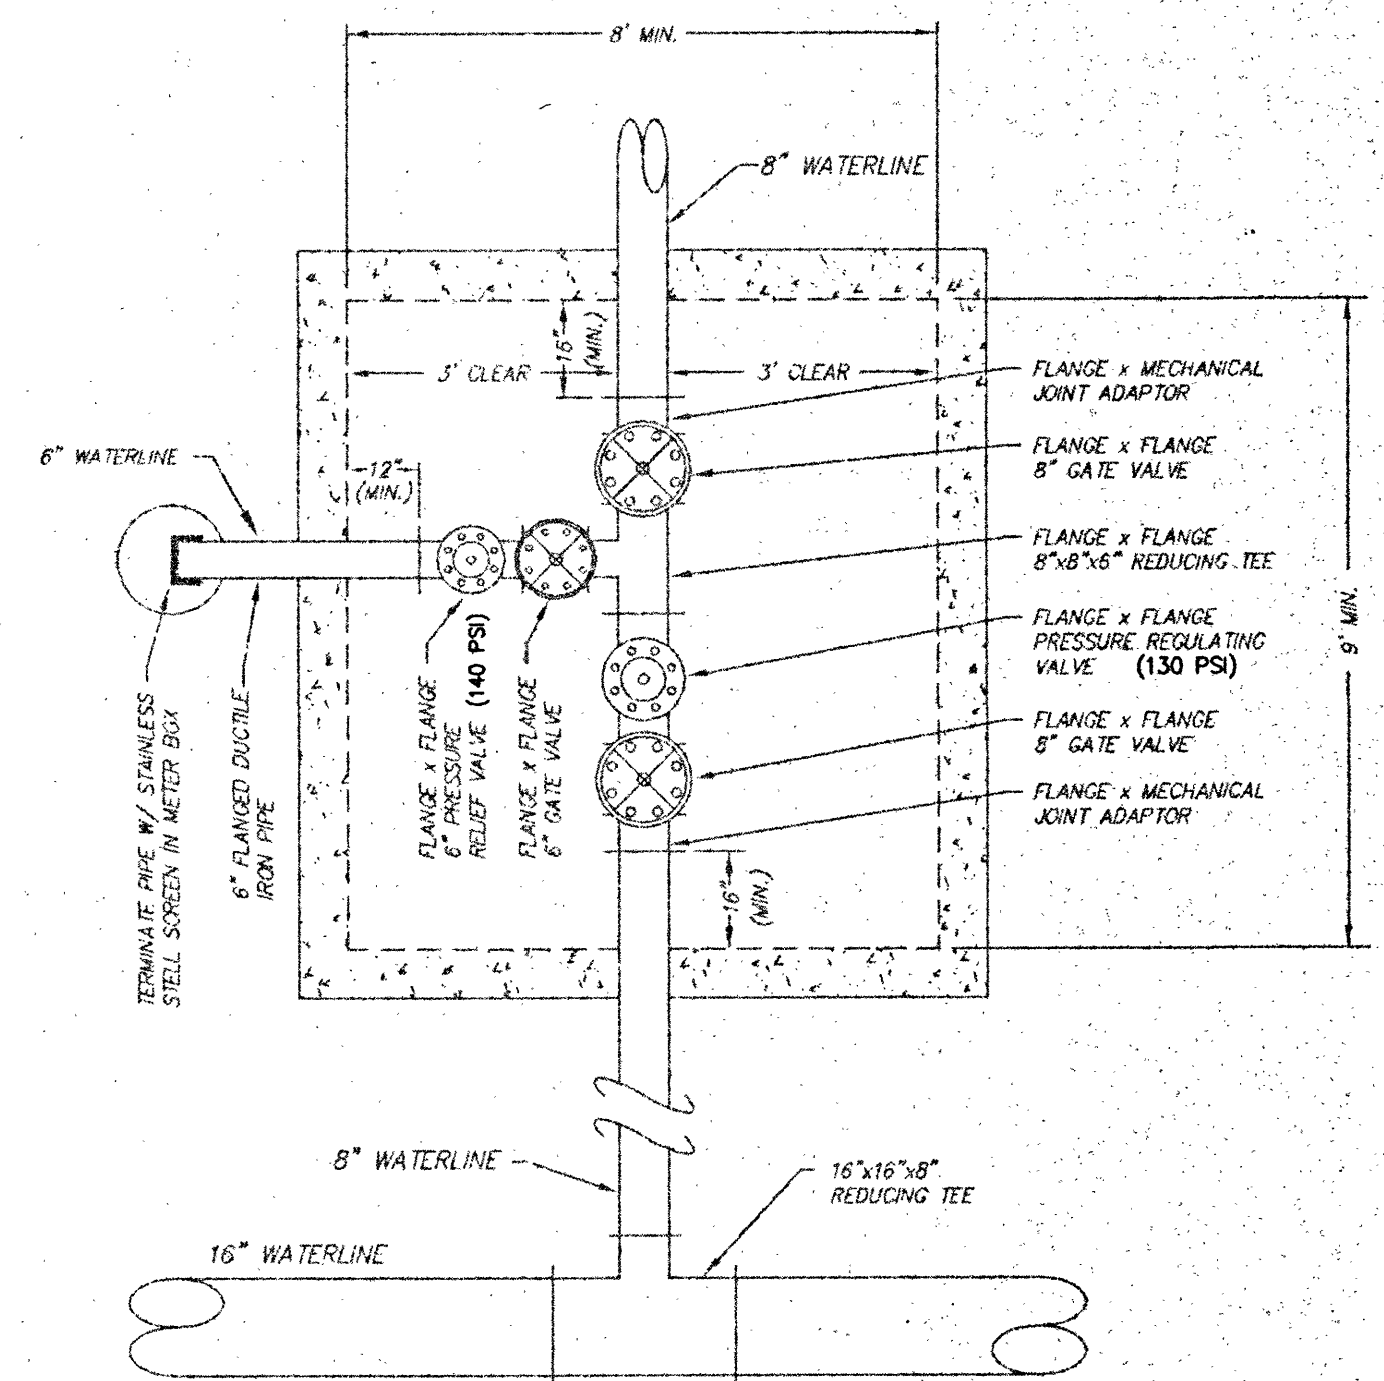
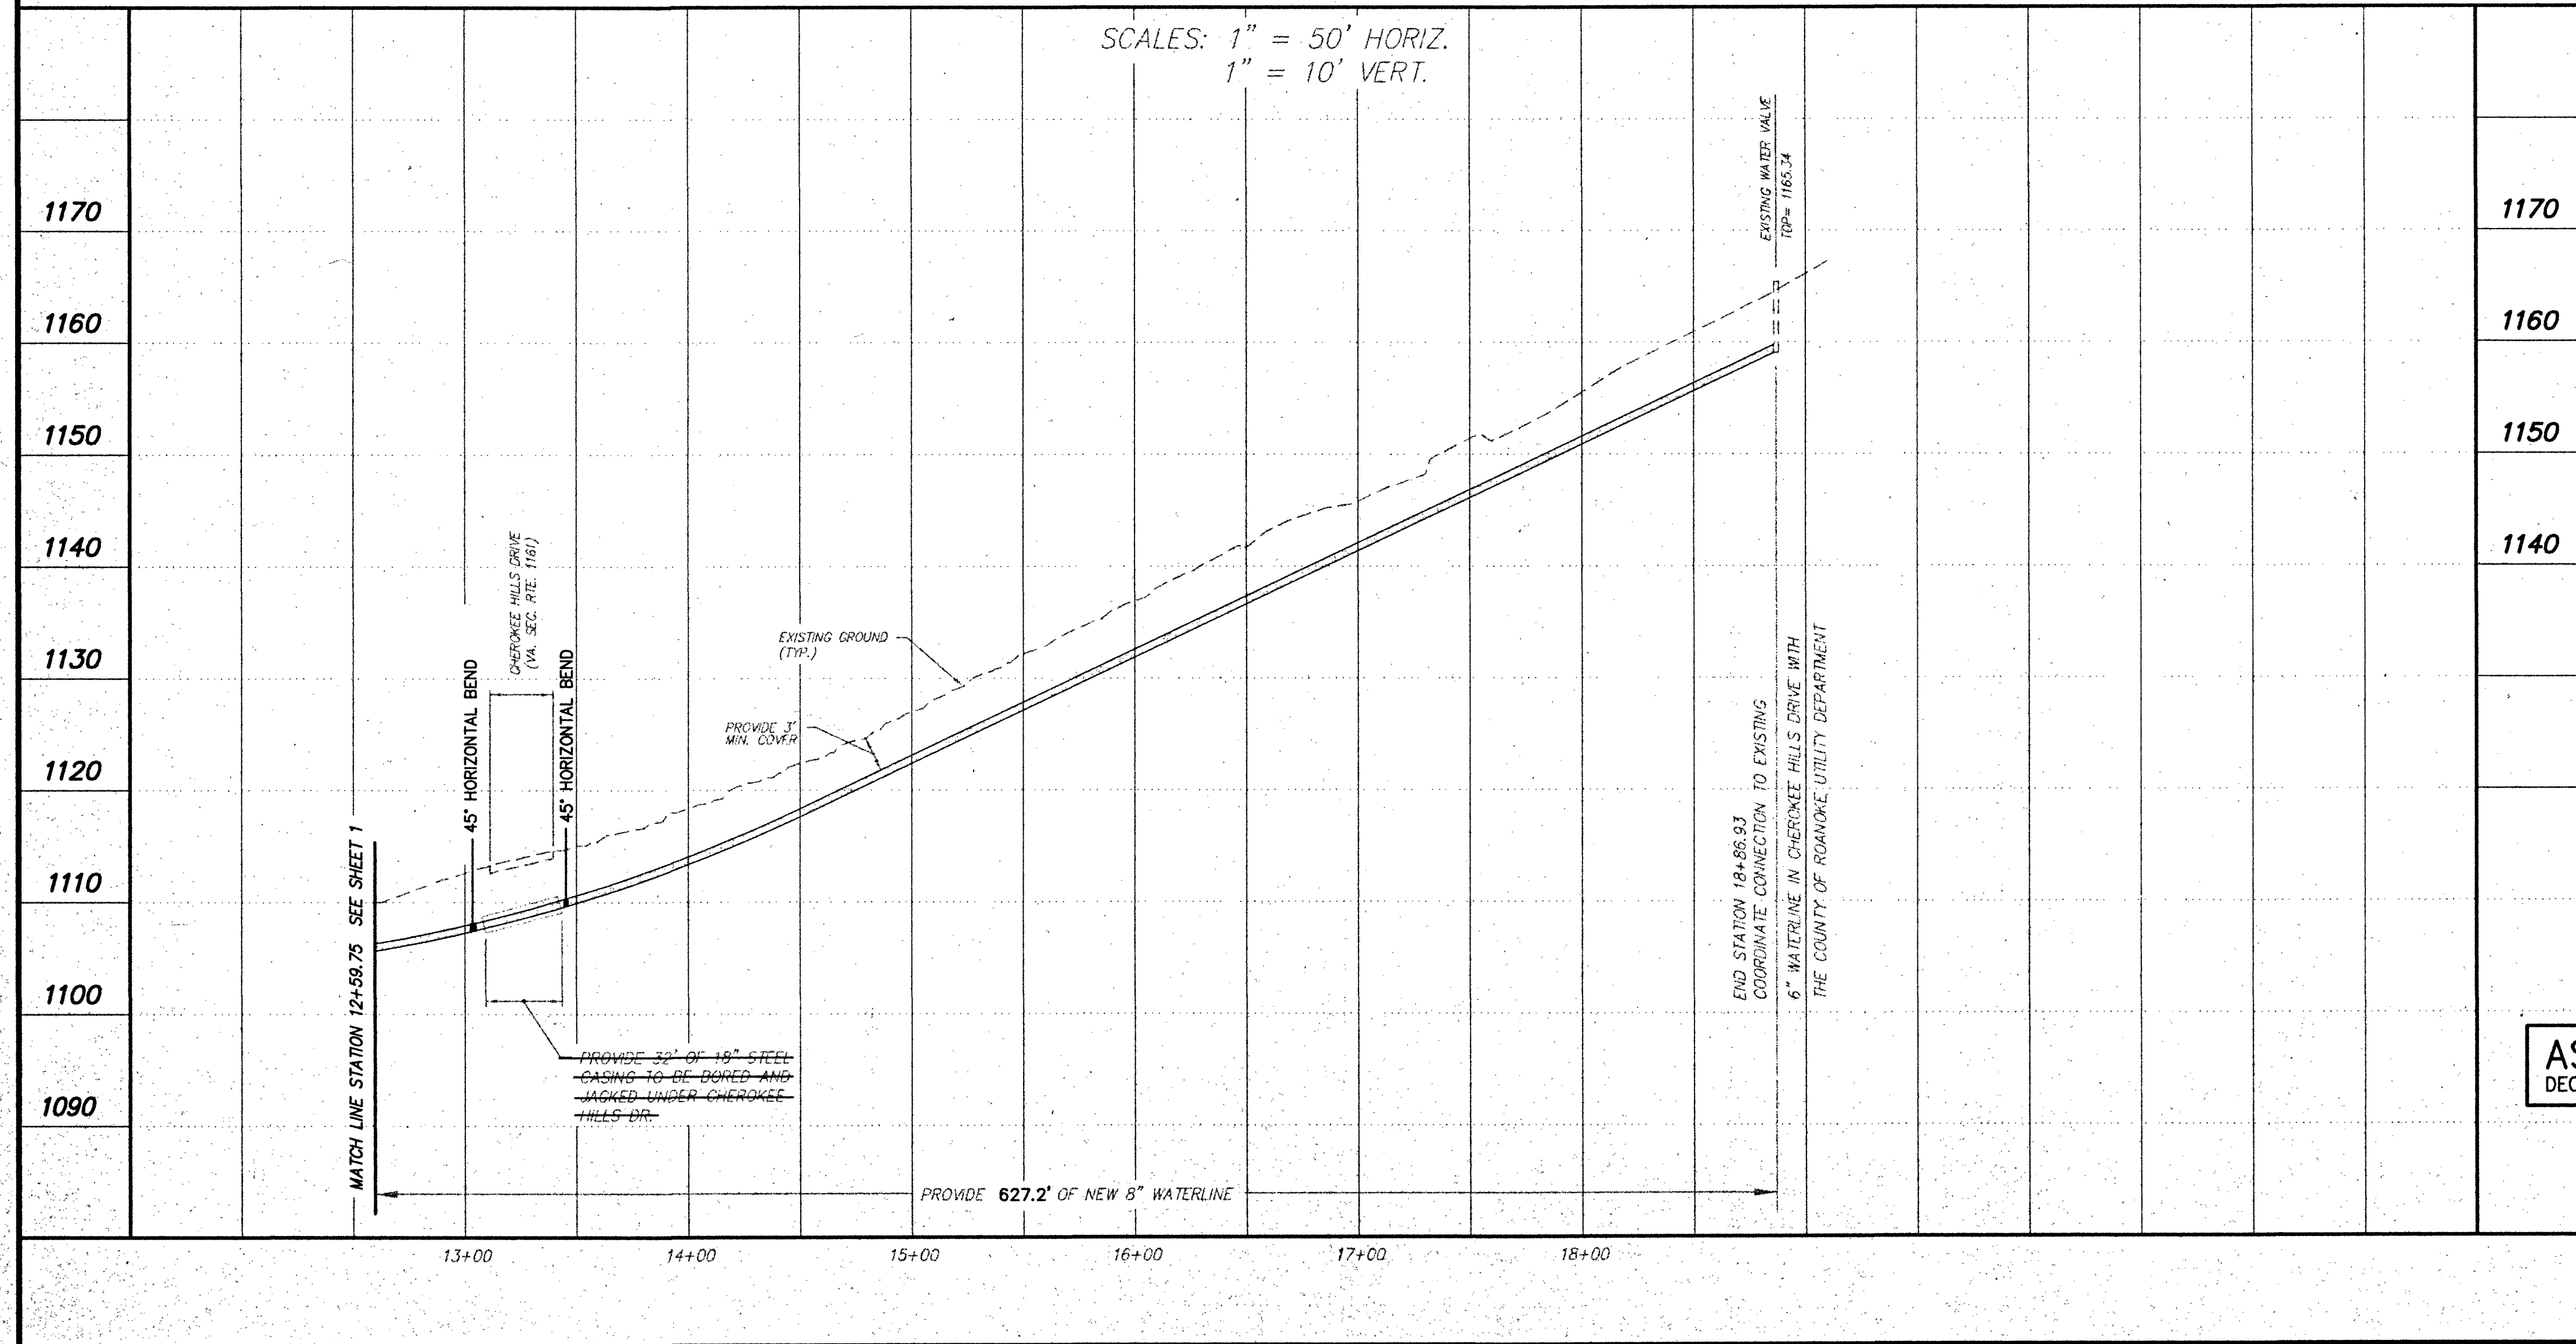
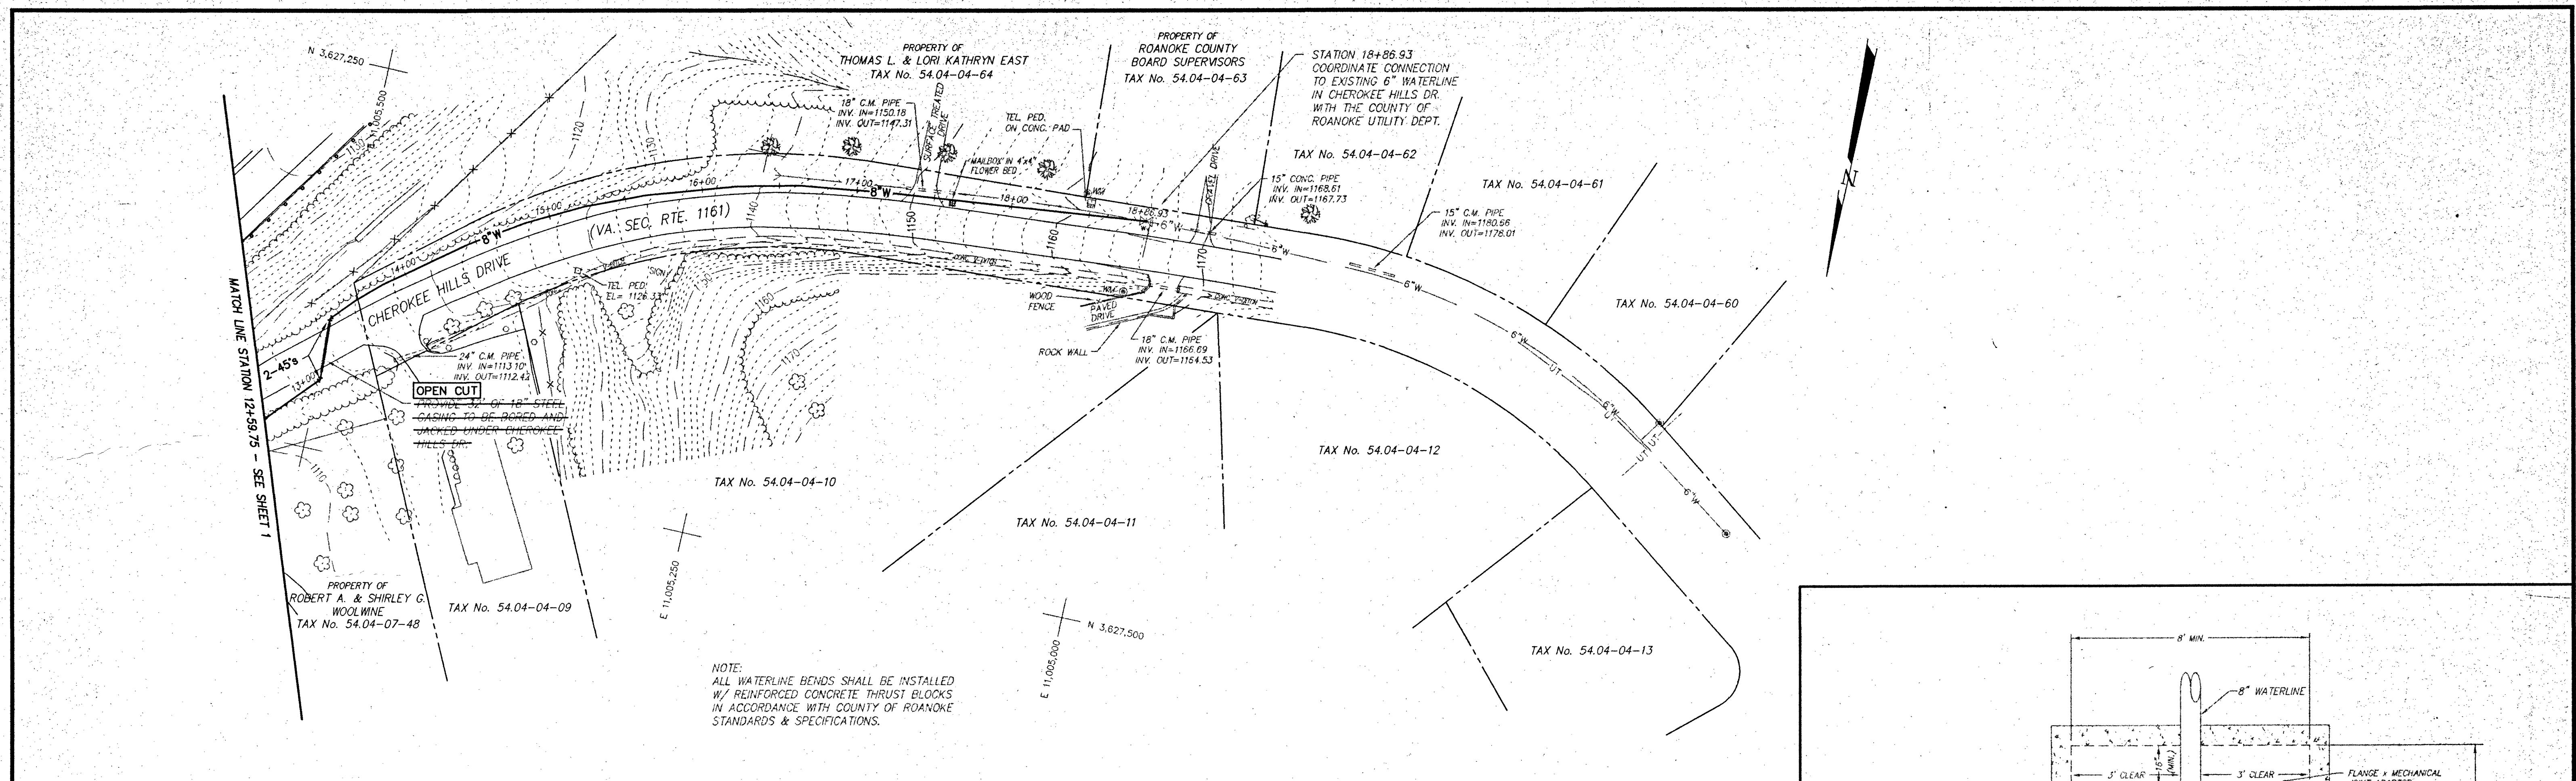


AS-BUILT
DECEMBER 2, 1996

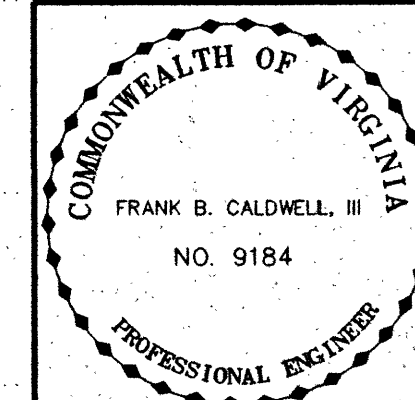

PLAN AND PROFILE
FOR
**NORTH LOOP WATER TRANSMISSION MAIN
PHASE 1**
FOR
THE COUNTY OF ROANOKE
SITUATE CATAWBA MAGISTERIAL DISTRICT
COUNTY OF ROANOKE, VIRGINIA
SCALE: AS SHOWN DATE: JANUARY 5, 1996

DESIGNED BY: C.L. WHITE
DRAWN BY: J.J. BERGLOFF
CHECKED BY: F.B. CALDWELL
W.O. #: 92-1077
N.B.:
TAX NO.:

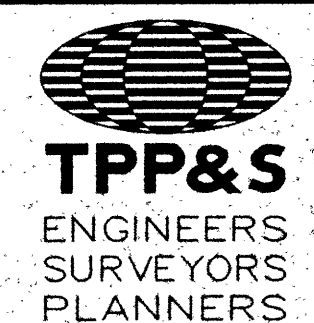

T. P. PARKER & SON
816 Boulevard
Post Office Box 39
Salem, Virginia 24153
Telephone: 540-387-1153
FAX: 540-389-5787