



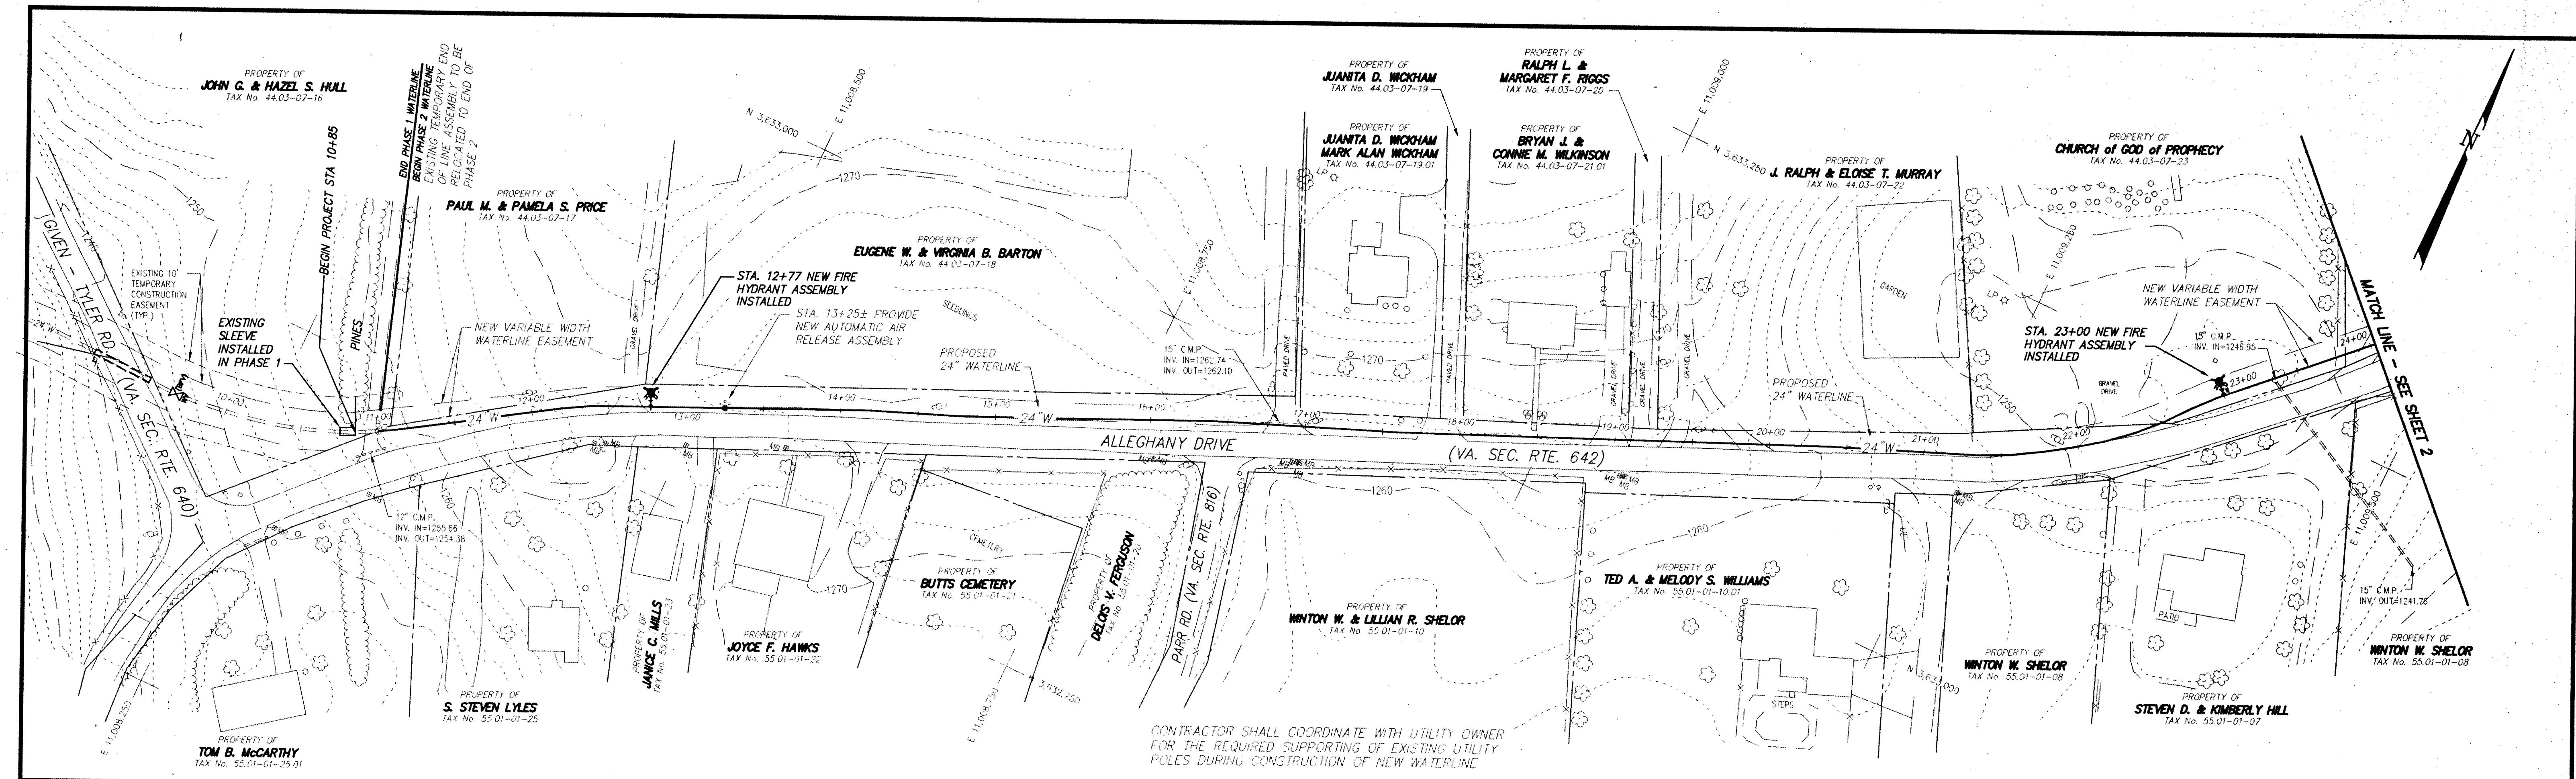


CONTRACTOR SHALL COORDINATE WITH UTILITY OWNER FOR THE REQUIRED SUPPORTING OF EXISTING UTILITY POLES DURING CONSTRUCTION OF NEW WATERLINE

SCALES: 1" = 50' HORIZONTAL
1" = 10' VERTICAL

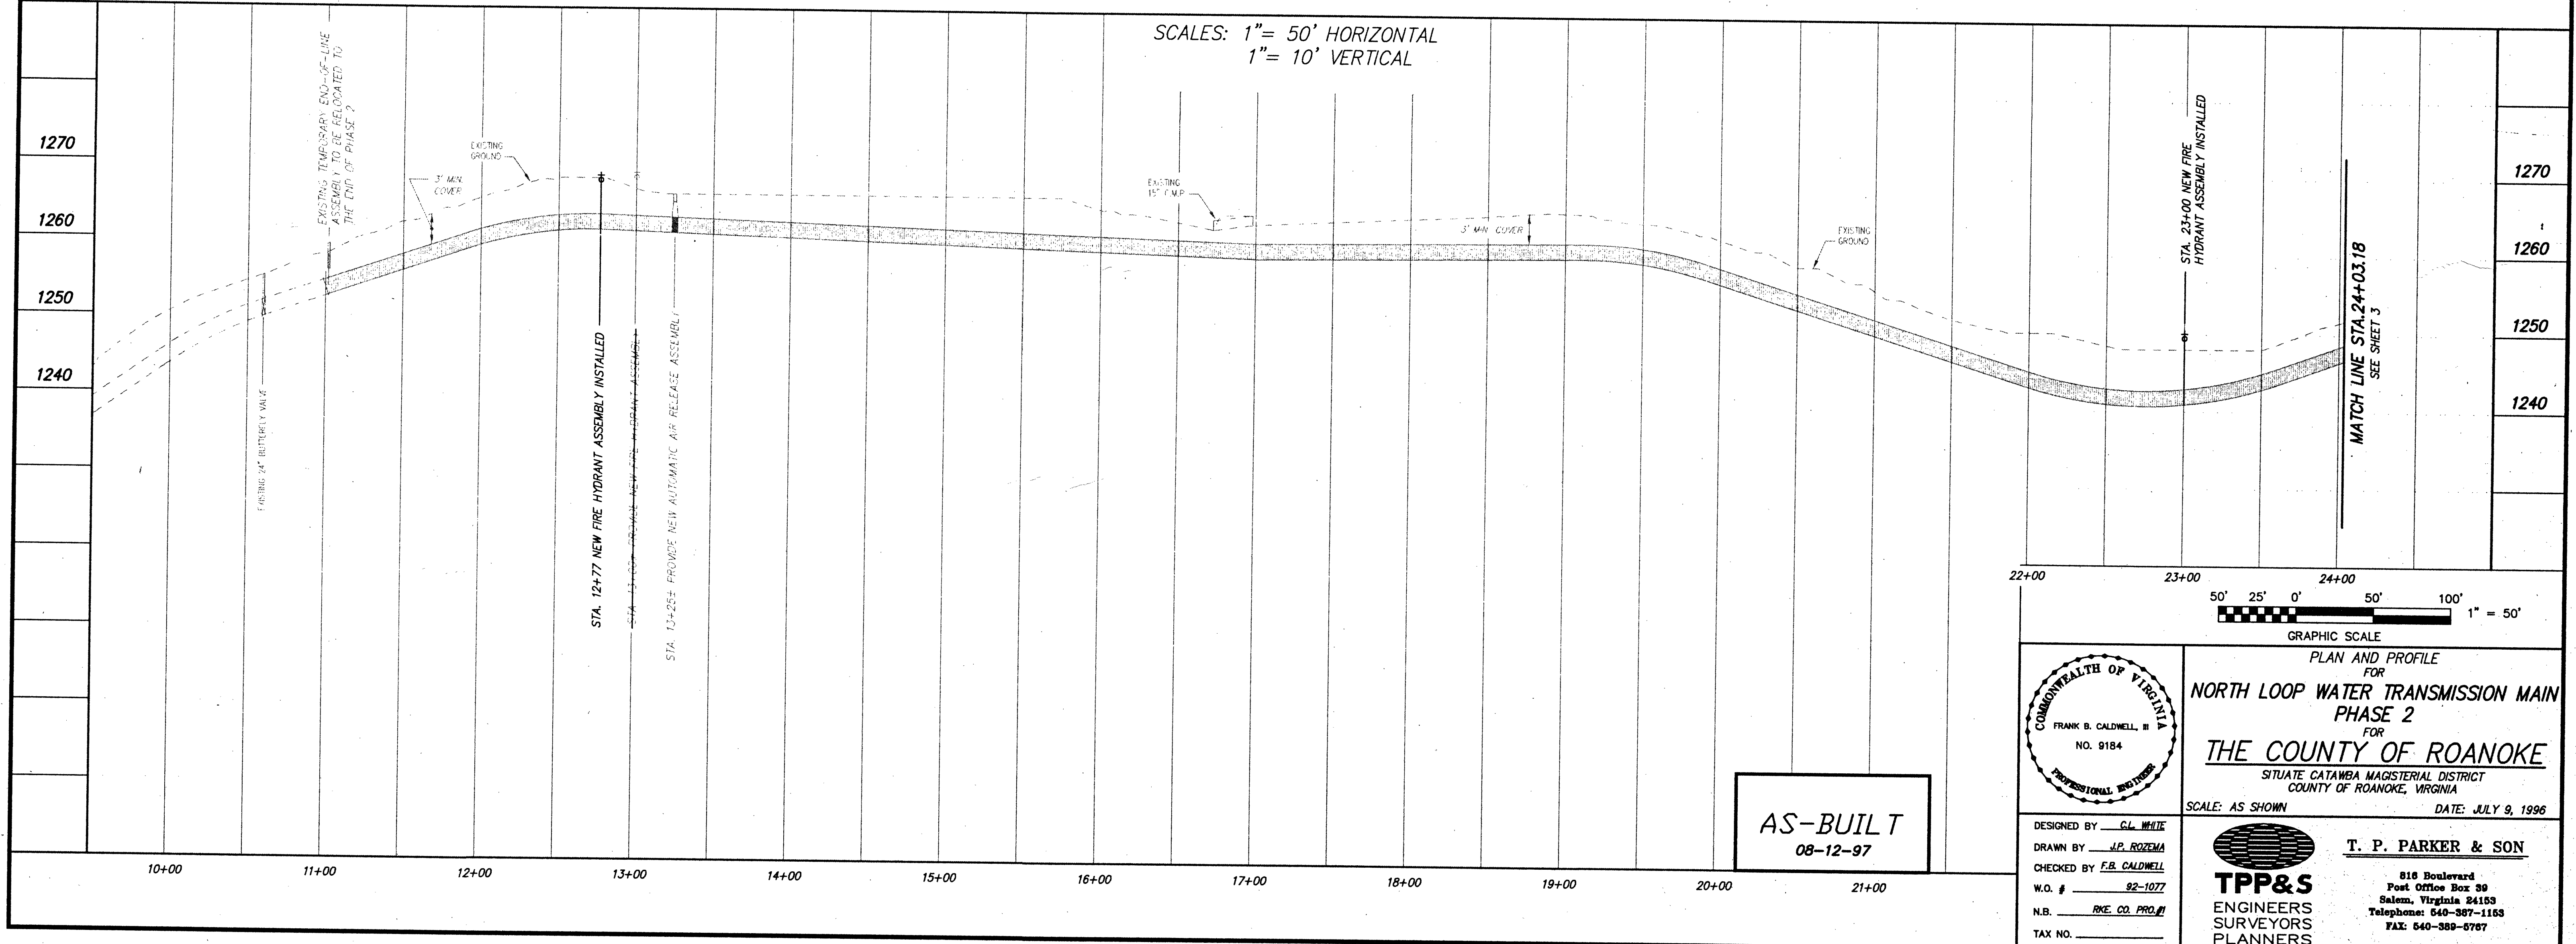

AS-BUILT
08-12-97

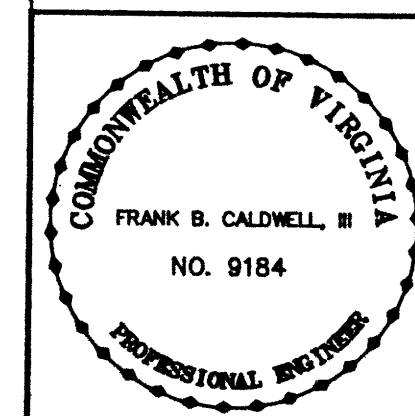

PLAN AND PROFILE FOR
**NORTH LOOP WATER TRANSMISSION MAIN
PHASE 2**
FOR
THE COUNTY OF ROANOKE
SITUATE CATAMBA MAGISTERIAL DISTRICT
COUNTY OF ROANOKE, VIRGINIA
SCALE: AS SHOWN DATE: JULY 9, 1996

DESIGNED BY: C.L. WHITE
DRAWN BY: J.P. ROZEMA
CHECKED BY: F.B. CALDWELL
W.O. #: 92-1077
N.B.: RKE CO. PROJ.
TAX NO.:

T. P. PARKER & SON
818 Boulevard
Post Office Box 39
Salem, Virginia 24153
Telephone: 540-387-1153
FAX: 540-389-5767
TPP&S
ENGINEERS
SURVEYORS
PLANNERS