
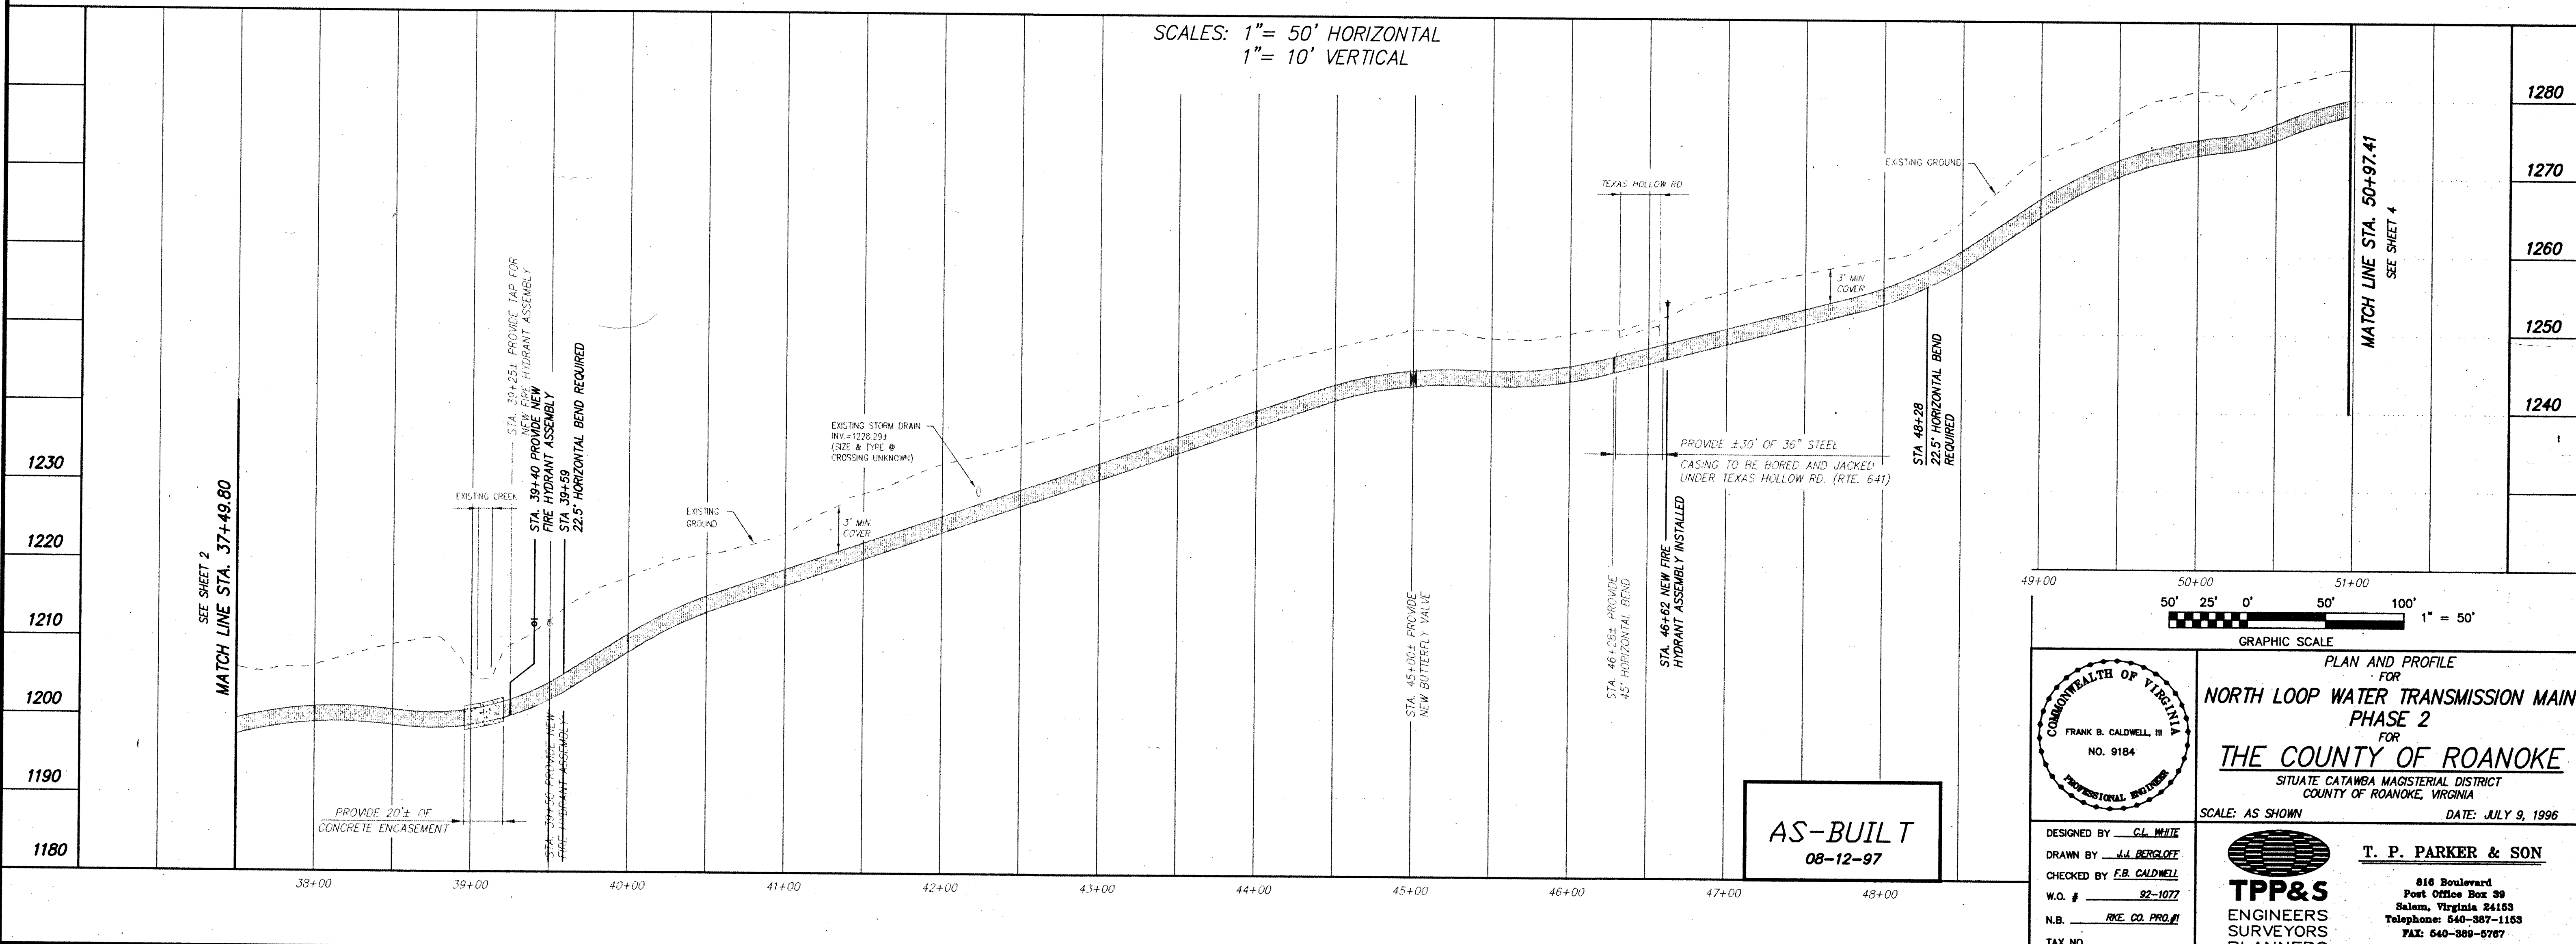


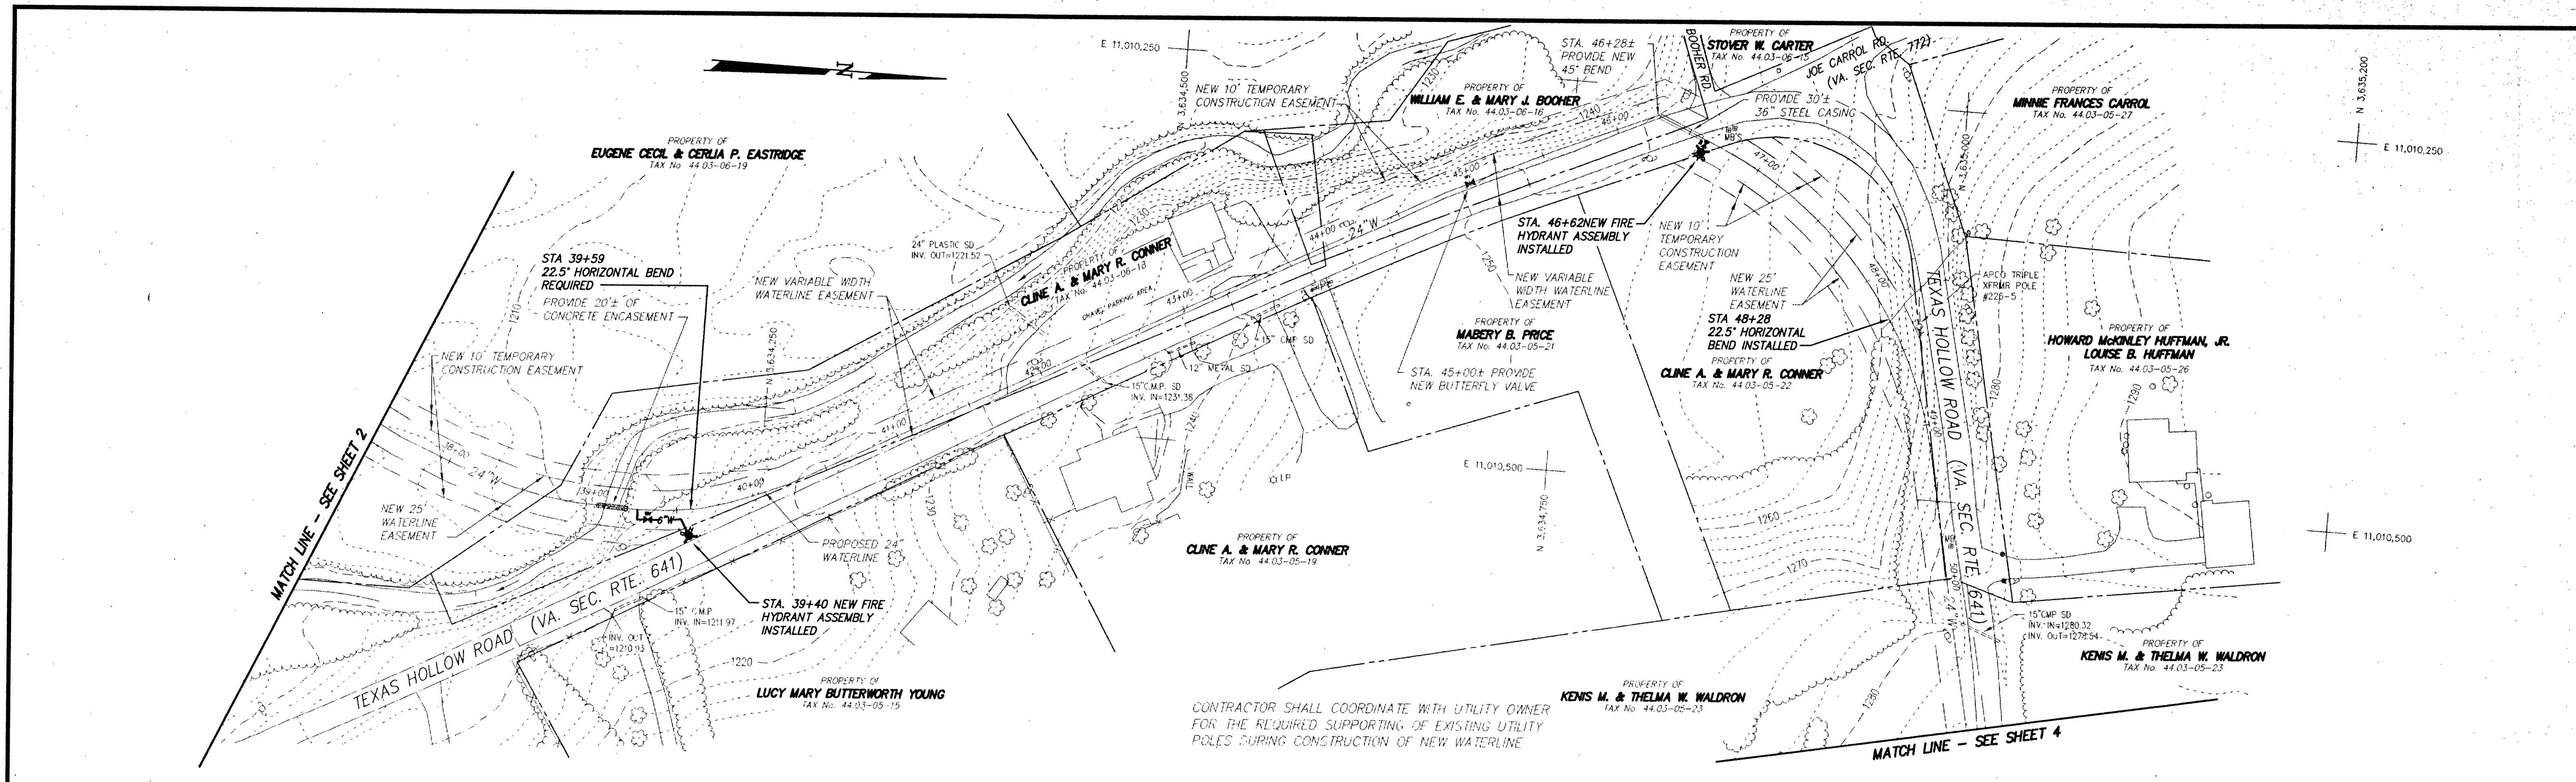

PLAN AND PROFILE
FOR
NORTH LOOP WATER TRANSMISSION MAIN
PHASE 2
FOR
THE COUNTY OF ROANOKE
SITUATE CATAWBA MAGISTERIAL DISTRICT
COUNTY OF ROANOKE, VIRGINIA
SCALE: AS SHOWN DATE: JULY 9, 1996

DESIGNED BY: C.L. WHITE
DRAWN BY: J.L. BERGLOFF
CHECKED BY: F.B. CALDWELL
W.O. #: 92-1077
N.B.: RKE CO. PROJ. #1
TAX NO.:

COMMONWEALTH OF VIRGINIA
FRANK B. CALDWELL, III
NO. 9184
PROFESSIONAL ENGINEER

T. P. PARKER & SON
816 Boulevard
Post Office Box 39
Salem, Virginia 24153
Telephone: 540-387-1153
FAX: 540-388-5787

TPP&S
ENGINEERS
SURVEYORS
PLANNERS