


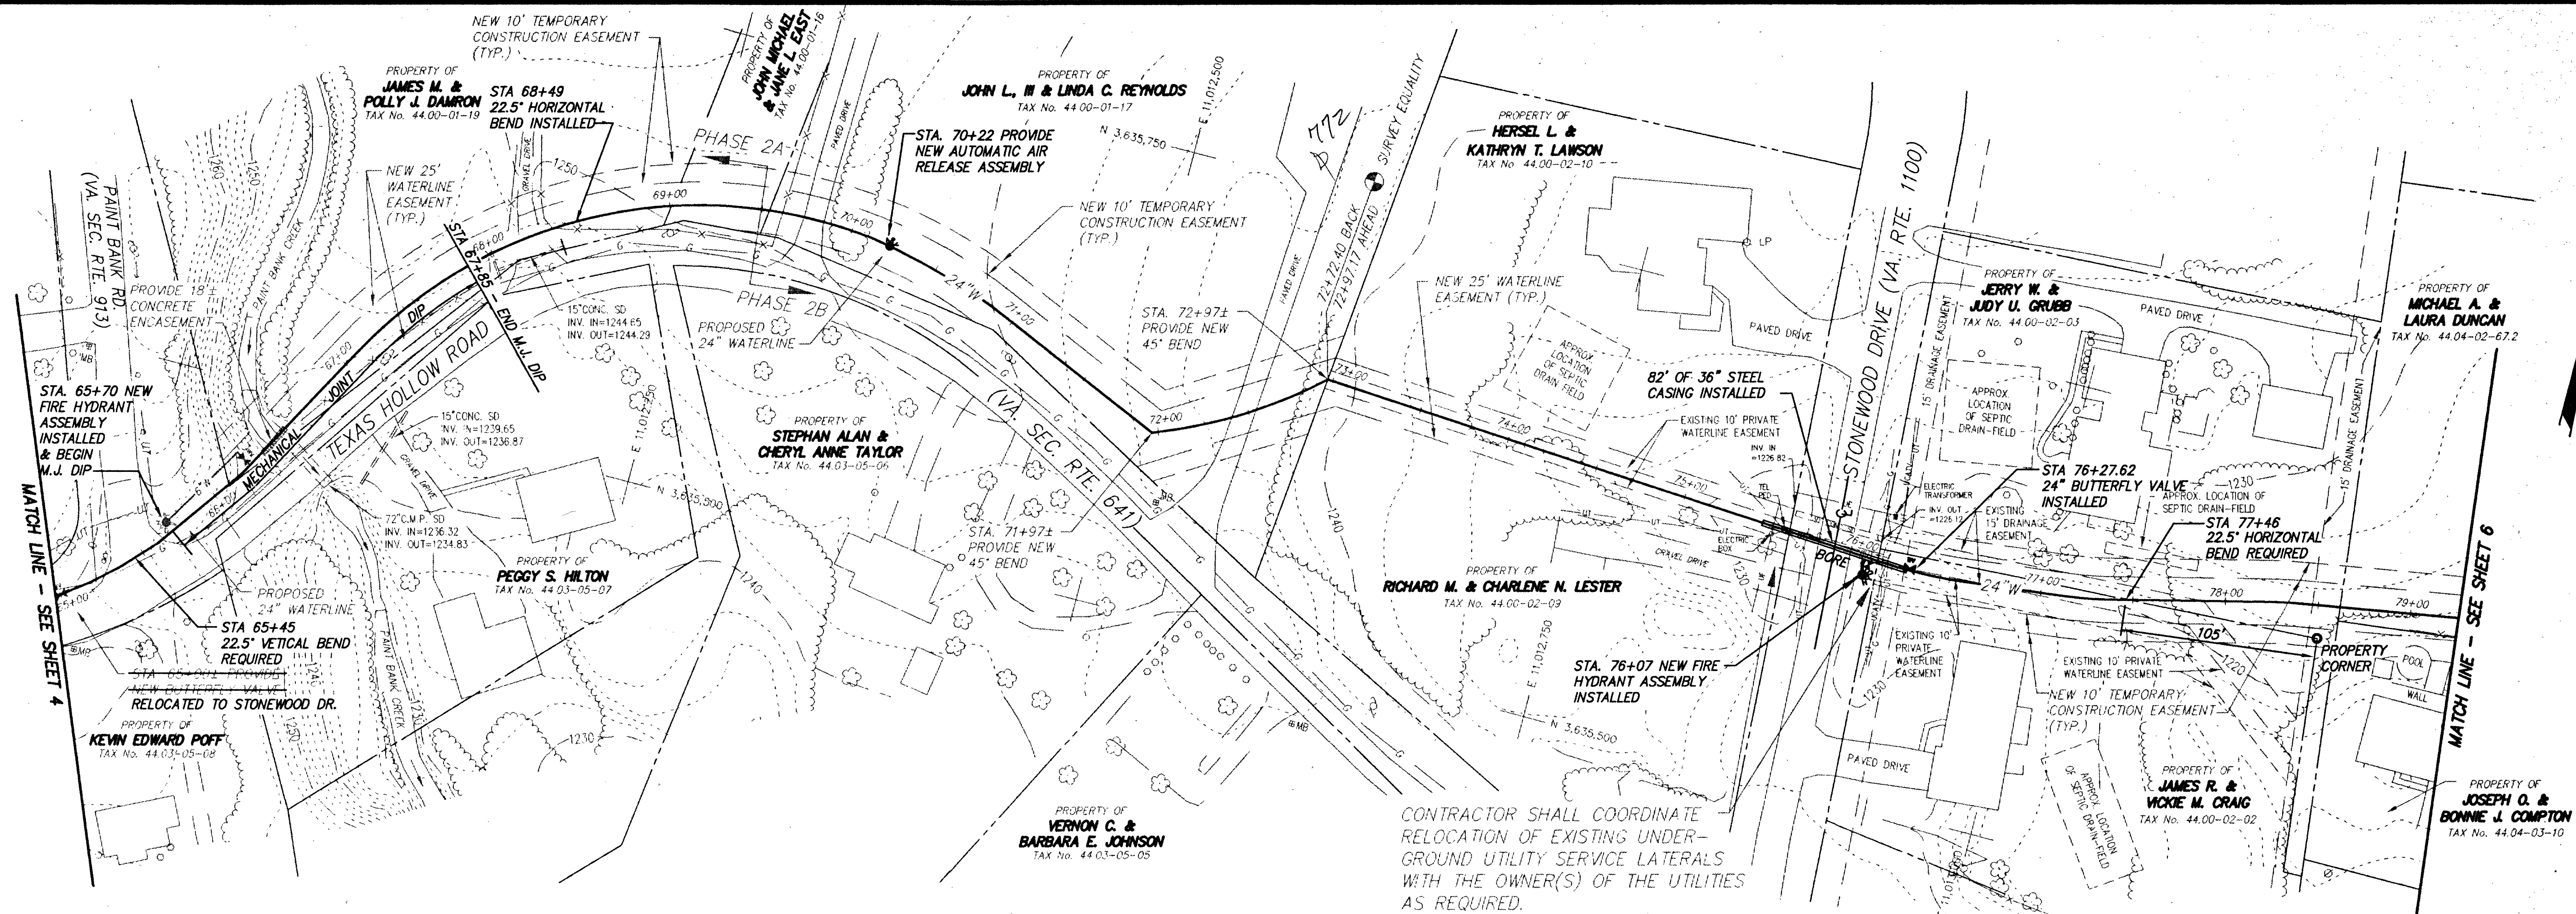


SCALES: 1" = 50' HORIZONTAL
1" = 10' VERTICAL


CONTRACTOR SHALL COORDINATE
RELOCATION OF EXISTING UNDER-
GROUND UTILITY SERVICE LATERALS
WITH THE OWNER(S) OF THE UTILITIES
AS REQUIRED.

SEE SHEET 4
MATCH LINE STA. 64+97.10

MATCH LINE STA. 79+26.24
SEE SHEET 6

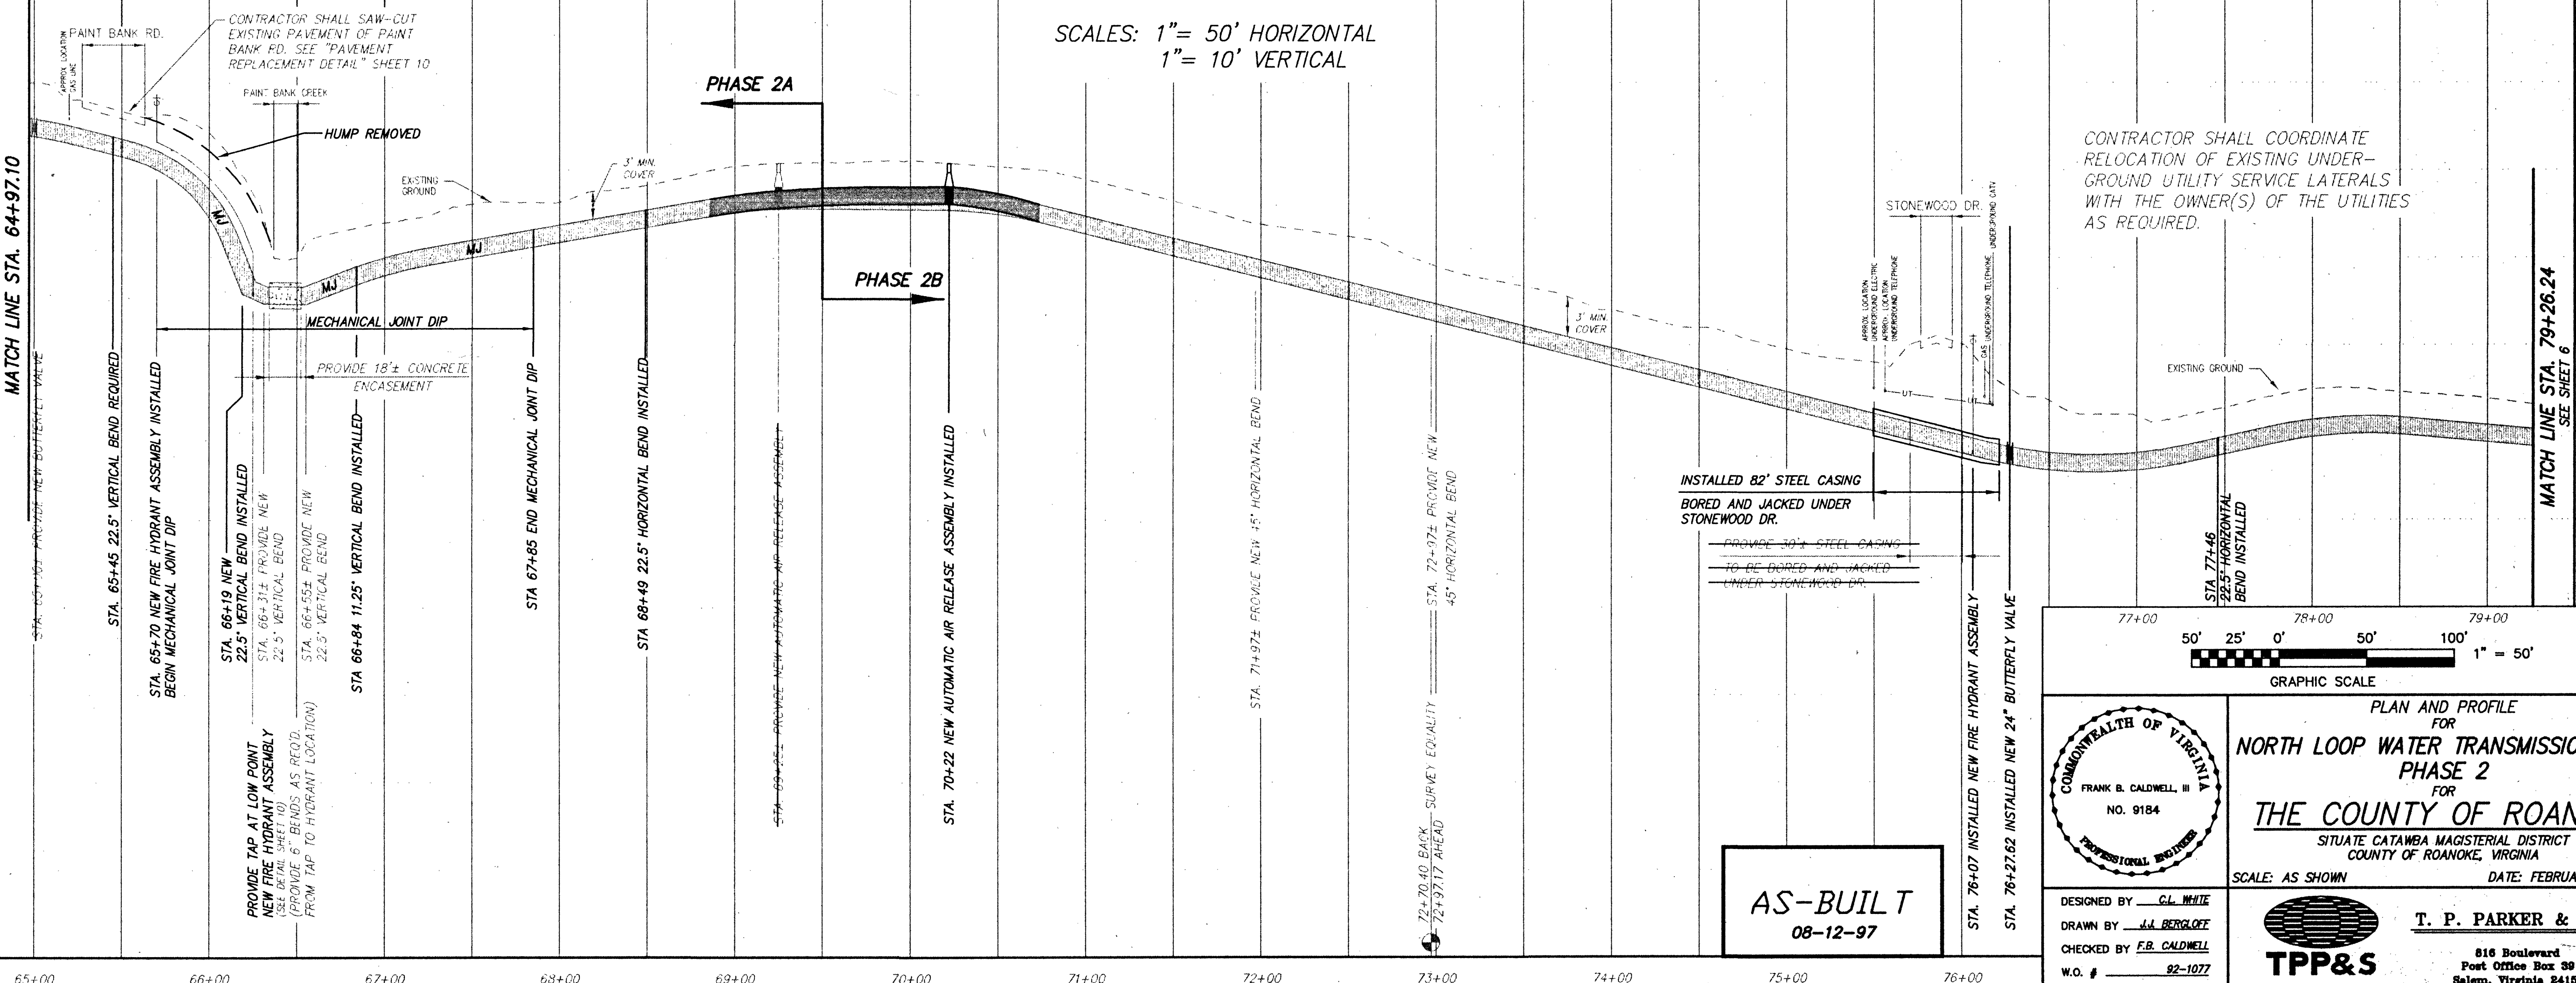

AS-BUILT
08-12-97

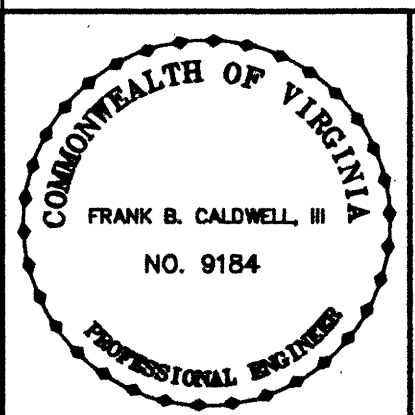

PLAN AND PROFILE
FOR
NORTH LOOP WATER TRANSMISSION MAIN
PHASE 2
FOR
THE COUNTY OF ROANOKE
SITUATE CATAMBA MAGISTERIAL DISTRICT
COUNTY OF ROANOKE, VIRGINIA
SCALE: AS SHOWN DATE: FEBRUARY 28, 1997

DESIGNED BY: C.L. WHITE
DRAWN BY: J.L. BERGLOFF
CHECKED BY: F.B. CALDWELL
W.O. #: 92-1077
N.B. RICE CO. PROJ. #1
TAX NO.:

T. P. PARKER & SON
816 Boulevard
Post Office Box 39
Salem, Virginia 24159
Telephone: 540-387-1153
FAX: 540-389-8787
TPP&S
ENGINEERS,
SURVEYORS
PLANNERS

REVISED: 08/27/96 WL ALIGNMENT BETWEEN STONEWOOD DR. & ROB KNOB RD. BY: JWB