


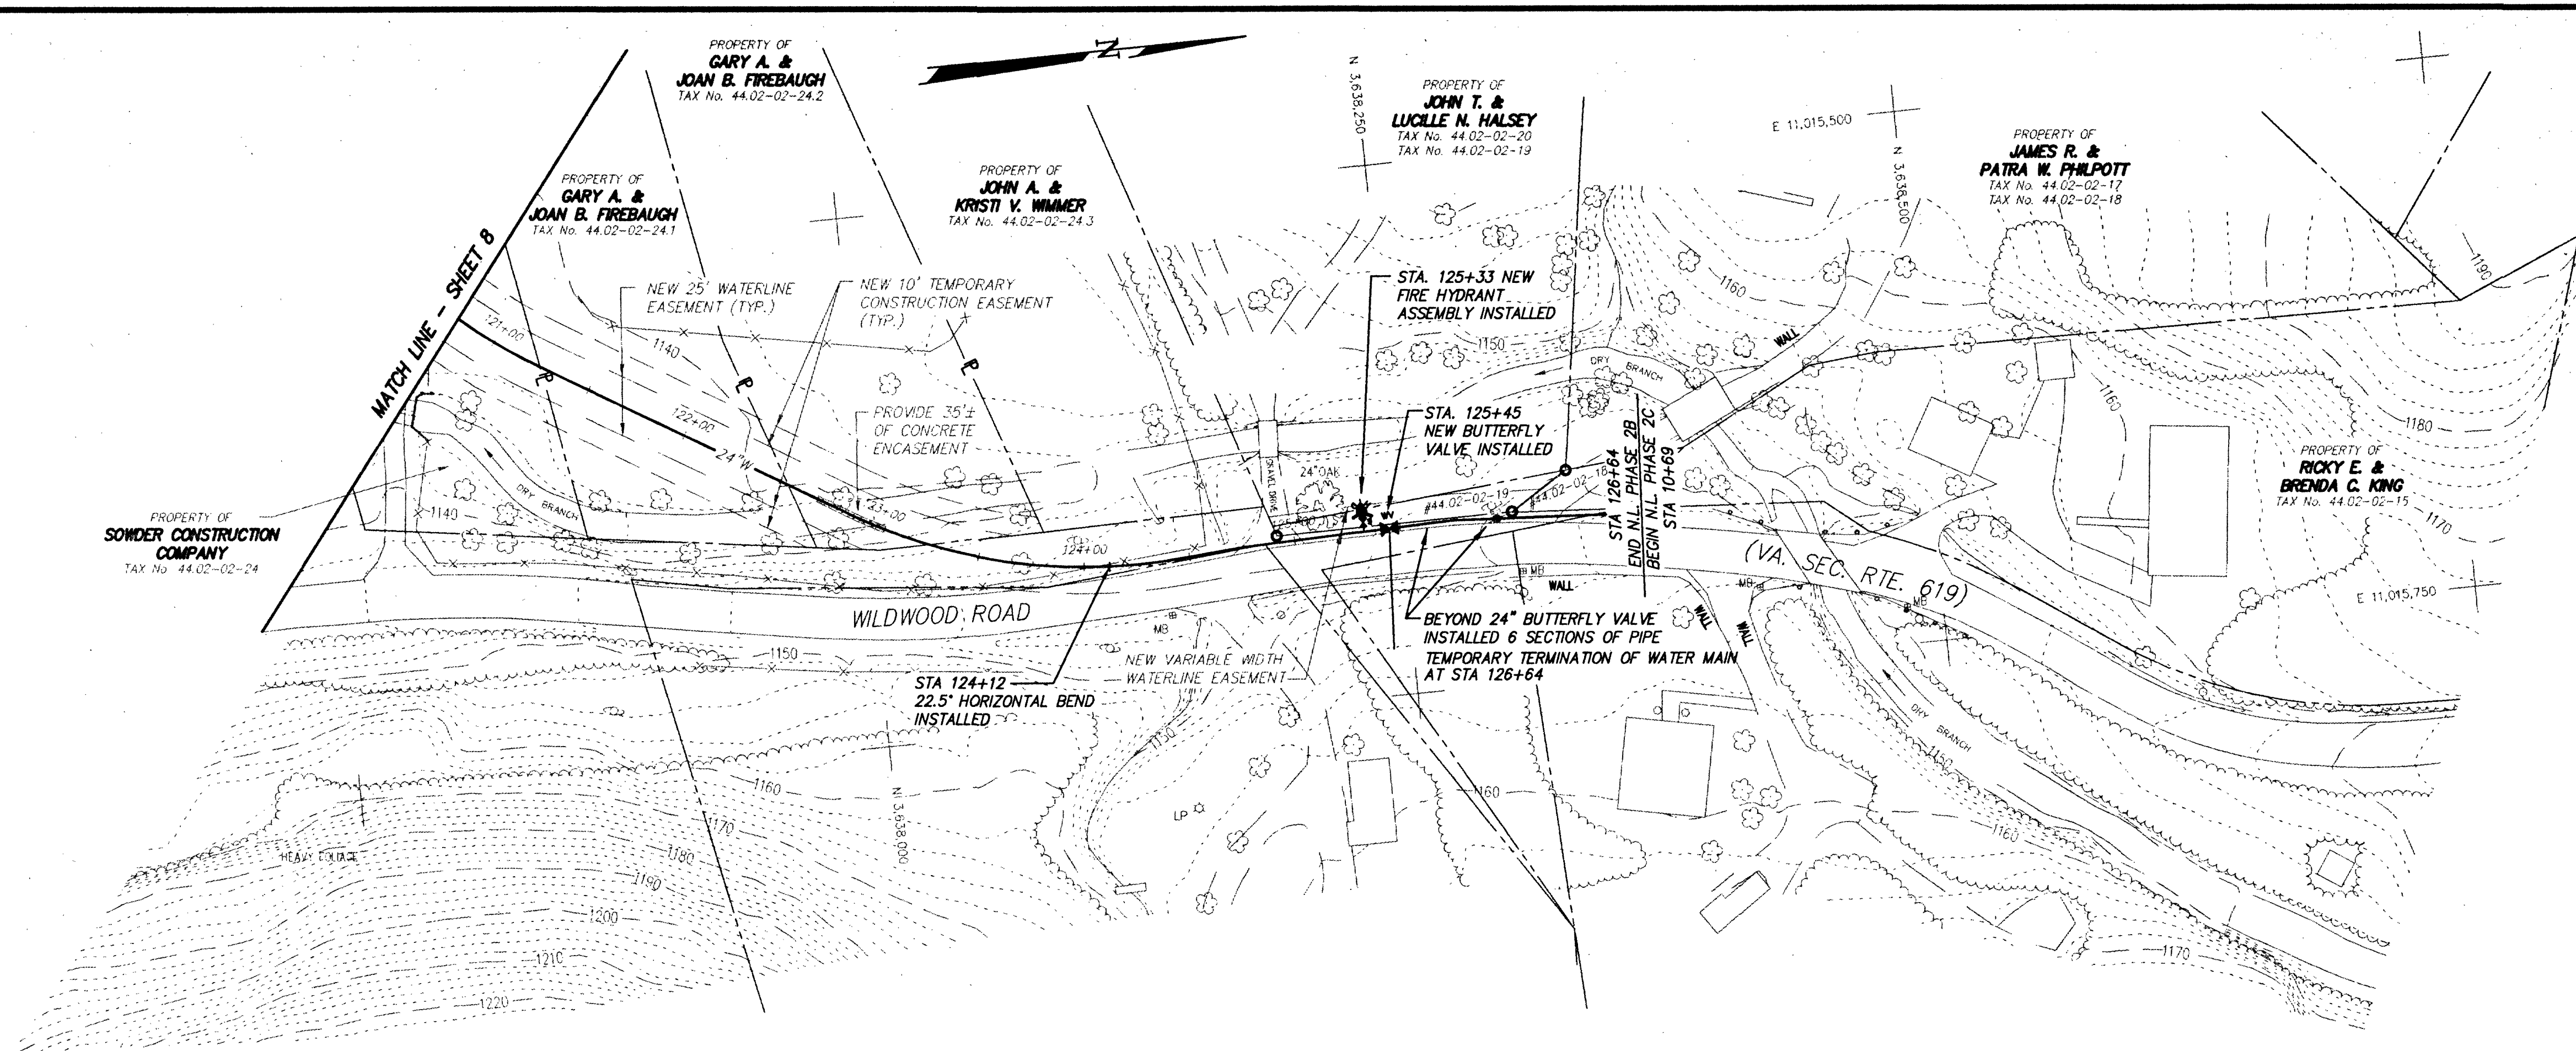


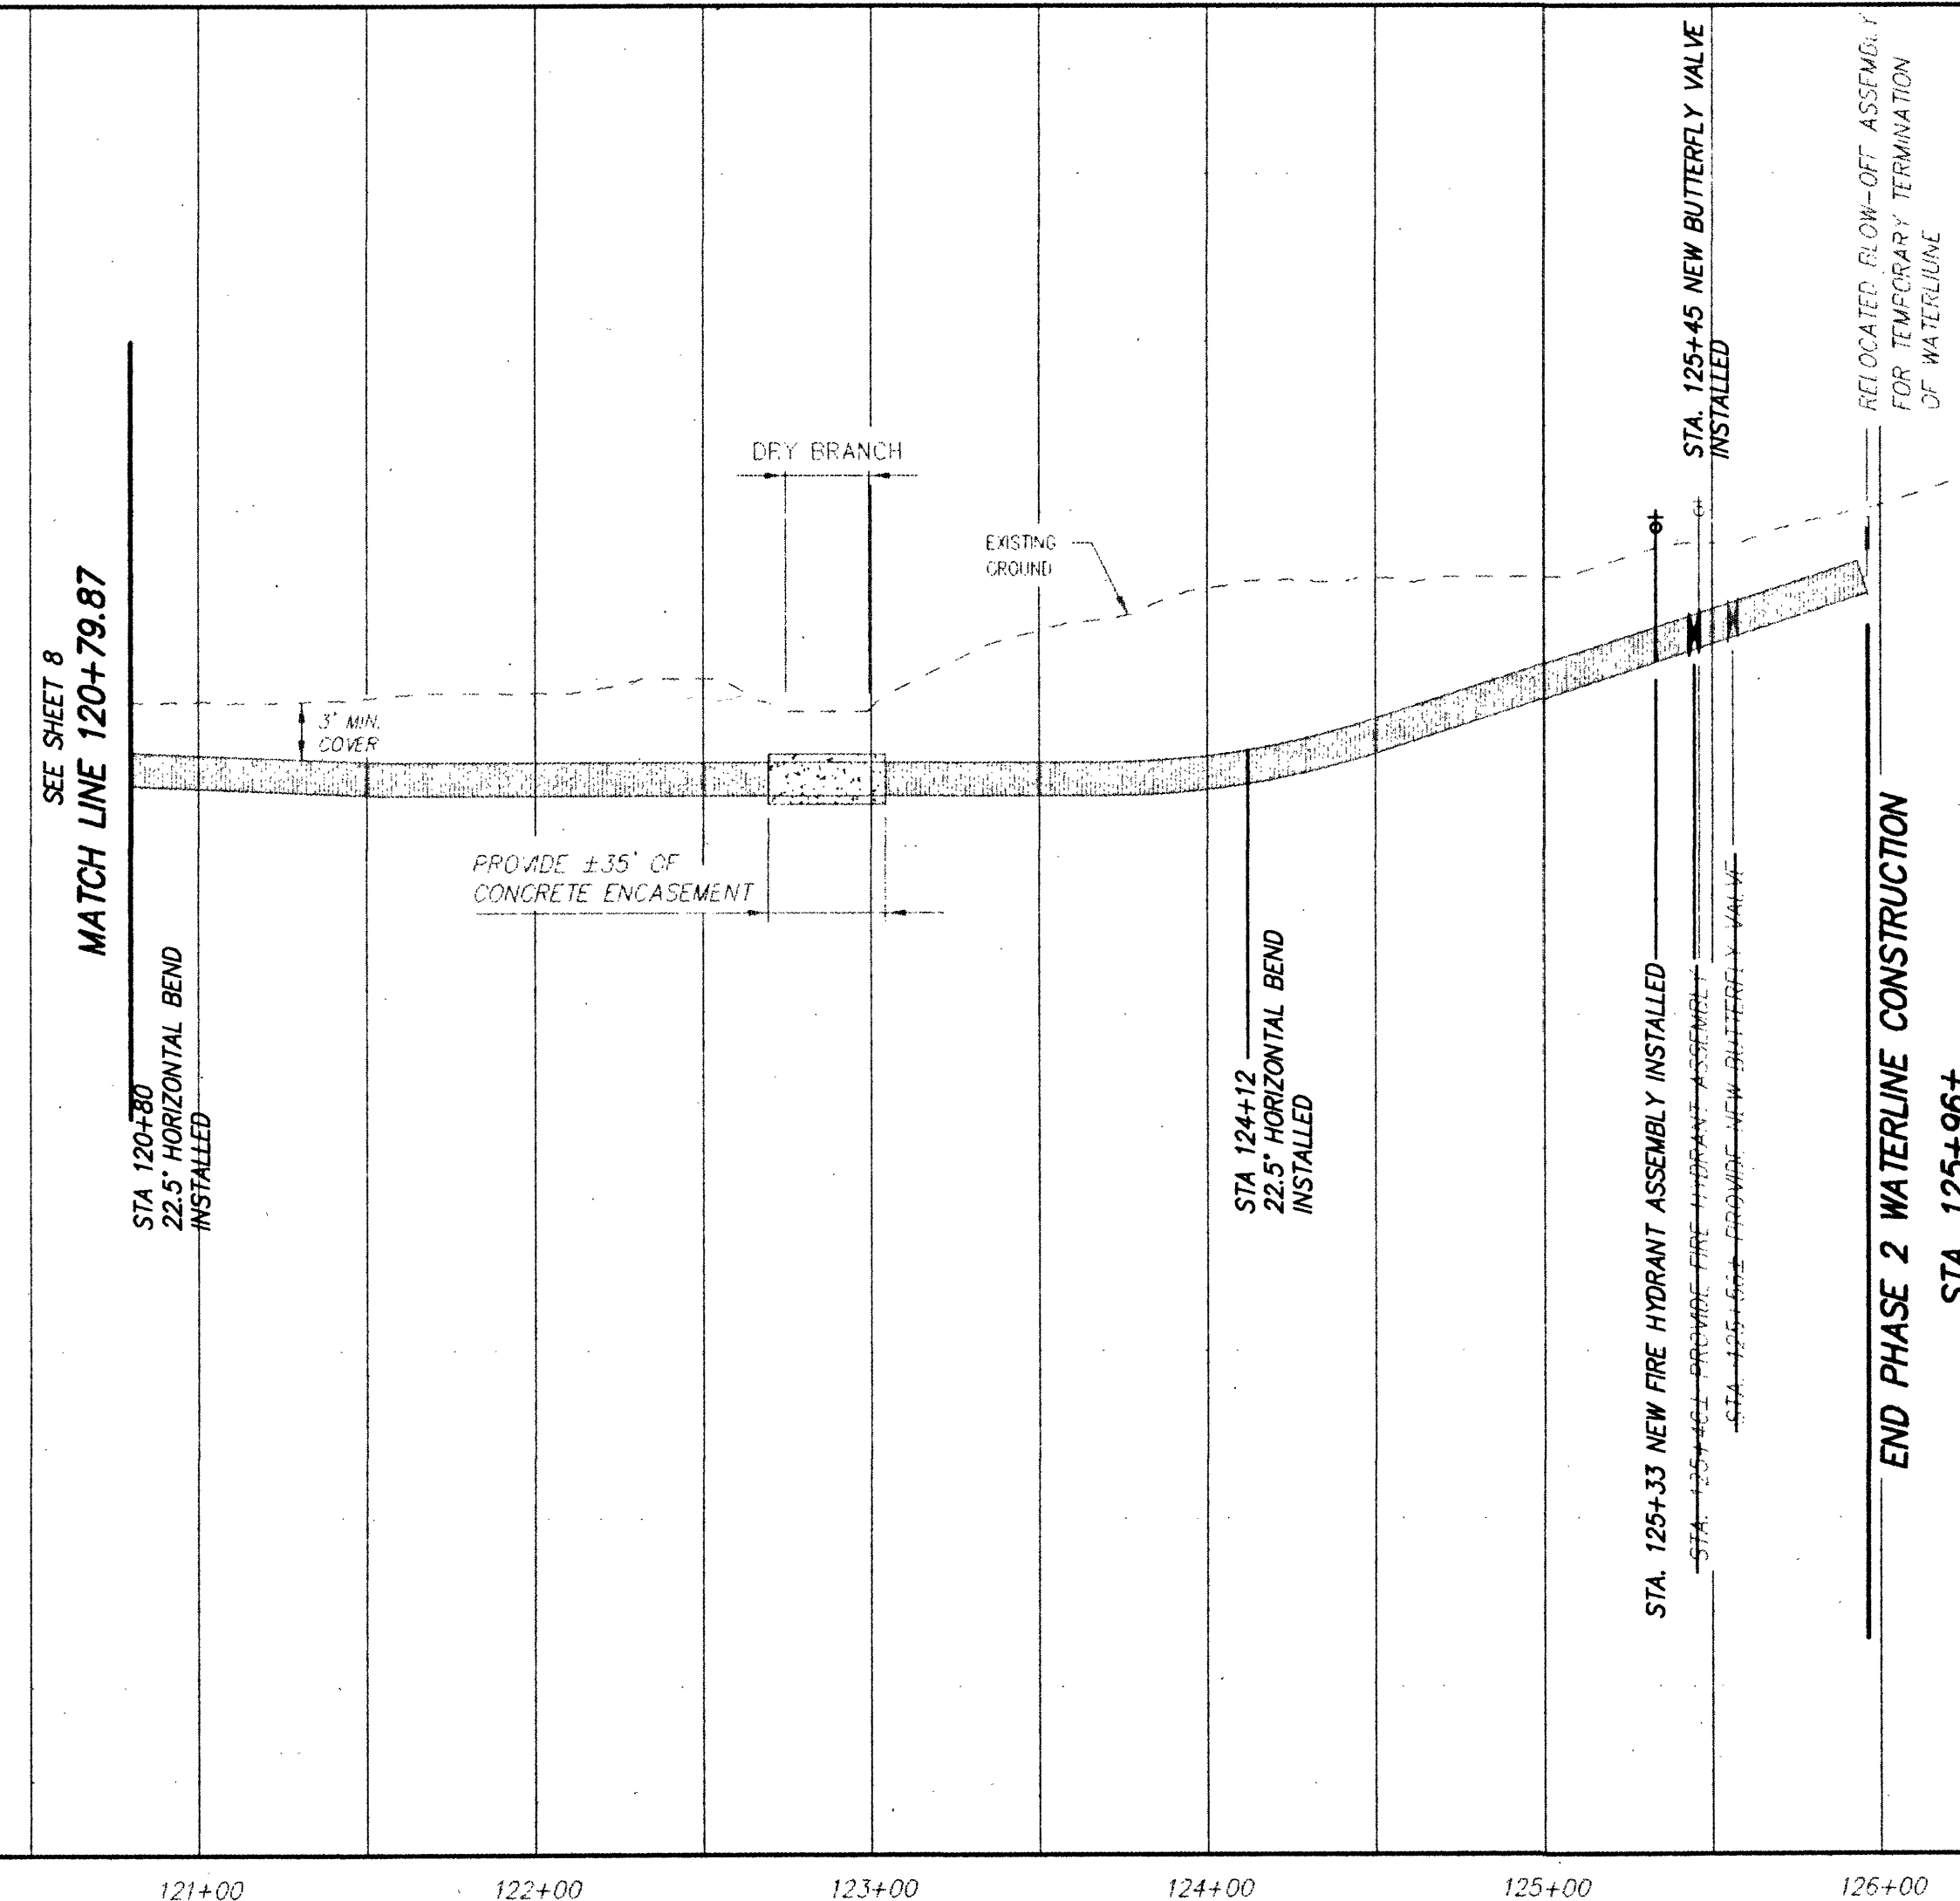

SCALES: 1" = 50' HORIZONTAL
1" = 10' VERTICAL

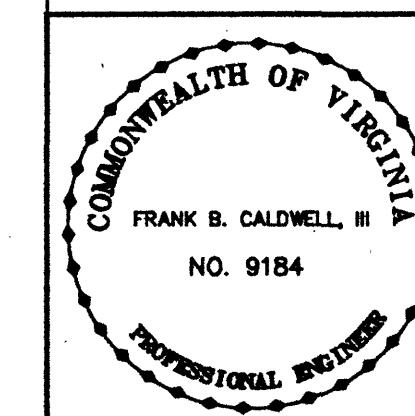


AS-BUILT
08-12-97

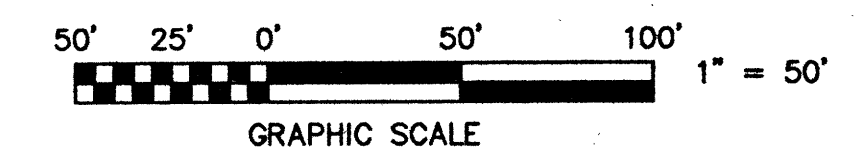

PLAN AND PROFILE
FOR
NORTH LOOP WATER TRANSMISSION MAIN
PHASE 2
FOR
THE COUNTY OF ROANOKE
SITUATE CATAMBA MAGISTERIAL DISTRICT
COUNTY OF ROANOKE, VIRGINIA
SCALE: AS SHOWN DATE: FEBRUARY 28, 1997

DESIGNED BY C.L. WHITE
DRAWN BY J.A. BERGLOFF
CHECKED BY F.B. CALDWELL
W.O. # 92-1077
N.B. RKE CO. PROJ.#1
TAX NO.

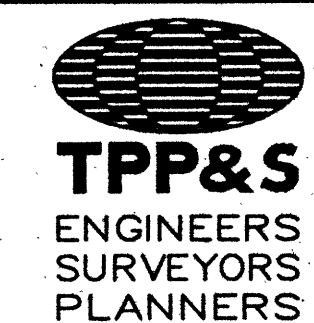

T. P. PARKER & SON
816 Boulevard
Post Office Box 90
Salem, Virginia 24163
Telephone: 540-387-1153
FAX: 540-389-5767