

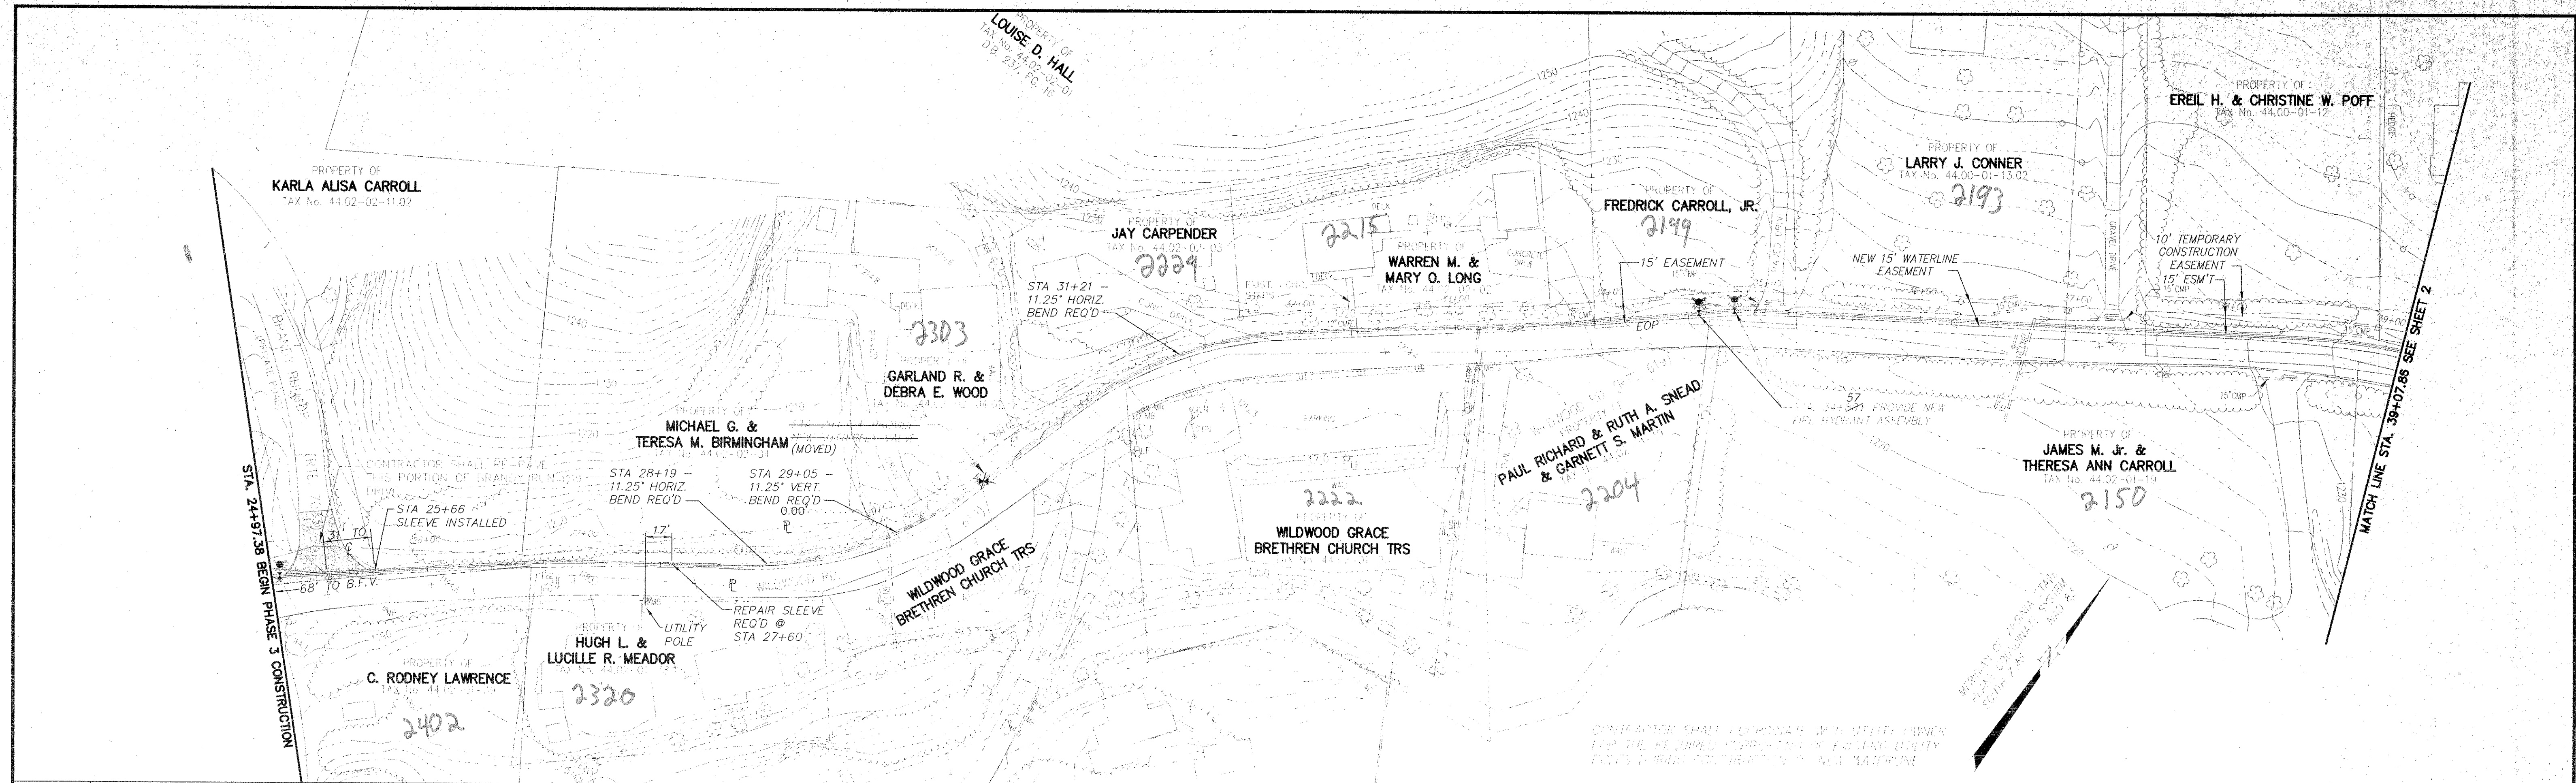


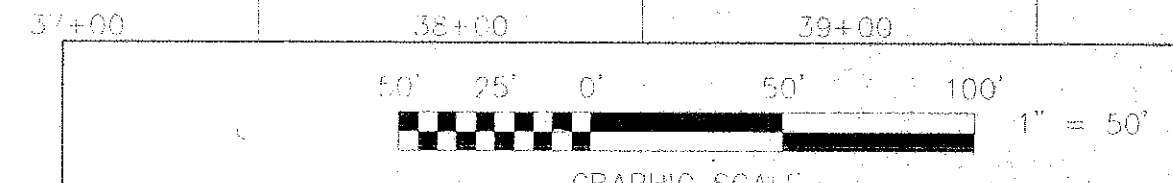

SCALES: 1" = 50' HORIZ.
1" = 10' VERT.

AS BUILT
OCTOBER 9, 1998
WATERMAIN ONLY

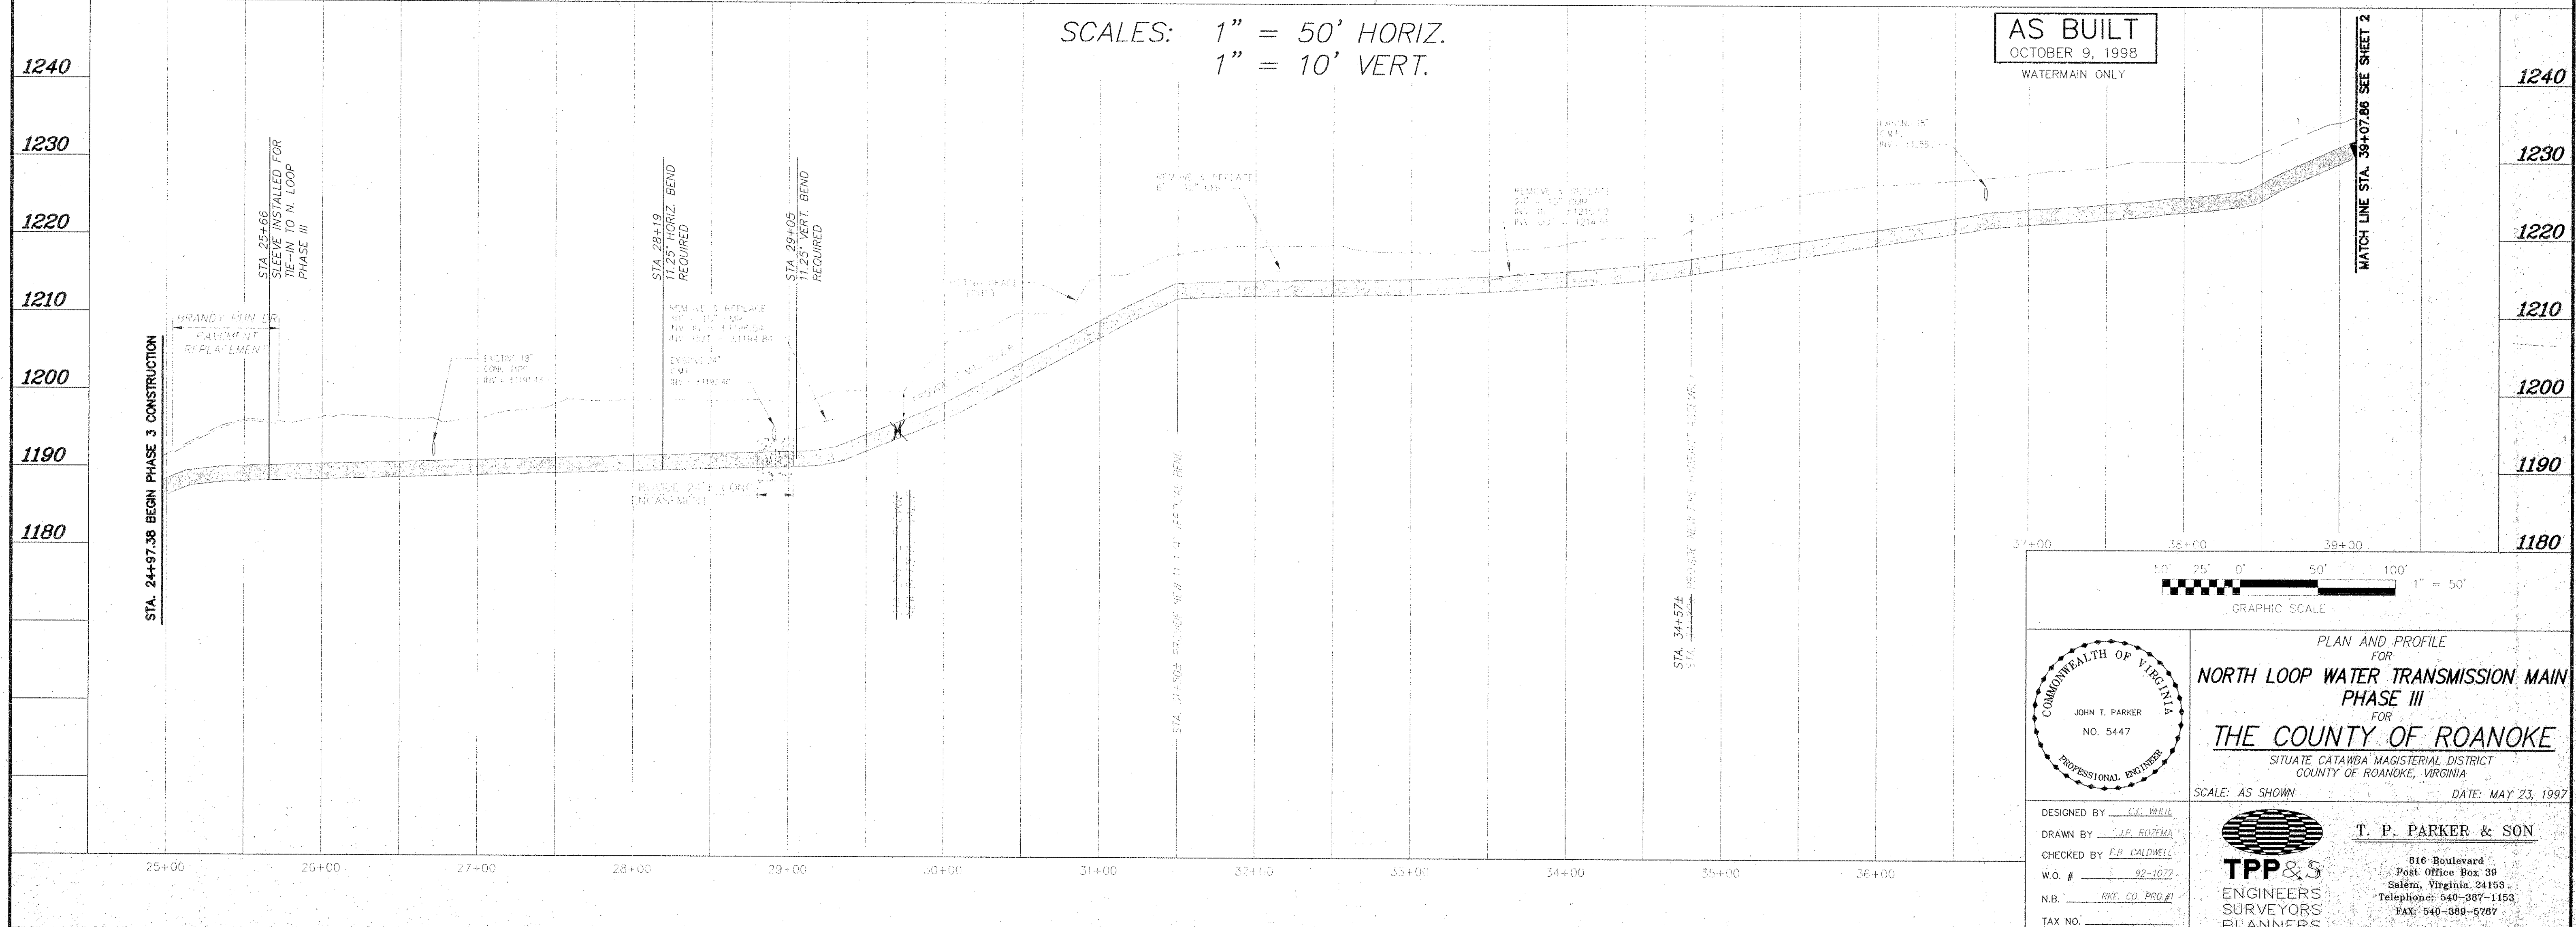

COMMONWEALTH OF VIRGINIA
JOHN T. PARKER
NO. 5447
PROFESSIONAL ENGINEER

PLAN AND PROFILE
FOR
**NORTH LOOP WATER TRANSMISSION MAIN
PHASE III**
FOR
THE COUNTY OF ROANOKE
SITUATE CATAWBA MAGISTERIAL DISTRICT
COUNTY OF ROANOKE, VIRGINIA

SCALE: AS SHOWN DATE: MAY 23, 1997

T. P. PARKER & SON
816 Boulevard
Post Office Box 39
Salem, Virginia 24153
Telephone: 540-387-1153
FAX: 540-388-5787

DESIGNED BY: C.L. WHITE
DRAWN BY: J.P. ROTZEM
CHECKED BY: F.H. CALDWELL
W.O. #: 92-1077
N.B. RPT. CO. PROJ. #
TAX NO.:

TPP&S
ENGINEERS
SURVEYORS
PLANNERS