
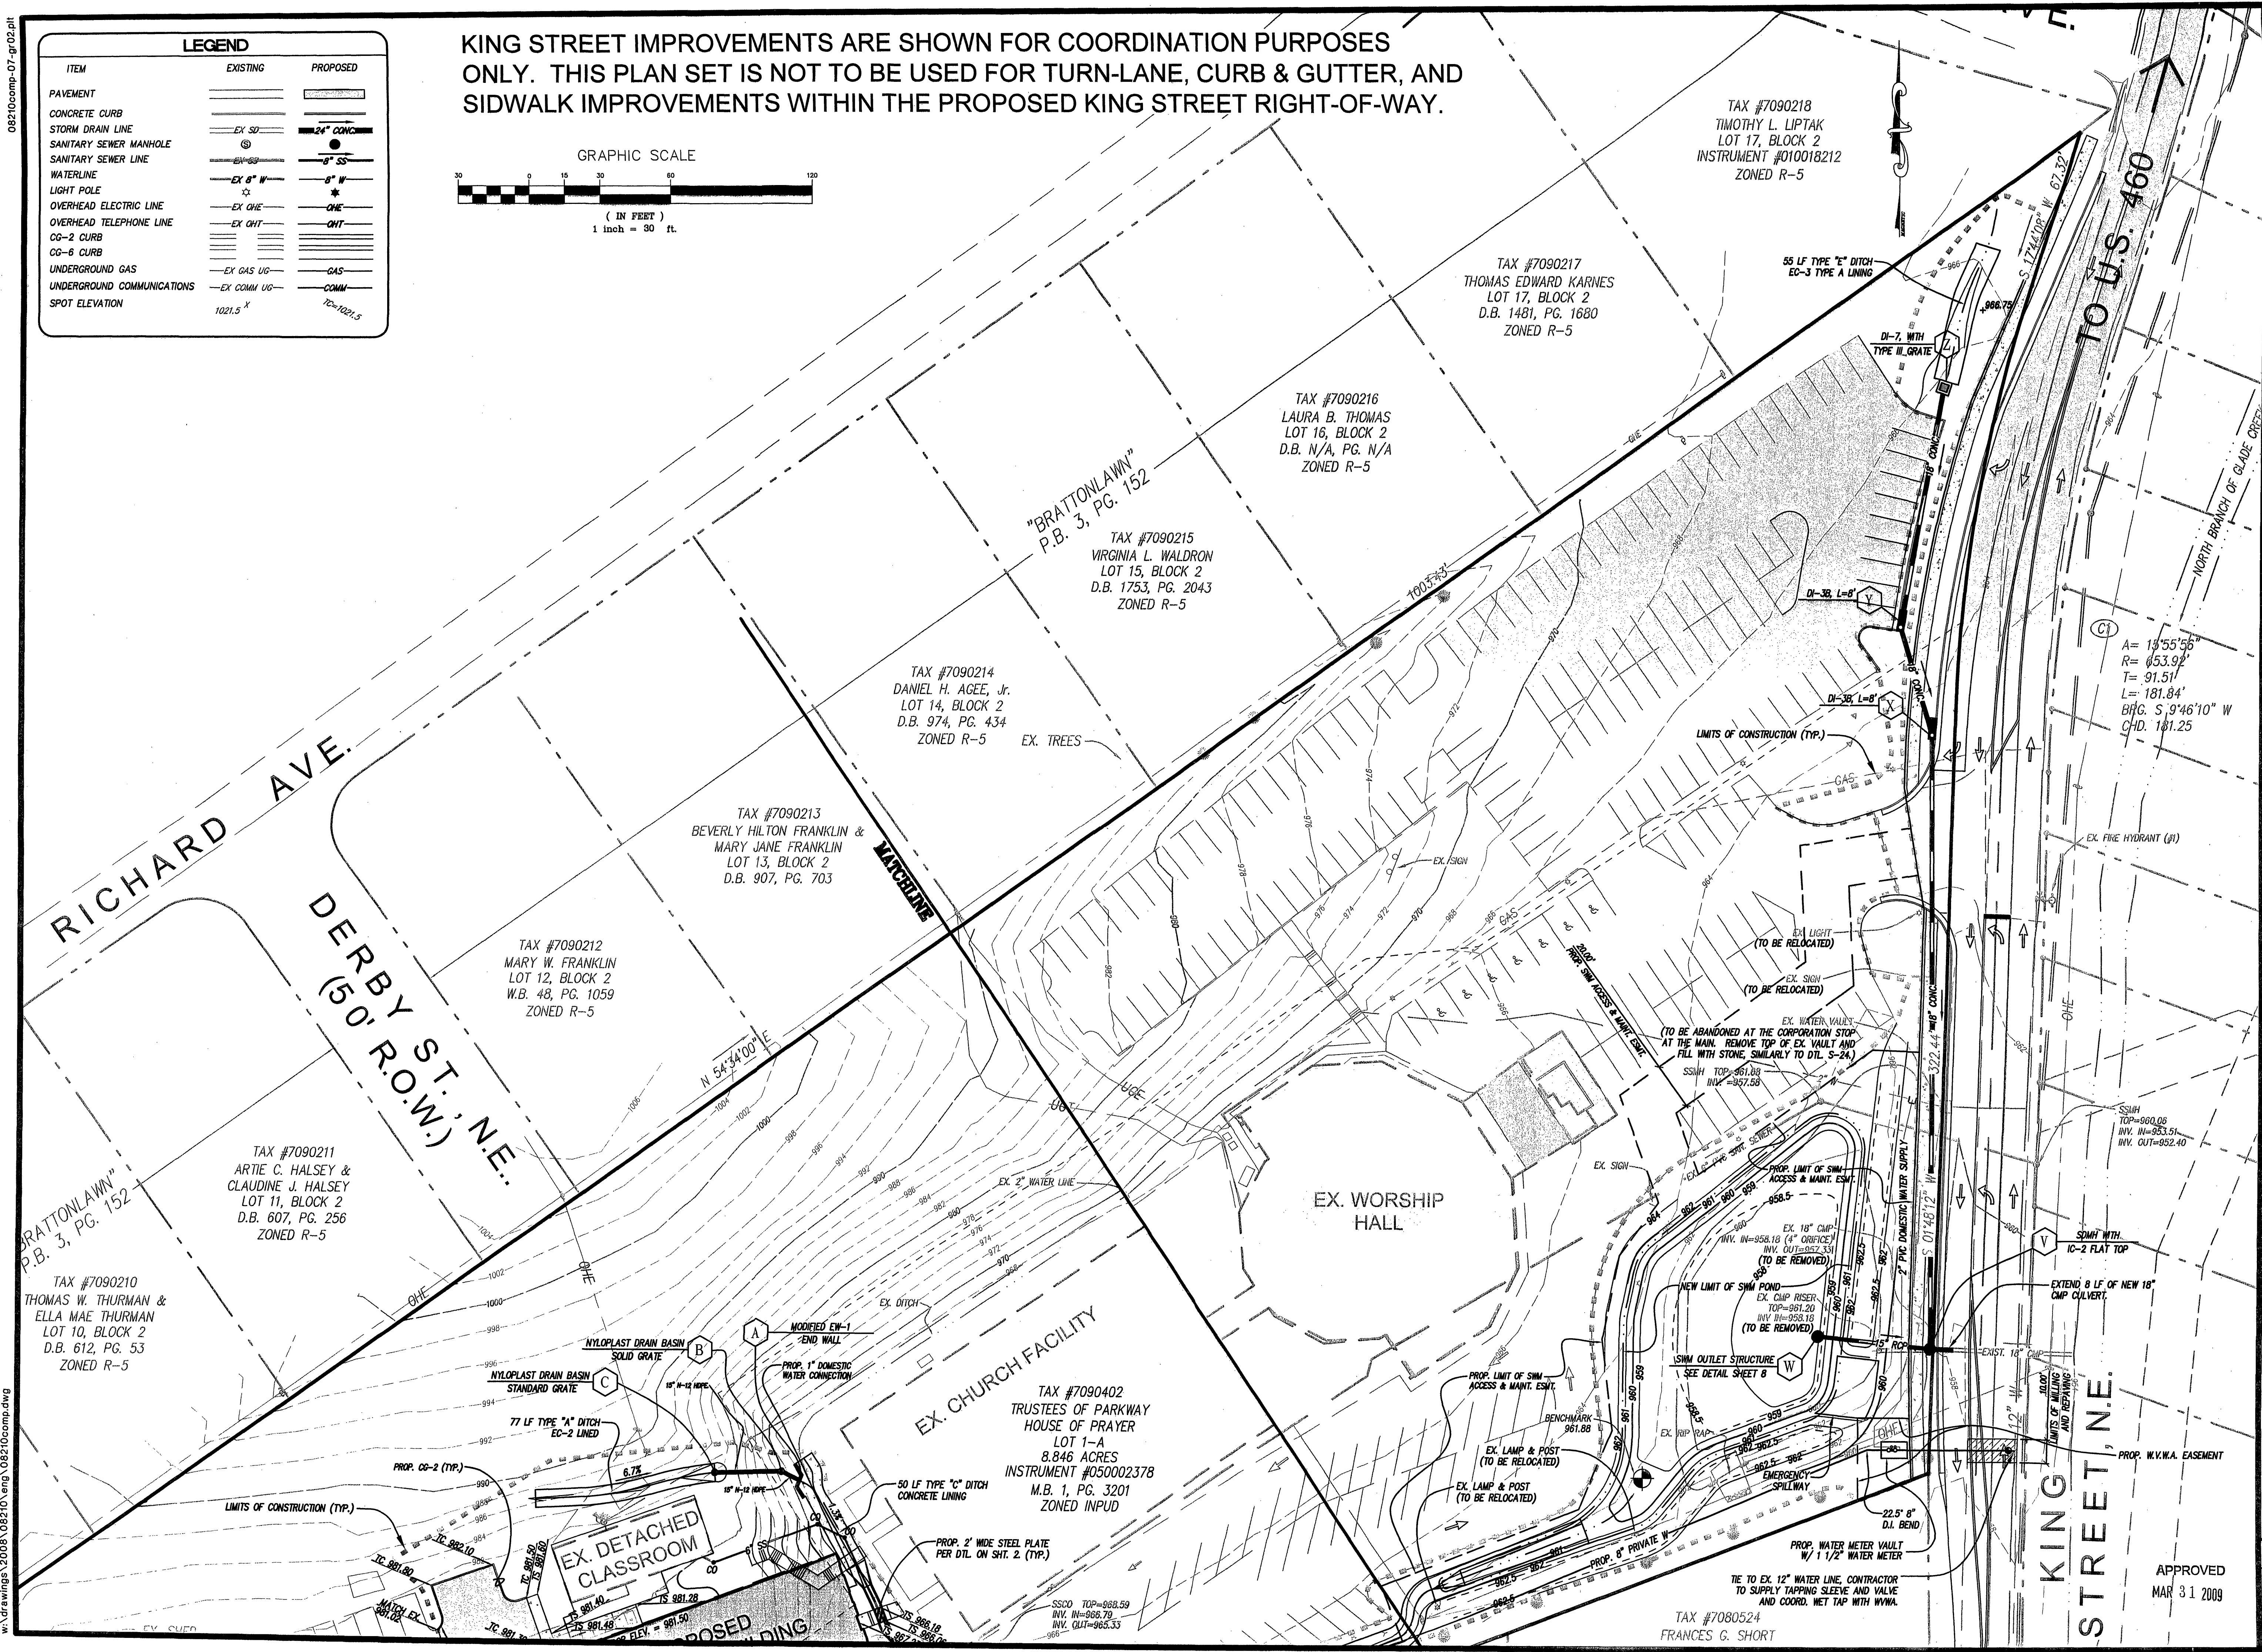


08210comp-07-gr02.dwg

w:\drawings\2008\08210\eng\08210comp.dwg

LEGEND		
ITEM	EXISTING	PROPOSED
PAVEMENT		
CONCRETE CURB		
STORM DRAIN LINE	EX SD	24" CONC
SANITARY SEWER MANHOLE	S	8" SS
SANITARY SEWER LINE	EX SS	8" SS
WATERLINE	EX 8" W	8" W
LIGHT POLE	*	*
OVERHEAD ELECTRIC LINE	EX OHE	OHE
OVERHEAD TELEPHONE LINE	EX OHT	OHT
CG-2 CURB		
CG-6 CURB		
UNDERGROUND GAS	EX GAS UG	GAS
UNDERGROUND COMMUNICATIONS	EX COMM UG	COMM
SPOT ELEVATION	1021.5 X	70-1021.5

KING STREET IMPROVEMENTS ARE SHOWN FOR COORDINATION PURPOSES ONLY. THIS PLAN SET IS NOT TO BE USED FOR TURN-LANE, CURB & GUTTER, AND SIDEWALK IMPROVEMENTS WITHIN THE PROPOSED KING STREET RIGHT-OF-WAY.

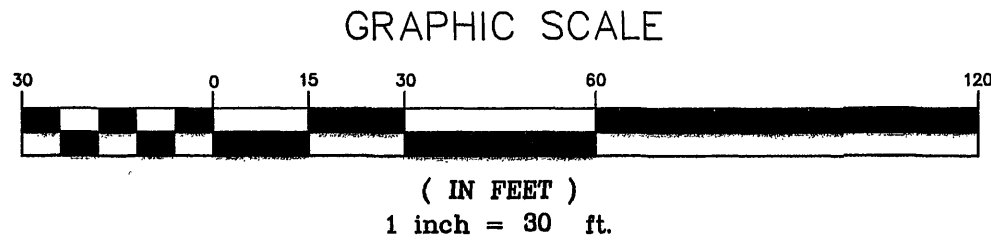

LUMSDEN ASSOCIATES, P.C.
ENGINEERS-SURVEYORS-PLANNERS
ROANOKE, VIRGINIA

4664 BRAMBLETON AVENUE
P.O. BOX 20669
ROANOKE, VIRGINIA 24018

PHONE: (540) 774-4411
FAX: (540) 772-9445
E-MAIL: MAIL@LUMSDENPC.COM

COMMONWEALTH OF VIRGINIA
KEVIN T. BARNES
Cert. No. 000787
2.20.2009
LANDSCAPE ARCHITECT

GRADING PLAN

PARKWAY ACADEMY
AT
PARKWAY HOUSE OF PRAYER
PREPARED FOR
JONES & JONES ARCHITECTS, PC
CITY OF ROANOKE, VIRGINIA

REVISIONS		DESCRIPTION
NO.	DATE	
1		
2		
3		
4		
5		

DATE: March 26, 2009
SCALE: 1" = 30'
COMMISSION NO: 08-210
SHEET 7 OF 13