

CITY OF SALEM
PENGUIN LANE PRESSURE ZONE
IMPROVEMENTS

* * *
CITY OF SALEM

SITE SUMMARY

OWNER: CITY OF SALEM
ADDRESS: 114 NORTH BROAD STREET
P.O. BOX 869
SALEM, VA 24153-0869

CONTACT: CITY OF SALEM WATER AND SEWER DEPARTMENT
TELEPHONE NO: 540-375-3029

WESTERN VIRGINIA WATER AUTHORITY
601 S. JEFFERSON STREET
ROANOKE, VA 24011

BOB BENNINGER
540-853-5750

DRAWING LIST

NO.	DESCRIPTION
T-1	COVER SHEET
T-1A	COUNTY OF ROANOKE COVER SHEET
T-2	NOTES AND LEGEND SHEET
T-3	COUNTY OF ROANOKE EROSION & SEDIMENT CONTROL DETAILS
U-1	WATERLINE PLAN AND PROFILE
U-2	WATERLINE PLAN AND PROFILE
U-3	WATERLINE PLAN AND PROFILE
U-4	WATERLINE PLAN AND PROFILE
U-5	DETAILS AND METER VAULT DETAIL
U-6	DETAILS
U-7	DETAILS


DRAPER ADEN ASSOCIATES REVIEW

THESE PLANS HAVE BEEN SUBJECTED TO TECHNICAL AND QUALITY REVIEWS BY:

NAME: Randall Hancock PRINTED: Jim M. Hume SIGNATURE: 1/6/09 DATE: 1/6/09
PROJECT DESIGNER


NAME: Randall Hancock PRINTED: Jim M. Hume SIGNATURE: 1/6/09 DATE: 1/6/09
PROJECT MANAGER

NAME: _____ PRINTED: _____ SIGNATURE: _____ DATE: _____
QUALITY REVIEWER

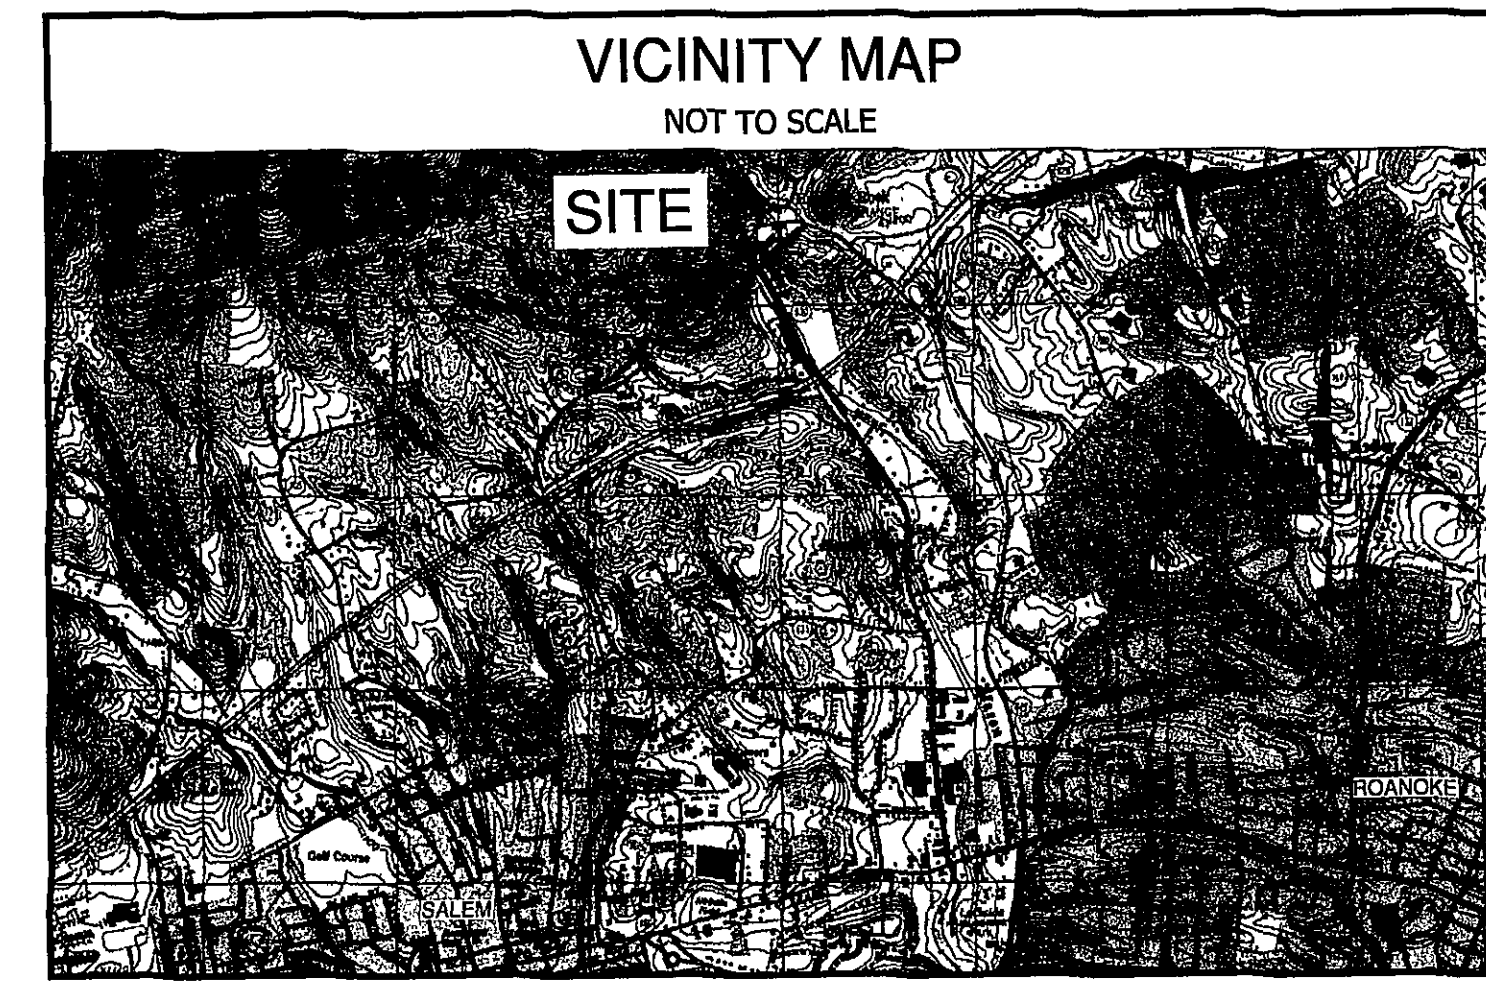

NOTE: CONTRACTOR TO CONTACT
MISS UTILITY (1-800-552-7001)
AT LEAST 3 WORKING DAYS IN
ADVANCE OF PLANNED WORK.

DESIGN TICKET No. A603801423

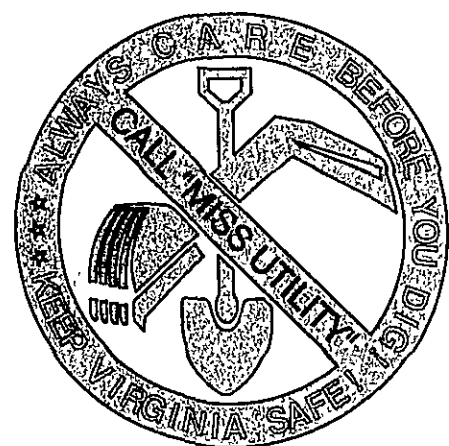


JUNE 12, 2008
* * * *
B07132-03

These documents, including drawings and specifications, were prepared by Draper Aden Associates, Consulting Engineers, pursuant to a contract by and between Draper Aden Associates and City of Salem with respect to the project described in said contract. Any reuse or modification of said documents (whether hard copy or electronic) without written verification or adaptation by Draper Aden Associates for the specific purpose intended will be at the sole risk of the individual or entity utilizing said documents, drawings and specifications and such use is without the authorization of Draper Aden Associates. Draper Aden Associates, Consulting Engineers, shall have no legal liability resulting from any and all claims, damages, losses, and expenses, including attorney's fees arising out of the unauthorized use of these documents, drawings, specifications, reports, and studies prepared as a result of the aforesaid contract.

APPROVED

AS - BUILT
6/18/2009

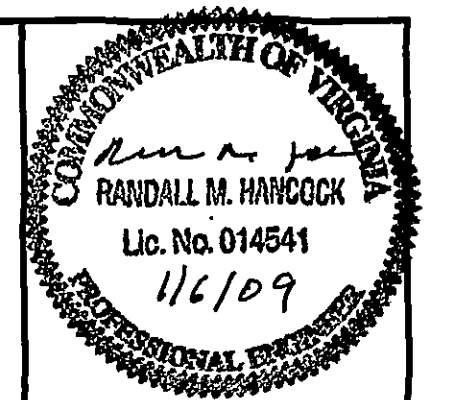

Draper Aden Associates
Engineering • Surveying • Environmental Services
Blacksburg, VA
210 South Main Street
Blacksburg, VA 24060
540-552-3444 Fax: 540-552-0281
www.daa.com

Richmond, VA
Charlottesville, VA
Hampton Roads, VA

COVER SHEET
PENGUIN LANE PRESSURE
ZONE IMPROVEMENTS
CITY OF SALEM
CITY OF SALEM, VIRGINIA

REVISIONS
07/02/08 ADDED SHEETS T-1A & T-3
DESIGNED BY: RMH
DRAWN BY: DLD
CHECKED BY: JSL
SCALE: N/A
DATE: 06/12/08
PROJECT NUMBER: B07132-03
T-1