


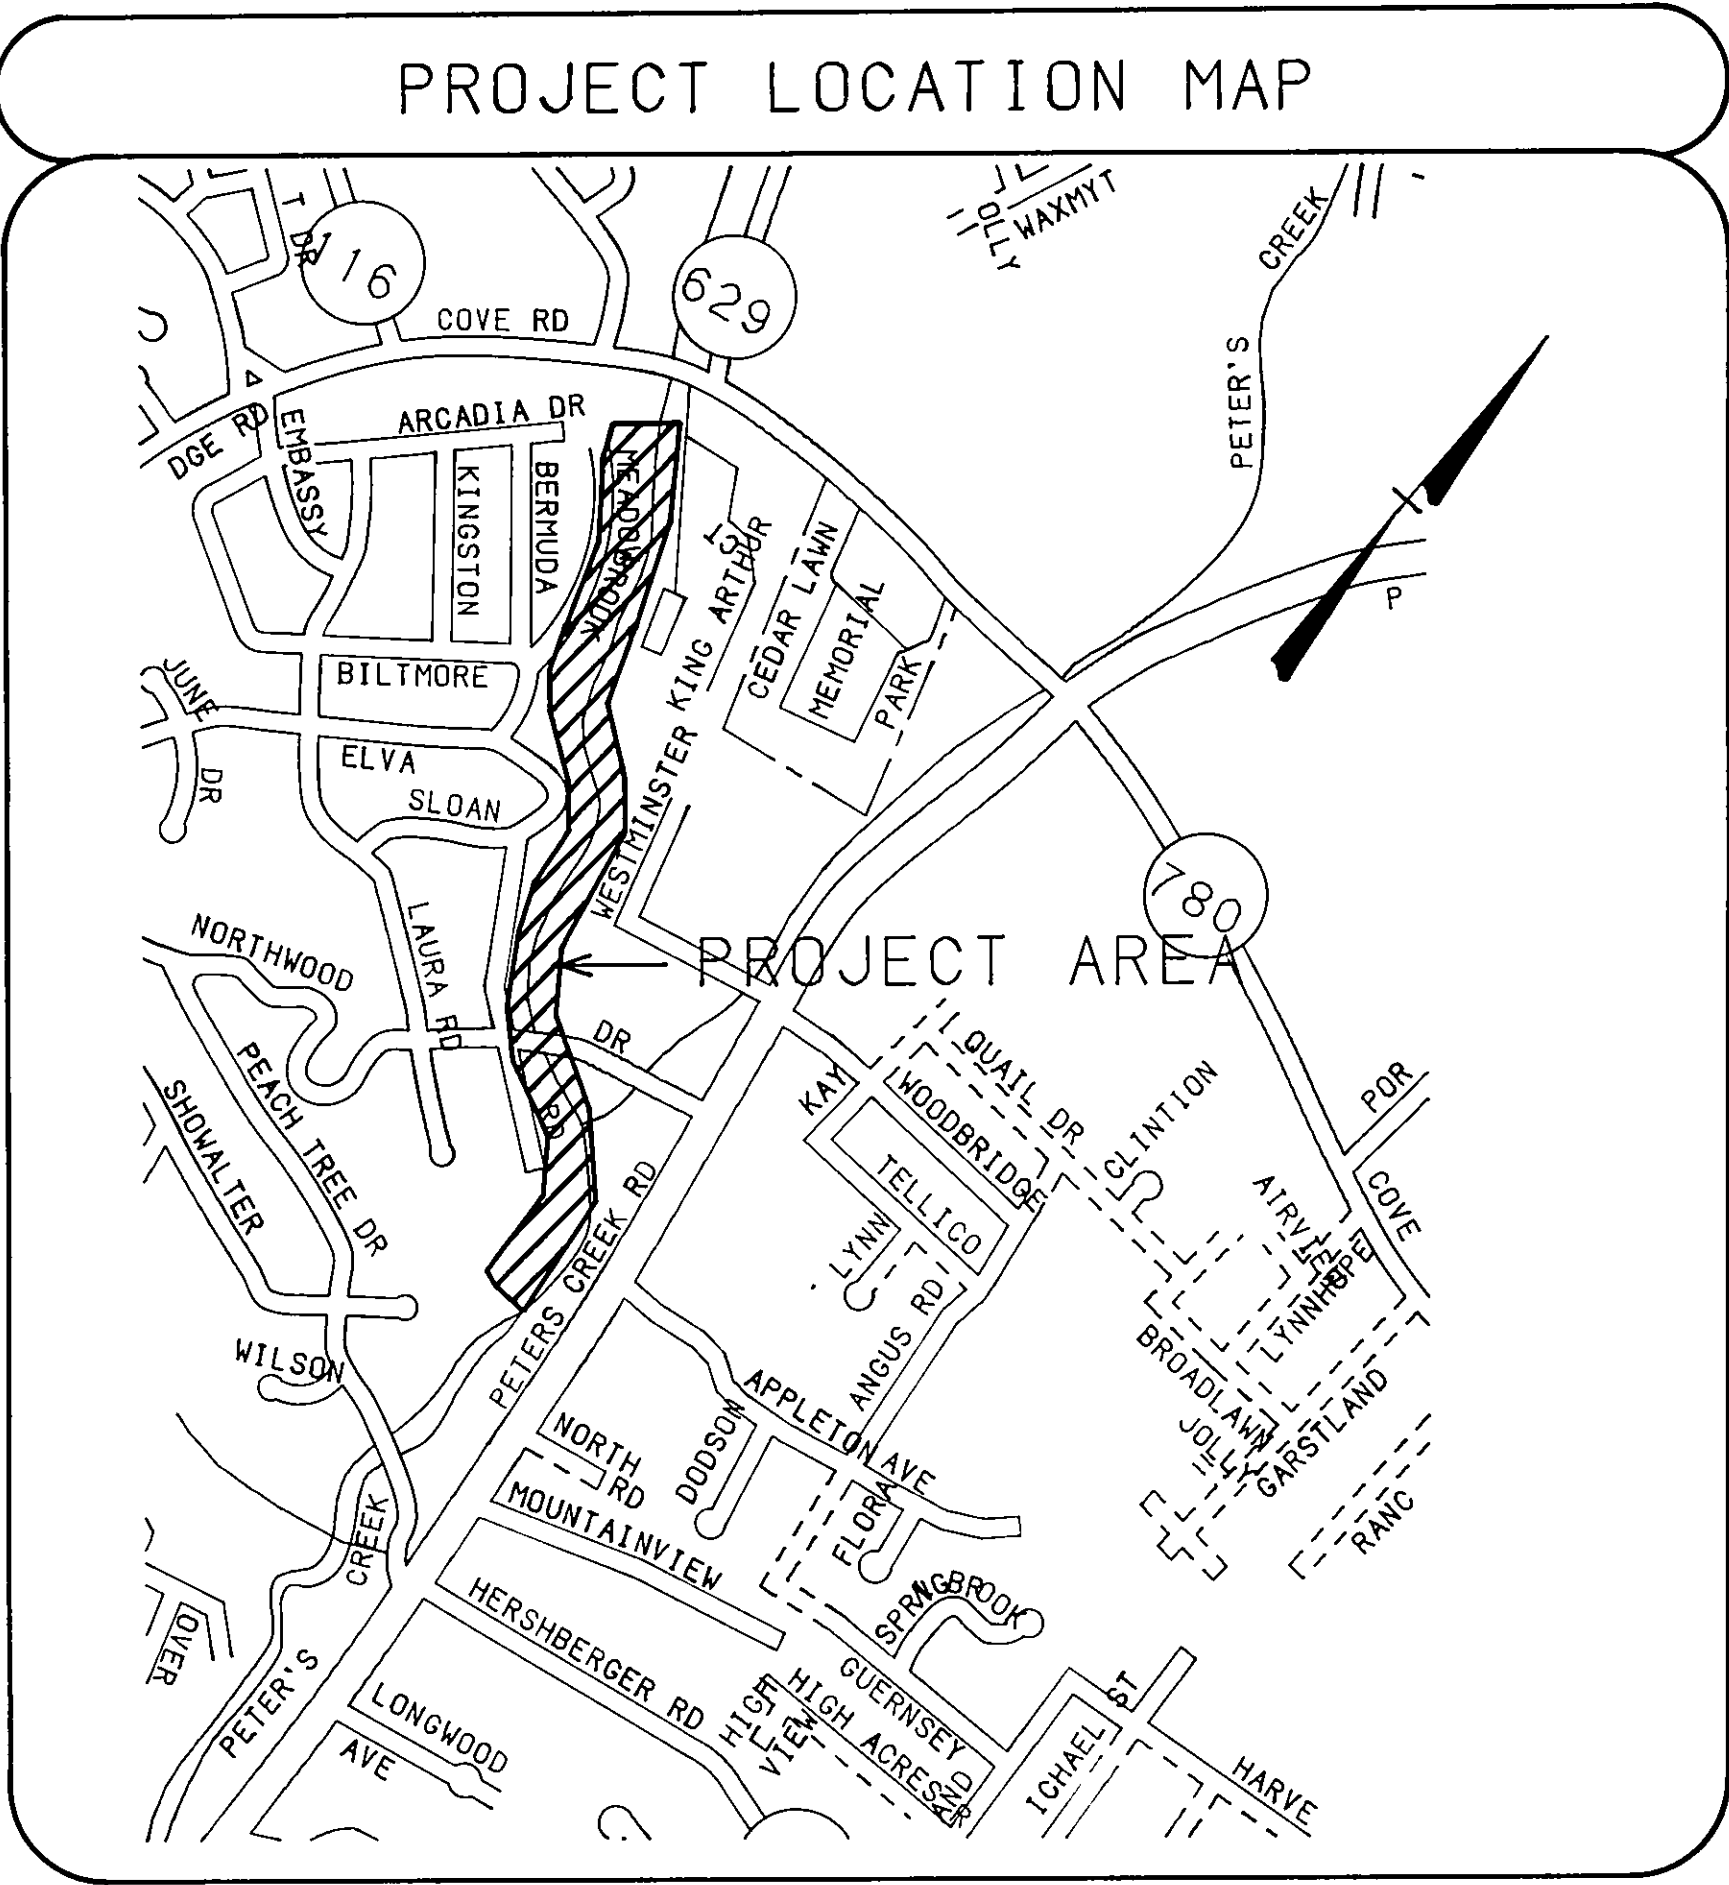

OFFICE OF CITY ENGINEER
ROOM 350
MUNICIPAL BUILDING
215 CHURCH AVENUE, S.W.
ROANOKE, VIRGINIA 24011

INDEX OF SHEETS

1	TITLE
2	SUMMARY OF QUANTITIES
3	GENERAL ABBREVIATIONS & LEGEND
4	SHEET INDEX & GENERAL NOTES
5	PLAN AND PROFILE
6	PLAN AND PROFILE
7	PLAN AND PROFILE
8	PLAN AND PROFILE
9	PLAN AND PROFILE
10	PLAN AND PROFILE
11	PLAN
12	PLAN
13	PROFILE
14	PROPERTY CORNER LOCATIONS

CONSULTING ENGINEERS

Mattern & Craig
CONSULTING ENGINEERS
SURVEYORS
701 FIRST STREET
ROANOKE, VIRGINIA

COMMISSION NUMBER: 1245

PROJECT NAME

SEWER REPLACEMENT PROJECT PC-1
PETERS CREEK SEWERSHED
CITY OF ROANOKE, VIRGINIA

PROJECT NUMBER: 6245

REVISION BY	DESCRIPTION	DATE
REVISION BY	DESCRIPTION	DATE
REVISION BY	DESCRIPTION	DATE
REVISION BY	DESCRIPTION	DATE

RECORD DRAWINGS
1-11-94

APPROVED FOR CONSTRUCTION

<u>Charles M. Hufline</u> ROANOKE CITY ENGINEER	<u>5-12-93</u> DATE
<u>Paul H. Hufline, ACTING</u> DIRECTOR OF PUBLIC WORKS	<u>5-12-93</u> DATE
_____ DIRECTOR OF PUBLIC UTILITIES AND OPERATIONS	_____ DATE
_____	_____ DATE
_____	_____ DATE

ADVERTISED DATE: 5-24-93

SET NUMBER: _____

SHEET NUMBER: 1 OF 14

(1994)
6245
PC-1