


16218comp-06-gr01.plt
w:\drawings\2016\16218\eng\16218comp.dwg

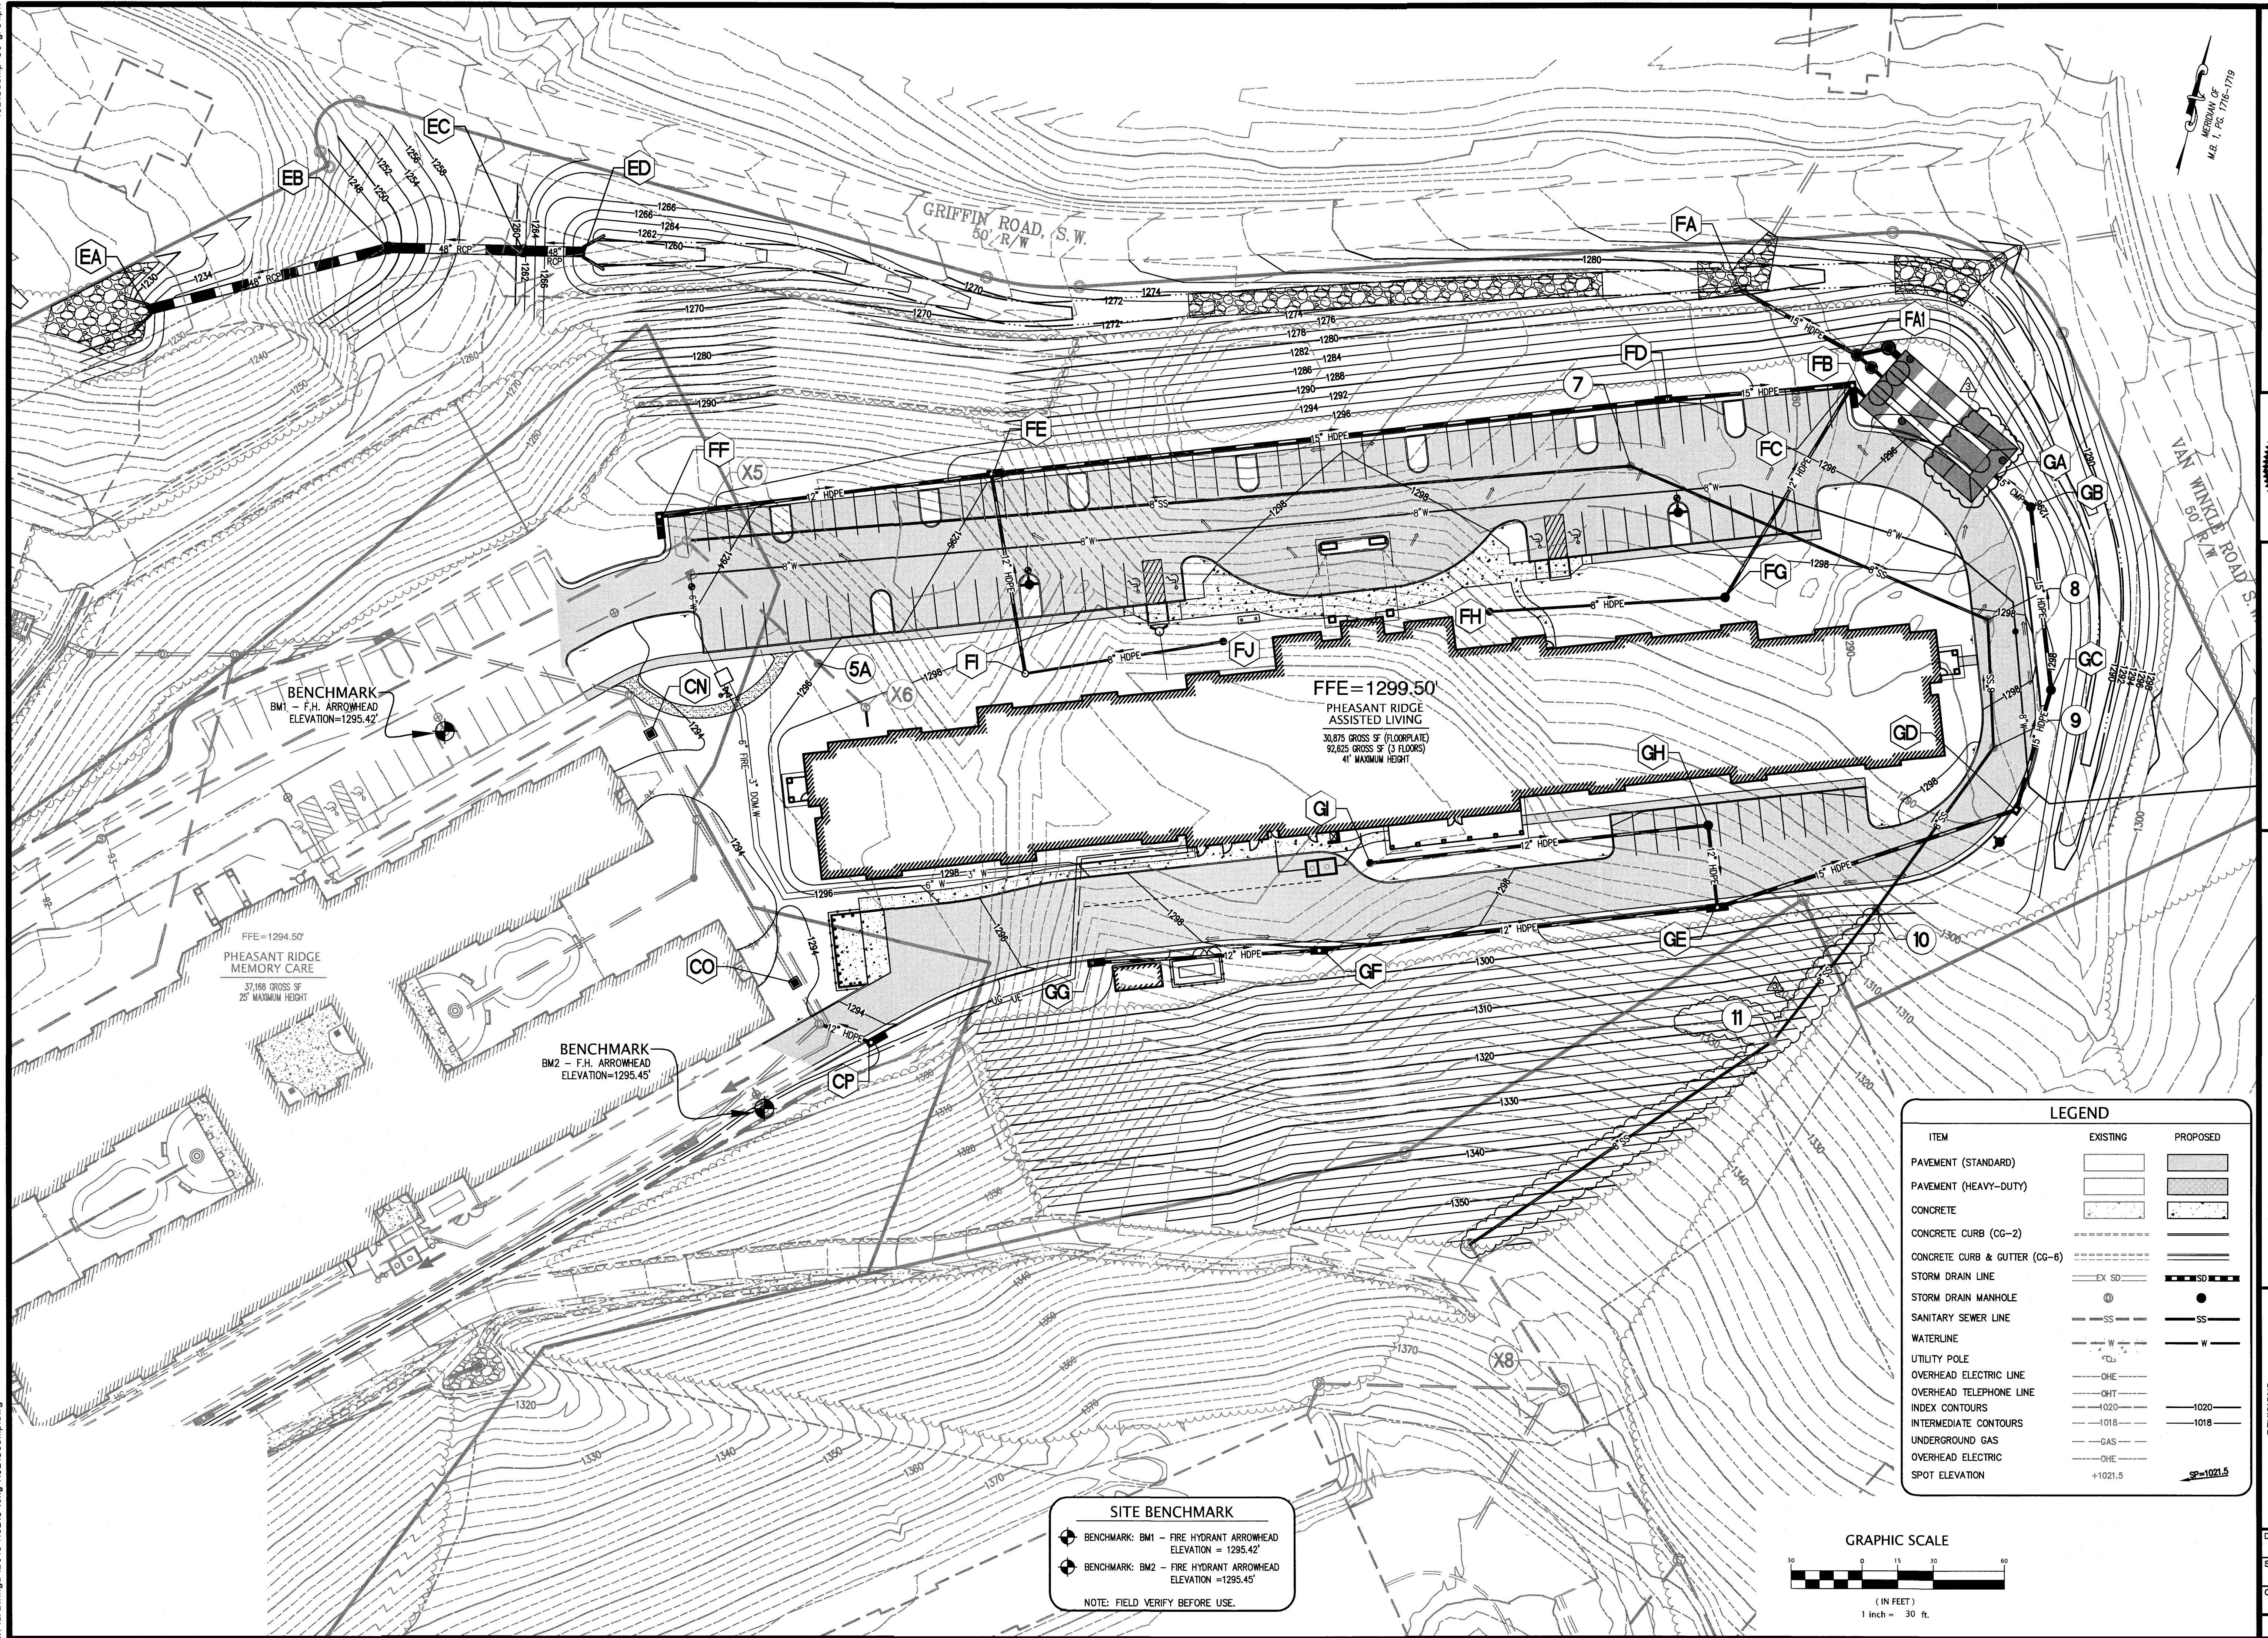

LUMSDEN ASSOCIATES P.C.
ENGINEERS-SURVEYORS-PLANNERS
ROANOKE, VIRGINIA

PHONE: (540) 774-4411
FAX: (540) 772-9445
E-MAIL: MAIL@LUMSDENPC.COM

COMMONWEALTH OF VIRGINIA
HOWARD P. BOGGS, II
Lic. No. 000920
11/17/17
LANDSCAPE ARCHITECT

GRADING PLAN

COMPREHENSIVE DEVELOPMENT PLAN
FOR
PHEASANT RIDGE ASSISTED LIVING
PREPARED FOR
SMITH/PACKETT MED-COM, L.L.C.
SITUATED AT 4414 PHEASANT RIDGE ROAD, SW
CITY OF ROANOKE, VIRGINIA

NO.	DATE	DESCRIPTION
1	11/7/17	REVISE SWM FACILITY LENGTH, SANITARY SEWER

DATE: June 23, 2017
SCALE: 1" = 30'
COMMISSION NO: 16-218
SHEET 6 OF 19