



BENCHMARK:
 ARROWHEAD ON FRONT OF
 FIRE HYDRANT ON N. SIDE
 OF PLEASANT RUN DRIVE
 ELEVATION=1277.34

FIELD EVIDENCE SHOWS THE PRESENCE
 OF AN UNDERGROUND TELEPHONE CABLE
 ON THE SOUTH SIDE OF PLEASANT RUN DR.
 THE CONTRACTOR SHALL LOCATE AND AVOID
 UNDERGROUND CABLES IN THIS AREA.

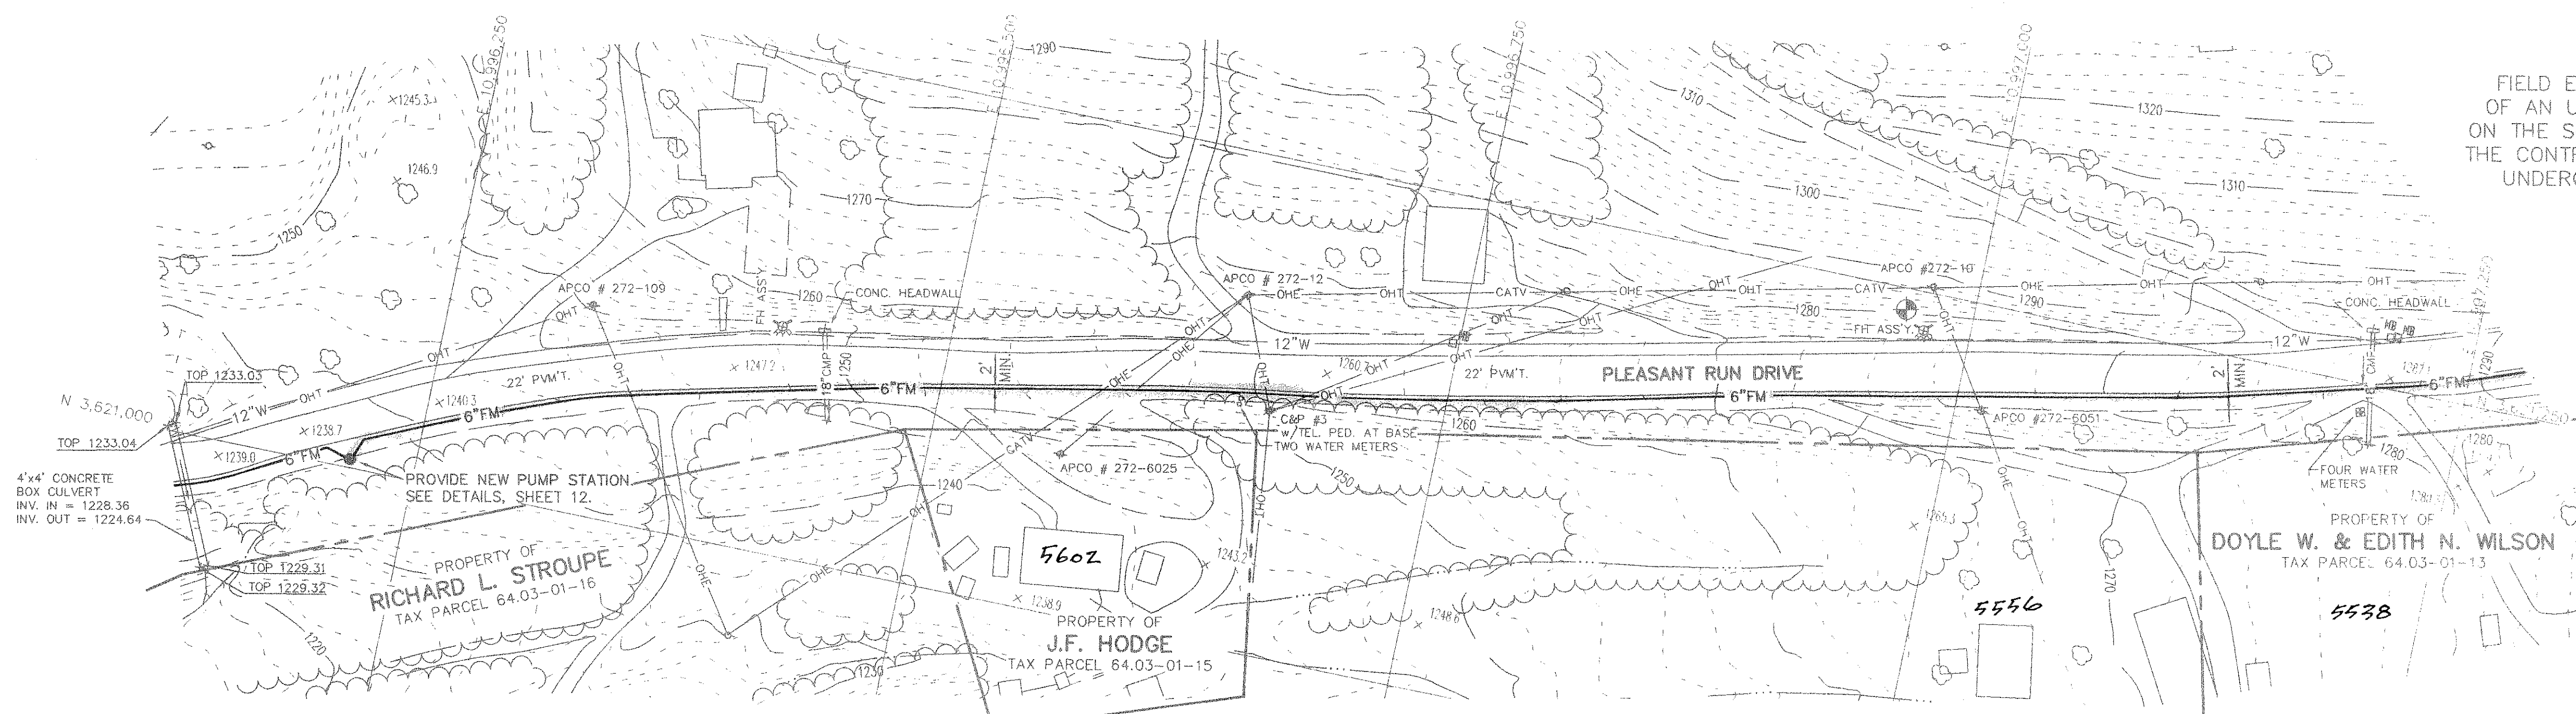

SCALE: 1" = 50' HORIZ.
 1" = 10' VERT.

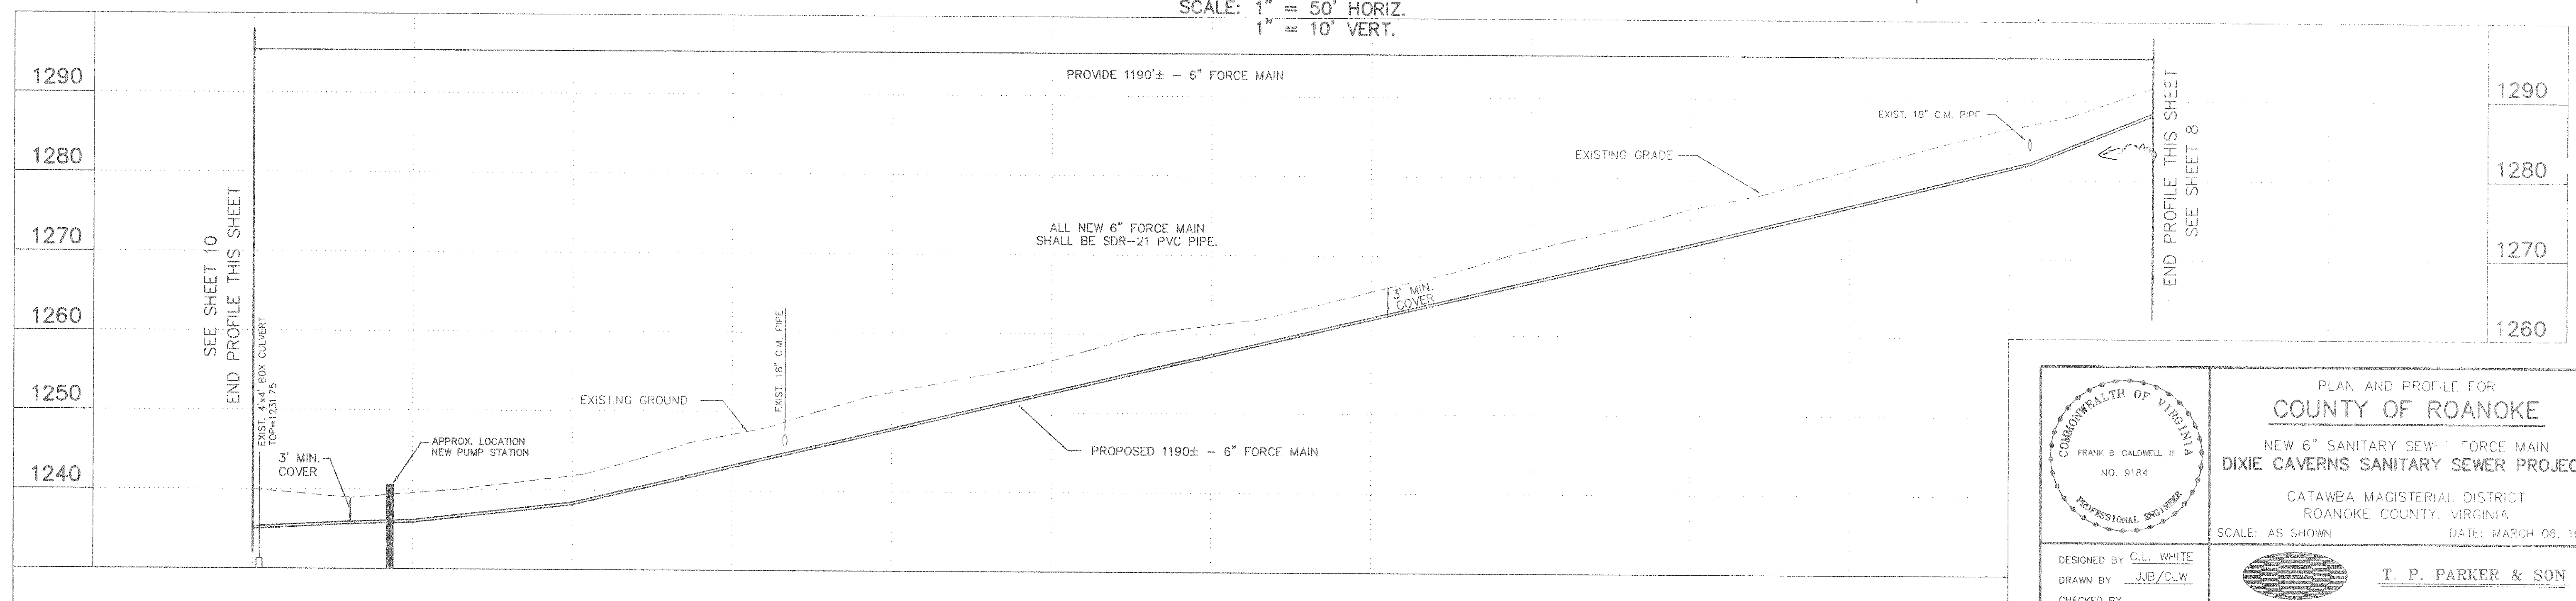

	PLAN AND PROFILE FOR COUNTY OF ROANOKE NEW 6" SANITARY SEWER FORCE MAIN DIXIE CAVERNS SANITARY SEWER PROJECT CATAWBA MAGISTERIAL DISTRICT ROANOKE COUNTY, VIRGINIA SCALE: AS SHOWN DATE: MARCH 06, 1995	
	DESIGNED BY: C.L. WHITE DRAWN BY: JJB/CLW CHECKED BY: 92-1081 N.B. RKE.CO.PROJ. #3 TAX NO.	T. P. PARKER & SON 816 Boulevard Post Office Box 30 Salem, Virginia 24153 Telephone: 703-387-1153 FAX: 703-389-5787
	GRAPHIC SCALE 50' 25' 0' 50' 100' 1" = 50'	
	SHEET 9 OF 13 804	