

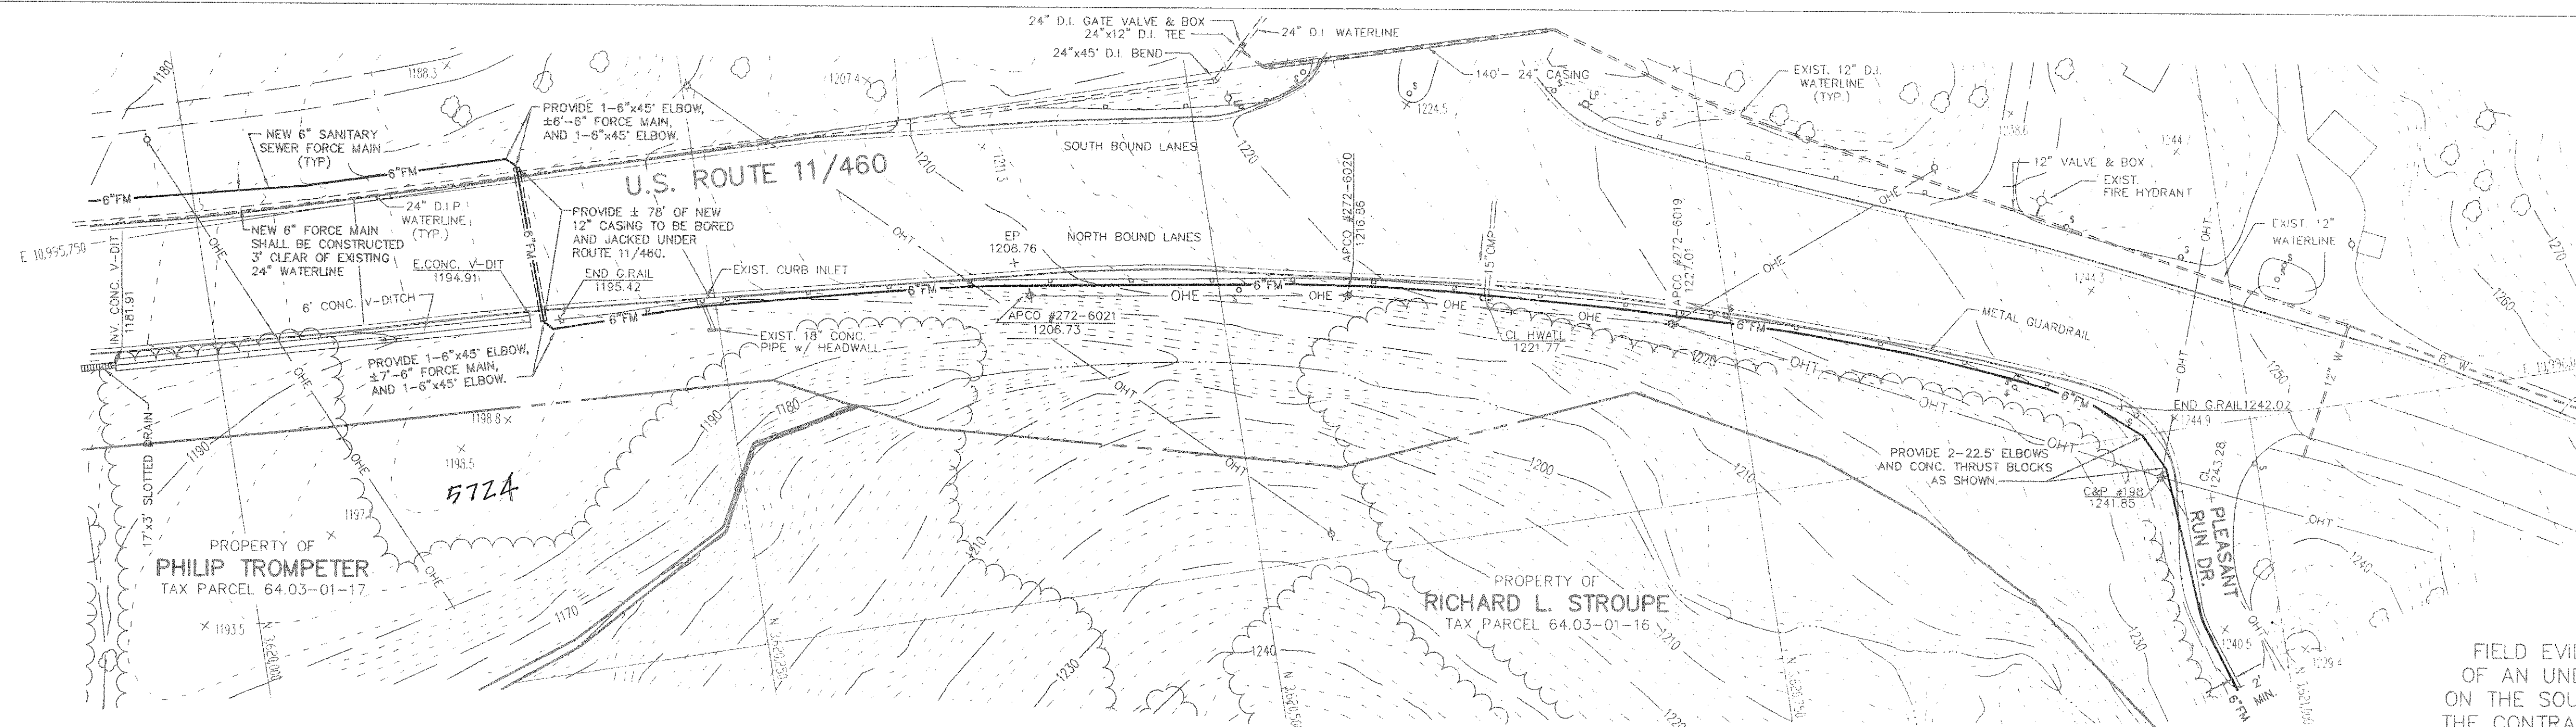


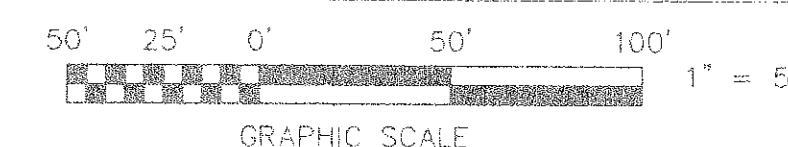

FIELD EVIDENCE SHOWS THE PRESENCE OF AN UNDERGROUND TELEPHONE CABLE ON THE SOUTH SIDE OF PLEASANT RUN DR. THE CONTRACTOR SHALL LOCATE AND AVOID UNDERGROUND CABLES IN THIS AREA.

SCALE: 1" = 50' HORIZ.
1" = 10' VERT.

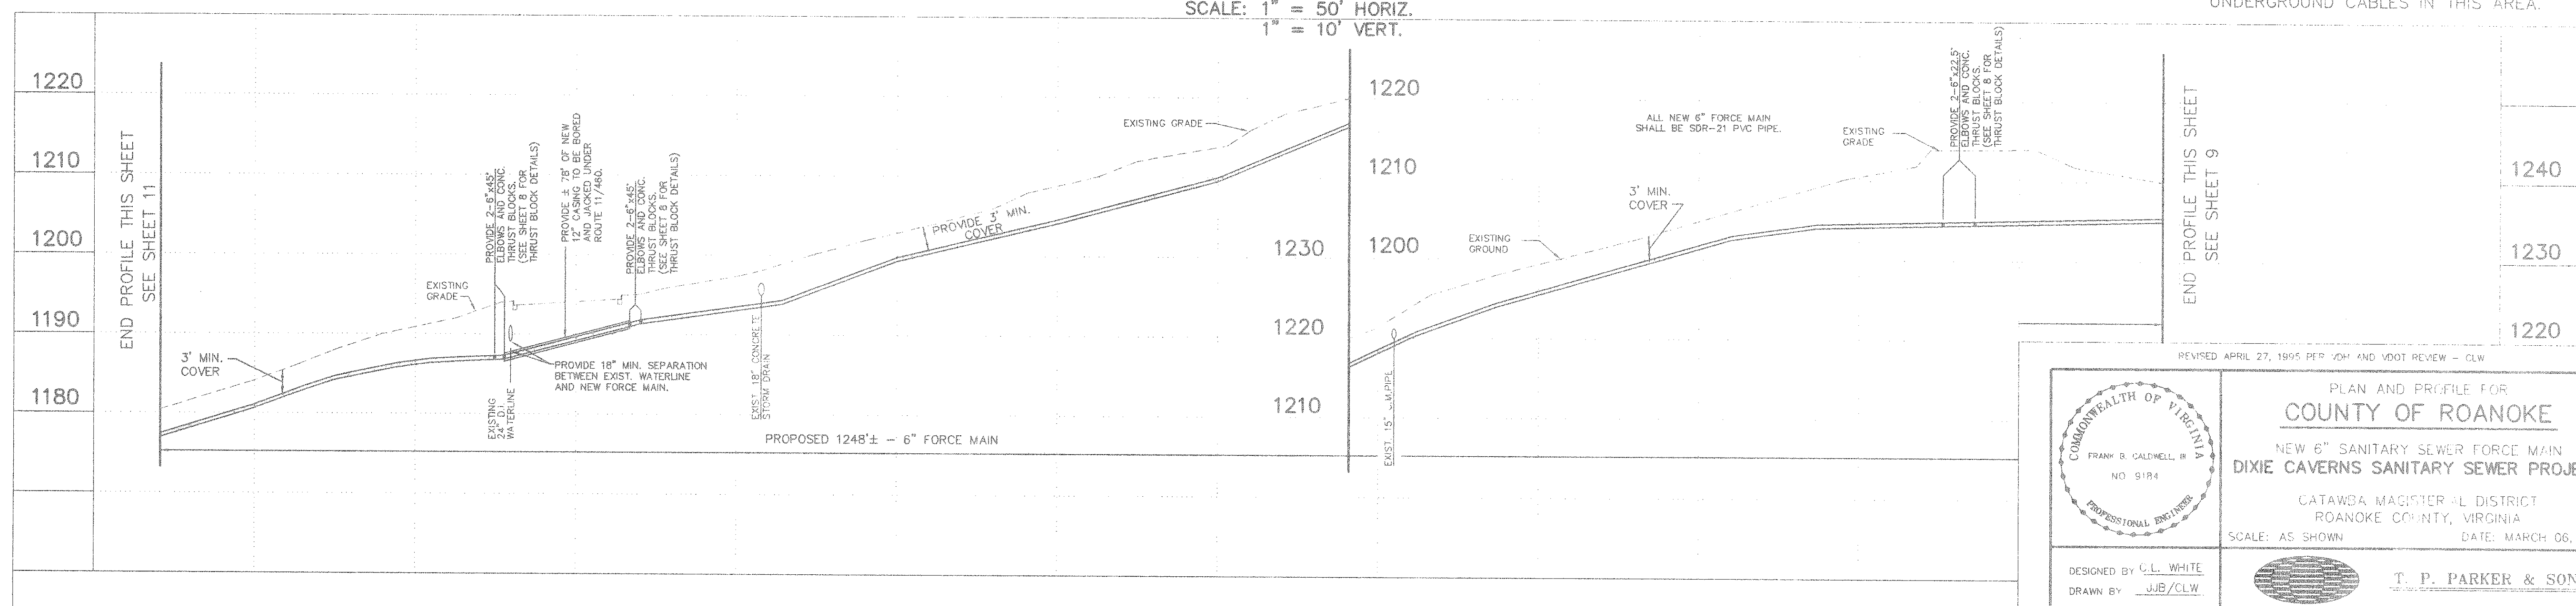

COMMONWEALTH OF VIRGINIA FRANK R. CALDWELL, III NO. 9184 PROFESSIONAL ENGINEER		PLAN AND PROFILE FOR COUNTY OF ROANOKE NEW 6" SANITARY SEWER FORCE MAIN DIXIE CAVERNS SANITARY SEWER PROJECT CATAWBA MAGISTERIAL DISTRICT ROANOKE COUNTY, VIRGINIA SCALE: AS SHOWN DATE: MARCH 06, 1995	
DESIGNED BY C.L. WHITE DRAWN BY JUB/CLW CHECKED BY W.D. # 92-1081 N.B. RKE.CO.PROJ. #3 TAX NO.		T.P.P. & SON 818 Boulevard Post Office Box 39 Salem, Virginia 24153 Telephone: 703-587-1153 FAX: 703-587-5767	