


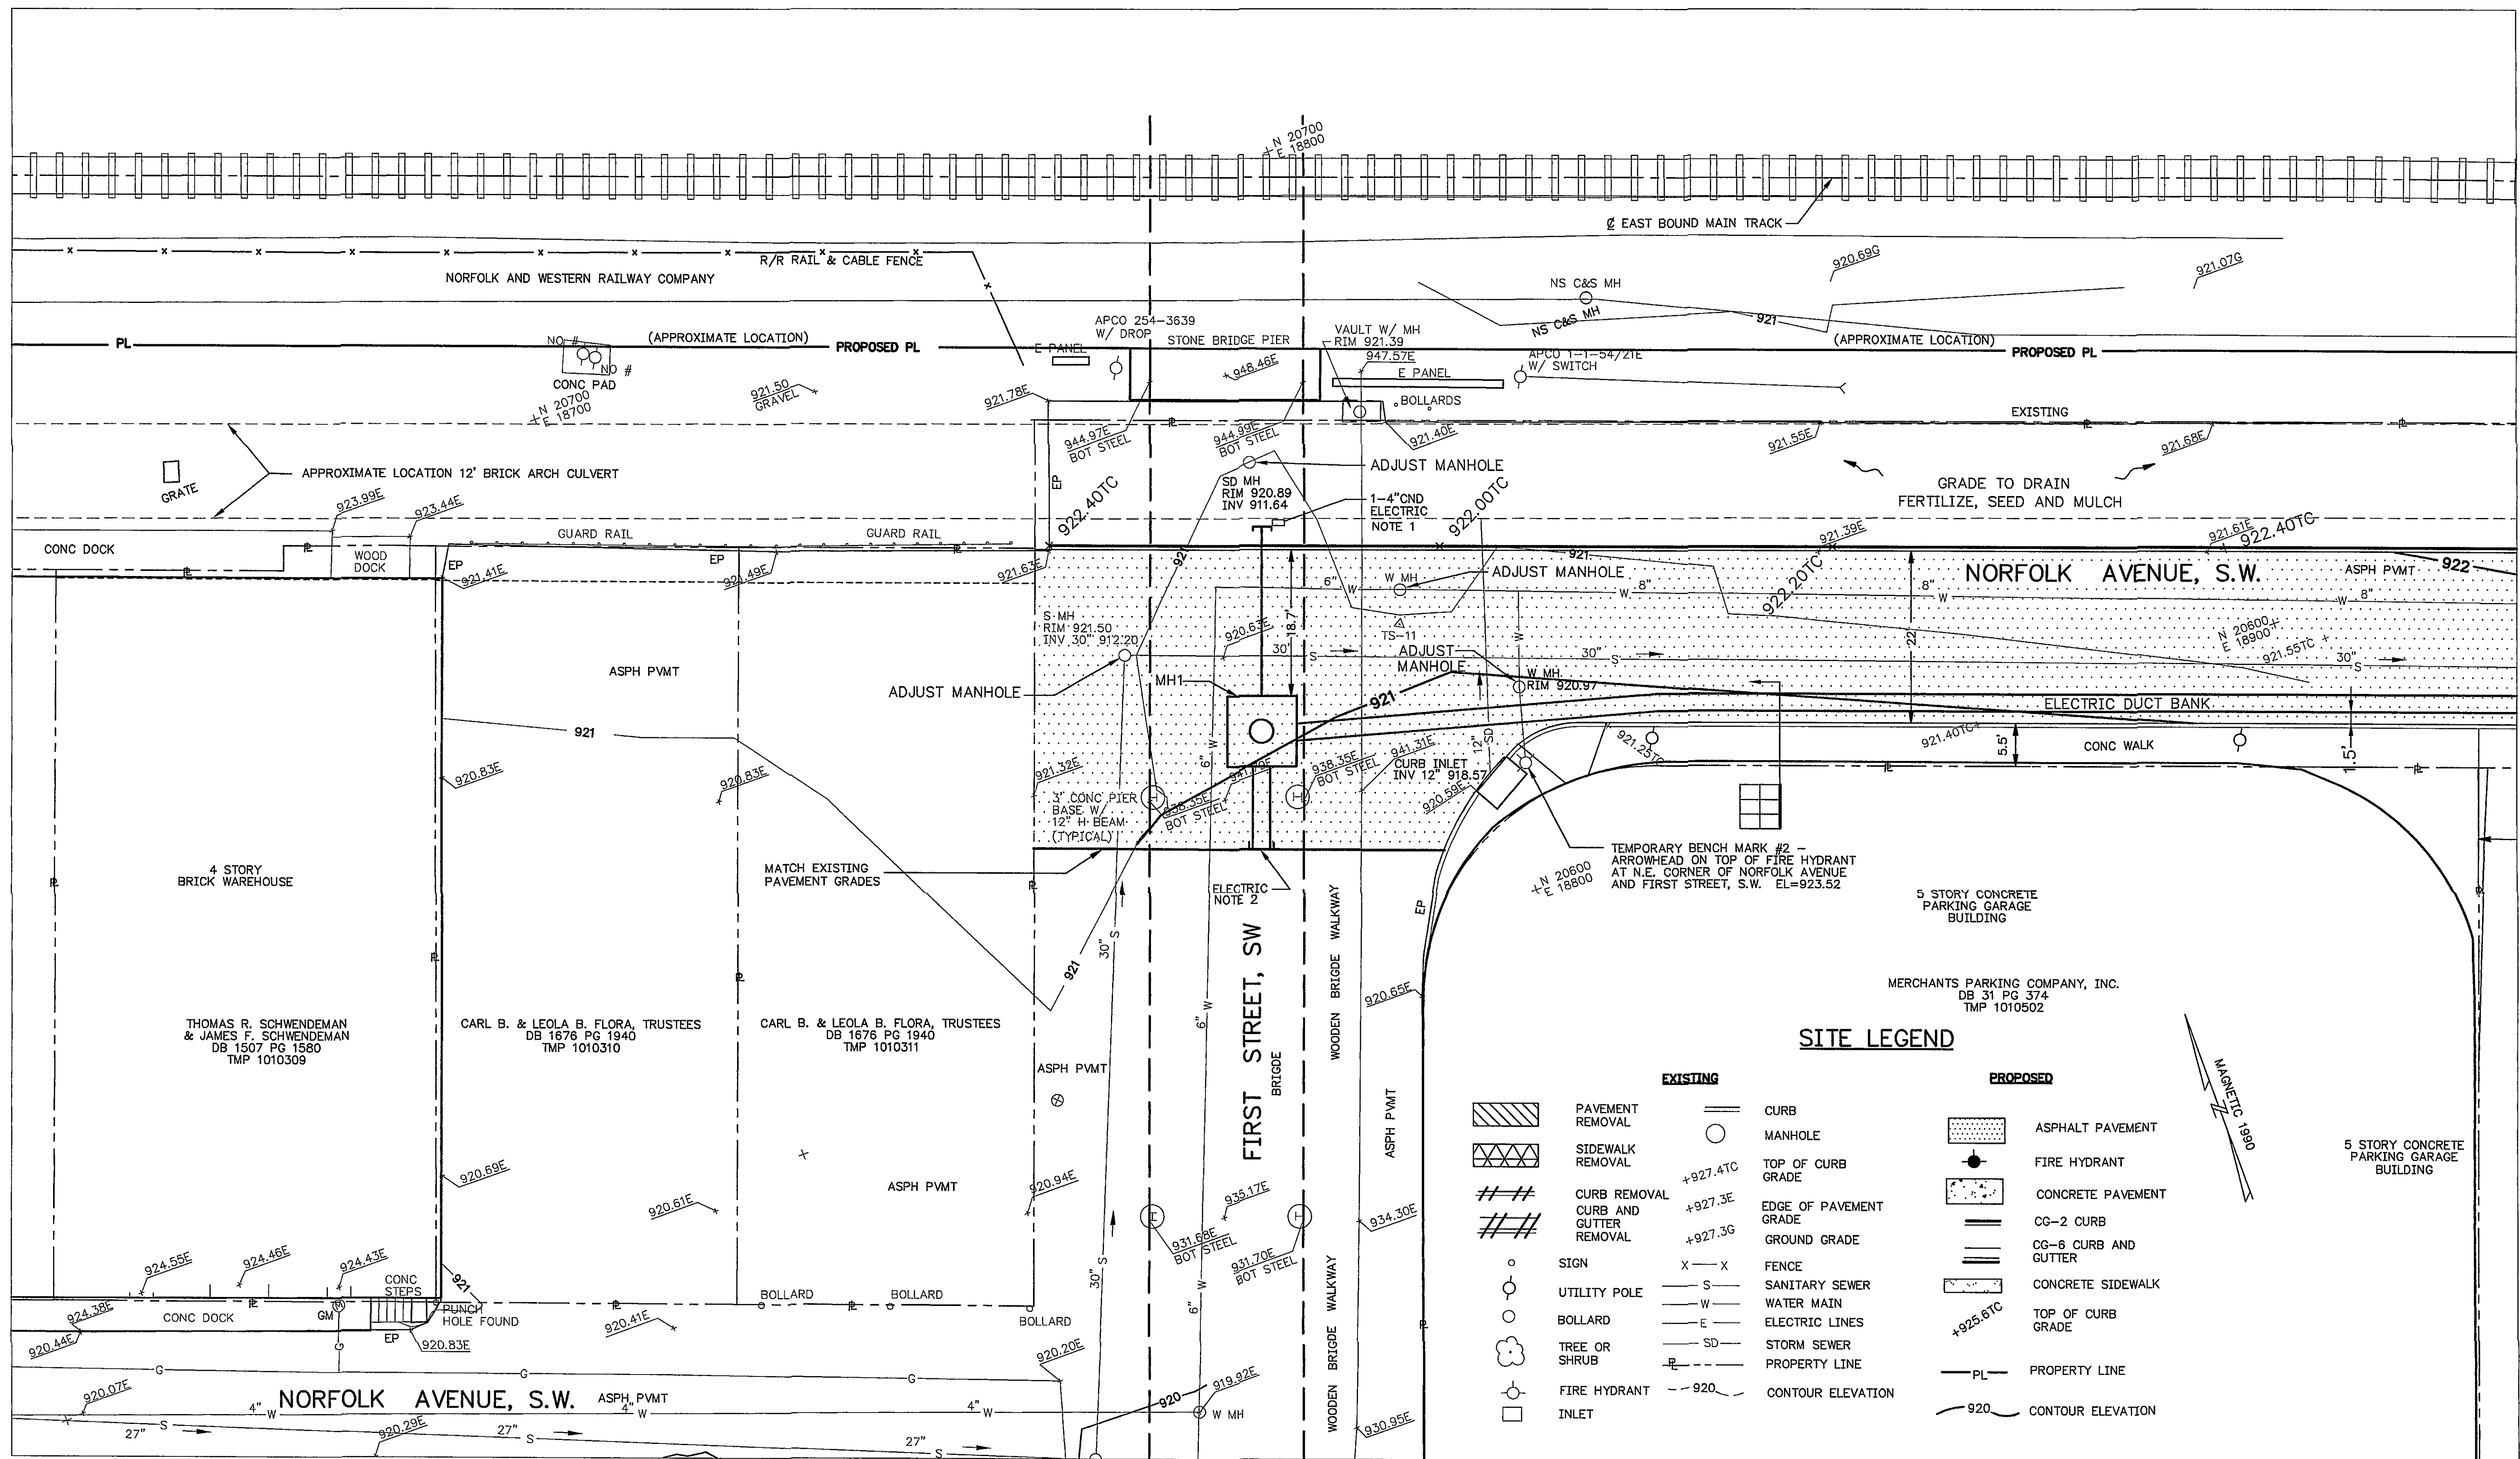


MATCH LINE E


ELECTRIC NOTES

1. EXTEND UNDER GROUND CONDUIT 4' BEYOND CG-2 CURB AND CAP OFF FOR FUTURE CONNECTION
2. EXTEND 6-4" CONDUIT 15' FROM MANHOLE AND CAP OFF PER DUCT BANK CAP OFF DETAIL, SEE E1, FOR FUTURE CONNECTION.
3. COORDINATE MANHOLE, DUCT BANK AND CONDUIT ELEVATIONS AND LOCATIONS WITH EXISTING UNDERGROUND UTILITIES.
4. SEE SHEET E1 FOR DUCT BANK AND MANHOLE DETAILS.

ELECTRIC LEGEND

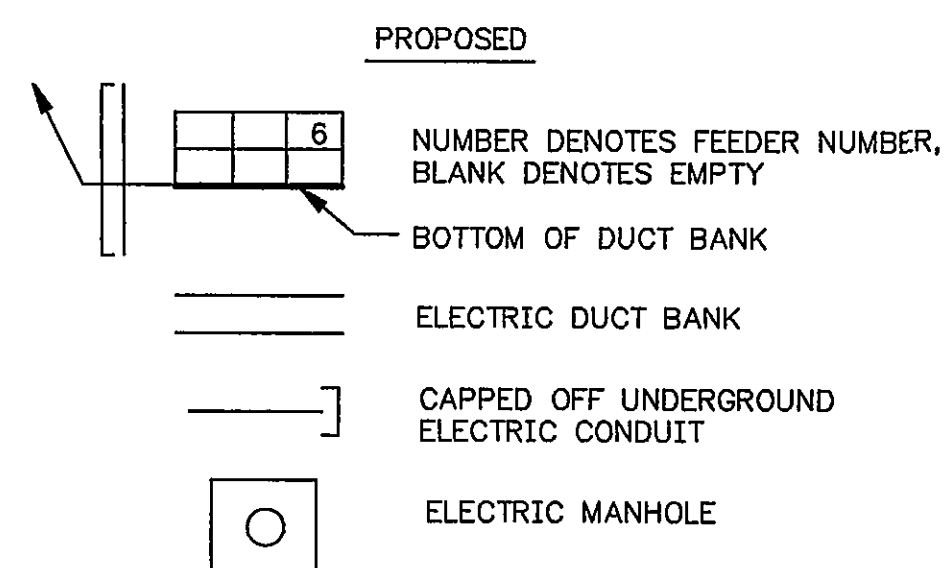

SITE LEGEND

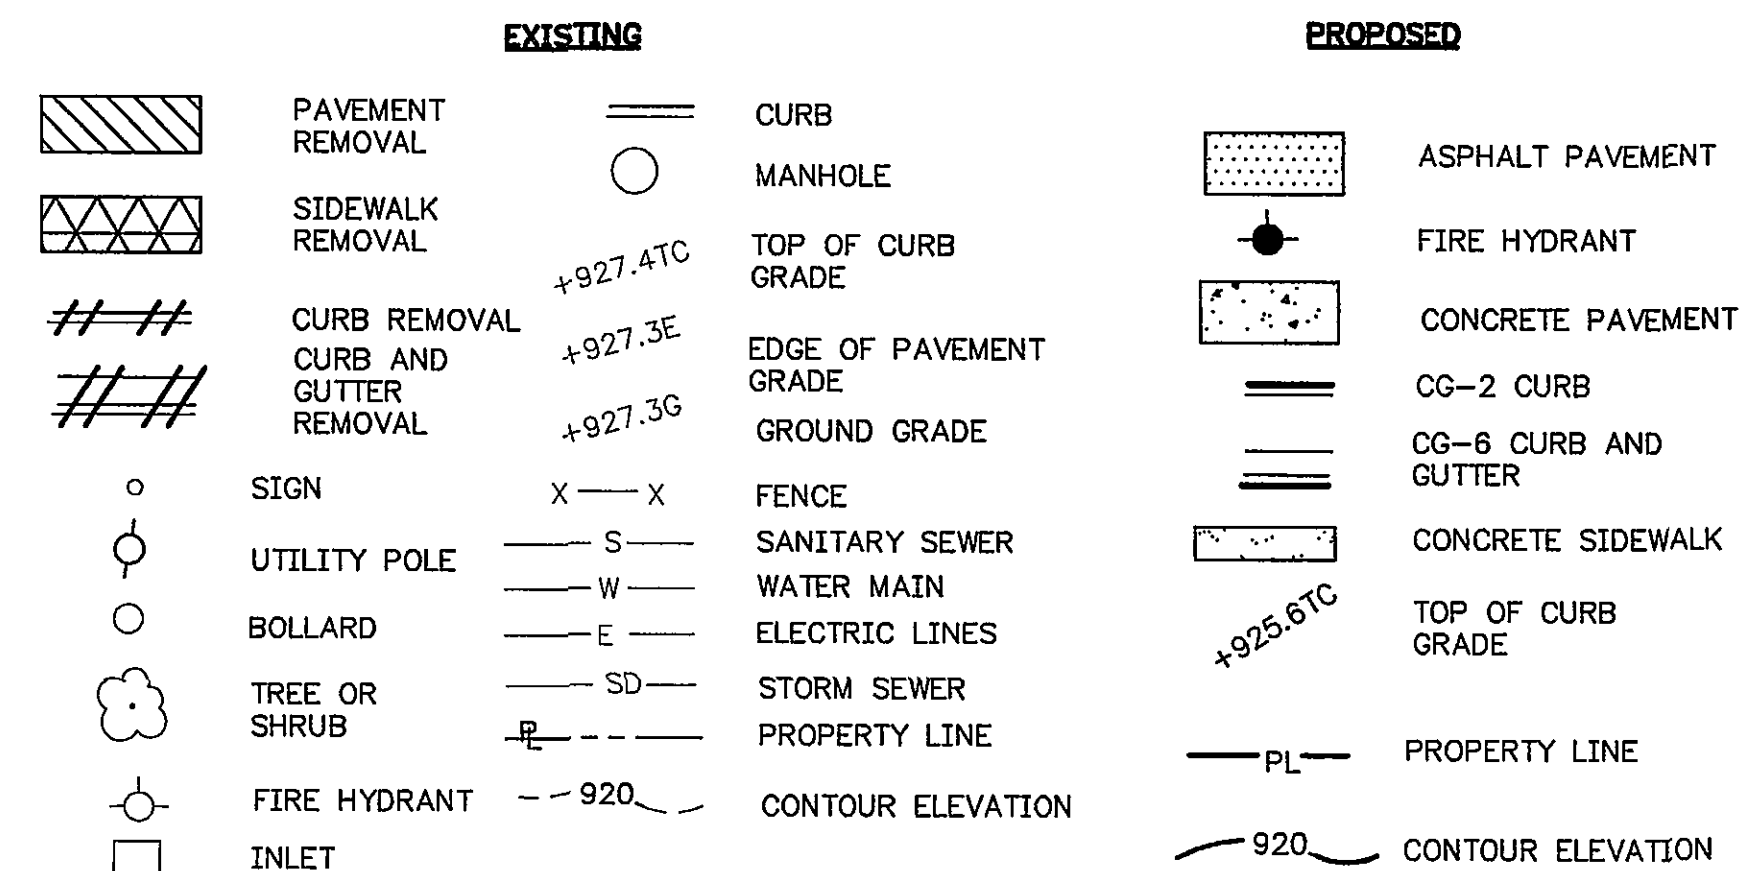

REVISION	DATE	DESCRIPTION		BY APP
DESIGNED	CJL/MGS	CITY OF ROANOKE RAILSIDE LINEAR WALK		
DRAWN	CJL			
CHECKED				
APPROVED				
SUBMITTED				
		SITE PLAN		
HAYES, SEAY, MATTERN & MATTERN, INC.		SCALE 1"=10'	COMM. NO. 7288	SHEET C5
ARCHITECTS — ENGINEERS — PLANNERS ROANOKE, VIRGINIA		DATE AUGUST 1998		