


MATCH LINE E

MATCH LINE F

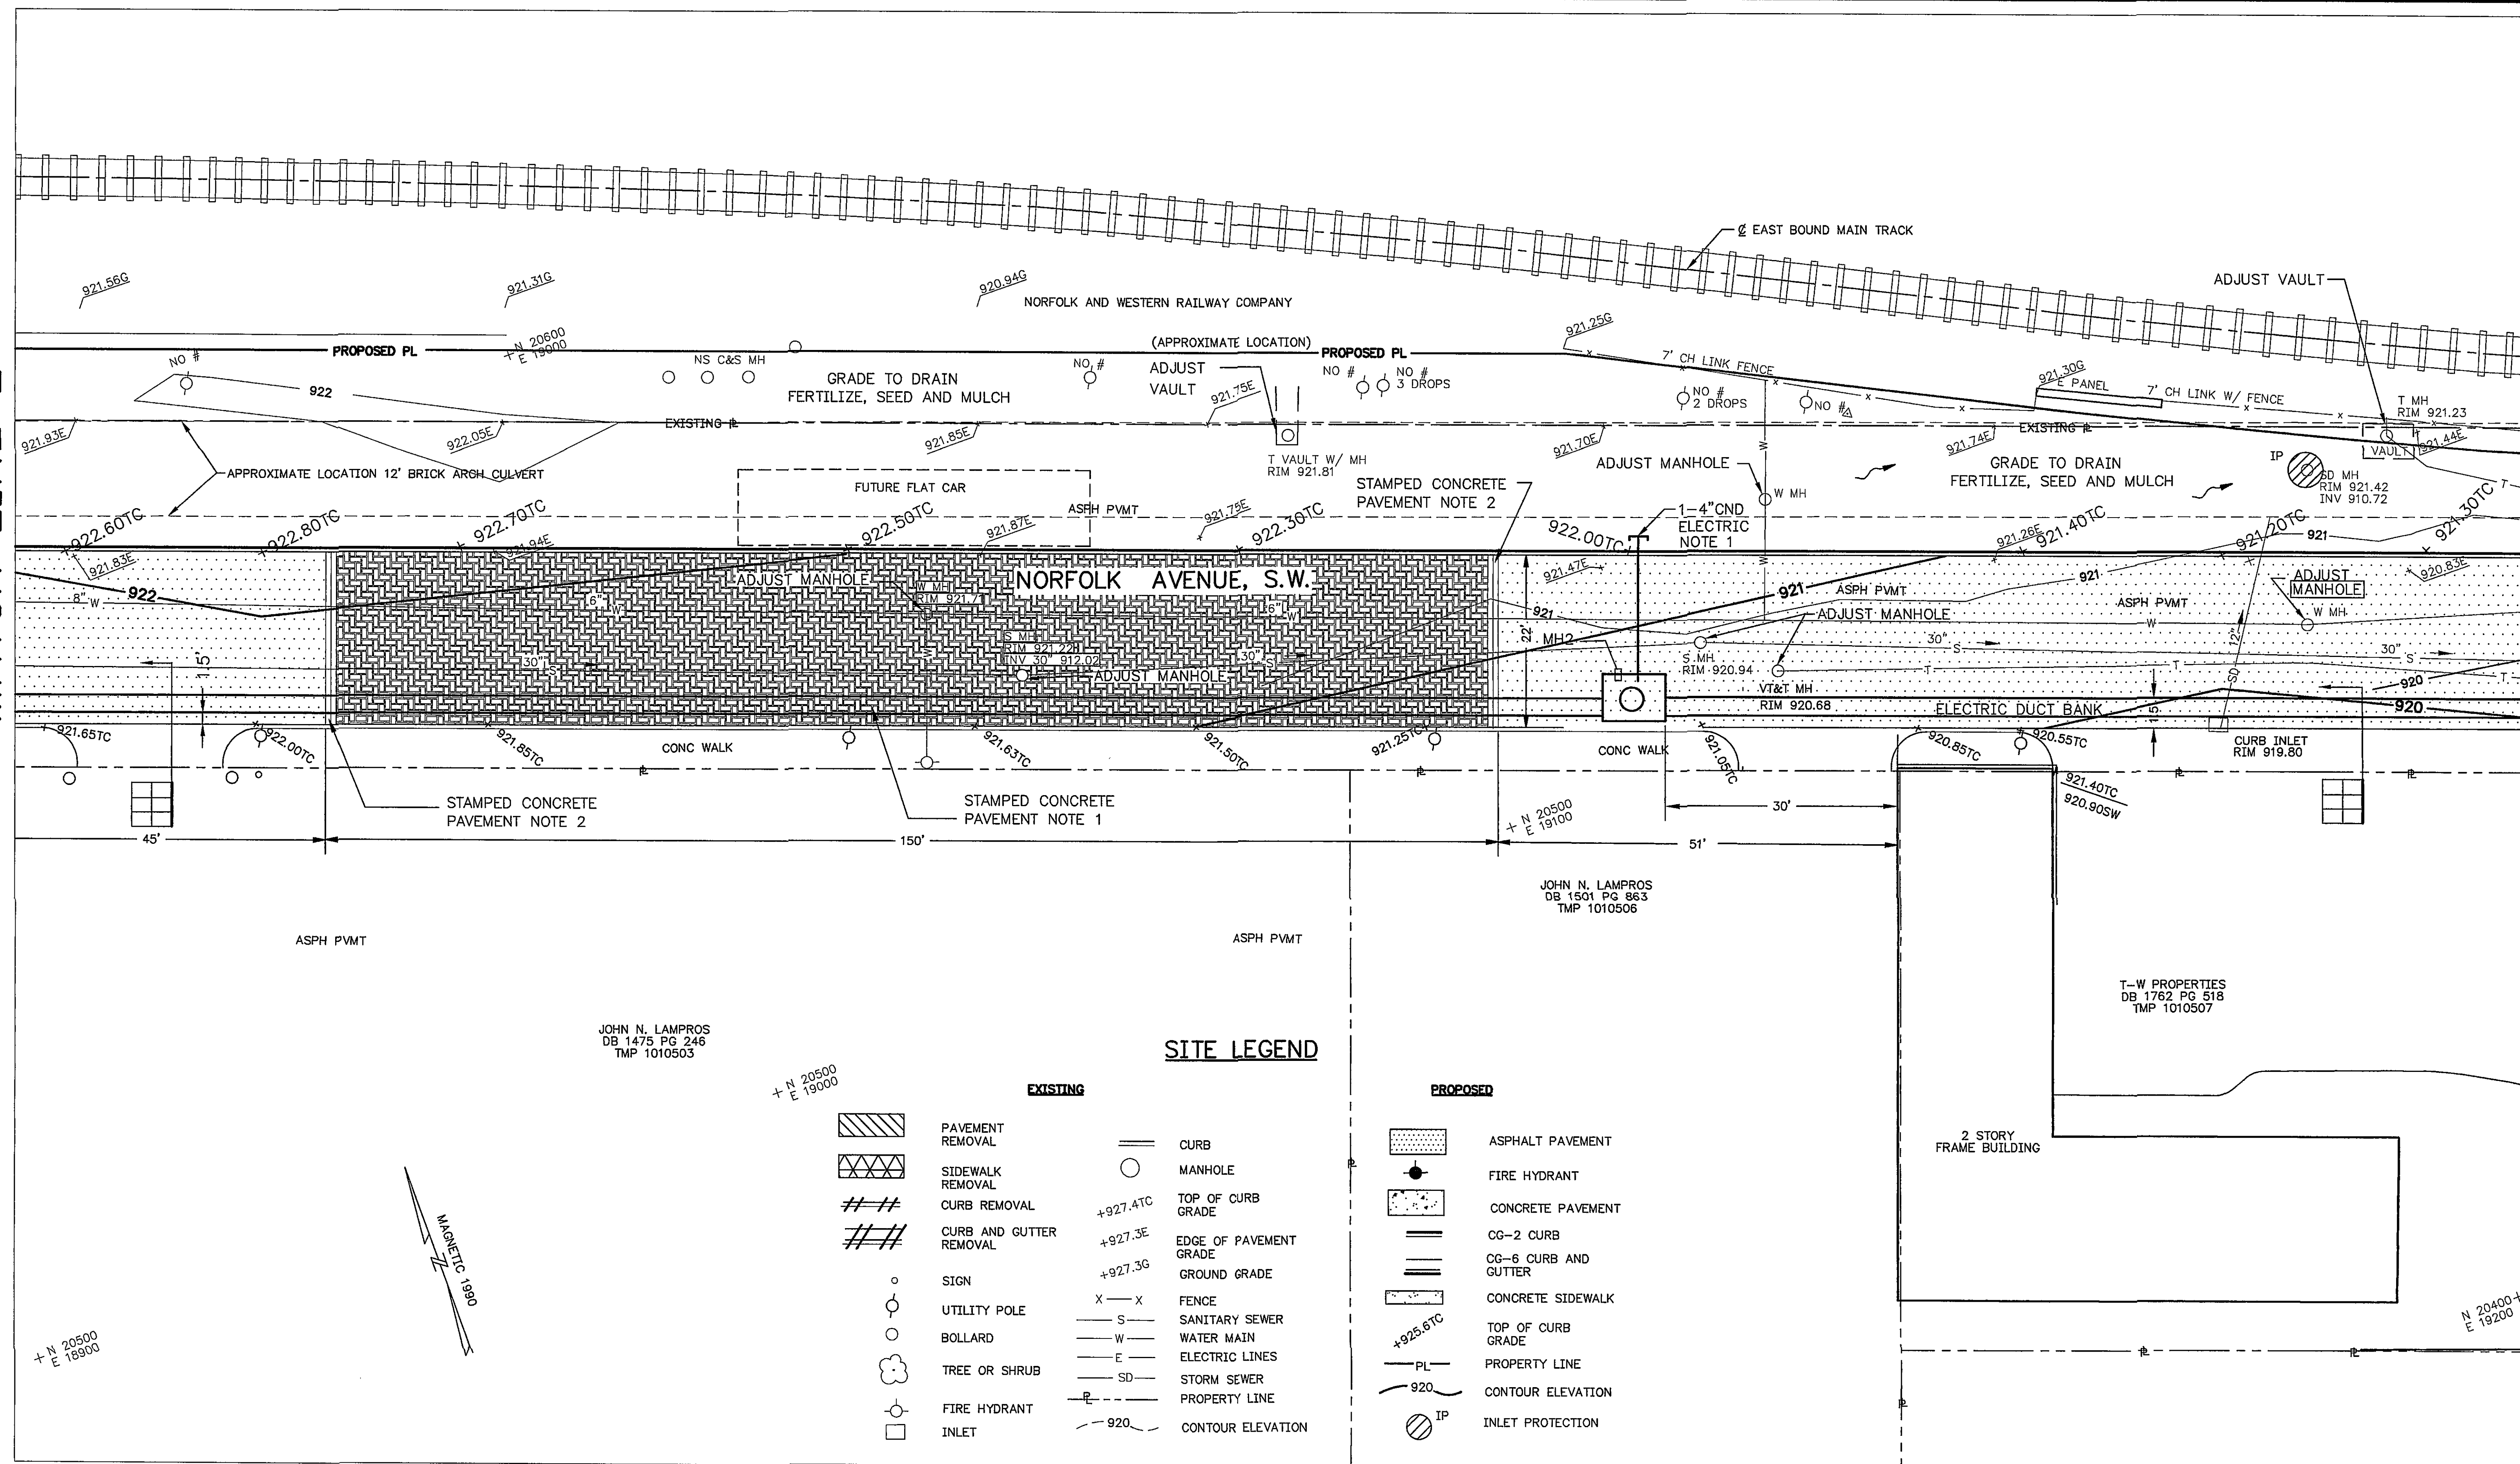

SITE LEGEND


EXISTING		PROPOSED	
	PAVEMENT REMOVAL		ASPHALT PAVEMENT
	SIDEWALK REMOVAL		FIRE HYDRANT
	CURB REMOVAL		CONCRETE PAVEMENT
	CURB AND GUTTER REMOVAL		CG-2 CURB
	SIGN		CG-6 CURB AND GUTTER
	UTILITY POLE		CONCRETE SIDEWALK
	BOLLARD		TOP OF CURB GRADE
	TREE OR SHRUB		PROPERTY LINE
	FIRE HYDRANT		CONTOUR ELEVATION
	INLET		INLET PROTECTION
	CURB		
	MANHOLE		
	TOP OF CURB GRADE		
	EDGE OF PAVEMENT GRADE		
	GROUND GRADE		
	FENCE		
	SANITARY SEWER		
	WATER MAIN		
	ELECTRIC LINES		
	STORM SEWER		
	PROPERTY LINE		
	CONTOUR ELEVATION		

ELECTRIC LEGEND

PROPOSED	
	NUMBER DENOTES FEEDER NUMBER, BLANK DENOTES EMPTY
	BOTTOM OF DUCT BANK
	ELECTRIC DUCT BANK
	CAPPED OFF UNDERGROUND ELECTRIC CONDUIT
	ELECTRIC MANHOLE

STAMPED CONCRETE PAVEMENT NOTES

 - COLOR HARDENER SHALL BE TERRA COTTA
COLOR RELEASE SHALL BE ASH WHITE
PATTERN SHALL BE OLD ENGLISH BRICK 90° BASKET WEAVE
- COLOR HARDENER SHALL BE DARK RED
COLOR RELEASE SHALL BE BRICK RED
PATTERN SHALL BE RUNNING BOND USED BRICK



ELECTRIC NOTES

- EXTEND UNDER GROUND CONDUIT 4' BEYOND CG-2 CURB AND COP OFF FOR FUTURE CONNECTION.
- COORDINATE MANHOLES, DUCT BANK AND CONDUIT ELEVATIONS AND LOCATIONS WITH EXISTING UNDERGROUND UTILITIES.
- SEE SHEET E1 FOR DUCT BANK AND MANHOLE DETAILS.

REVISION	DATE	DESCRIPTION		BY APP
DESIGNED	CJL/MGS	CITY OF ROANOKE RAILSIDE LINEAR WALK		
DRAWN	CJL			
CHECKED		SITE PLAN		
APPROVED				
SUBMITTED				
HAYES, SEAY, MATTERN & MATTERN, INC.		SCALE 1"=10'	COMM. NO.	7288
ARCHITECTS — ENGINEERS — PLANNERS ROANOKE, VIRGINIA		DATE AUGUST 1998	SHEET	C6