
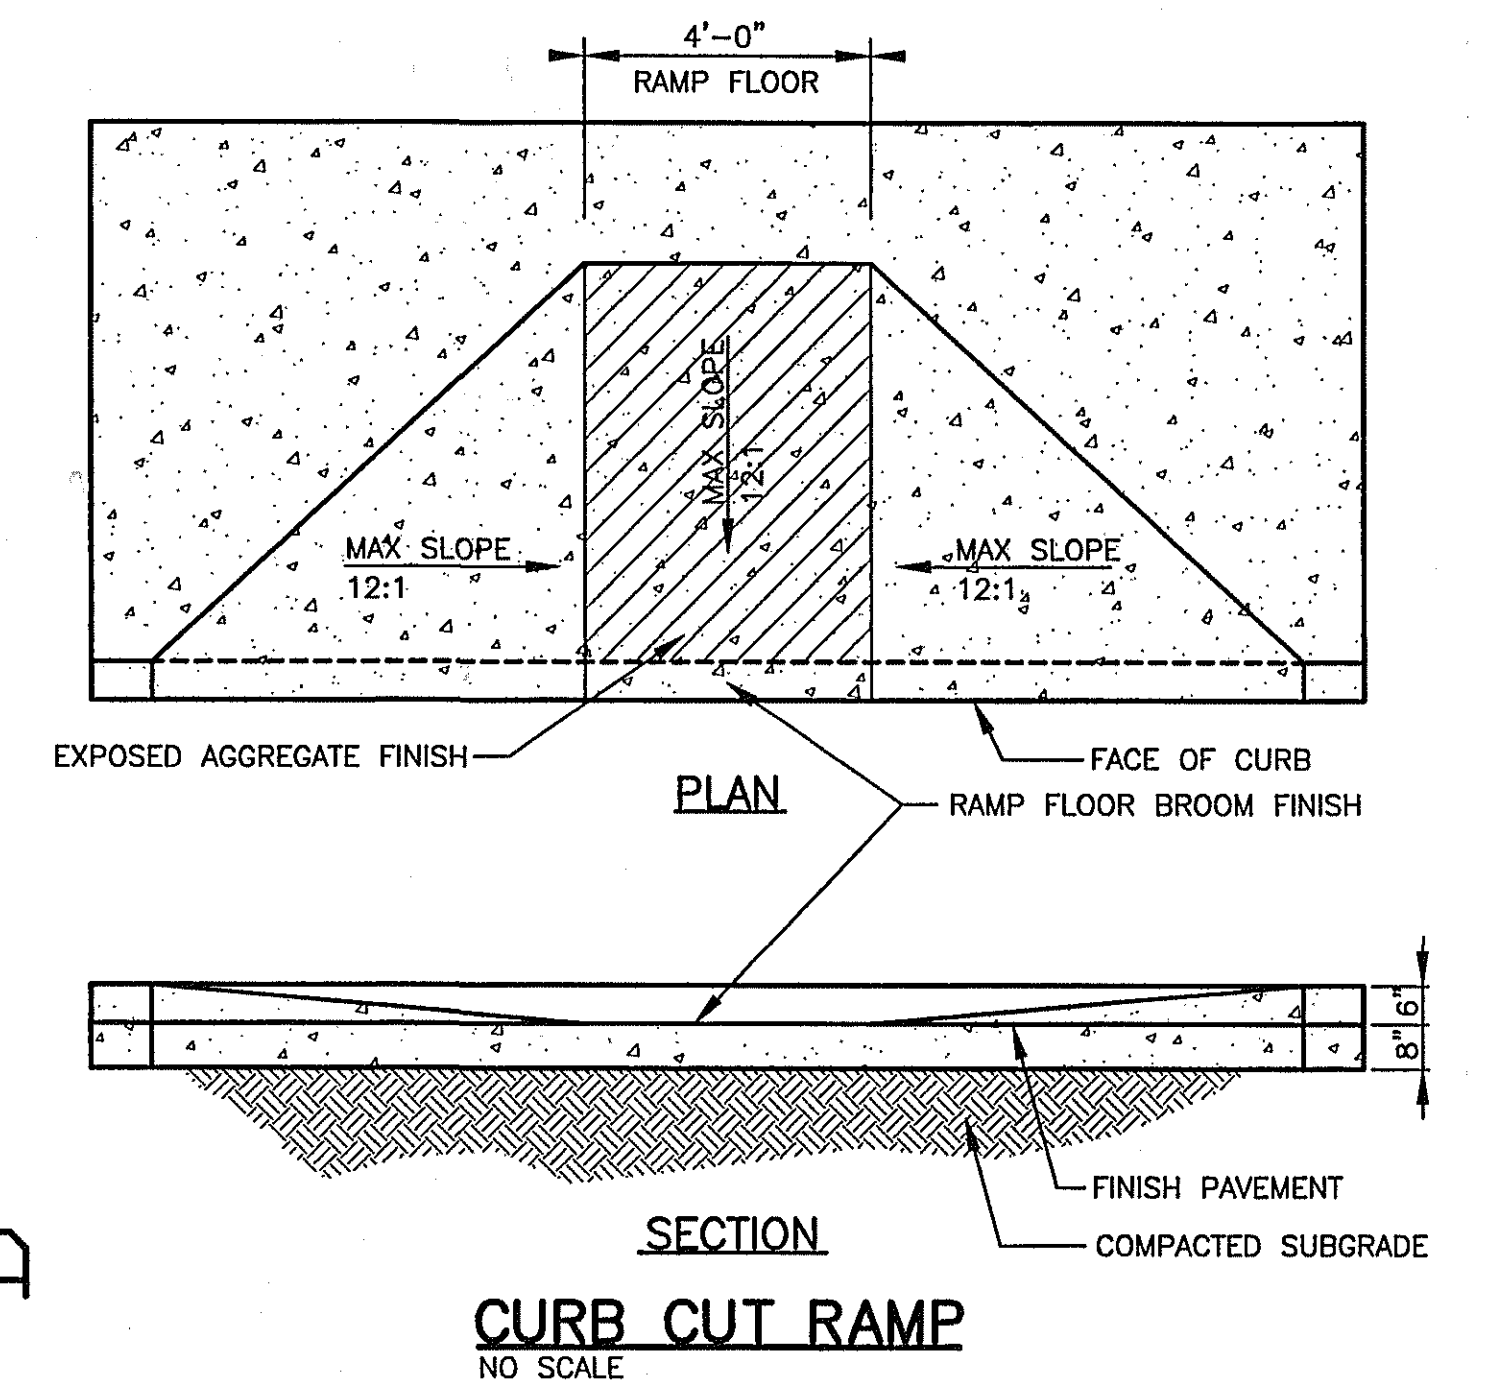


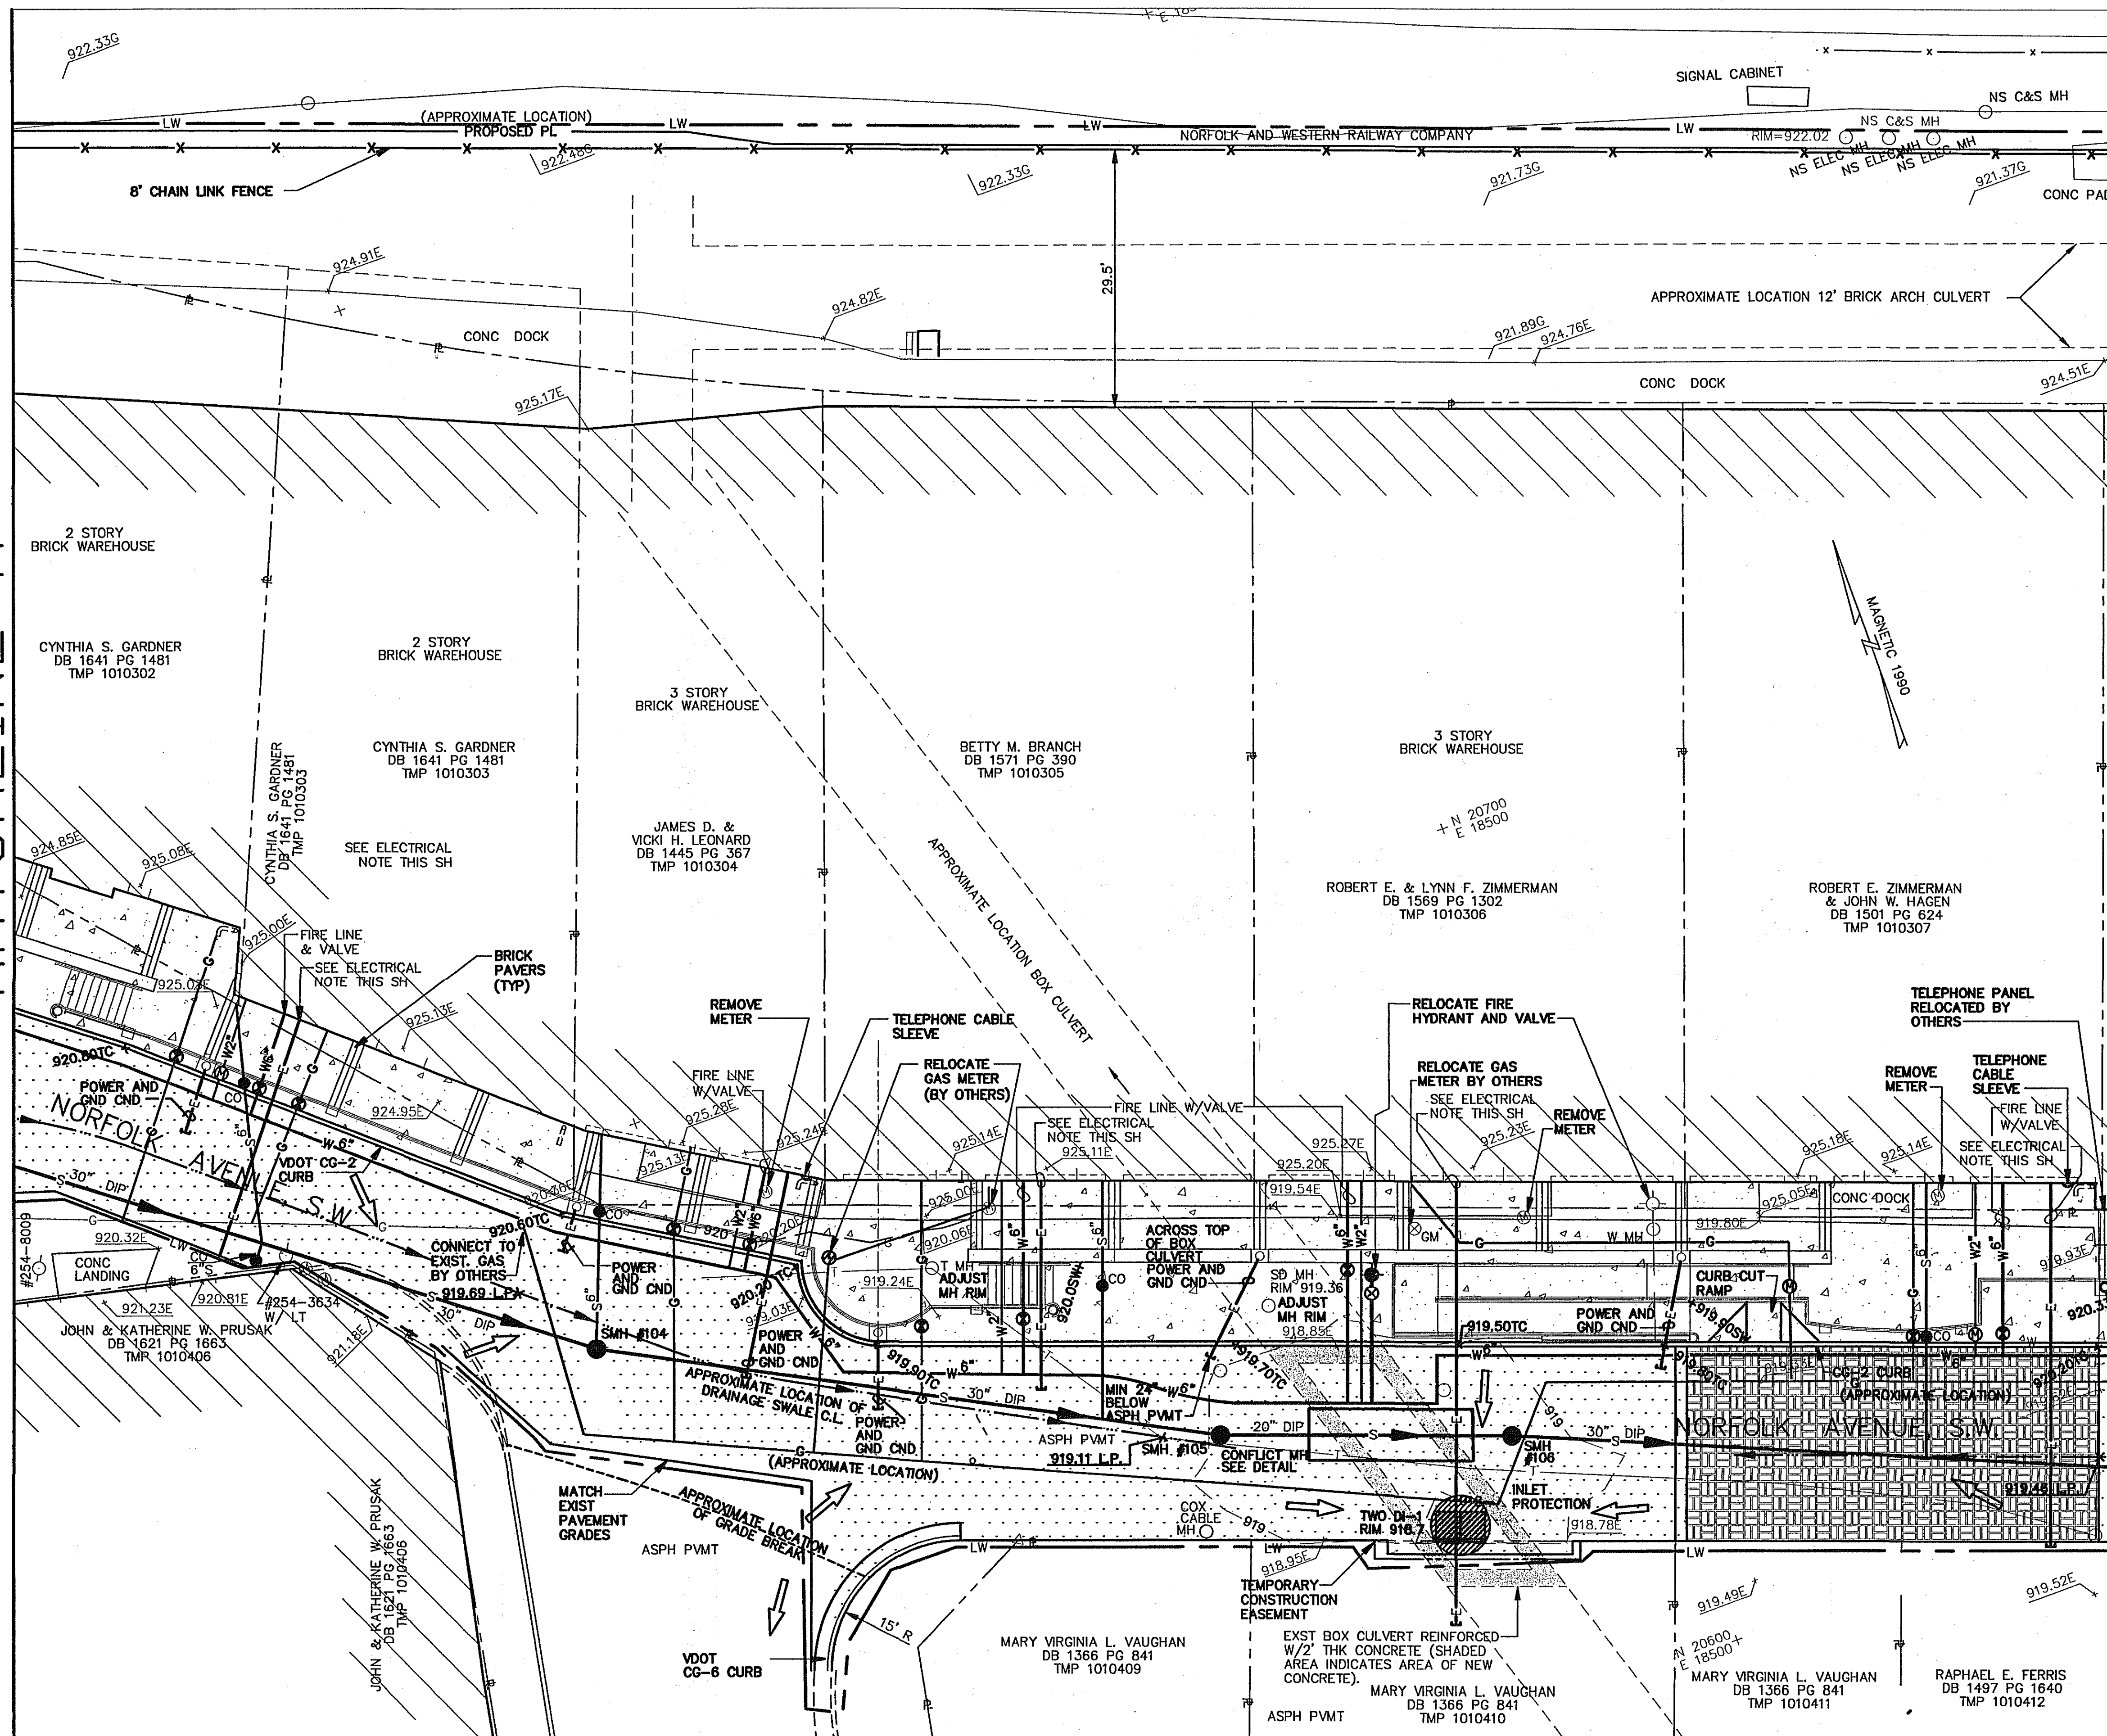

ELECTRICAL NOTE:

AEP ELECTRICAL CONDUITS
LOCATIONS ENTERING WAREHOUSE
CAN BE DETERMINED BY
OBSERVATION IN BASEMENT AREA.

NOTE:

STAMPED CONCRETE SHALL BE 8" THICK CONCRETE
AND 6" AGGREGATE BASE MATERIAL, TYPE I, SIZE NO. 21A,
OR 21B.

SEE SHEET C1 FOR GENERAL NOTES AND SHEET G3 FOR
LEGEND.

SEE ARCHITECTURAL SHEET FOR ADDITIONAL LAYOUT
INFORMATION.

SEE STRUCTURAL SHEETS FOR SIDEWALK ELEVATIONS.

 
SEE SANITARY SEWER PROFILE FOR SANITARY SEWER
INVERT ELEVATIONS.

SEE SHEET A5 FOR SECTION SHOWING GROUND CONDUIT
(GND CND) AND POWER CONDUIT (PWR CND).

TELEPHONE CABLE SLEEVE TO BE FURNISHED BY
VERIZON AND INSTALLED BY THE CONTRACTOR.

CONTRACTOR SHALL MATCH EXST. DRAINAGE PATTERNS
USING DRAINAGE SWALE IN PVMT. (APPROX. LOCATION
SHOWN).

GRAPHIC SCALE



	NOV 2003	AS-BUILTS	TSP	
REVISION	DATE	DESCRIPTION	BY	APP
DESIGNED	CJL	CITY OF ROANOKE RAILSIDE LINEAR WALK PHASE V CIVIL SITE PLAN		
DRAWN	CJL			
CHECKED	MDJ			
APPROVED	MDJ			
SUBMITTED	MB			
HAYES, SEAY, MATTERN & MATTERN, INC.		SCALE	COMM. NO.	
ARCHITECTS — ENGINEERS — PLANNERS		1"=10'	7288	
ROANOKE, VIRGINIA		DATE	SHEET	
		AUG. 3, 2001		C5