

ARCH E 30' x 48'


Approved:

Checked:

Designer:

Project Management Initials:

THIS DRAWING IS THE PROPERTY OF AECOM. IT IS TO BE USED ONLY FOR THE PROJECT AND SITE SPECIFICALLY IDENTIFIED HEREON. IT IS NOT TO BE REPRODUCED, COPIED, OR TRANSMITTED IN ANY FORM OR BY ANY MEANS, ELECTRONIC OR MECHANICAL, INCLUDING PHOTOCOPYING, RECORDING, OR BY ANY INFORMATION STORAGE AND RETRIEVAL SYSTEM, WITHOUT THE WRITTEN PERMISSION OF AECOM. AECOM AND ITS EMPLOYEES SHALL NOT BE LIABLE FOR ANY DAMAGE OR LOSS OF ANY KIND, INCLUDING REASONABLE ATTORNEY'S FEES, ARISING OUT OF OR IN CONNECTION WITH THE PERFORMANCE OF SERVICES UNDER THIS AGREEMENT.

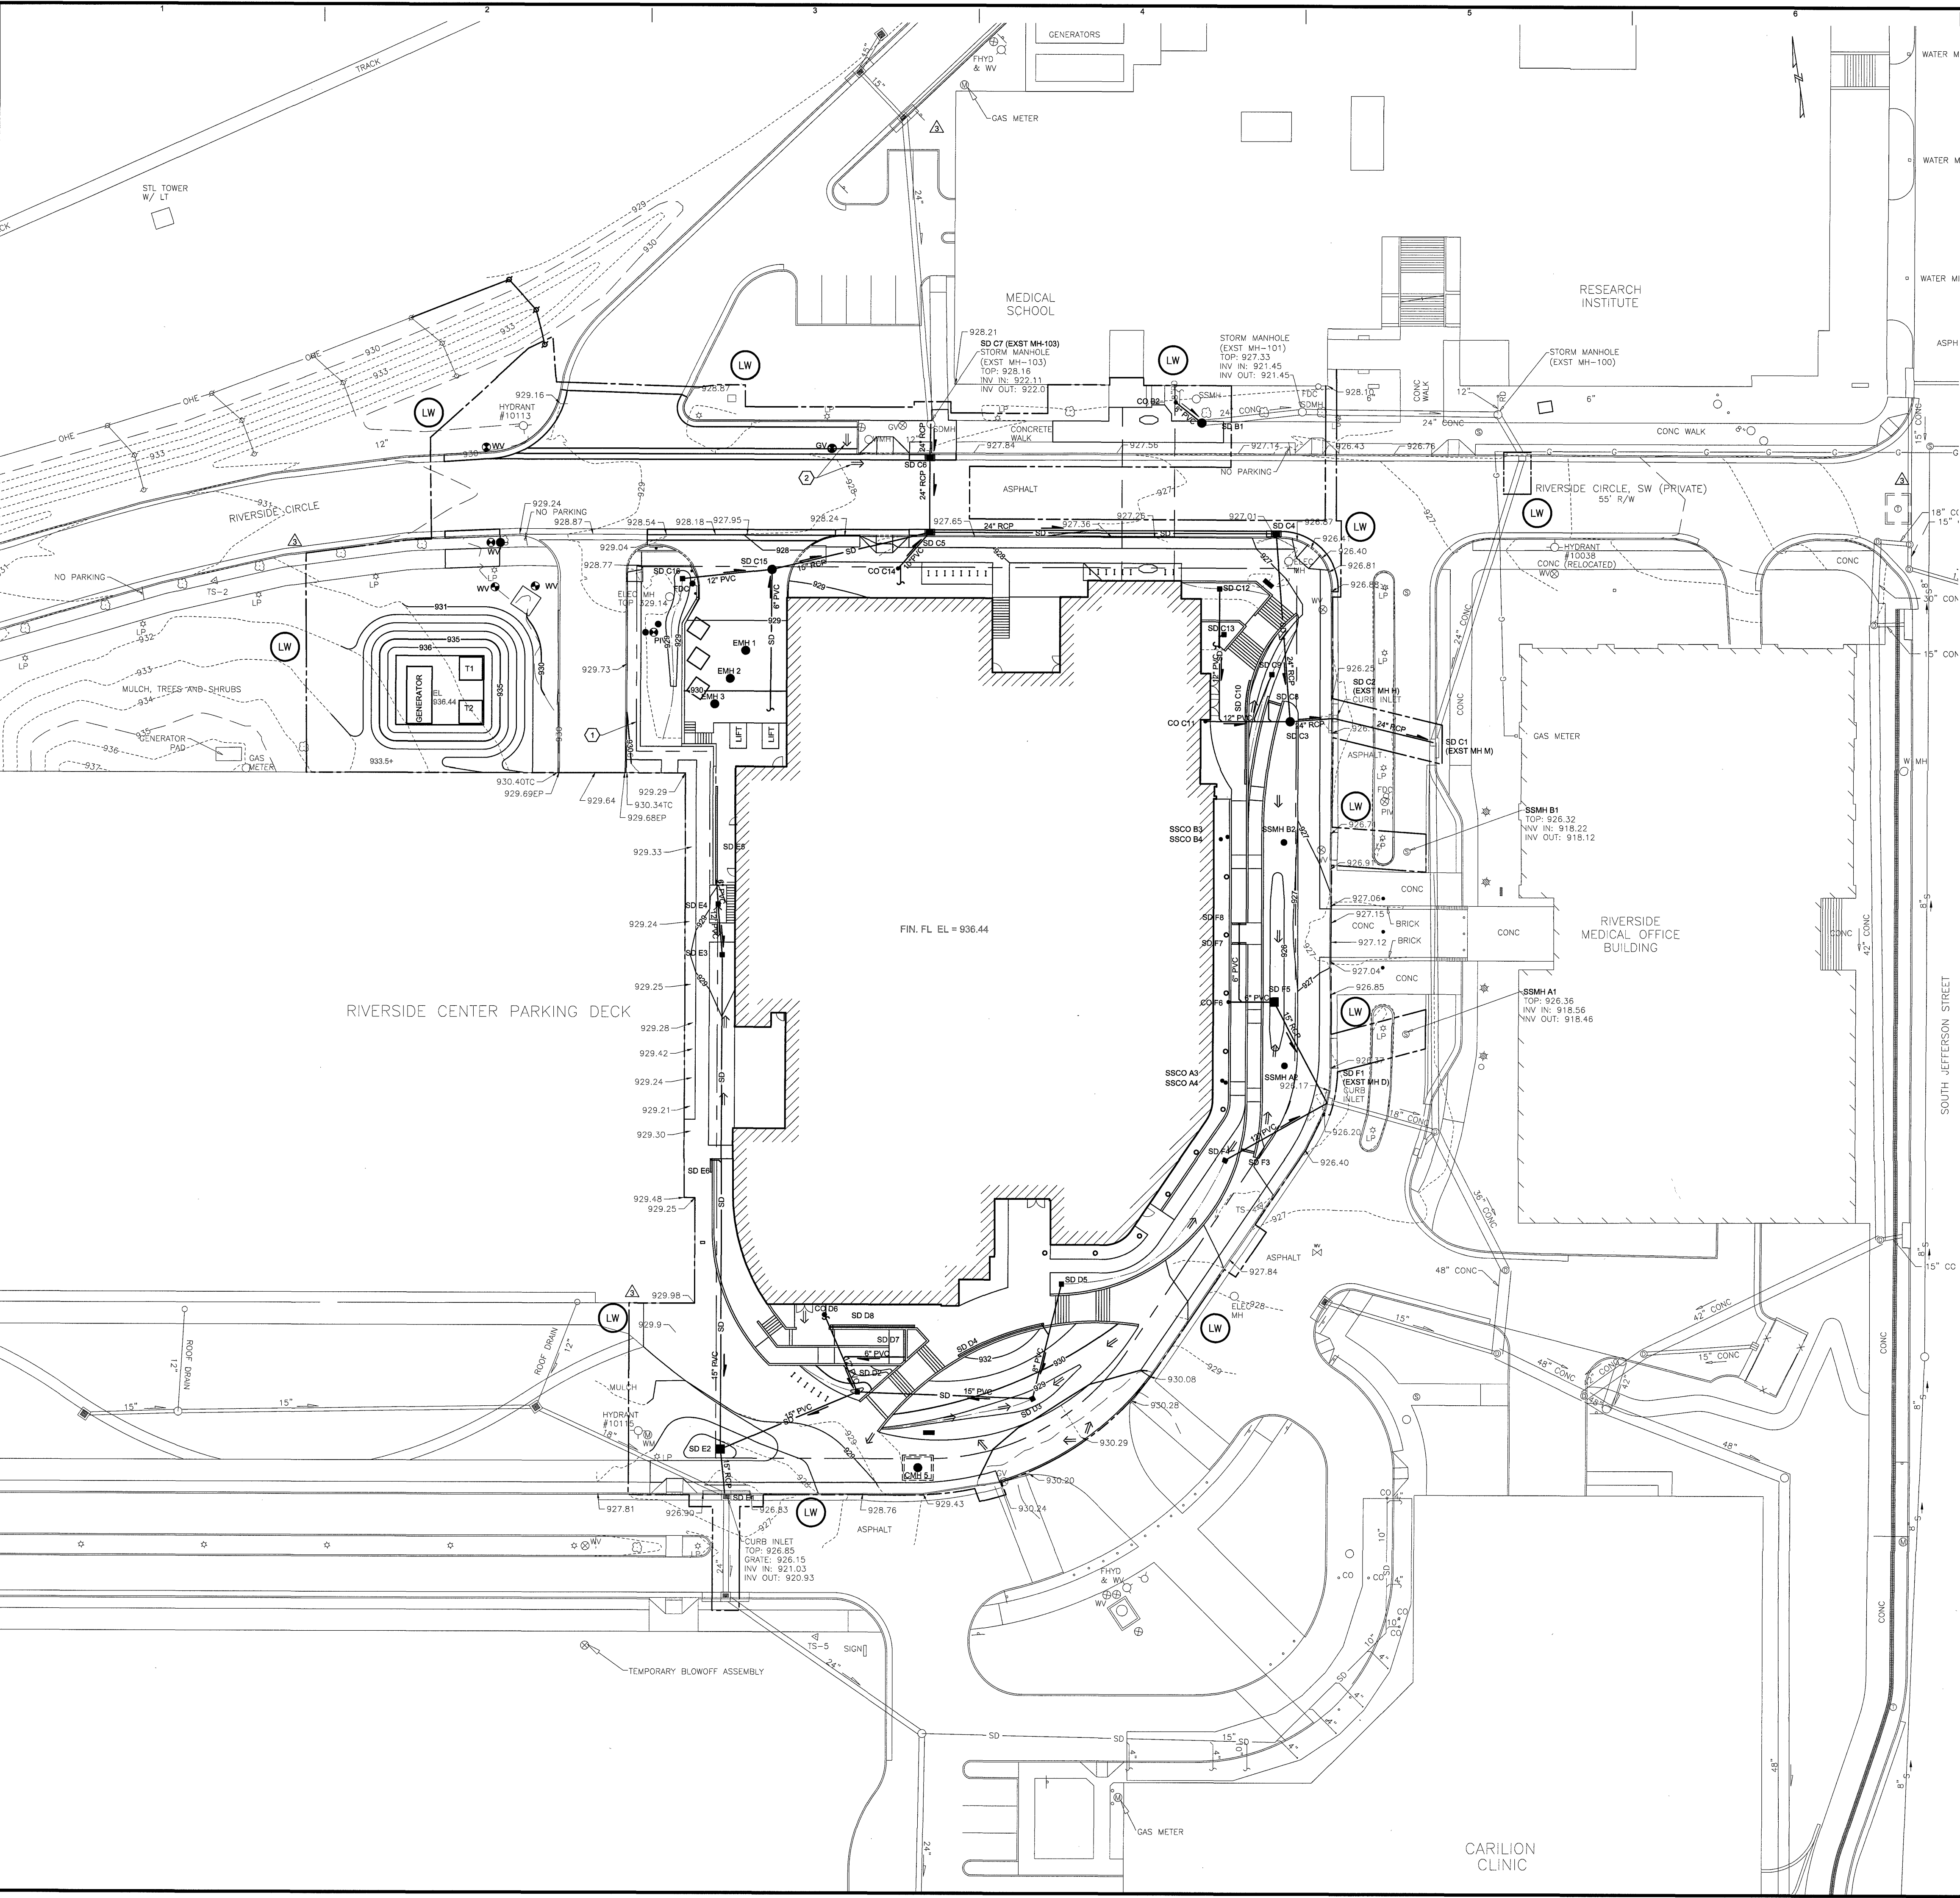


GENERAL NOTES THIS SHEET:

- SEE SHEET C-001 FOR CIVIL NOTES, ABBREVIATIONS, AND LEGEND.
- SEE COORDINATE POINT DIAGRAMS ON SHEET C-001 FOR BENCHMARK ELEVATION INFORMATION.
- PROJECT SITE LIES IN H.U.D. FLOOD HAZARD ZONE AE COMMUNITY PANEL NO. 51101C0184G, DATED SEPTEMBER 28, 2007. THE 100-YEAR FLOODPLAIN ELEVATION AT THE PROJECT SITE IS 934.44 FEET.
- THE BUILDING FINISH FLOOR ELEVATION AND THE ELEVATION OF GENERATOR AND TRANSFORMER PAD IS SET AT LEAST TWO FEET ABOVE THE 100-YEAR FLOOD PLAIN ELEVATION.
- REINFORCED CONCRETE PIPE (RCP) IS CLASS 3, UNLESS NOTED OTHERWISE.

SHEET KEYNOTES:

 - PROPERTY LINE (TYPICAL).
- PROVIDE POSITIVE DRAINAGE.



AECOM

PROJECT

VIRGINIA TECH CARILION (VTC)
BIOMEDICAL RESEARCH
EXPANSION

VIRGINIA TECH
4 RIVERSIDE CIRCLE
ROANOKE, VA 24016
CLIENT

CARILIONCLINIC
213 MCCLANAHAN ST. S.W.,
THIRD FLOOR
ROANOKE, VA 24014
PHONE: 840-981-7024

VIRGINIA TECH.

Virginia-Maryland
College of Veterinary Medicine

CONSULTANT


AECOM
10 South Jefferson Street, Suite 1600
Roanoke, Virginia 24011
840.857.3100 tel. 840.857.3180 fax
www.aecom.com

SLAM
www.slamcoil.com

Wagner Architecture, pllc
1000 N. JEFFERSON ST., SUITE 100
ROANOKE, VA 24011

**HILL
STUDIO**

REGISTRATION

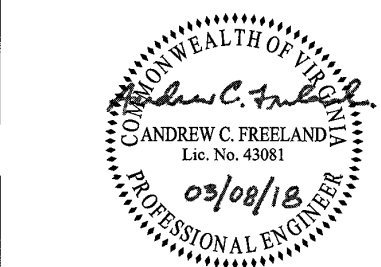

ISSUE/REVISION

NO.	DATE	DESCRIPTION
4	03/09/2018	CITY CP SUBMISSION
3	02/09/2018	SI-G2 REVISED FOUNDATION
2	01/19/2018	CITY CP SUBMISSION
1	12/04/2017	FOR PRESUBMISSION MEETING
0	12/01/2017	FOUNDATION SUBMISSION
IR1		DATE DESCRIPTION

KEY PLAN

PROJECT NUMBER

60544603

SHEET TITLE

GRADING PLAN

SHEET NUMBER

C-104