

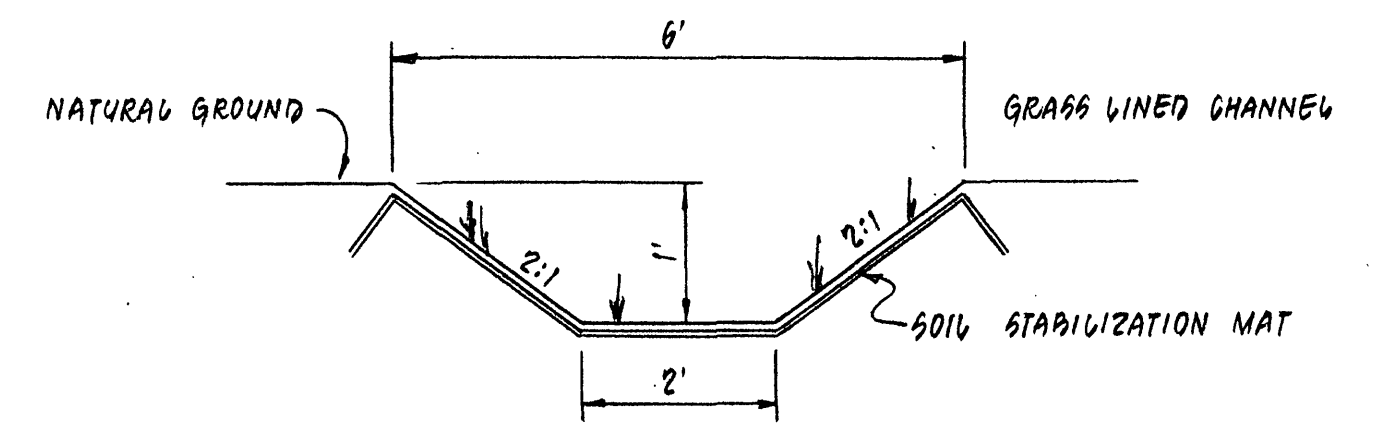
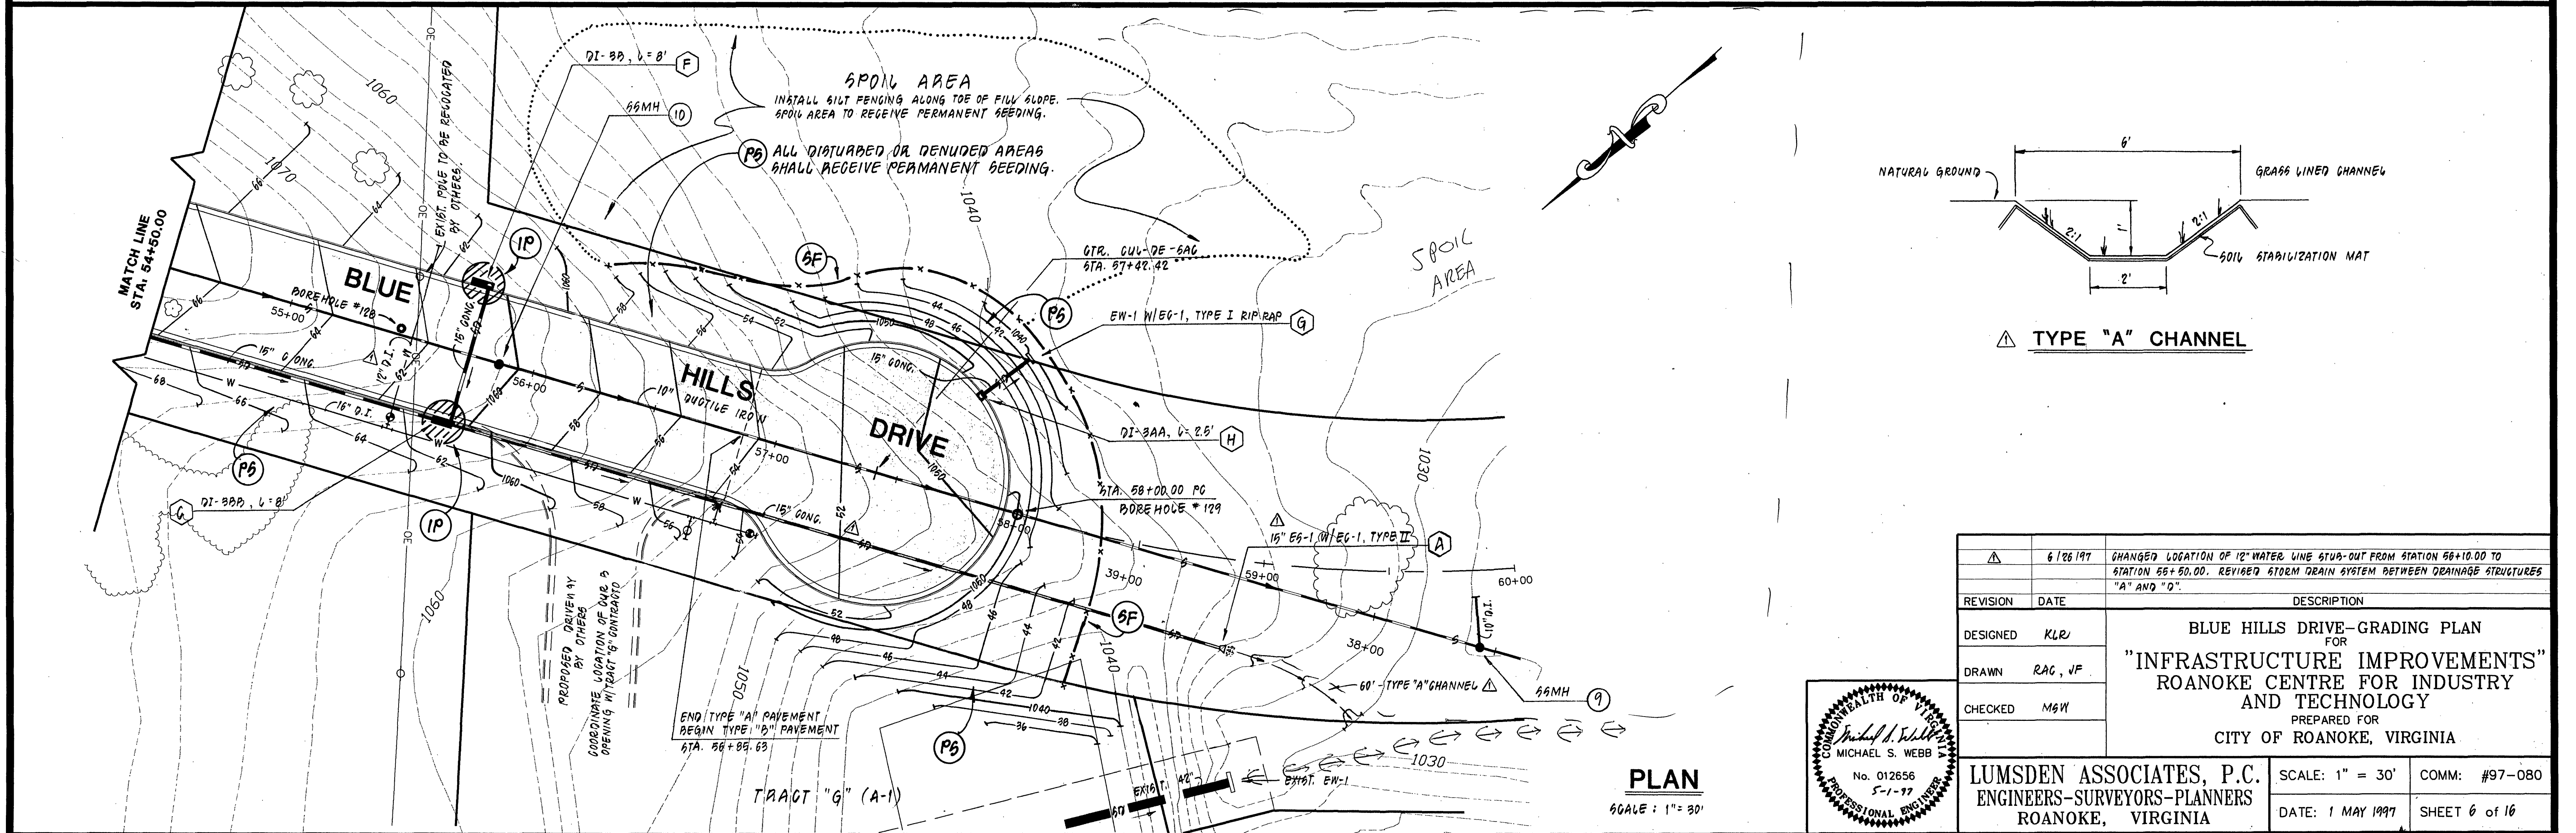


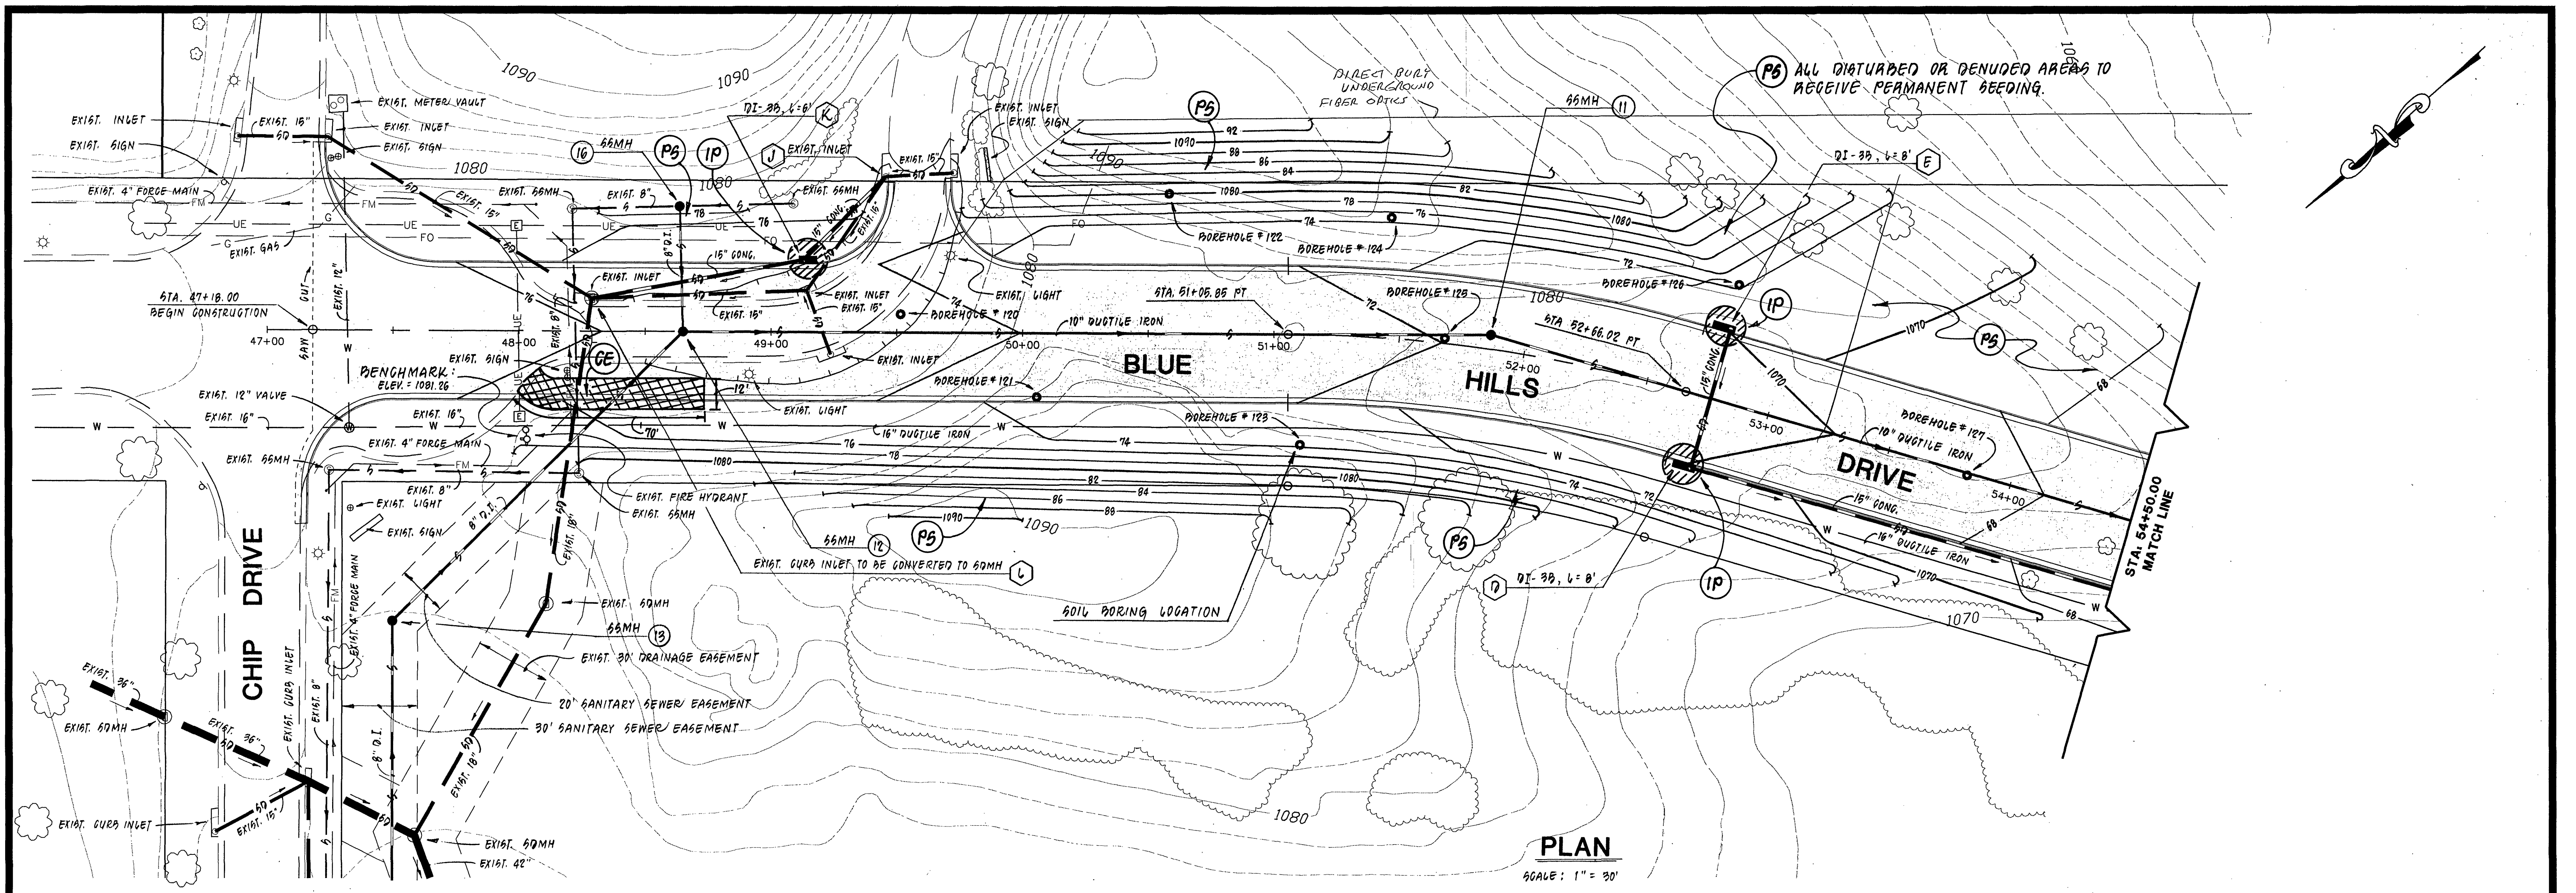

TYPE "A" CHANNEL

REVISION	DATE	DESCRIPTION
1	6/26/97	CHANGED LOCATION OF 12" WATER LINE SUB-OUT FROM STATION 56+10.00 TO STATION 56+50.00. REVISED STORM DRAIN SYSTEM BETWEEN DRAINAGE STRUCTURES "A" AND "D".
DESIGNED	KLR	BLUE HILLS DRIVE-GRADING PLAN FOR "INFRASTRUCTURE IMPROVEMENTS" ROANOKE CENTRE FOR INDUSTRY AND TECHNOLOGY PREPARED FOR CITY OF ROANOKE, VIRGINIA
DRAWN	RAG, JF	
CHECKED	MHW	

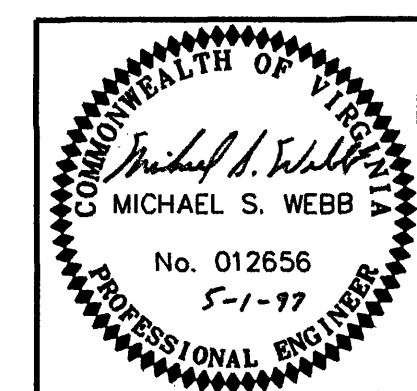

LUMSDEN ASSOCIATES, P.C.
ENGINEERS-SURVEYORS-PLANNERS
ROANOKE, VIRGINIA

SCALE: 1" = 30'
 DATE: 1 MAY 1997
 COMM: #97-080
 SHEET 6 of 16