

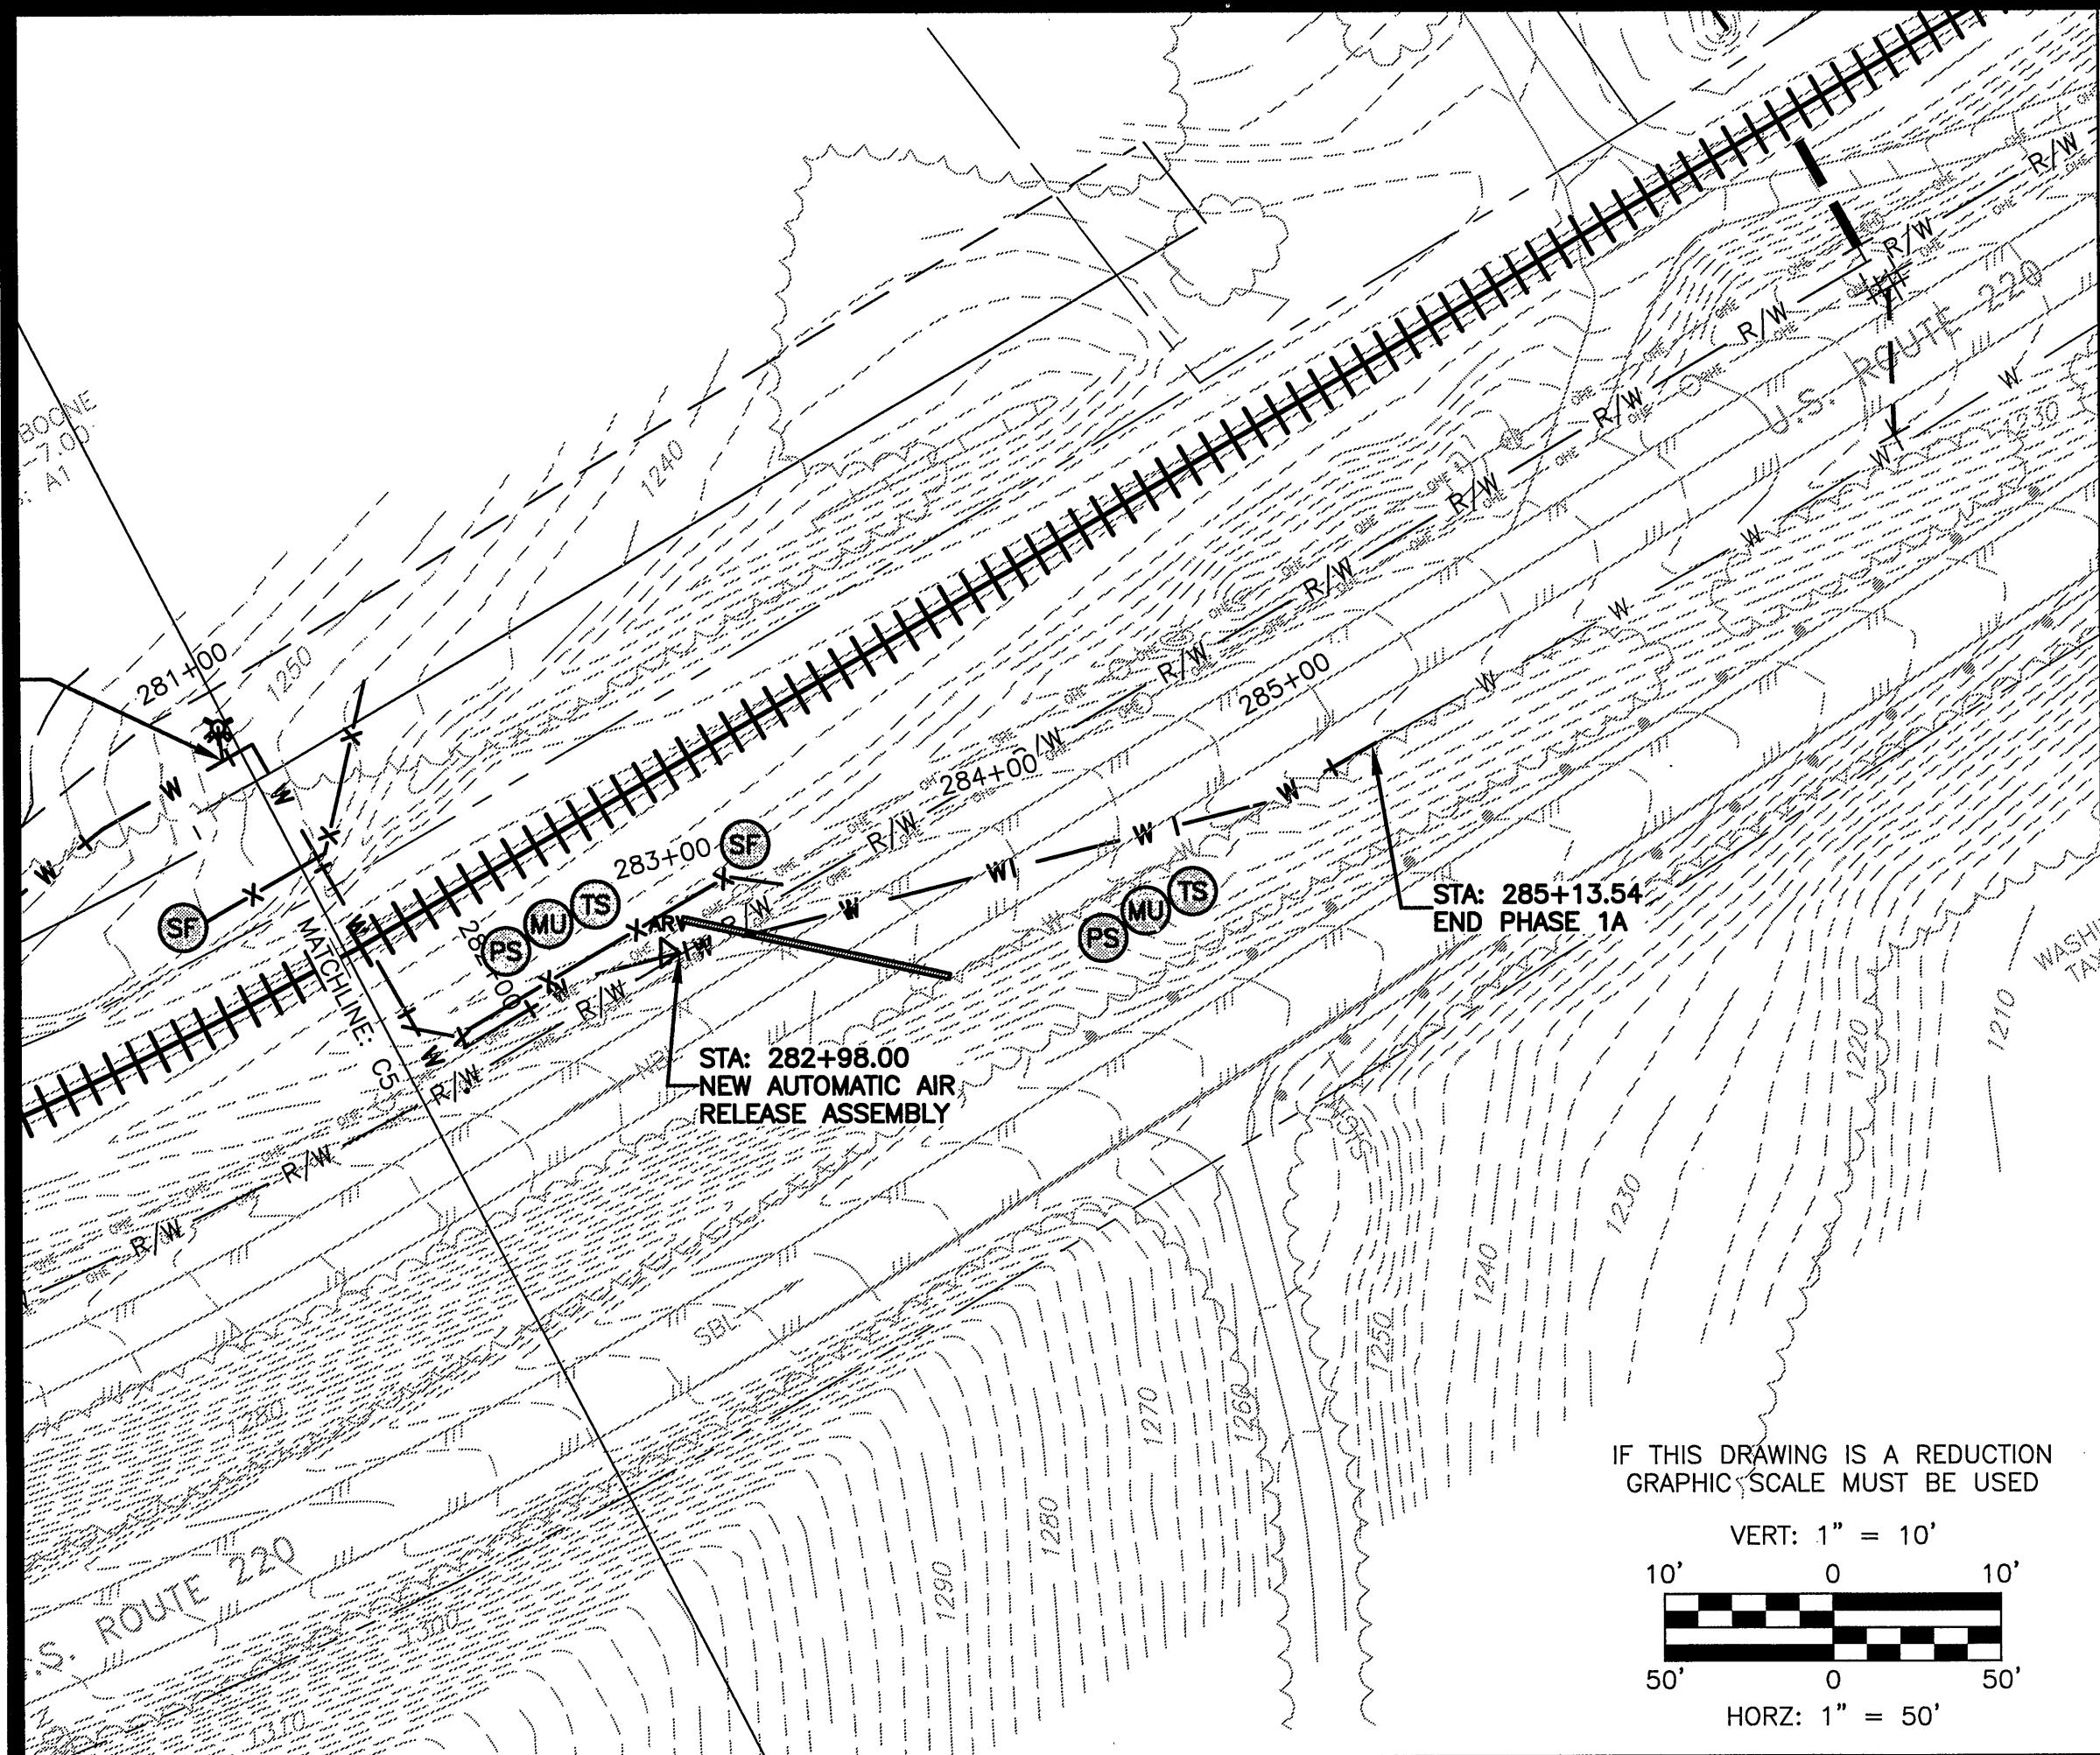
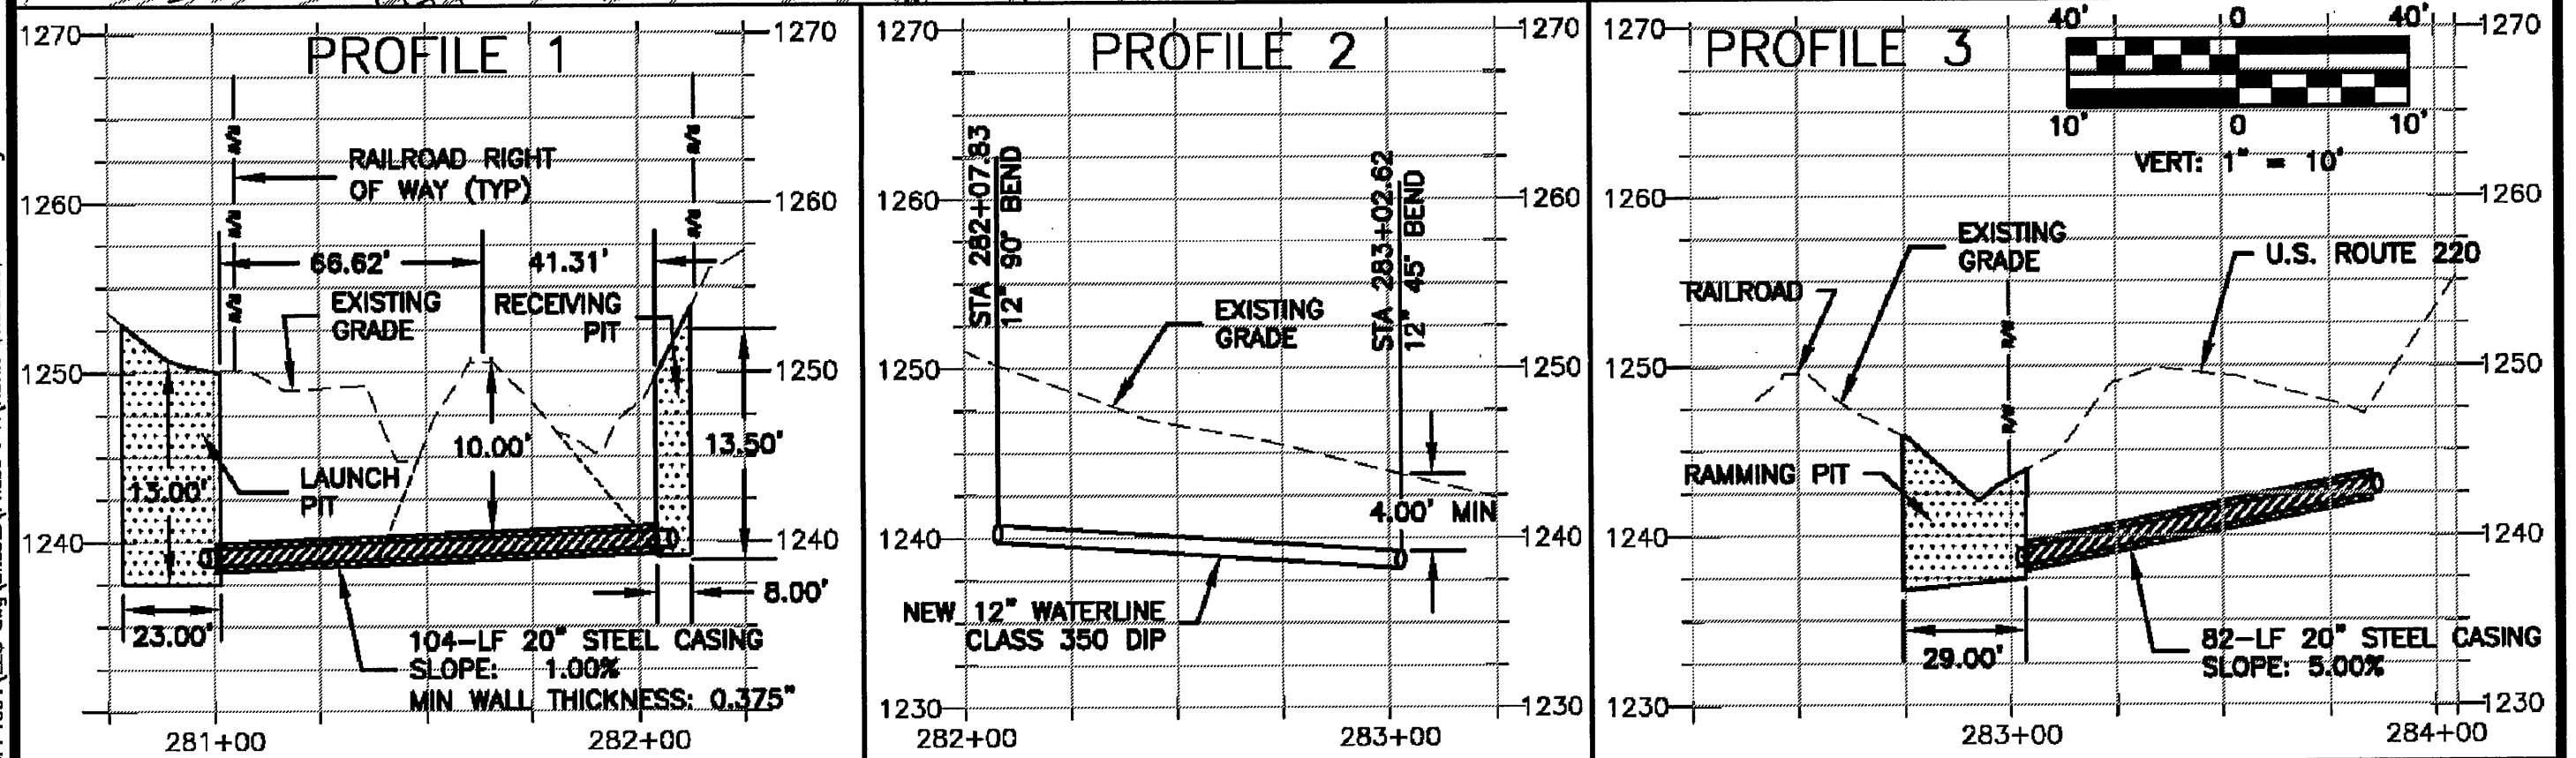


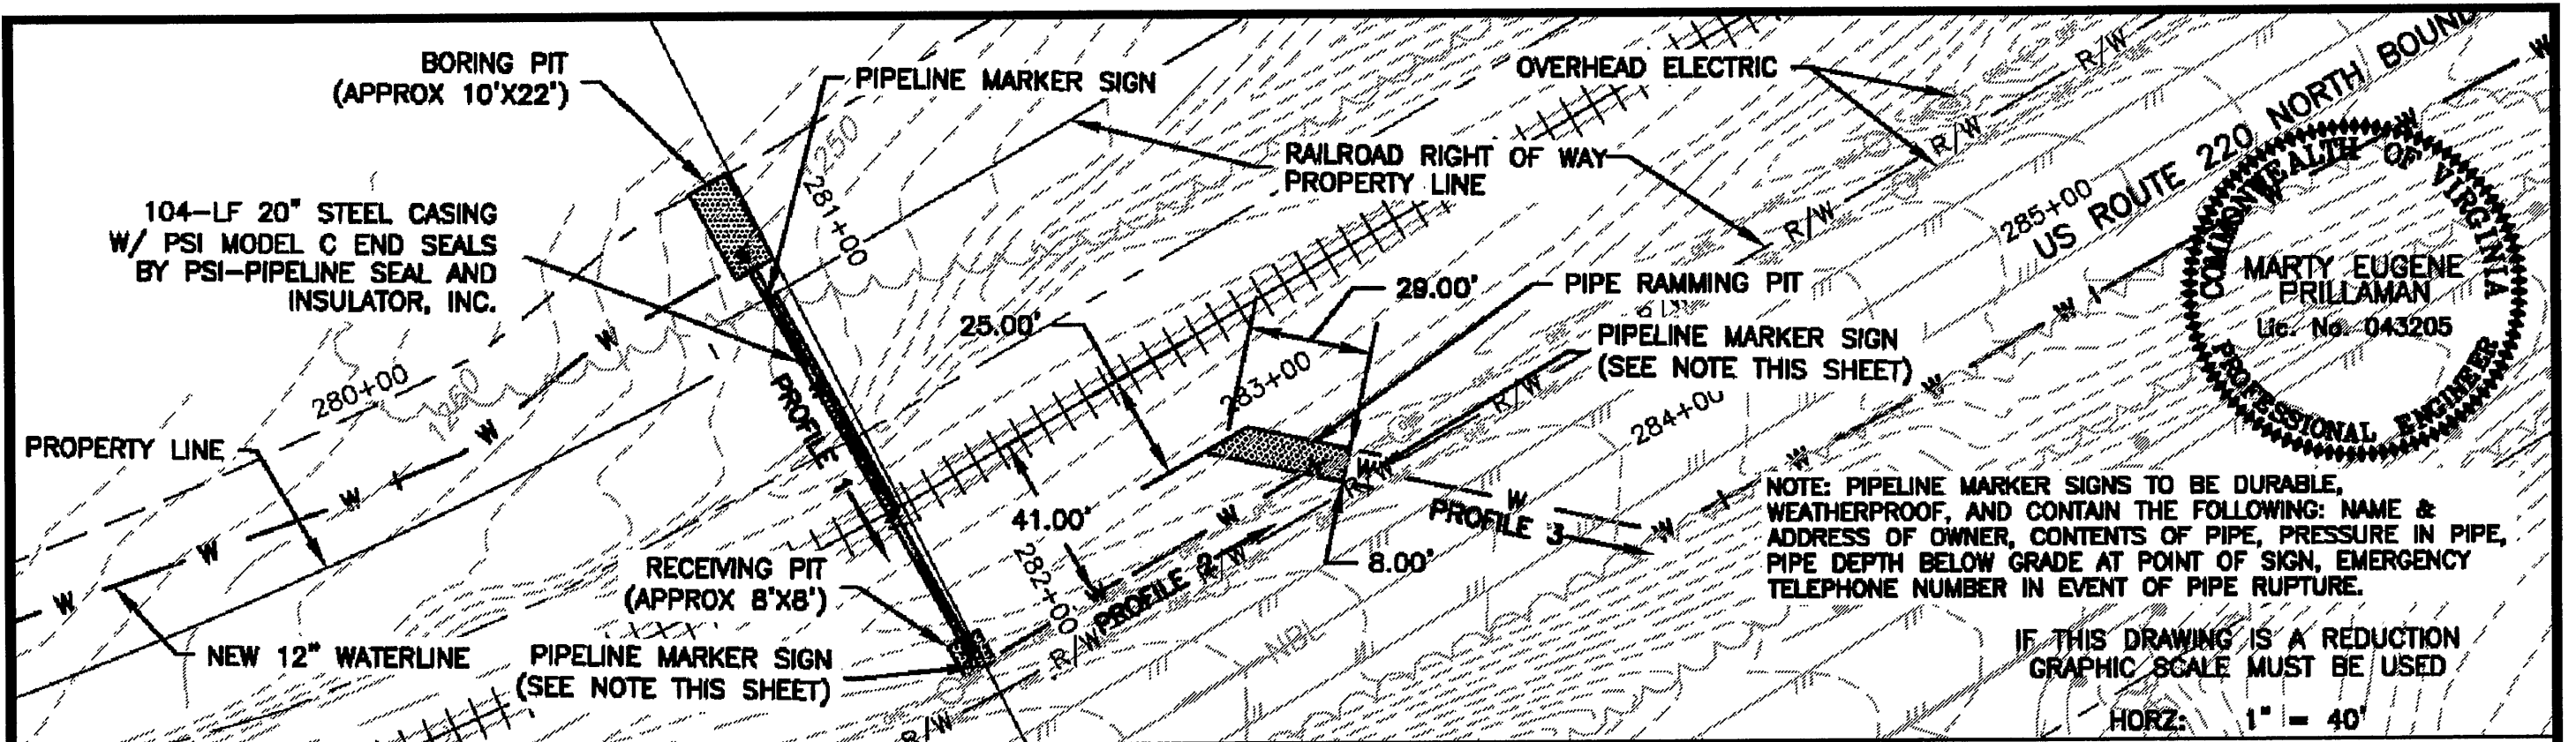



IF THIS DRAWING IS A REDUCTION GRAPHIC SCALE MUST BE USED
VERT: 1" = 10'
HORIZ: 1" = 50'

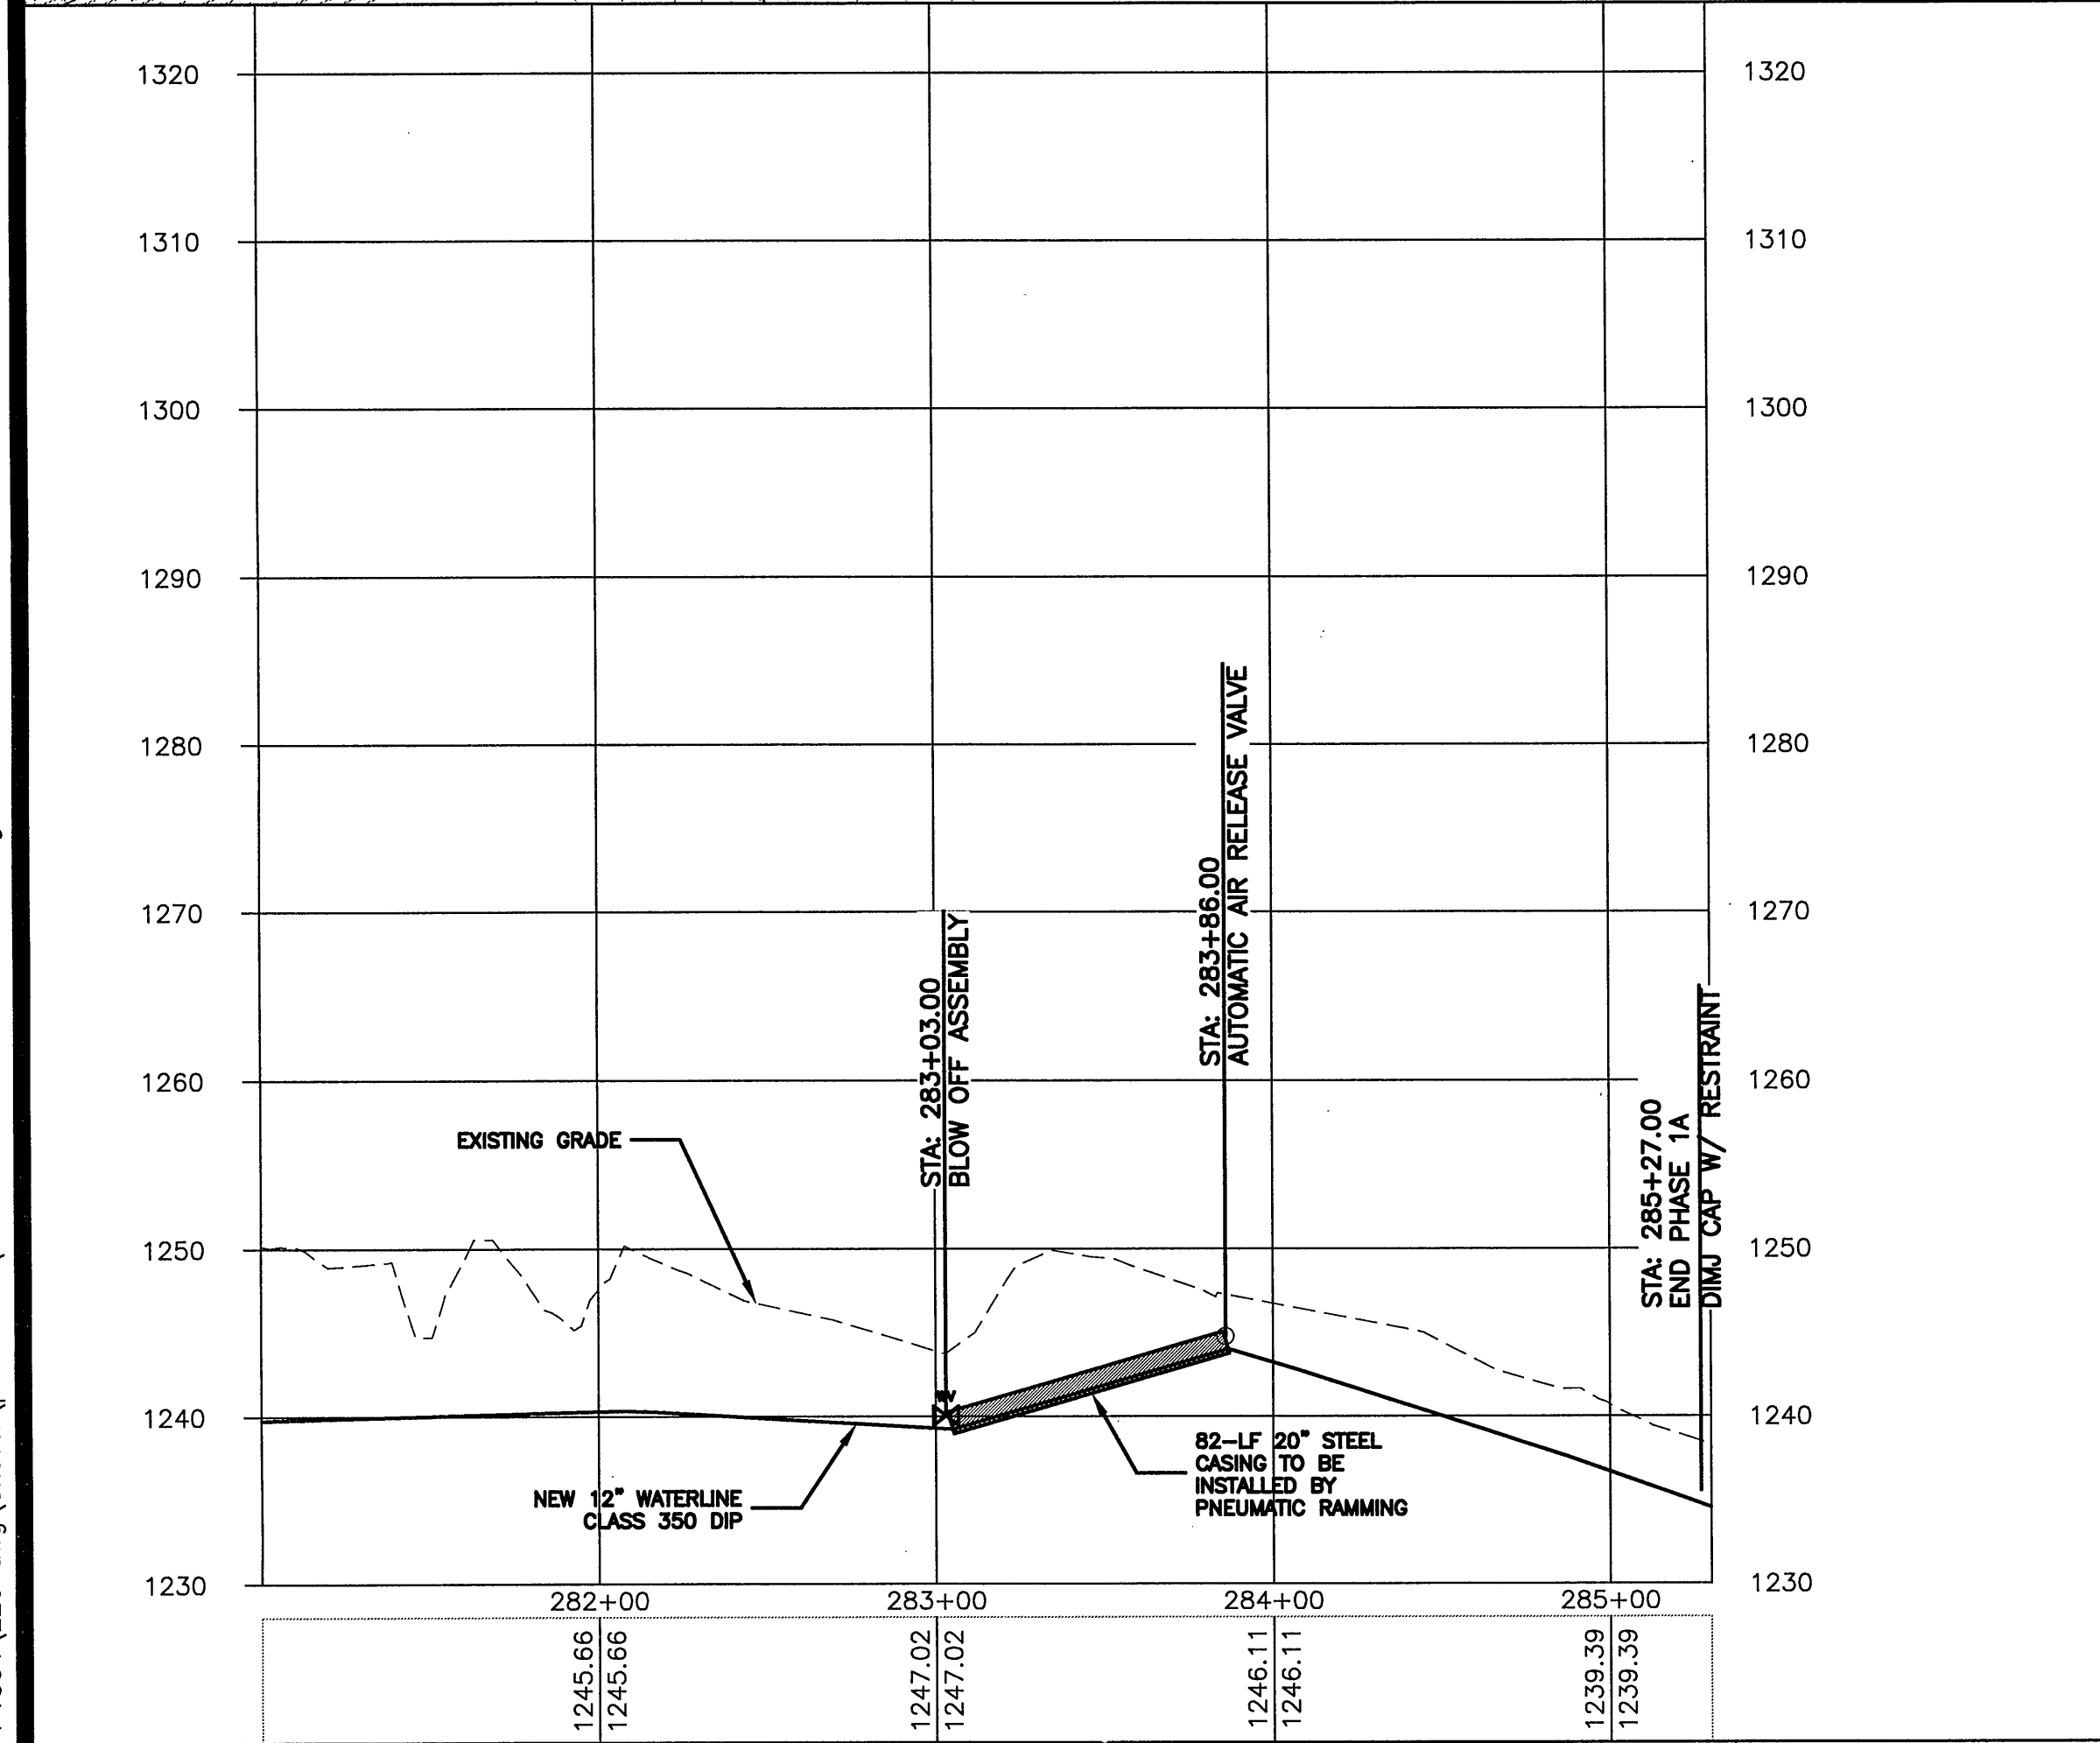

No.	Revisions	Date	DESIGN BY: MEP	PROJECT: ROANOKE/FRANKLIN COUNTY WATERLINE EXTENSION WESTERN VIRGINIA WATER AUTHORITY	DATE: 2/20/09
			DRAWN BY: MEP	TITLE: RAILROAD CROSSING PLAN AND PROFILE	DRAWING NUMBER: C1
			REVIEWED BY: JNL	DRAWING NAME: NSRR CROSSING DETAIL.dwg	SHEET NUMBER: 1 of 1
			JOB NUMBER: FCPP1004	SCALE: AS SHOWN	

EARTH ENVIRONMENTAL CONSULTANTS, INC.
235 Claiborne Ave
Rocky Mount, VA 2415
www.eearthenv.com
Phone: (540) 483-5975
Fax: (540) 483-2221

EARTH ENVIRONMENTAL CONSULTANTS, INC.
235 Claiborne Avenue
Rocky Mount, VA 24151
www.eearthenv.com
Phone: (540) 483-5975
Fax: (540) 483-2221

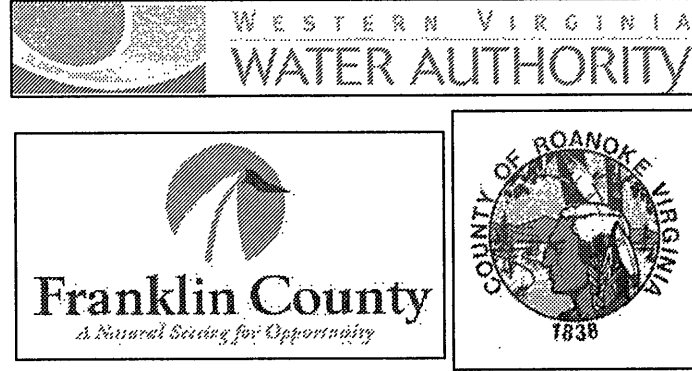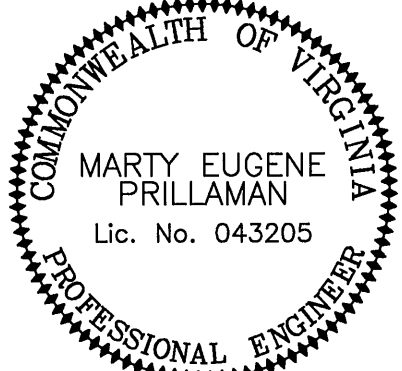

DESIGN BY: BKS/MEP	PROJECT: ADDENDUM TO ROANOKE/FRANKLIN COUNTY WATERLINE EXTENSION PHASE I-A U.S. ROUTE 220 ROANOKE COUNTY, VA	DATE: 2/20/09
DRAWN BY: BKS	TITLE: PLAN & PROFILE STA 280+00 TO 282+00	DRAWING NUMBER: C6
REVIEWED BY: MEP	DRAWING NAME: C6 STA 280+00 TO 282+00.dwg	SHEET NUMBER: 2 of 2
PROJECT NUMBER: FCPP1004	SCALE: H: 1" = 50'	