
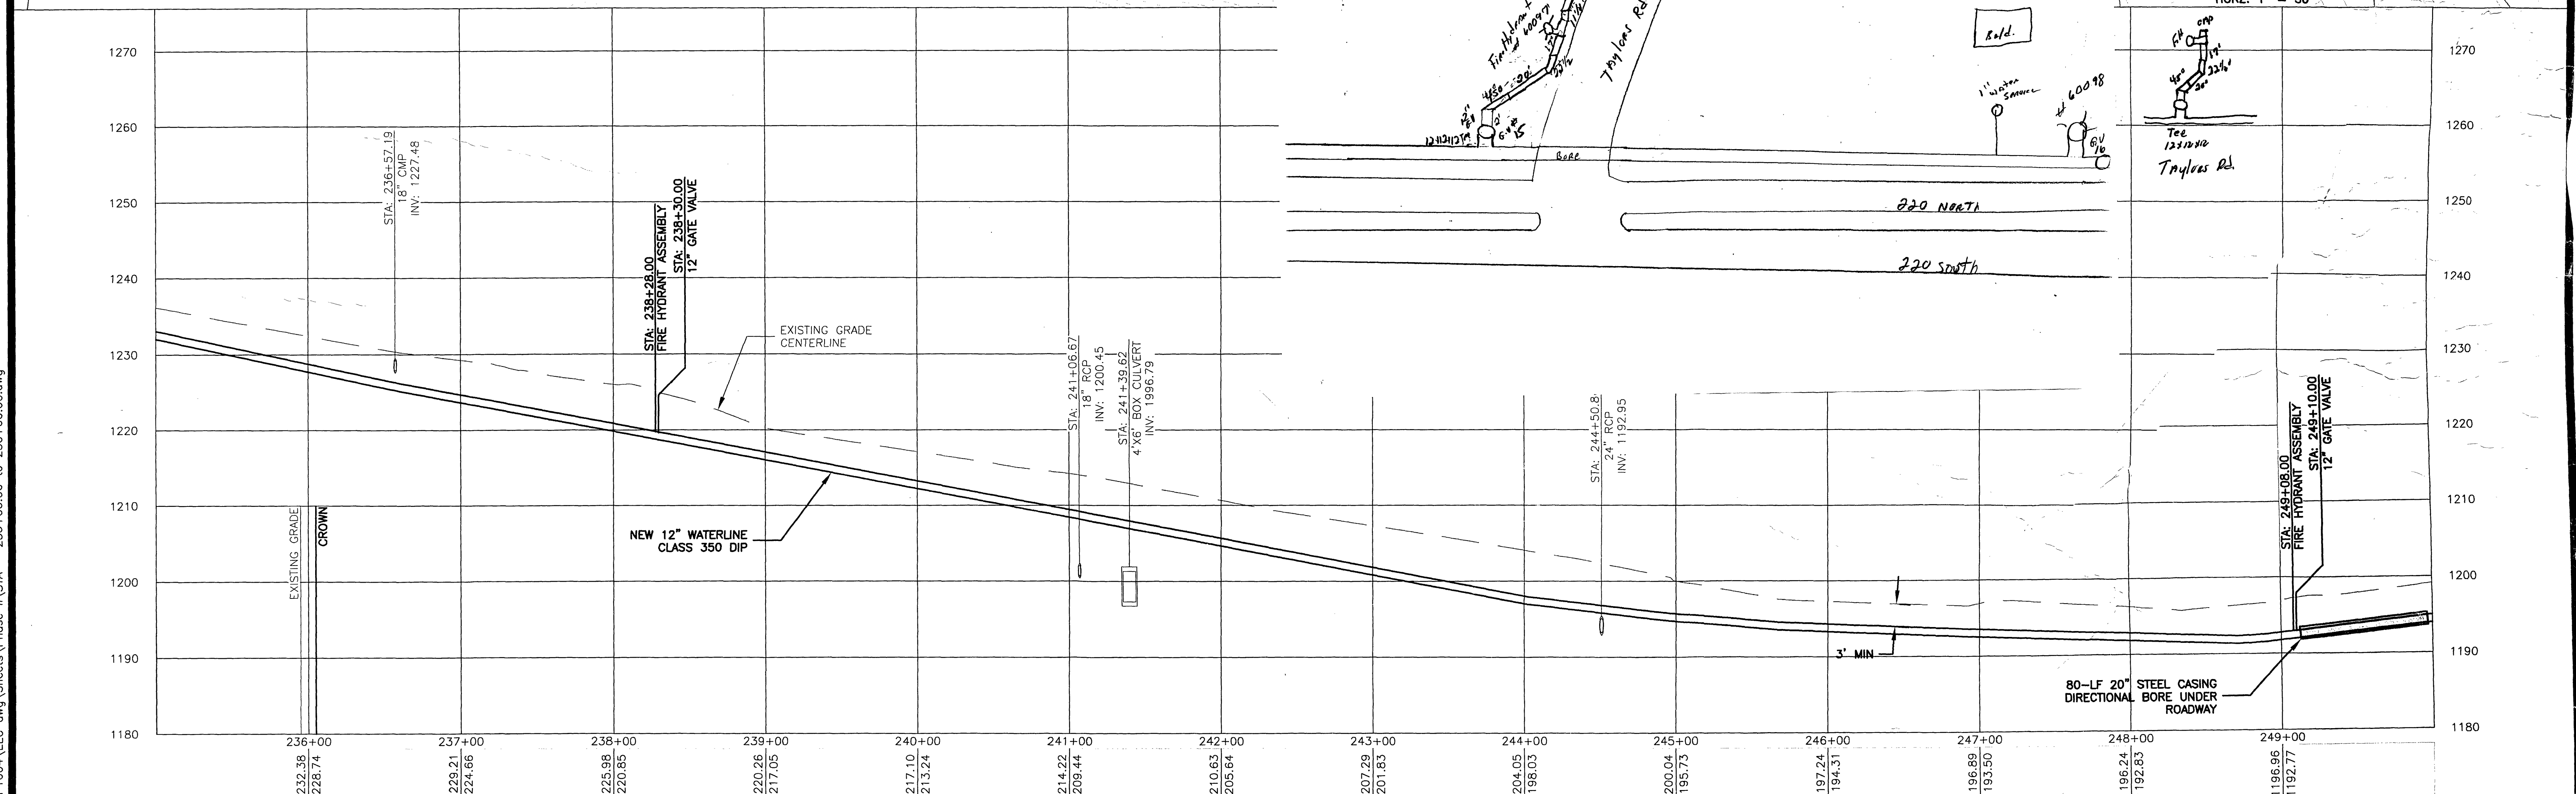


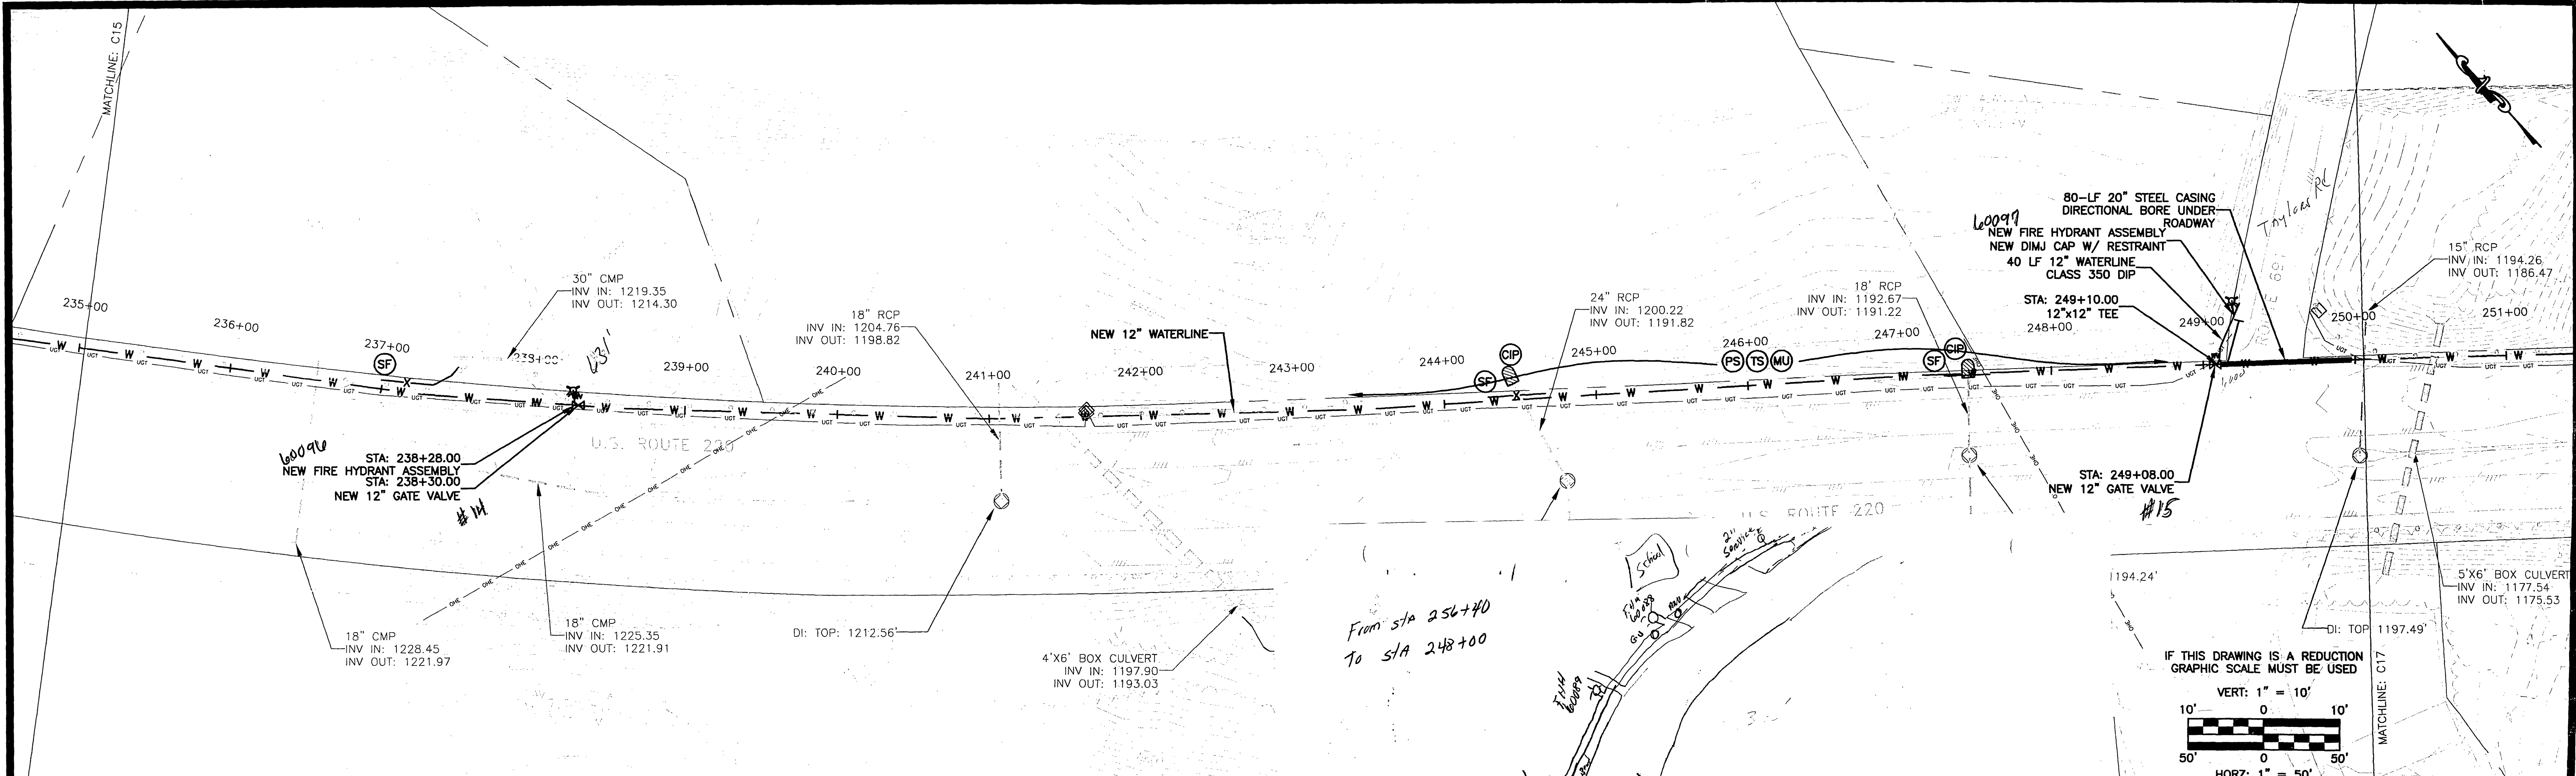

No:		Revisions:		Date:		Design By:		Project:		Date:	
1		FRANKLIN COUNTY COMMENTS		02/27/09		BKS/MEP		ROANOKE/FRANKLIN COUNTY WATERLINE EXTENSION PHASE II		01/14/09	
						BKS		U.S. ROUTE 220		DRAWING NUMBER:	
						MEP		FRANKLIN COUNTY, VA		C16	
						PROJECT NUMBER:		Plan and Profile		SHEET NUMBER:	
						FCPP1004		STA - 235+00.00 to 250+00.00.dwg		18 of 28	
								SCALE:			
								H: 1" = 50'			
								V: 1" = 10'			

EARTH ENVIRONMENTAL CONSULTANTS, INC.
235 Claiborne Ave.,
Rocky Mount, VA 24151
www.earthenv.com
Phone: (540) 483-5975
Fax: (540) 483-2221

COMMONWEALTH OF VIRGINIA
MARTY EUGENE PRILLAMAN
Lic. No. 043205
2/27/09
PROFESSIONAL ENGINEER

WATER AUTHORITY
Franklin County
A Division of the County of Roanoke

DESIGN BY: BKS/MEP
DRAWN BY: BKS
REVIEWED BY: MEP
PROJECT NUMBER: FCPP1004
PROJECT: ROANOKE/FRANKLIN COUNTY WATERLINE EXTENSION PHASE II
U.S. ROUTE 220
FRANKLIN COUNTY, VA
TITLE: Plan and Profile
STA - 235+00.00 to 250+00.00
DRAWING NAME: STA - 235+00.00 to 250+00.00.dwg
SCALE: H: 1" = 50'
V: 1" = 10'