


P:\FC - Plateau Plaza\FCPP1004\EEC dwg\Sheets\Phase II\STA - 355+00.00 to 370+16.94.dwg

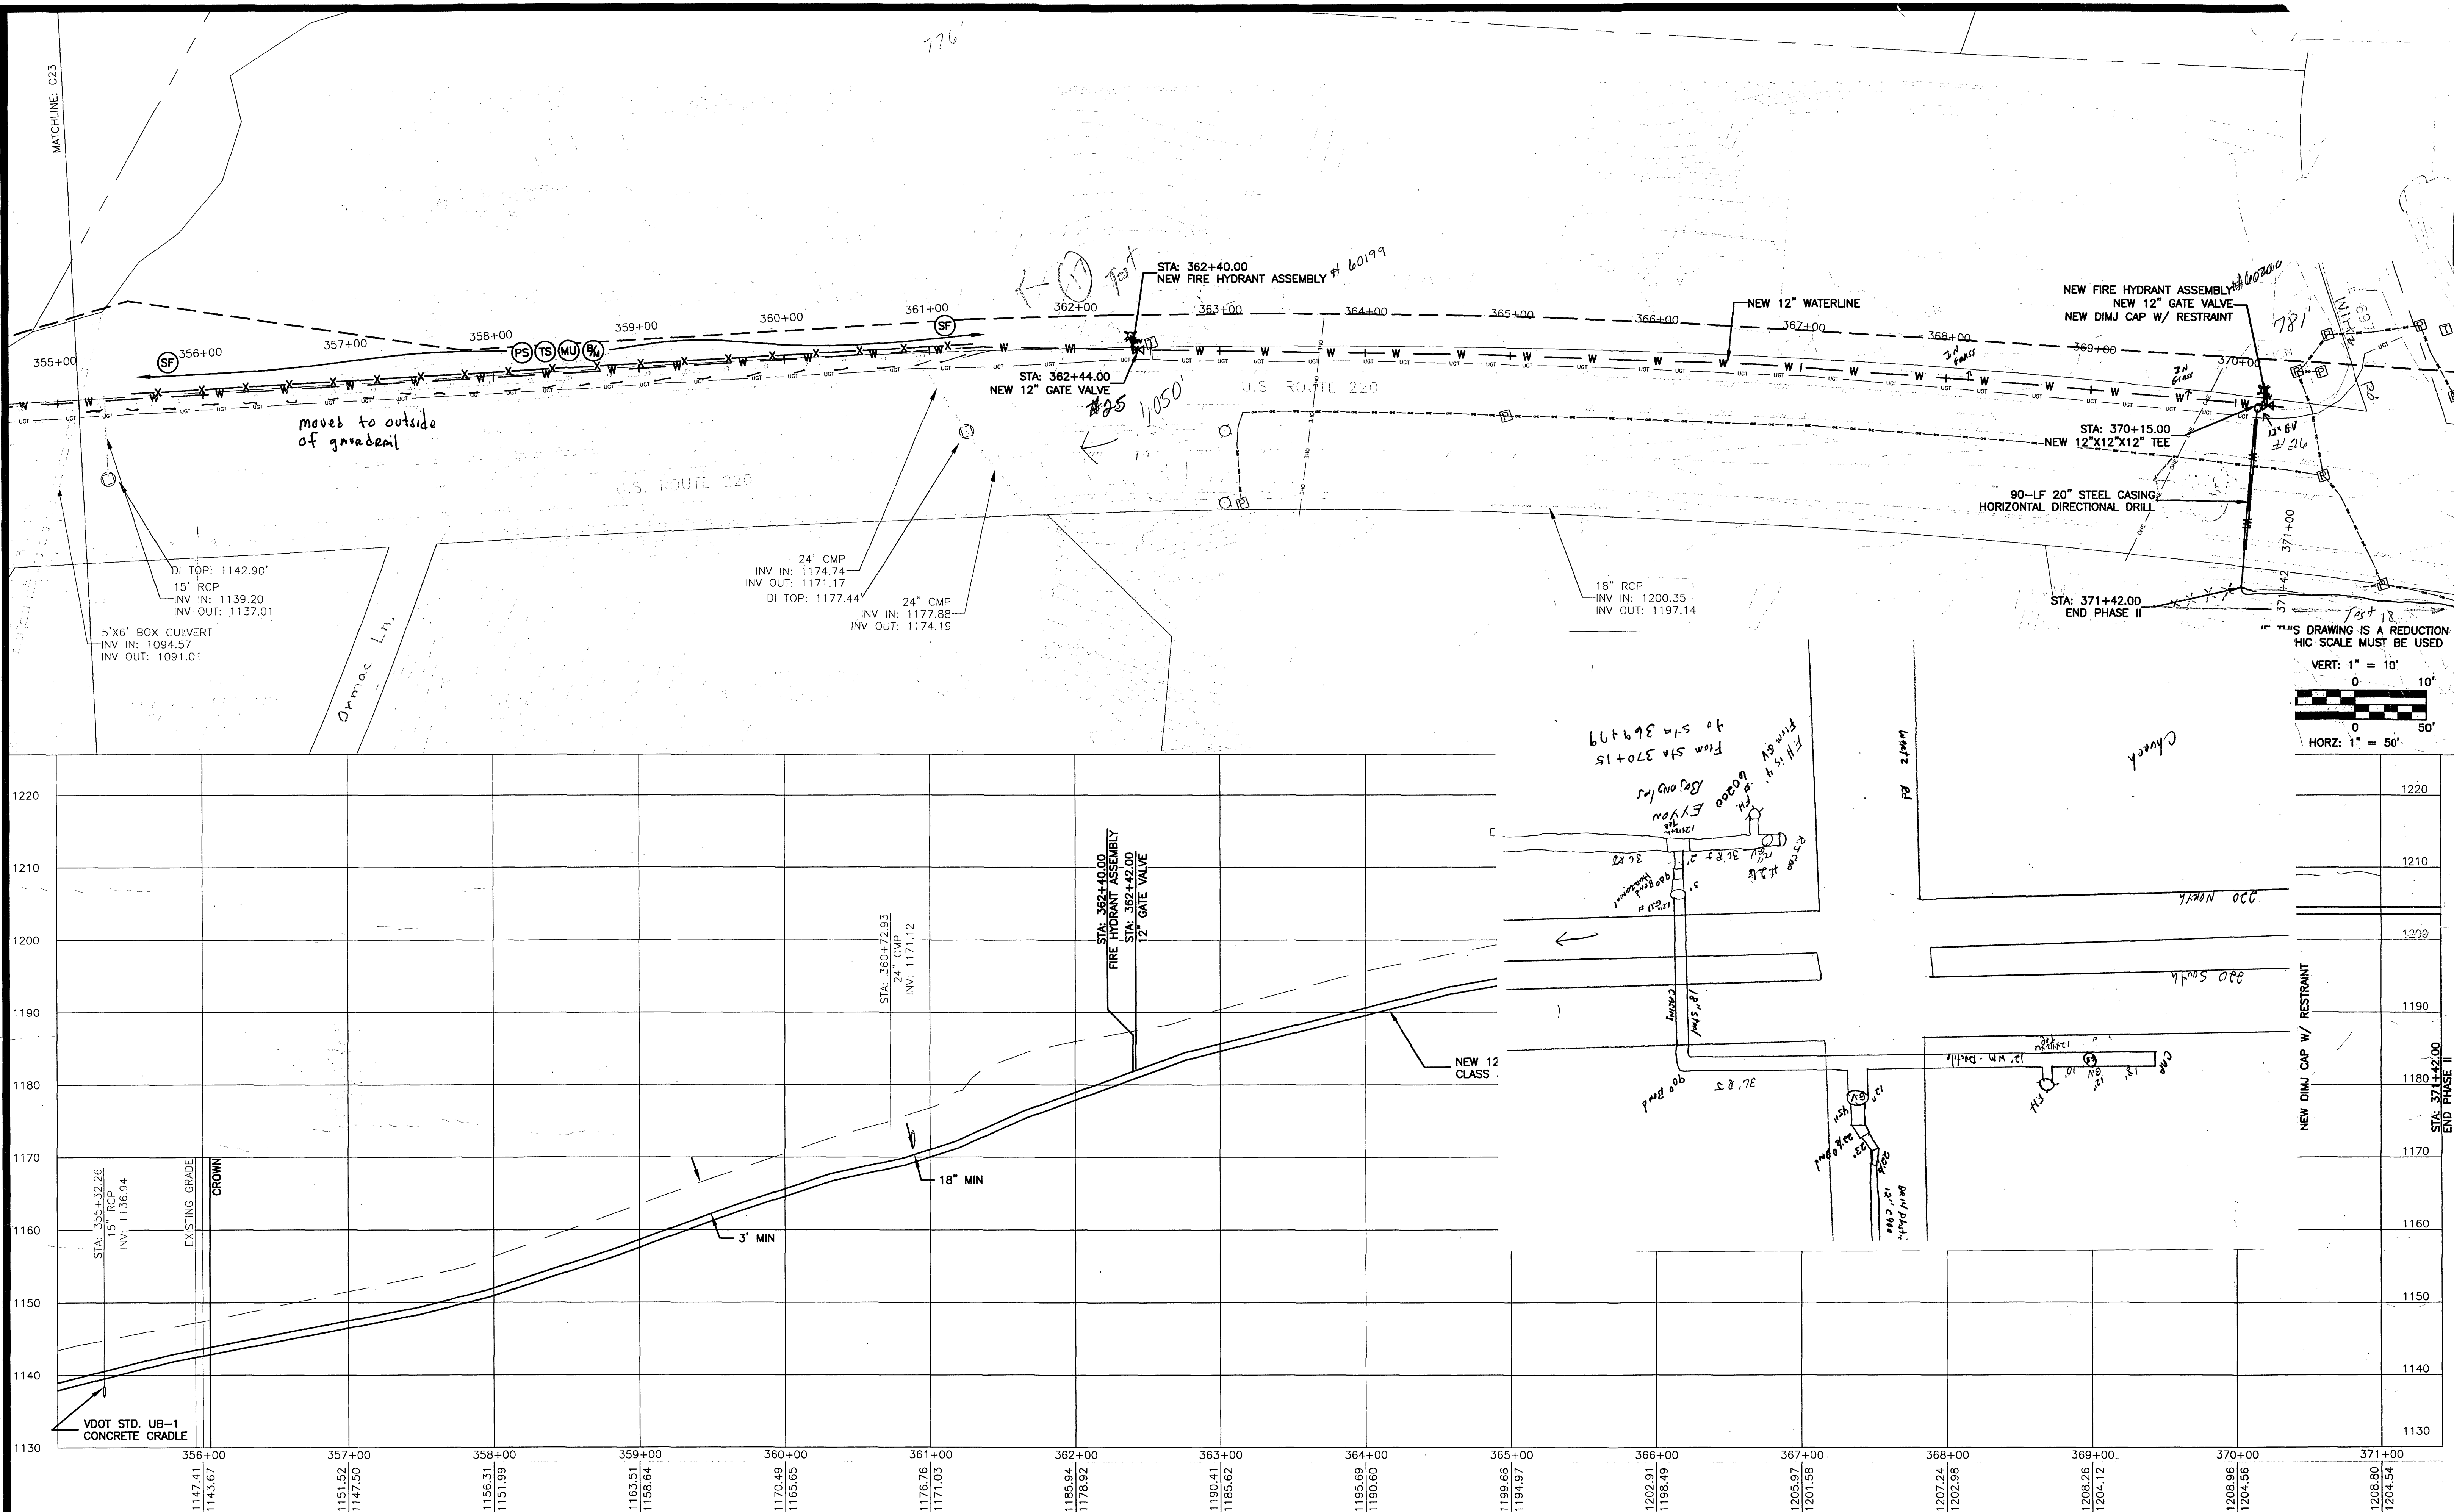


No:		Revisions:	Date:
1	FRANKLIN COUNTY COMMENTS		02/27/09



EARTH ENVIRONMENTAL CONSULTANTS, INC.
235 Claiborne Ave.,
Rocky Mount, VA 24151
www.earthenv.com

Phone: (540) 483-5975
Fax: (540) 483-2221

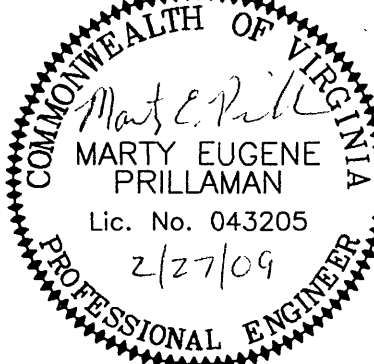

MARTY EUGENE PRILLAMAN
Lic. No. 043205
2/27/09
PROFESSIONAL ENGINEER



WATER AUTHORITY



Franklin County

DESIGN BY: BKS/MEP	PROJECT: ROANOKE/FRANKLIN COUNTY WATERLINE EXTENSION PHASE II U.S. ROUTE 220 FRANKLIN COUNTY, VA	DATE: 01/14/09
DRAWN BY: BKS	TITLE: Plan and Profile STA - 355+00.00 to 370+16.94	DRAWING NUMBER: C24
REVIEWED BY: MEP	DRAWING NAME: STA - 355+00.00 to 370+16.94.dwg	SHEET NUMBER: 26 of 28
PROJECT NUMBER: FCPP1004	SCALE: H: 1" = 50' V: 1" = 10'	