
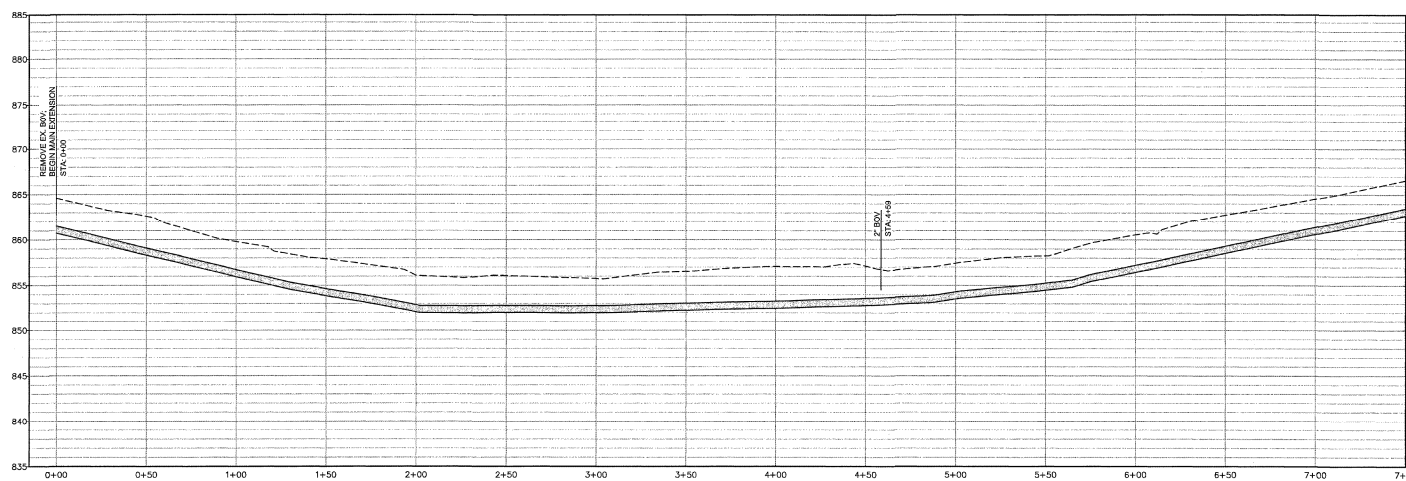


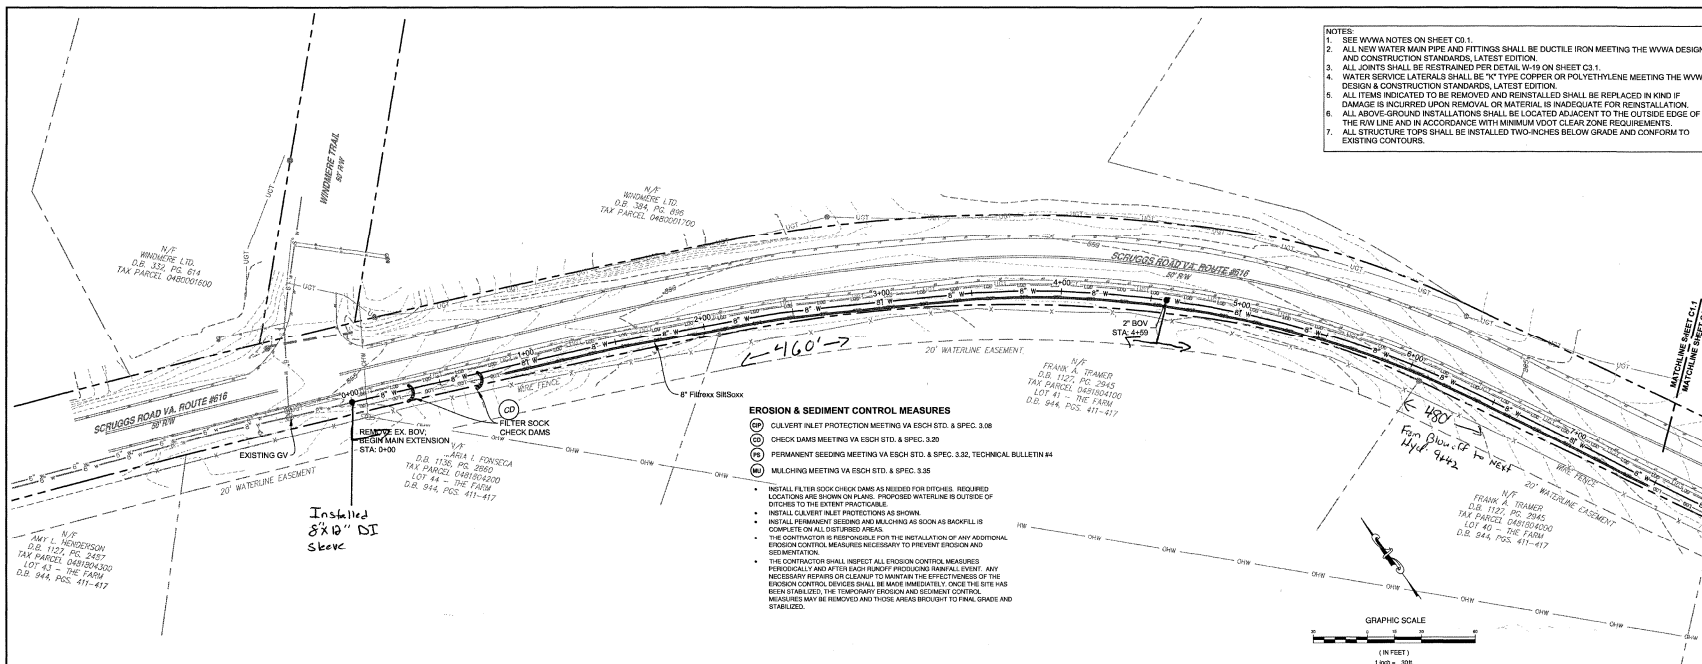

SEAL OF THE COMMONWEALTH OF VIRGINIA
8/12/2022

parker
DESIGN GROUP
REGISTERED PROFESSIONAL ENGINEERS
2122 Carolina Ave. SW
Roanoke, VA 24014
(540) 387-1133
1915-B W. Cary Street
Richmond, VA 23220
(804) 338-3347
www.parkerdesign.com

SCRUGGS ROAD AREA IMPROVEMENTS
WINDMERE - COMPASS COVE - BERNARD'S LANDING
WATER MAIN EXTENSION & PRV SITES
PREPARED FOR WESTERN VIRGINIA WATER AUTHORITY
FRANKLIN COUNTY, VIRGINIA

REVISIONS

NO.	DESCRIPTION	DATE
1	DESIGNED BY: CEP	
2	DRAWN BY: CEP	
3	CHECKED BY: JRS & SLH	
4	SCALE: 1" = 30'	
5	DATE: AUGUST 12, 2022	
6	PROJECT NUMBER: 21-0287	
7	SHEET TITLE: PLAN AND PROFILE STA 0+00 TO STA 7+50	

C1.1
4 OF 14