



NO.	REVISION
1	Date: 9-9-87
2	By: [Signature]
3	By: [Signature]
4	By: [Signature]
5	By: [Signature]
6	By: [Signature]
7	By: [Signature]
8	By: [Signature]
9	By: [Signature]
10	By: [Signature]
11	By: [Signature]
12	By: [Signature]
13	By: [Signature]
14	By: [Signature]
15	By: [Signature]
16	By: [Signature]
17	By: [Signature]
18	By: [Signature]

SHOPPING CENTER
SHENANDOAH & WEST SIDE BLVD
ROANOKE, VA

architecture, planning
interior design, graphics
shenandoah, tennessee
phone: 615.265.4313
INCORPORATED

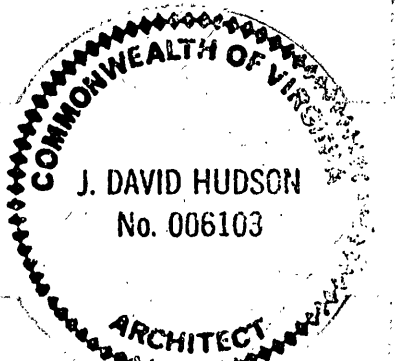

87-126
8-27-87
F.L.
G.A.H.
C-3
11/8

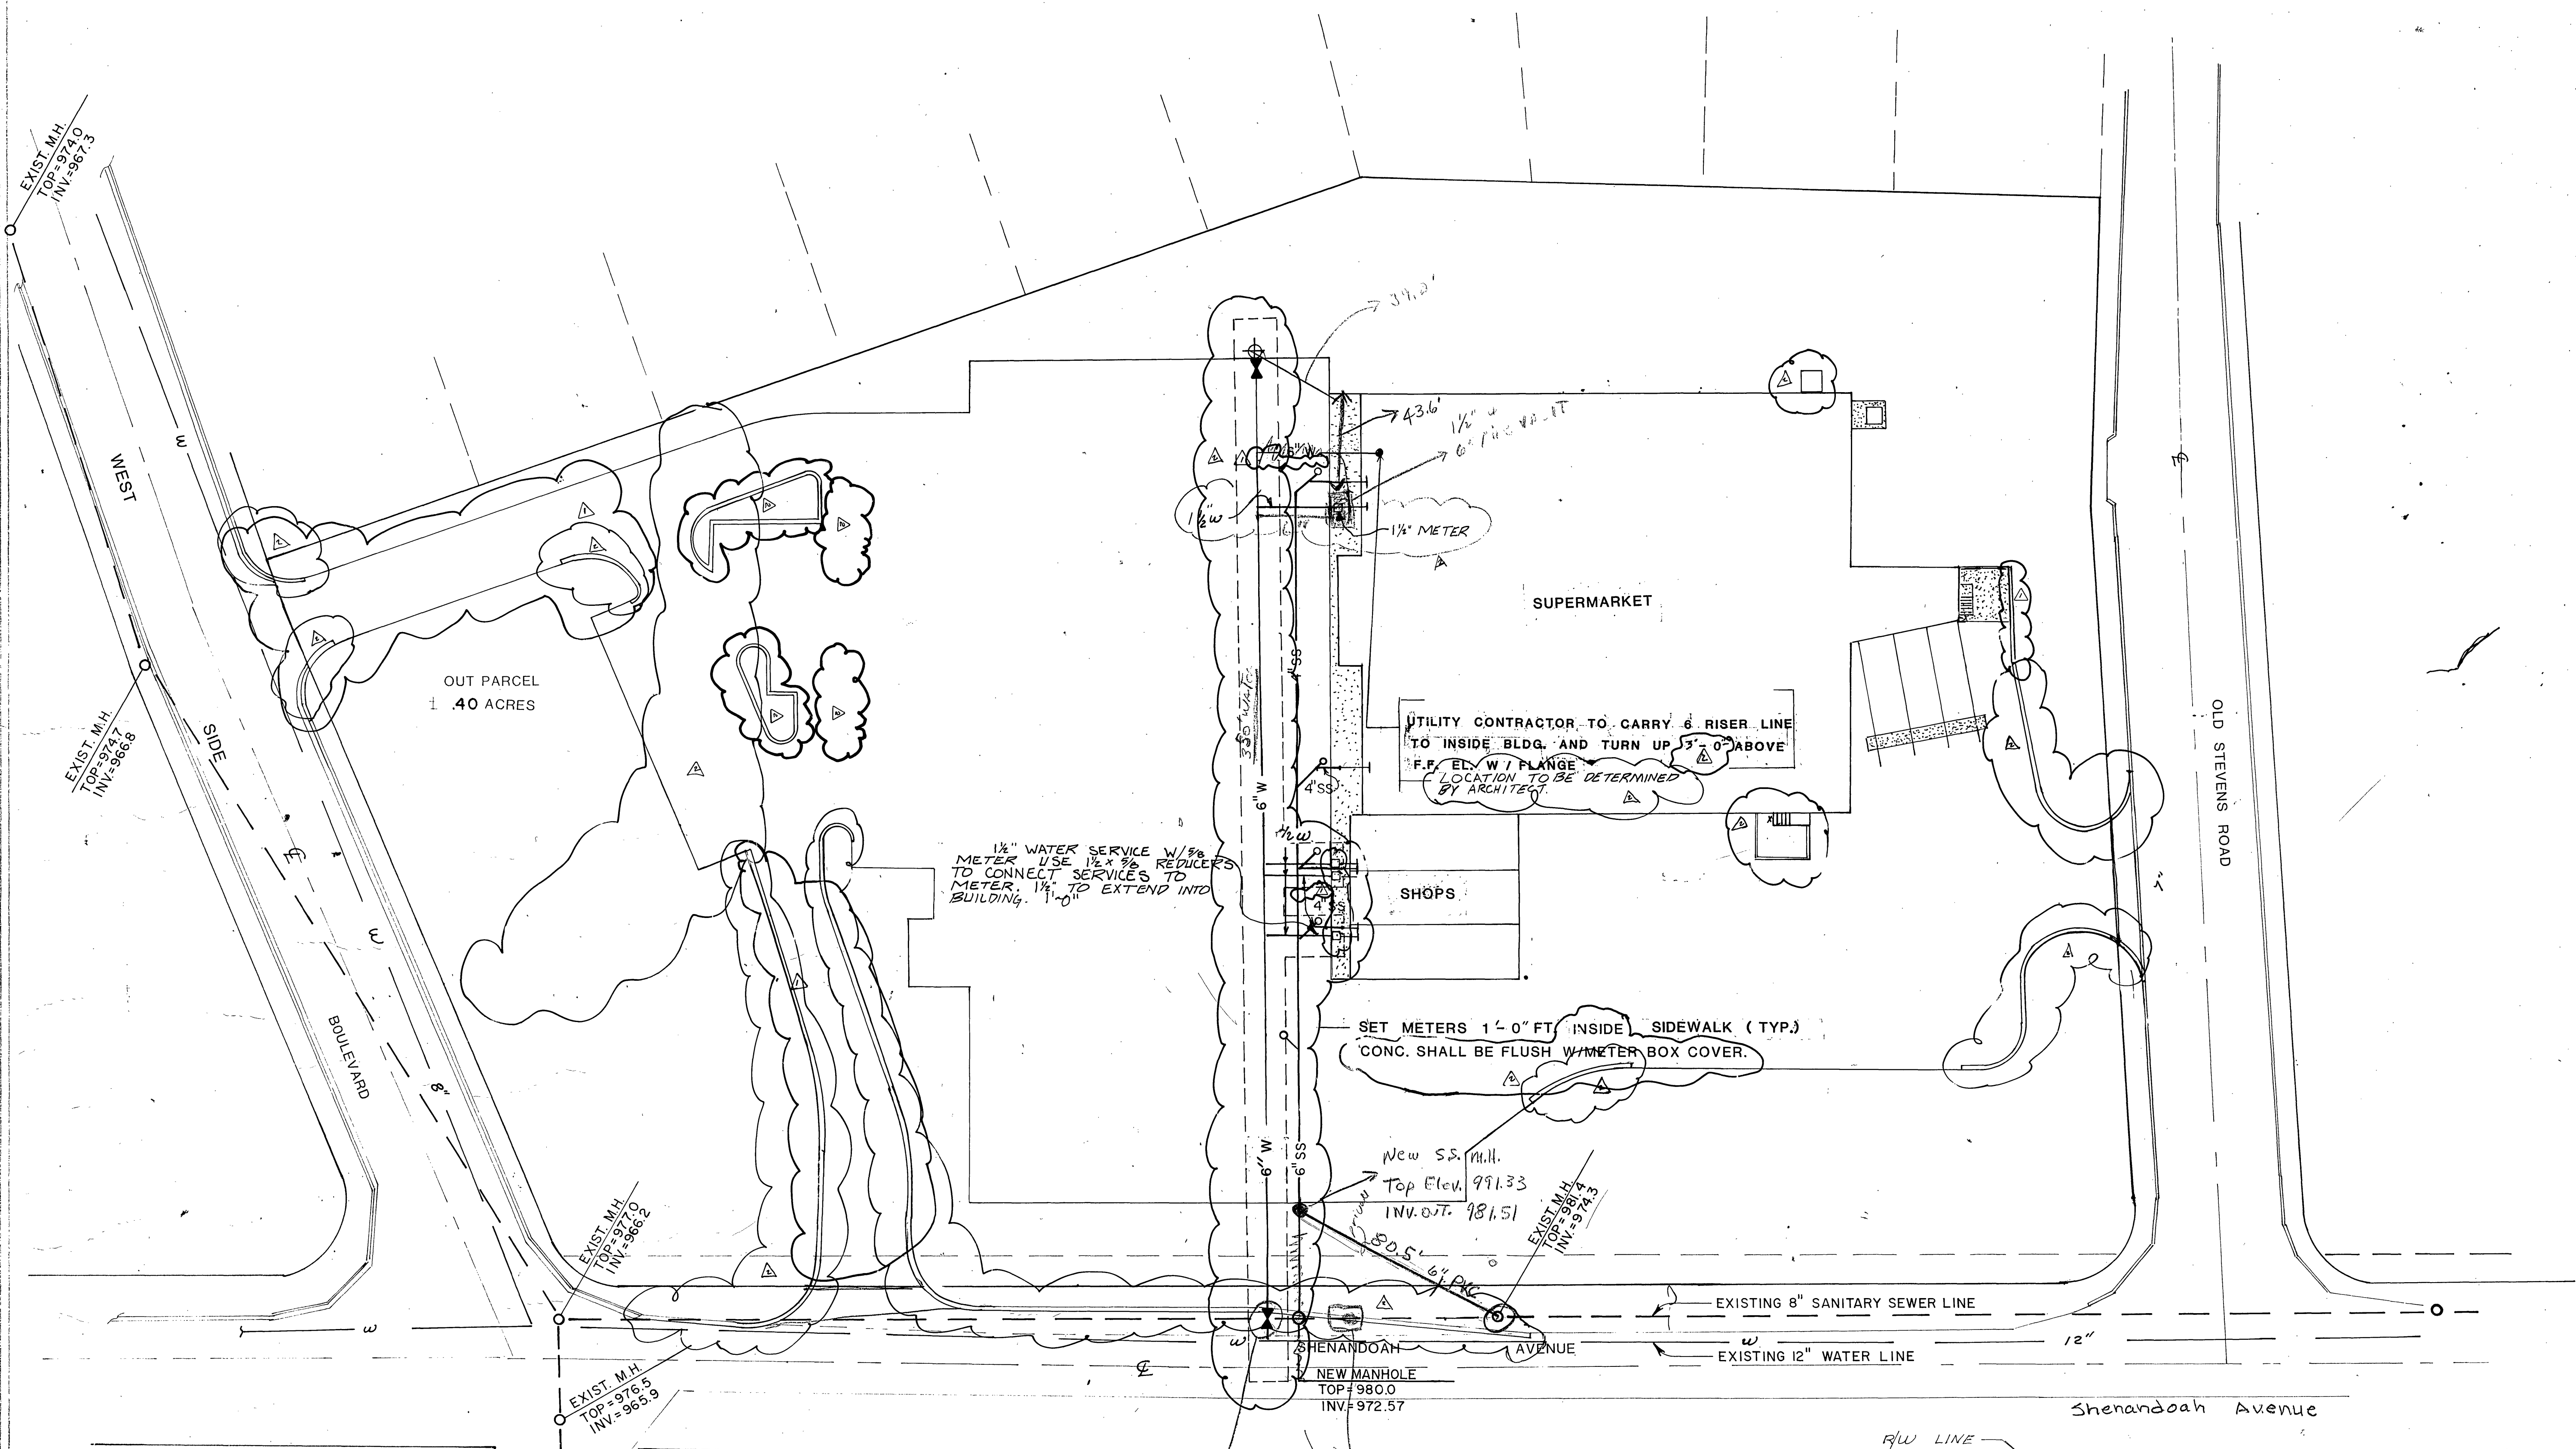

GENERAL NOTES - SITE UTILITY

- UTILITY CONTRACTOR IS RESPONSIBLE FOR CONTACTING LOCAL UTILITIES PRIOR TO INSTALLATION TO EACH UTILITY.
- UTILITY CONTRACTOR IS TO VERIFY LOCATION OF ALL EXISTING UTILITIES PRIOR TO CONSTRUCTION.
- UTILITY CONTRACTOR IS TO TERMINATE ALL UTILITIES 5 FEET OUTSIDE OF BUILDING AND CAP UNTIL SUCH TIME AS NEEDED. (UNLESS OTHERWISE NOTED)
- INSTALLATION OF UTILITIES IS TO CONFORM TO ALL STATE AND LOCAL CODES.
- SHOULD ANY CONFLICTS IN PIPE CROSSINGS OCCUR, IT IS THE RESPONSIBILITY OF THE CONTRACTOR TO NOTIFY THE ENGINEER IMMEDIATELY PRIOR TO INSTALLATION.
- SEE SHEET C-2 FOR PIPE INSTALLATION DETAILS.
- ALL DIMENSIONS ARE MEASURED FROM FACE OF CURB.

- CONSTRUCTION OF SANITARY SEWER AND PAVEMENT REPLACEMENT TO BE IN ACCORDANCE WITH CITY OF ROANOKE SPECIFICATIONS.
- CONTRACTOR SHALL VERIFY LOCATION OF ALL UTILITIES PRIOR TO CONSTRUCTION.

UTILITY PLAN

(SCALE: 1"=30')

LEGEND

- CONC. SIDEWALK
- SANITARY SEWER LINE
- WATER LINE
- WATER METER
- FIRE HYDRANT
- SANITARY SEWER CLEANOUT
- WATER VALVE

4/8/1988 As-Built