
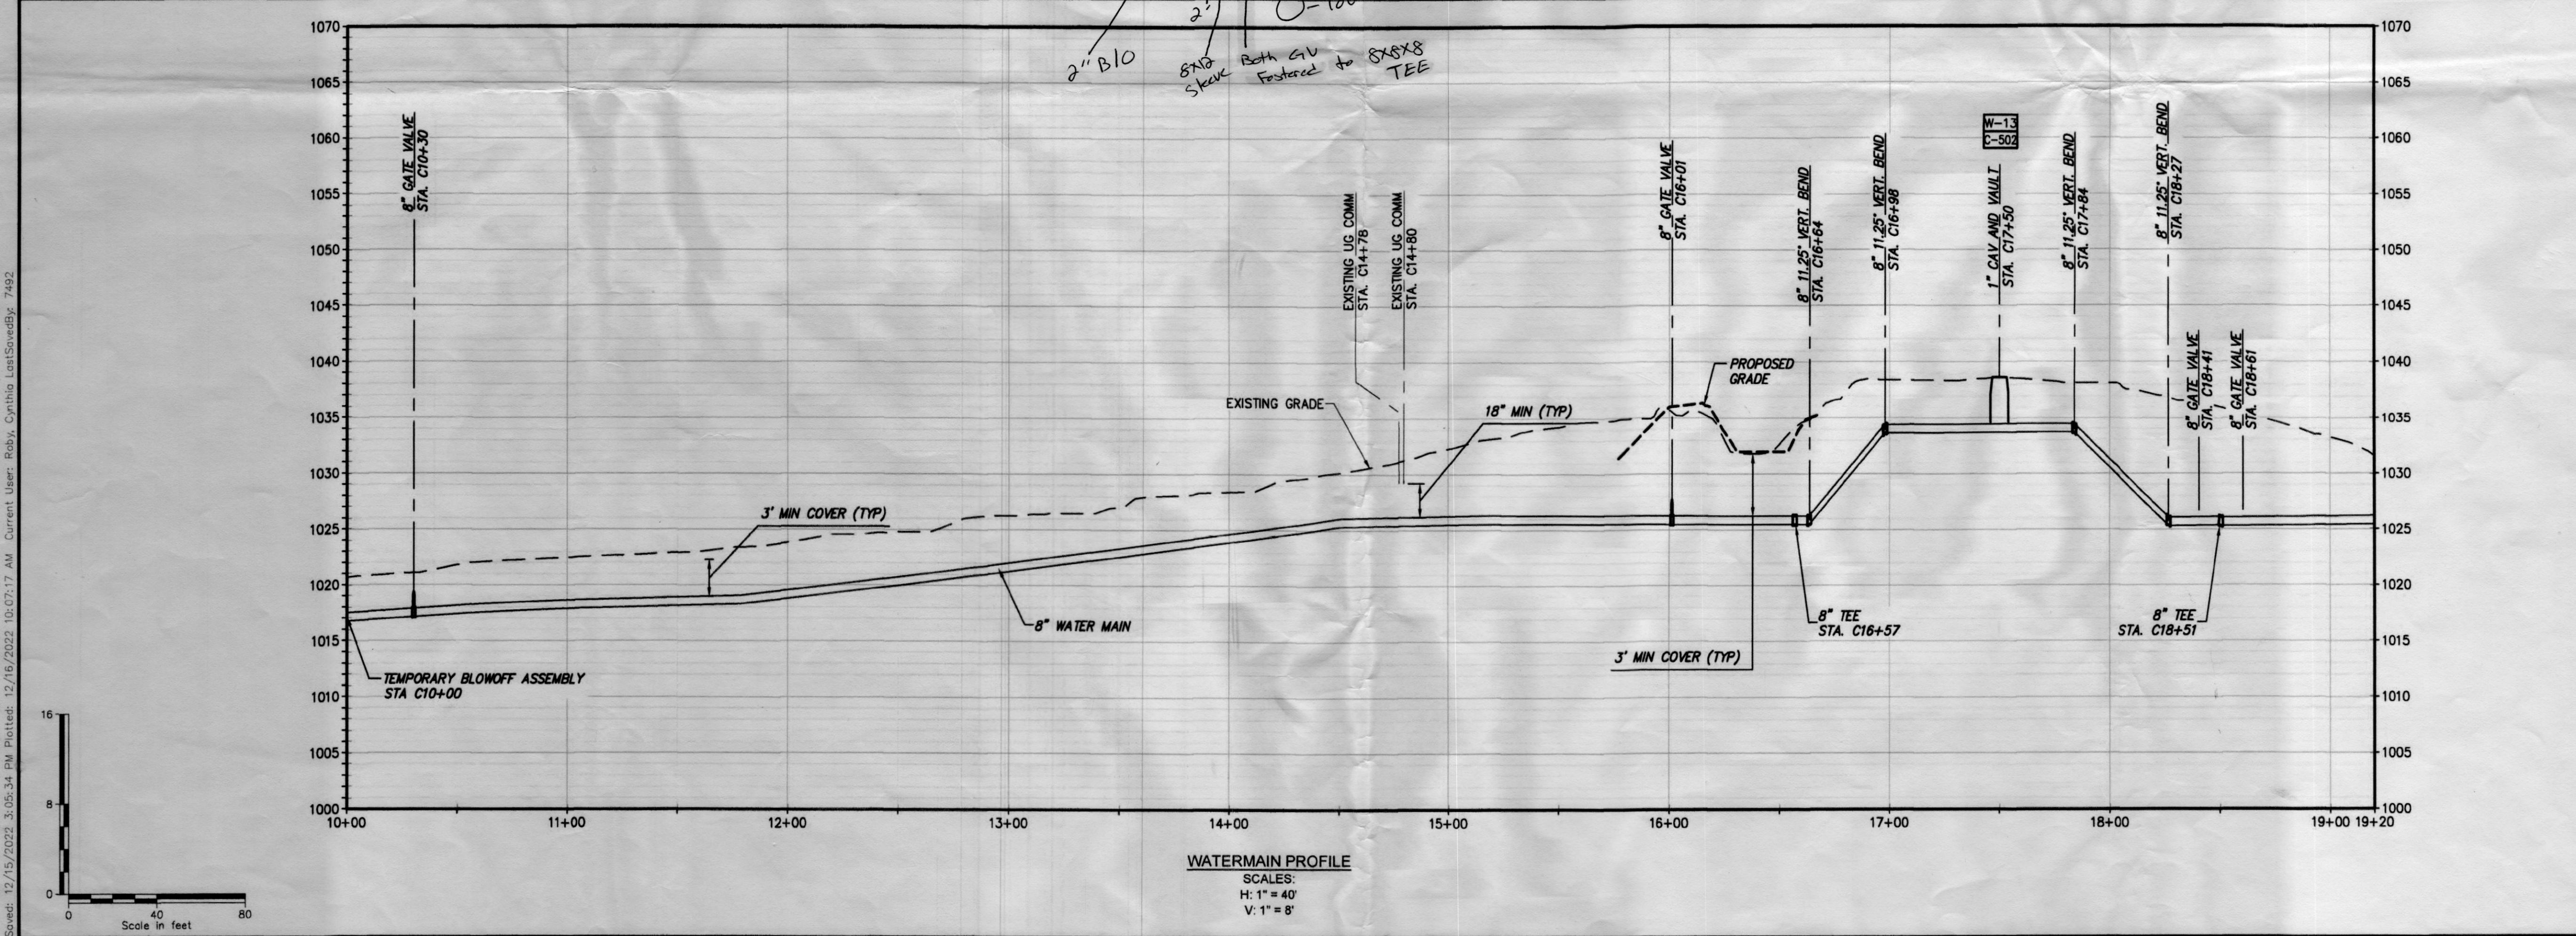


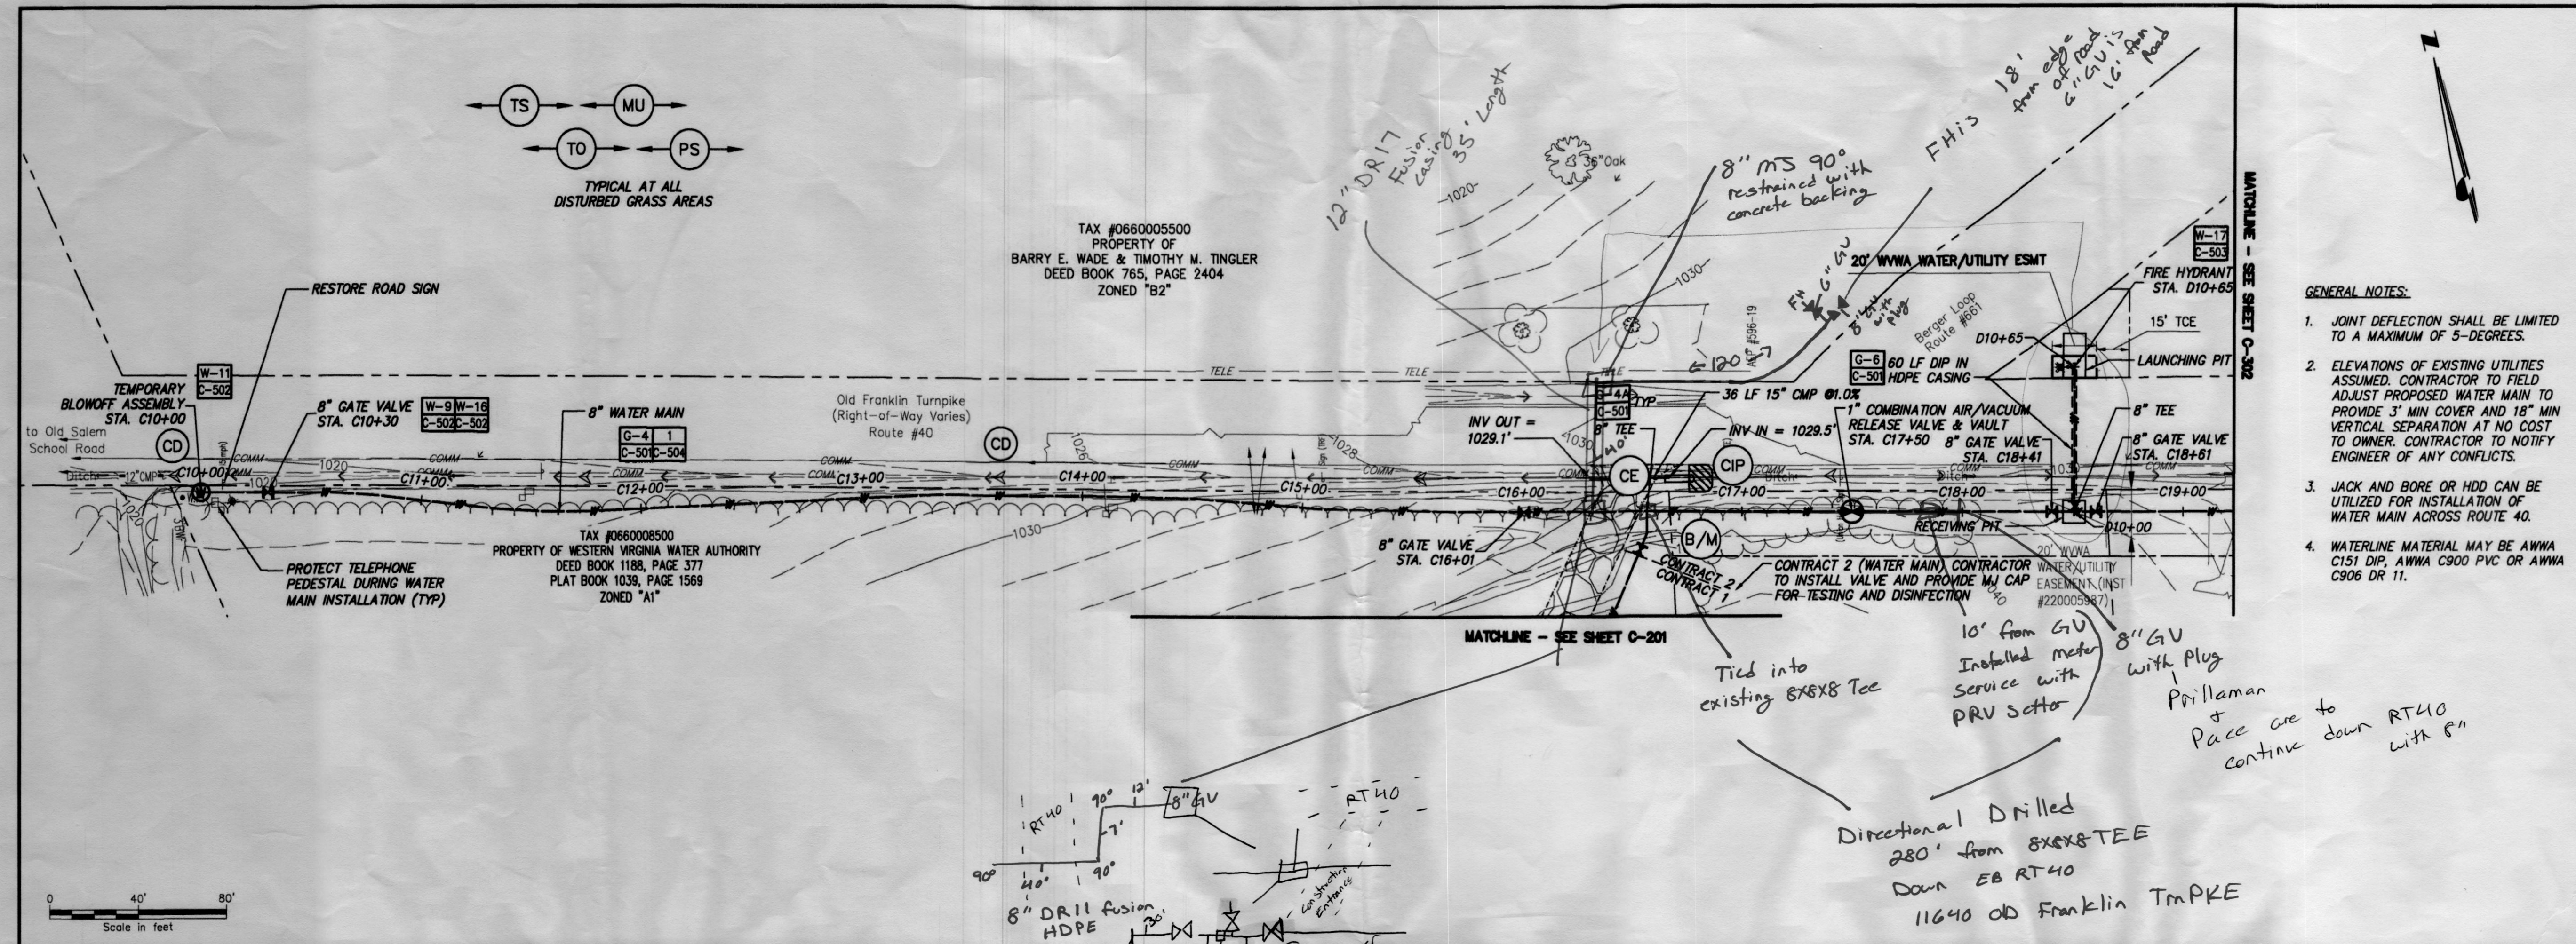

1341 Research Center Drive, Suite 2100
 Blacksburg, VA 26060-5548
 540.522.5548 www.chaconline.com

WESTERN VIRGINIA WATER AUTHORITY

ERIC T. ANDERSON
 Lic. No. 040813
 12/16/2022

SOUTHLAKE WATER SYSTEM

CONTRACT 1: WATER TREATMENT PLANT

CONTRACT 2: WATER MAIN

No.	Submital / Revision	App'd.	By	Date

BID ISSUE ETA CDR 12/15/22

WATERMAIN PLAN AND PROFILE

Designed By: CDR	Drawn By: CDR	Checked By: ETA
Issue Date: 12/15/22	Project No: 073612	Scale: AS NOTED

Drawing No.:
C-301

File: V:\PROJECTS\WV\073612\000\09_DESIGN\DRAWINGS\01_SHEETS\PHASE 2 - PROCESS\73612_C-301.DWG
 Saved: 12/15/2022 3:05:34 PM Plotted: 12/16/2022 10:07:17 AM Current User: Robb, Cynthia Last Saved By: 7492