


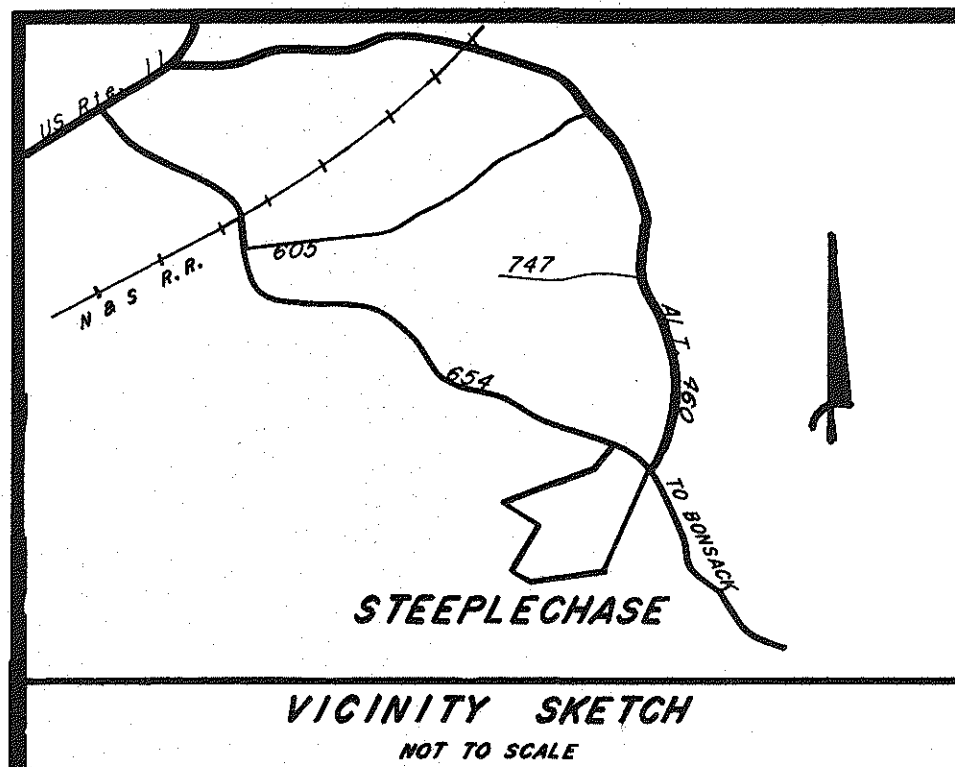

PROJECT NAME: Steeple Chase Sec 3
DATE: 12/1
TYPE: _____
LOCATION: _____
TOTAL # SHEETS: 4
A/E FIRM: Shankel
OF SETS: 1

STEEPLECHASE

SECTION 3

AS - BUILT Sanitary Sewer Plans

Blue Ridge Magisterial District
BOTETOURT COUNTY, VIRGINIA

Owner & Developer

A. R. OVERBAY

Contractor

St. Clair Construction

SHEET INDEX

	<u>AS-BUILT PLANS</u>	<u>CONSTRUCTION PLANS</u>
COVER SHEET	1	1
McINTOSH ROAD - Plan & Profile Sta. 10+00 to Sta. 21+90.77 MH 9 and 26 through 31	2	3
McINTOSH ROAD - Plan & Profile Sta. 21+90.77 to Sta. 28+40.51 MH 5 through 8, and 18	3	4
SANITARY SEWER LINE 2 - Profile Sta. 0+00 to Sta. 13+22.08 MH 5 and 26 through 29	4	5


THE FOLLOWING CONSTRUCTION PLAN SHEETS HAVE BEEN OMITTED FROM AS-BUILT PLANS

<i>SHEET NUMBER</i>	<i>ITEM</i>
<i>2</i>	<i>MASTER PLAN</i>
<i>6</i>	<i>UTILITY SPECIFICATIONS</i>
<i>7</i>	<i>SANITARY SEWER DETAILS</i>
<i>8</i>	<i>WATER LINE DETAILS</i>
<i>9</i>	<i>EROSION CONTROL DETAILS</i>


SHANKS ASSOCIATES, P. C. - ENGINEERS - SURVEYORS - PLANNERS

SHEET NUMBER		DATE		REVISION DESCRIPTION	
1 OF 4					
JOB NUMBER		DATE			
291003		12/04/91			
		DRAWN BY:			
		CEG			
		DESIGNED BY:			
		FOS			
		CHECKED BY:			
		FOS			
		SCALE:			
		AS NOTED			
STEEPLECHASE - SECTION 3 AS BUILT PLANS COVER SHEET					


PROFILE NOTE BOOK No. 87.7	SURVEYED _____	BY SJM	DATE 3/14/97
	PLOTTED _____	SJM	3/10/97
	GRADES CHECKED _____	PDS	4/23/97
	B. M.'s NOTED _____		
	STRUCTURE NOTATIONS CHECKED _____		

 

PROFILE NOTE BOOK NO. 89-7	SURVIVED _____	BY RAM	DATE 3/29/91
	PLOTTED _____	RAM	3/29/91
	GRANDS CHECKED _____	POS	4/23/91
	B. M. & NOTED _____		
STRUCTURE NOTATIONS CHECKED _____			

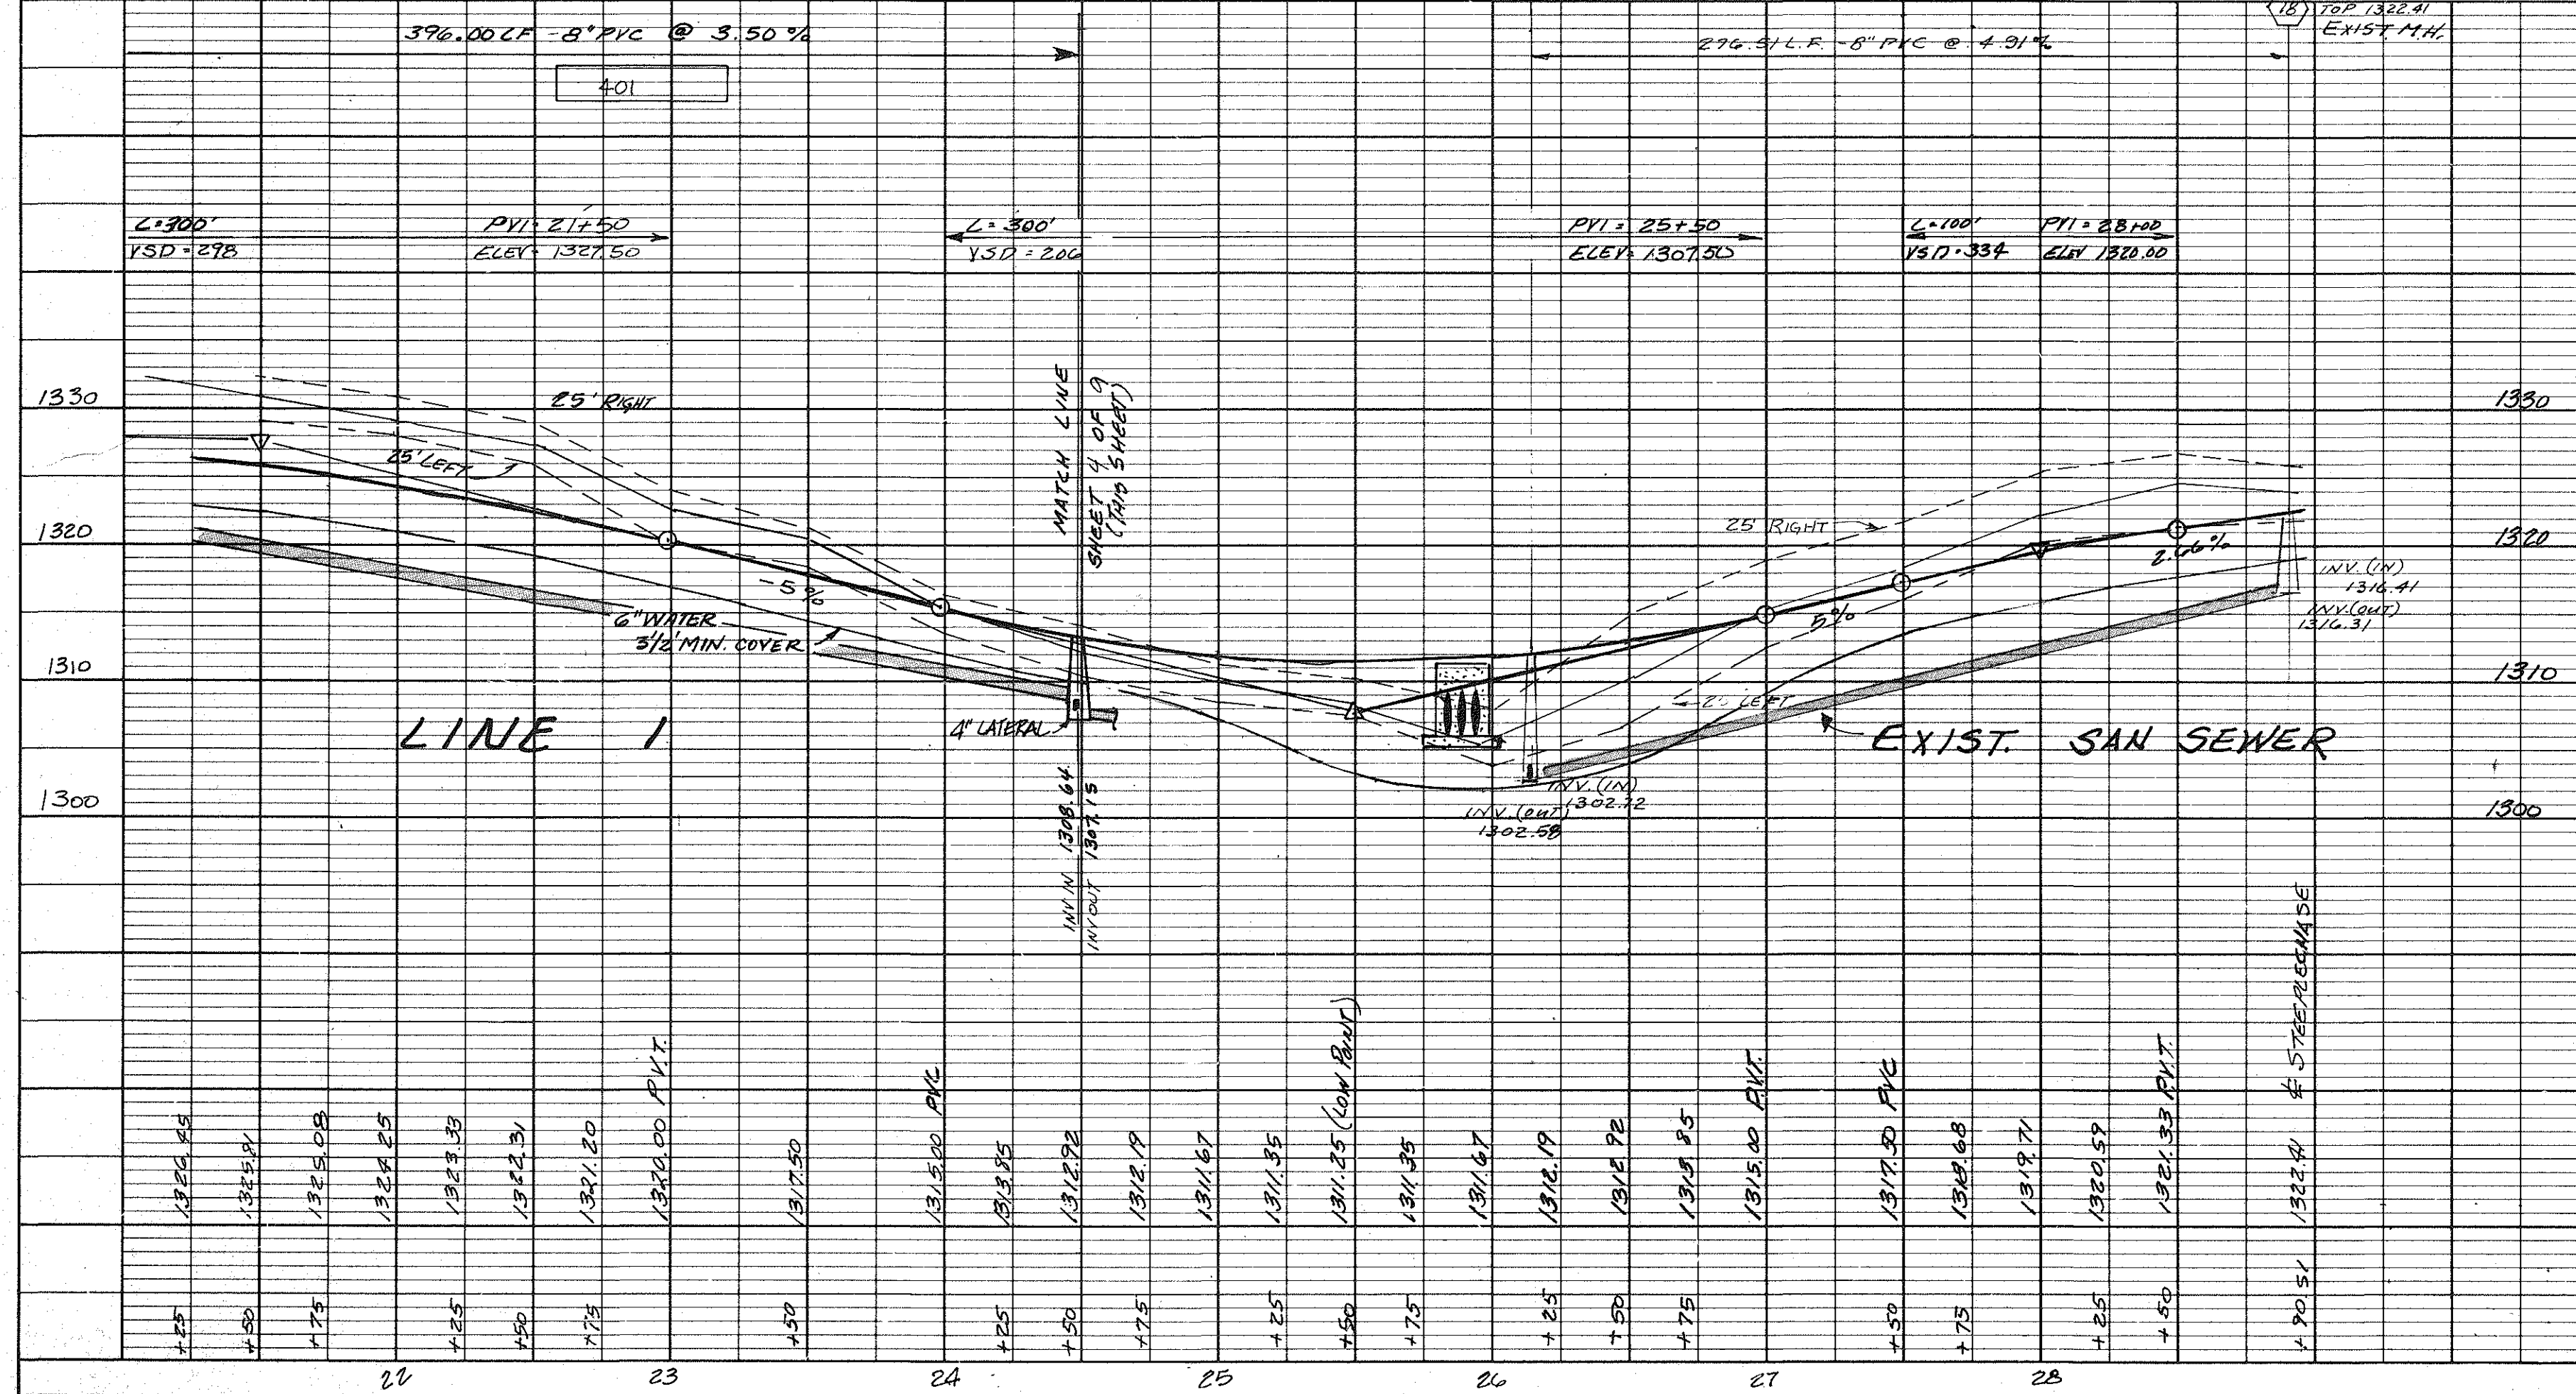


SHANKS ASSOCIATES, P. C.
ENGINEERS-SURVEYORS-PLANNERS
313 LUCK AVENUE
ROANOKE, VIRGINIA 24011
(703) 343-6685
Job Number 291003

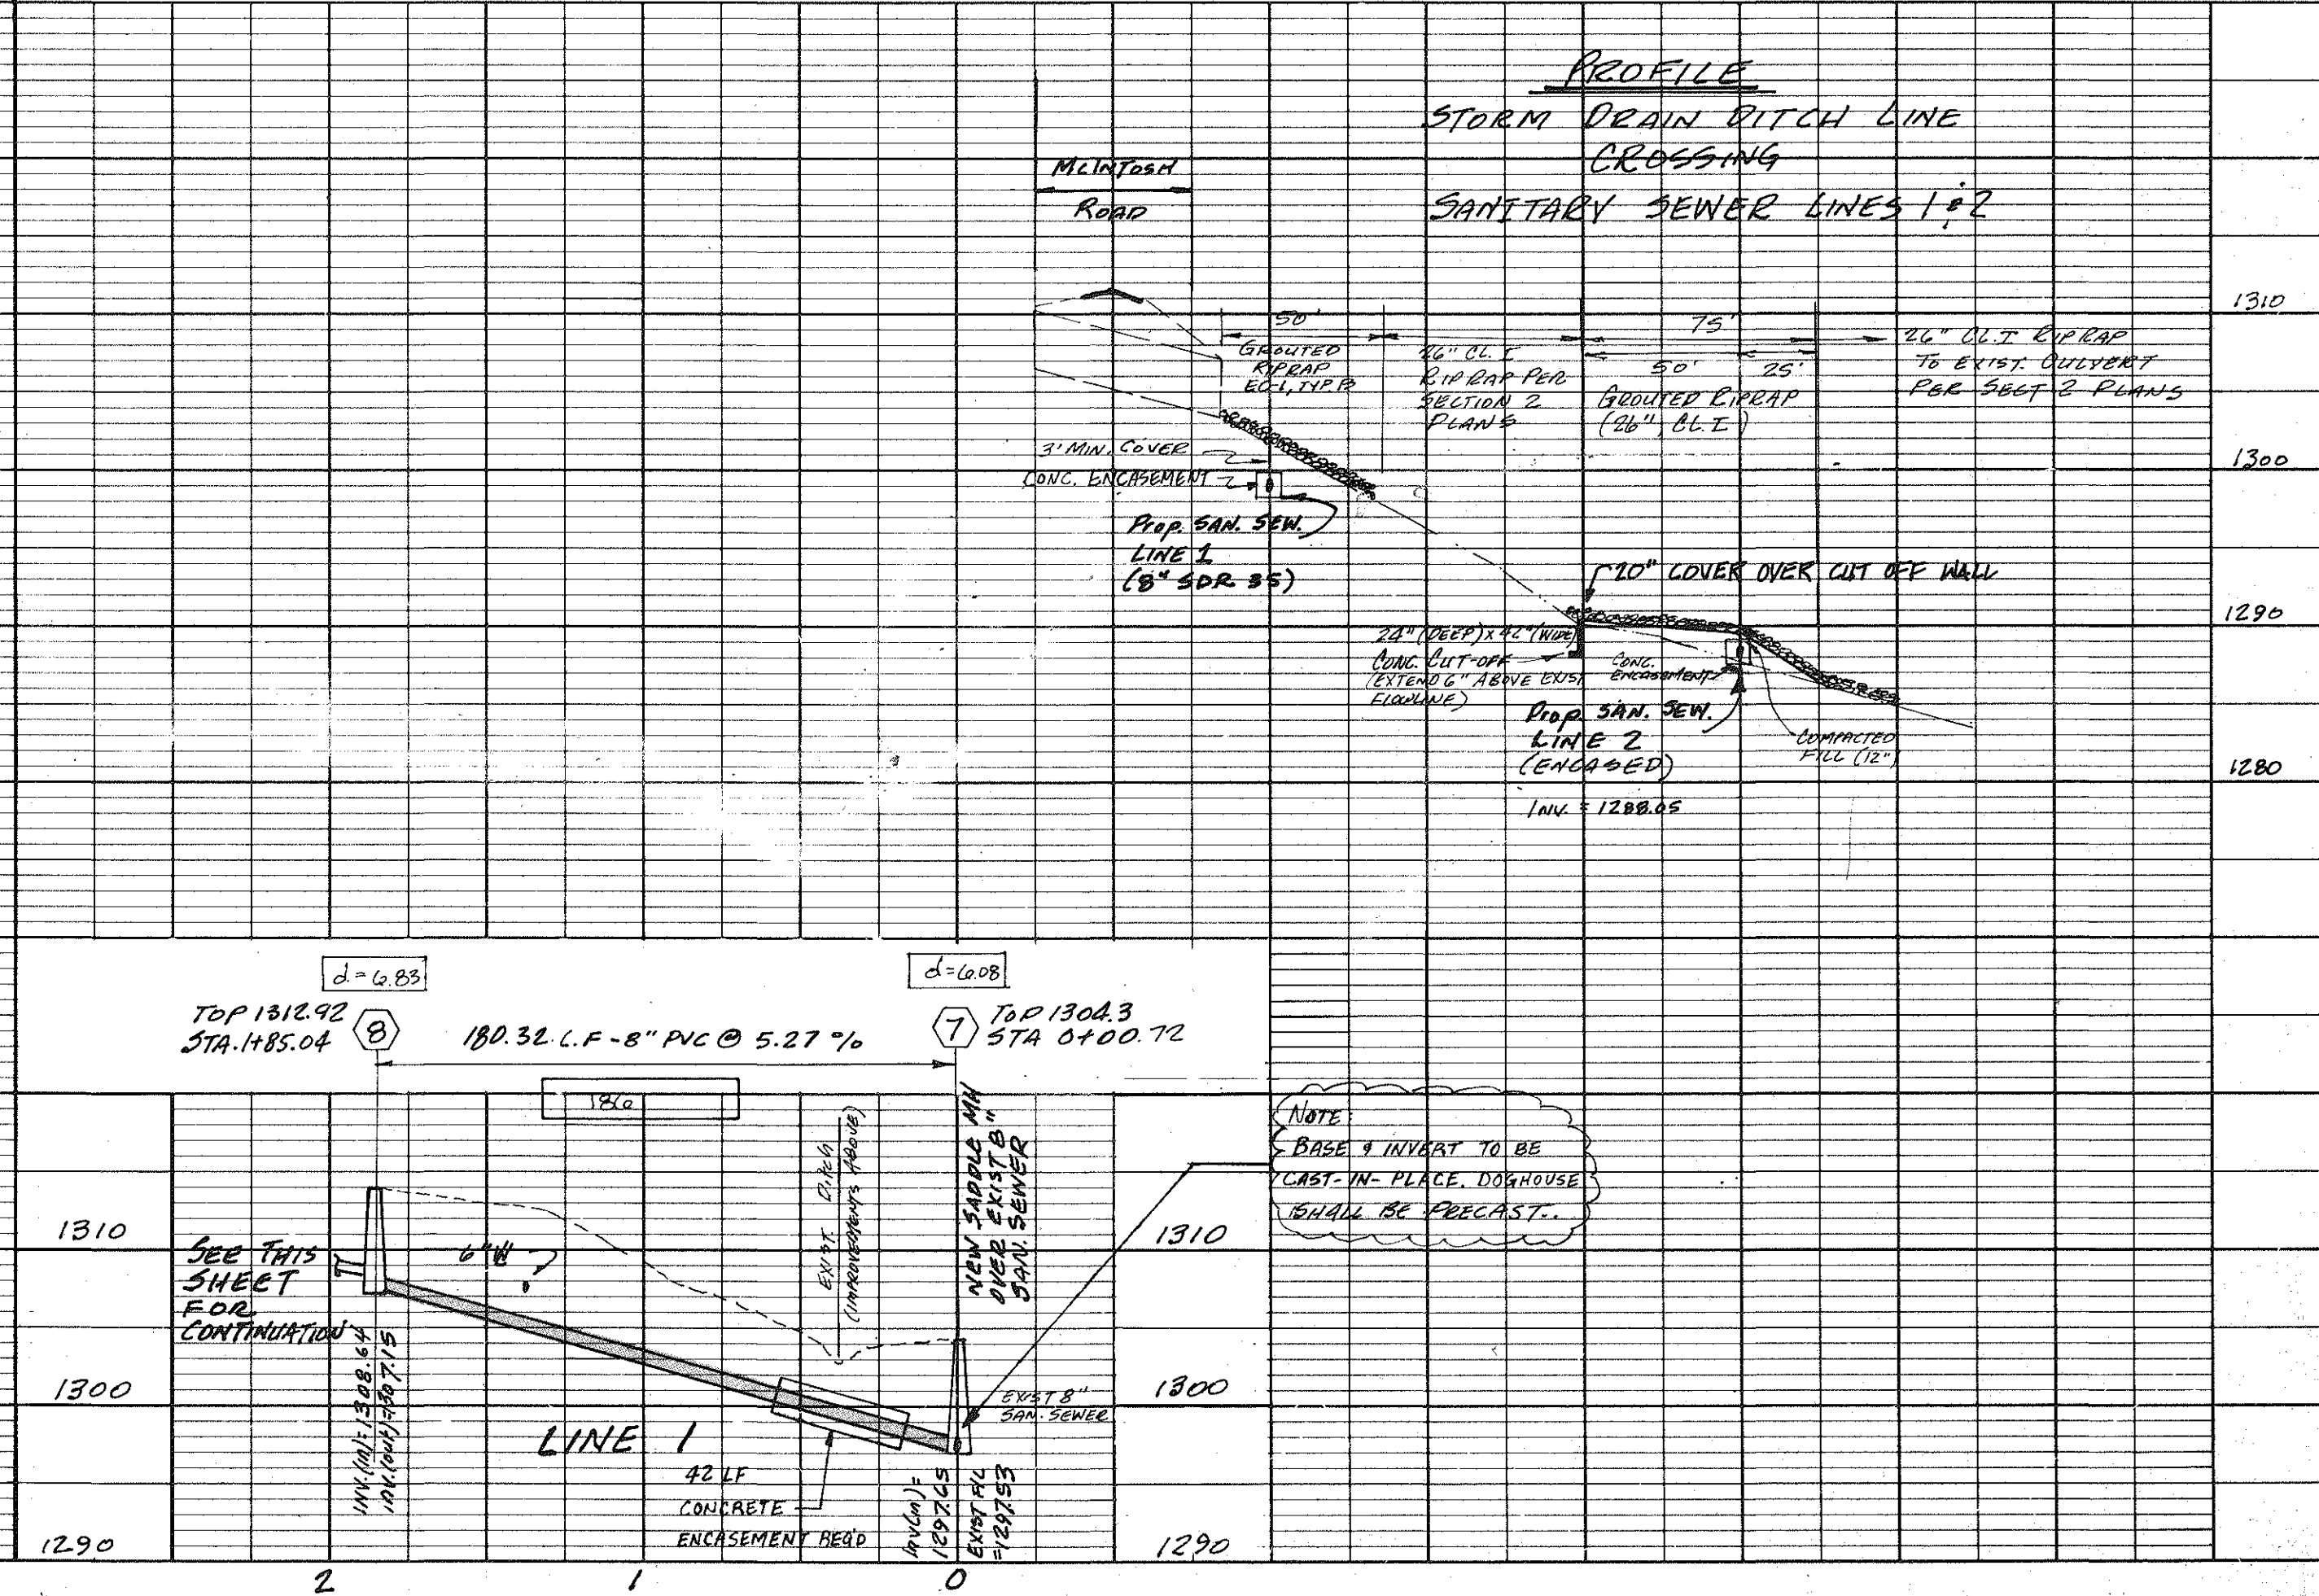

DATE	3/19/77
BY	SCM
SURVEYED	SCM
PLOTTED	SCM
NOTE BOOK	NO. 877
ALIGNMENT CHECKED	
BY	

DATE	3/19/77
BY	SCM
SURVEYED	SCM
PLOTTED	SCM
NOTE BOOK	NO. 877
GRADES CHECKED	
BY	
STRUCTURE NOTATIONS CHECKED	
BY	

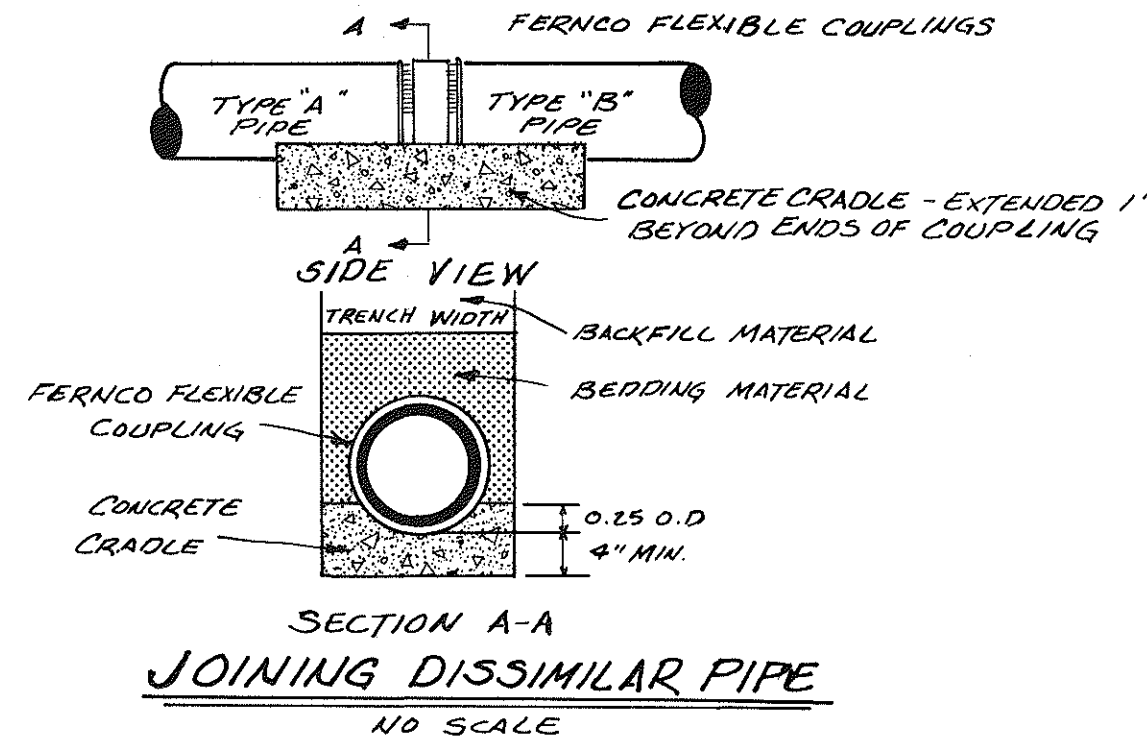

AS-BUILT
SEWER PLAN

PLAN & PROFILE
SteepleChase
Section 3
Sanitary Sewer

SHANKS ASSOCIATES, P.C.
ENGINEERS-SURVEYORS-PLANNERS
313 LUCK AVENUE
ROANOKE, VIRGINIA 24011
(703) 343-6685
Job Number 291003

DATE: REVISED:

